


GENERAL SHEET NOTES


1. REFER TO DRAWING FA0.01 FOR SYMBOLS, ABBREVIATIONS, AND NOTES.
2. FIRE ALARM SYSTEM SHALL REMAIN OPERATIONAL THROUGHOUT CONSTRUCTION. ONLY AFFECTED CIRCUITS AND ZONES SHALL BE TEMPORARILY DISABLED DURING SYSTEM MODIFICATION WORK. ALL CIRCUITS AND ZONES SHALL BE RE-ENABLED AT THE END OF EACH WORK SHIFT TO MINIMIZE SYSTEM DOWN-TIME. ALL SYSTEM OUTAGES SHALL BE COORDINATED WITH FACILITY MANAGEMENT.
3. DEVICES AND EQUIPMENT LOCATION INDICATED ARE GENERAL ONLY. CONTRACTOR SHALL VERIFY ACTUAL DEVICE AND EQUIPMENT LOCATION PRIOR TO COMMENCEMENT OF DEMOLITION.
4. DEMOLISH ALL ASSOCIATED WIRING, RACEWAY AND ELECTRICAL BOXES BACK TO PREVIOUS DEVICE ON CIRCUIT OR SOURCE FOR ALL DEVICES OR EQUIPMENT SCHEDULED FOR DEMOLITION.
5. CONTRACTOR SHALL CIRCUIT TRACE EXISTING FIRE ALARM CIRCUITS FOR CIRCUITS SERVING AREA OF WORK. PORTIONS OF CIRCUITS SERVING EXISTING TO REMAIN DEVICES IN ADJACENT AREAS SHALL BE MAINTAINED.

DEMOLITION KEYNOTES

- ① EXISTING FIRE ALARM PULL STATION TO REMAIN.
- ② EXISTING FIRE ALARM NOTIFICATION APPLIANCE TO REMAIN.
- ③ DEMOLISH FIRE ALARM NOTIFICATION APPLIANCE.
- ④ DEMOLISH FIRE ALARM PULL STATION DEVICE.
- ⑤ DEMOLISH FIRE ALARM SMOKE DETECTOR DEVICE.
- ⑥ DEMOLISH FIRE ALARM ANNUNCIATOR PANEL.

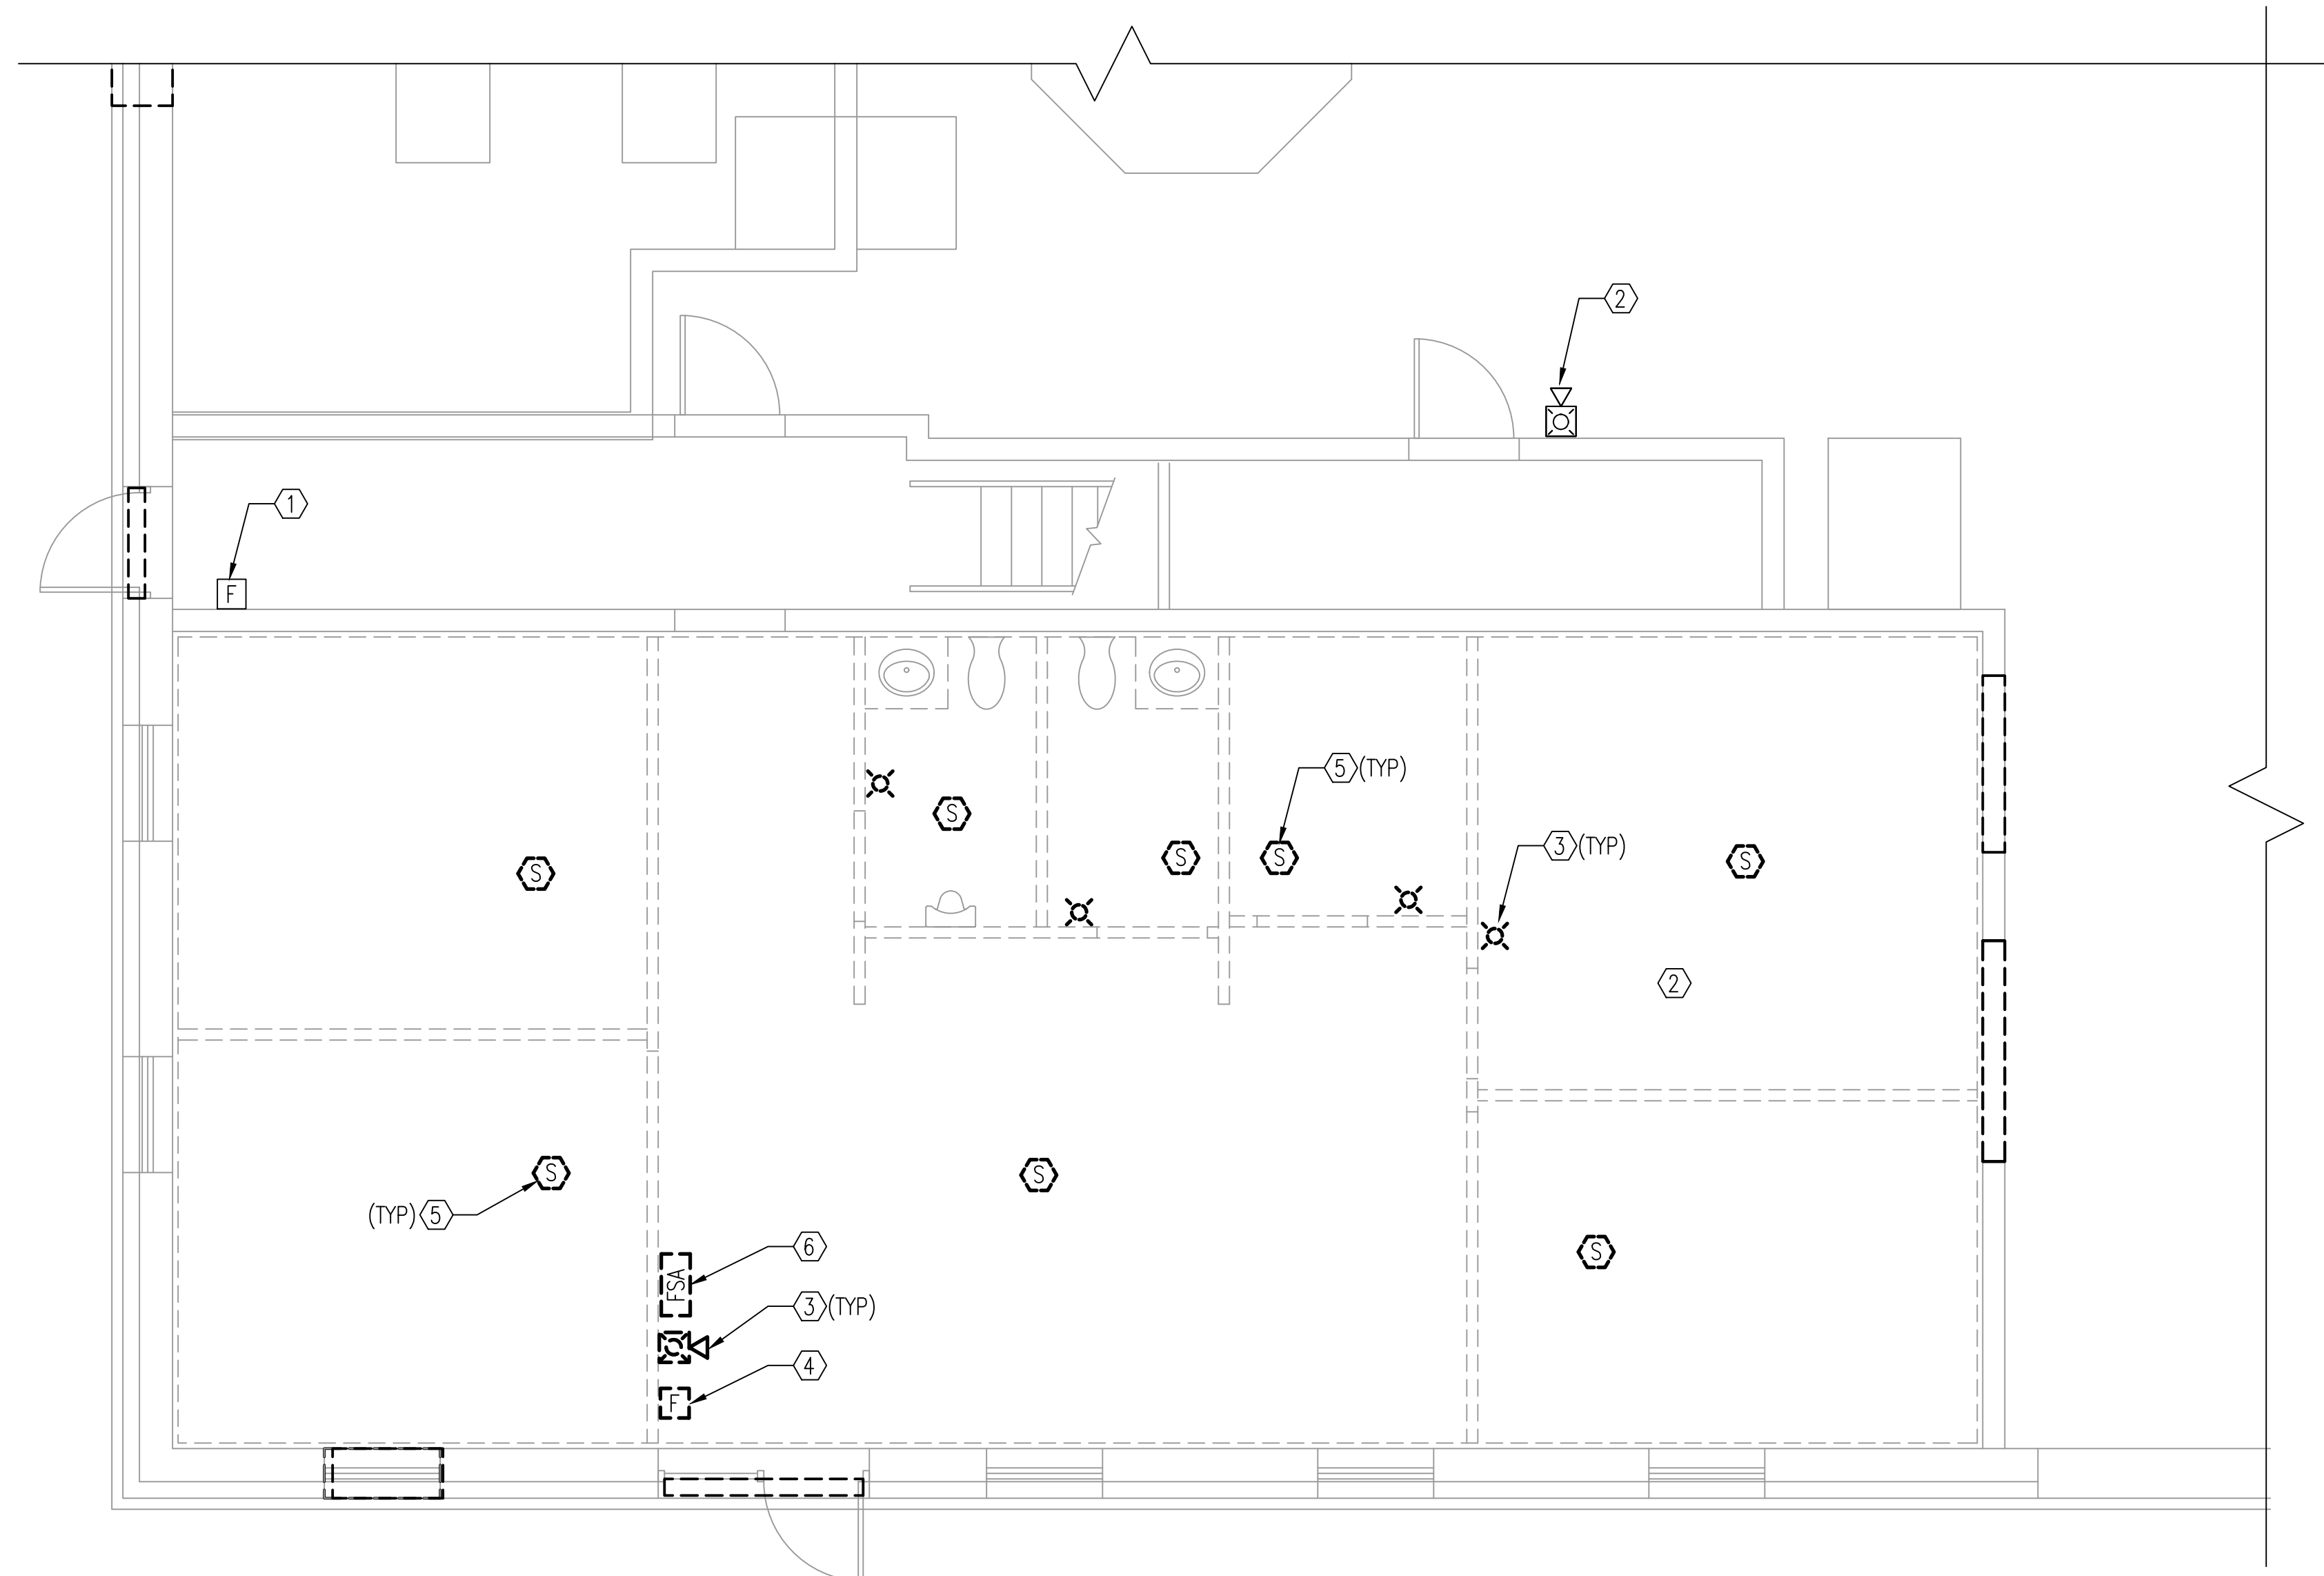

FIRE ALARM FLOOR PLAN - DEMOLITION
 SCALE: 1/4" = 1'-0"

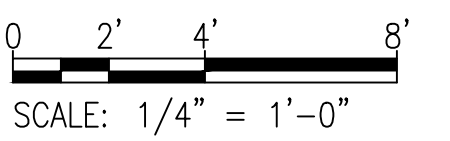

REV	DATE	DESCRIPTION



WESTERN VIRGINIA WATER AUTHORITY
 601 South Jefferson Street, Suite 300
 Roanoke, Virginia 24011

DES: EPH	SCALE: 1/4"=1'-0"
DRAWN: PBF	HORIZ: N/A
CHECK: EPH	VERT: N/A
DATE: 1/24/20	

**CRYSTAL SPRING
 PUMP STATION RELOCATION**

**FIRE ALARM FLOOR PLAN
 - DEMOLITION**

DRAWING	SHEET
FAD1.01	36

PLOT STYLE: WPL_PLOTCTB.PAPER SIZE: ARCH FULL BLEED D: 36.00 X 24.00 INCHES