


PLOT STYLE: VPA\_2006.CTB PAPER SIZE: ARCH FULL BLEED D: 36.00 X 54.00 INCHES

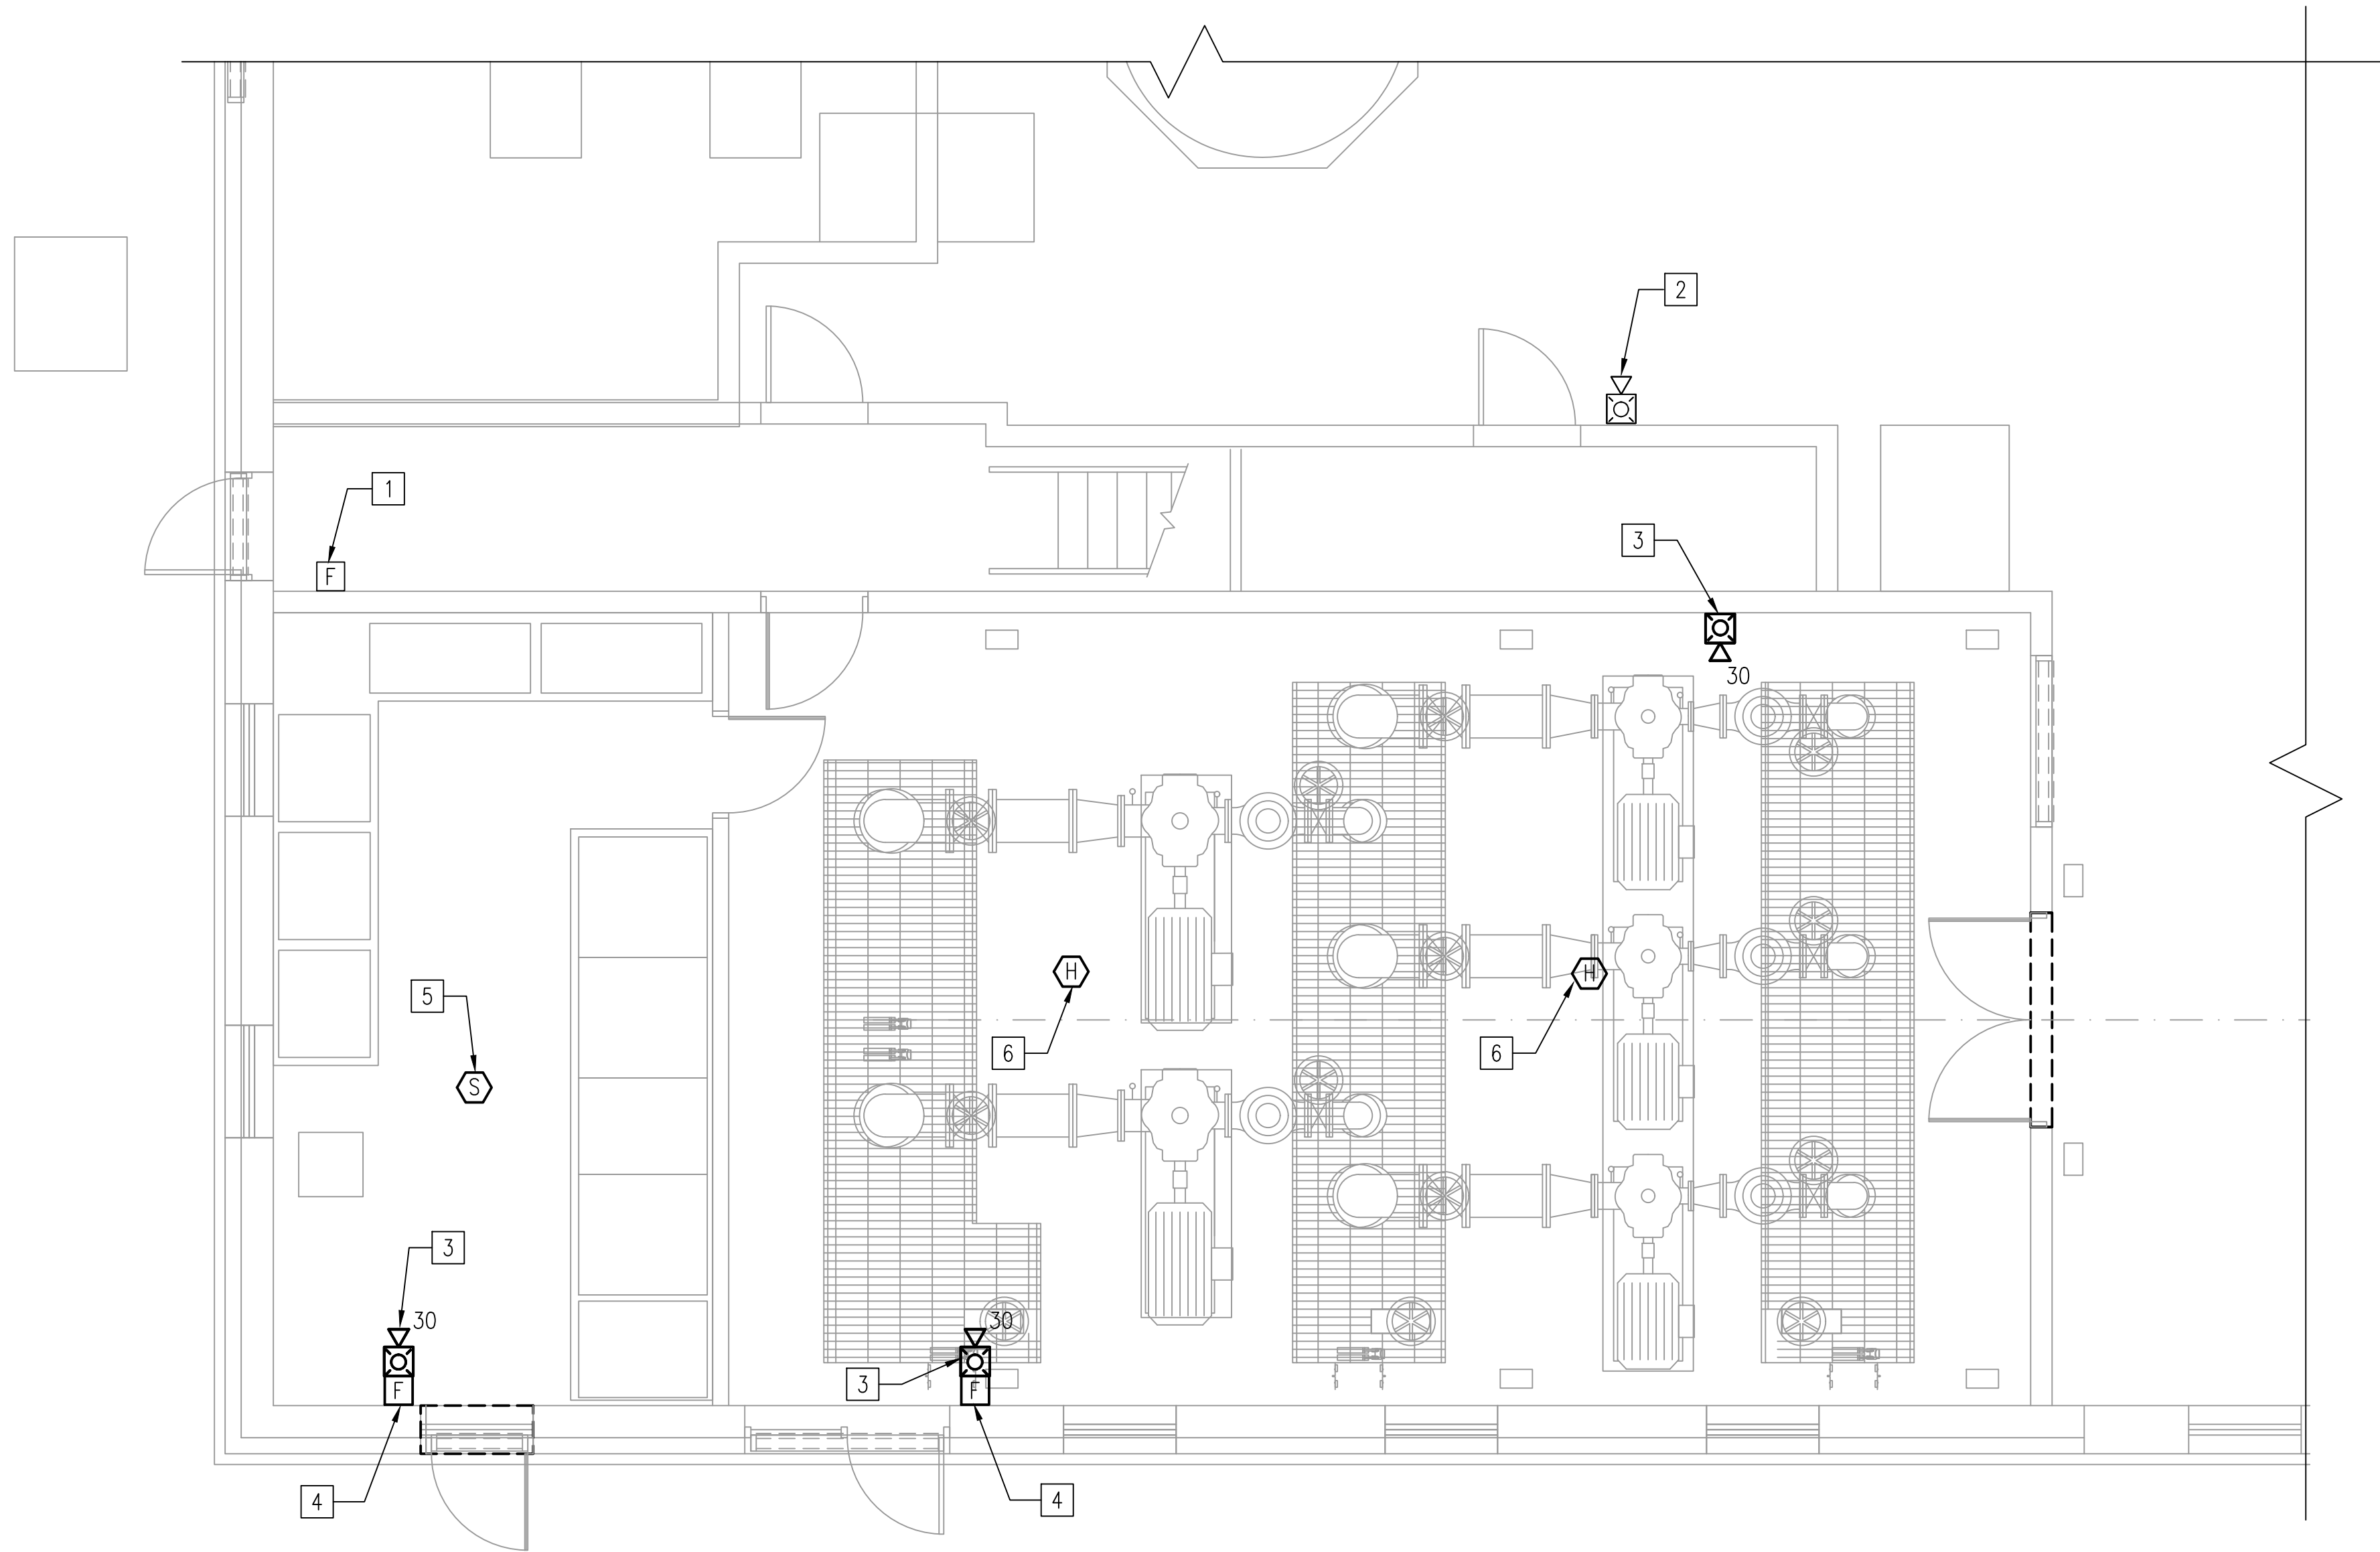

FIRE ALARM FLOOR PLAN - NEW WORK  
SCALE: 1/4" = 1'-0"

GENERAL SHEET NOTES

1. REFER TO DRAWING FA0.01 FOR SYMBOLS, ABBREVIATIONS, AND NOTES.
2. FIRE ALARM SYSTEM SHALL REMAIN OPERATIONAL THROUGHOUT CONSTRUCTION. ONLY AFFECTED CIRCUITS AND ZONES SHALL BE TEMPORARILY DISABLED DURING SYSTEM MODIFICATION WORK. ALL CIRCUITS AND ZONES SHALL BE RE-ENABLED AT THE END OF EACH WORK SHIFT TO MINIMIZE SYSTEM DOWN-TIME. ALL SYSTEM OUTAGES SHALL BE COORDINATED WITH FACILITY MANAGEMENT.
3. DEVICES AND EQUIPMENT LOCATION INDICATED ARE GENERAL ONLY. CONTRACTOR SHALL VERIFY ACTUAL DEVICE AND EQUIPMENT LOCATION AND DETERMINE FINAL CIRCUITING.

SHEET KEYNOTES

- 1 EXISTING FIRE ALARM PULL STATION TO REMAIN.
- 2 EXISTING FIRE ALARM NOTIFICATION APPLIANCE TO REMAIN.
- 3 PROVIDE FIRE ALARM NOTIFICATION APPLIANCE.
- 4 PROVIDE FIRE ALARM PULL STATION DEVICE.
- 5 PROVIDE CEILING SMOKE DETECTOR DEVICE.
- 6 PROVIDE CEILING HEAT DETECTOR DEVICE.

0 2' 4' 8'  
SCALE: 1/4" = 1'-0"



WESTERN VIRGINIA WATER AUTHORITY  
601 South Jefferson Street, Suite 300  
Roanoke, Virginia 24011

DES:	EPH	SCALE:	1/4"=1'-0"
DRAWN:	PBF	HORIZ:	N/A
CHECK:	EPH	VERT:	N/A
DATE:	1/24/20		

CRYSTAL SPRING  
PUMP STATION RELOCATION

FIRE ALARM FLOOR PLAN  
- NEW WORK

DRAWING  
FA1.01

SHEET  
37