


PROVIDE ONE HOUR RATED GYPSUM BOARD CEILING ABOVE ACOUSTICAL TILE CEILING. SEE STAIR SECTION 3 ON A-8 FOR TYPICAL DETAILS.

PROVIDE 6 1/4" R-19 BATT INSULATION ABOVE ACOUSTICAL PANEL CEILING THROUGHOUT ENTIRE 2ND FLOOR

PROVIDE ONE HOUR RATED GYPSUM BOARD CEILING ABOVE ACOUSTICAL TILE CEILING. SEE STAIR SECTION 3 ON A-8 FOR TYPICAL DETAILS.

SECOND FLOOR REFLECTED CEILING PLAN

SCALE: 1/8" = 1'-0"

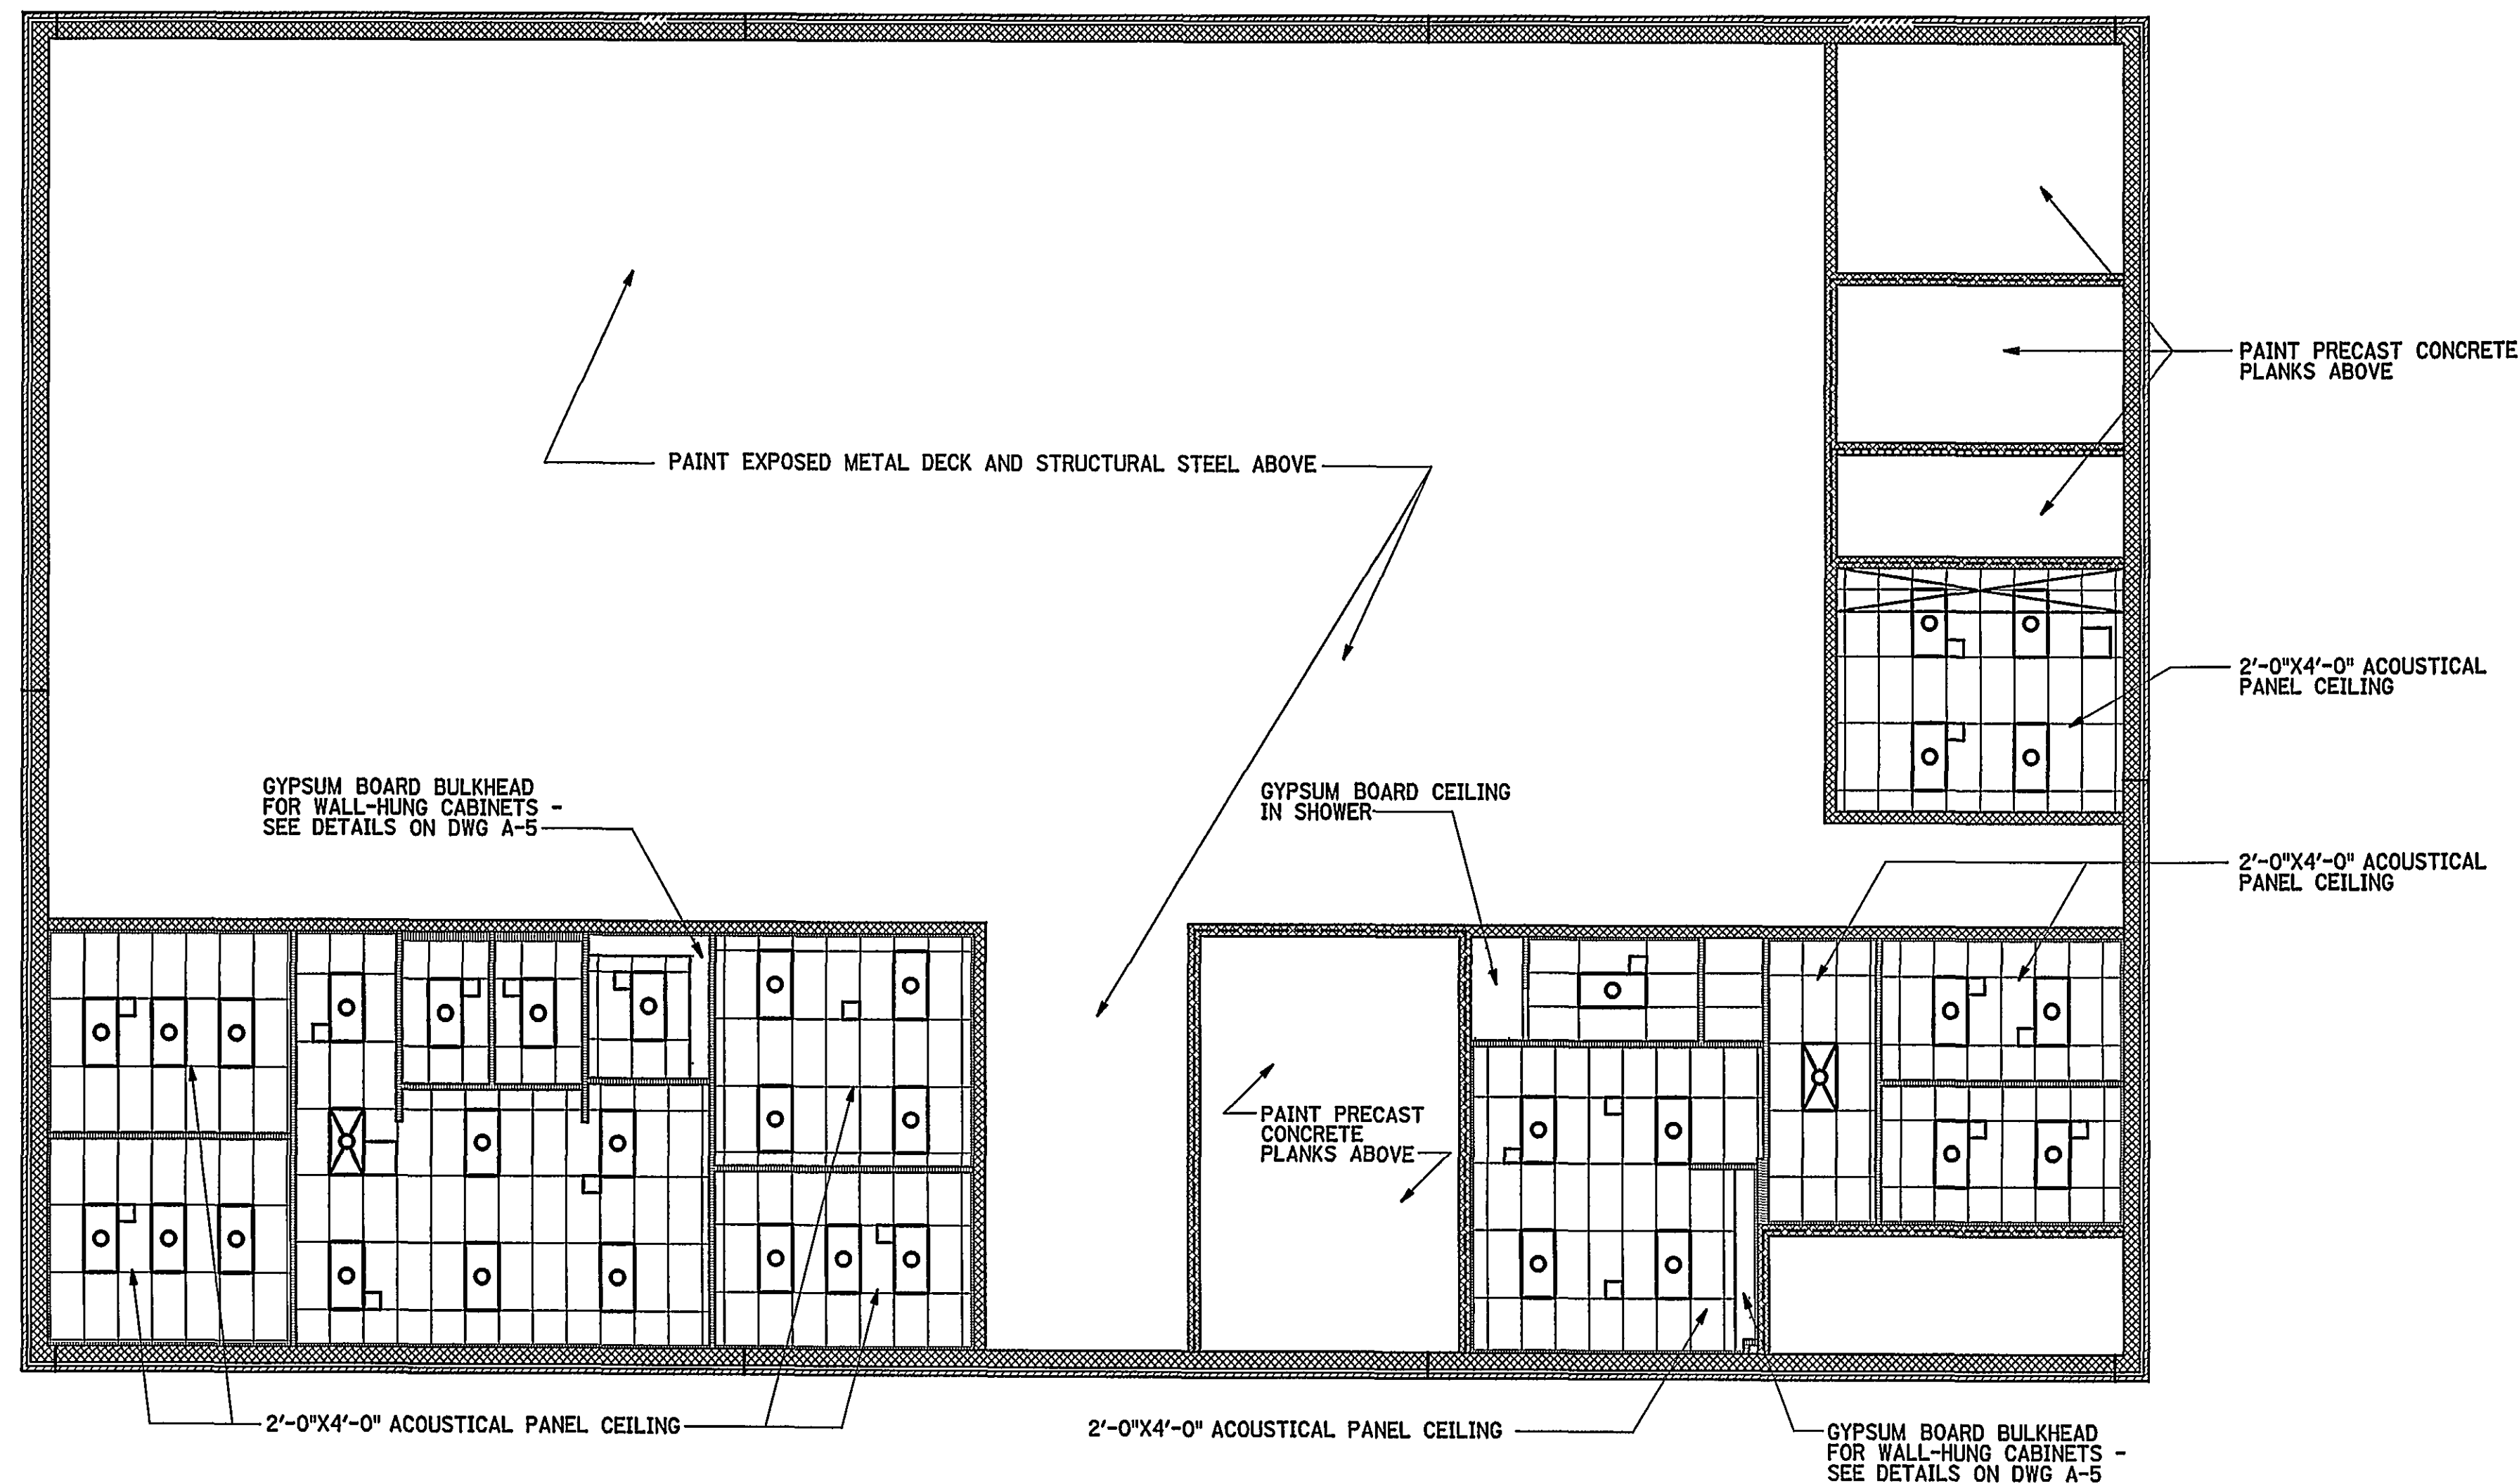


FIRST FLOOR REFLECTED CEILING PLAN

SCALE: 1/8" = 1'-0"



IF THIS DRAWING IS A REDUCTION, GRAPHIC SCALE MUST BE USED.

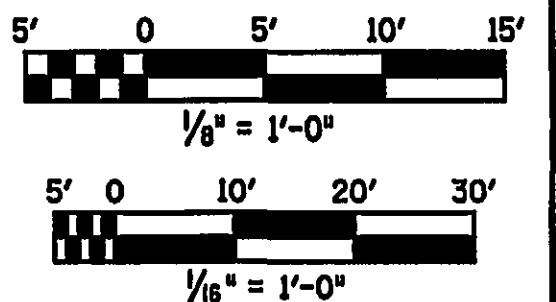

REV.	DATE	BY	APP.	DESCRIPTION
5-01-03	JLW	MKJ		RECORD DRAWING

RECORD DRAWING

DATE: MAY 1, 2003

Wiley & Wilson
ARCHITECTS ENGINEERS PLANNERS
An Employee-Owned Company

2310 LANGHORNE ROAD
LYNCHBURG, VIRGINIA 24501
(804) 947-1901

P.O. BOX 877
LYNCHBURG, VIRGINIA 24505-0877

IN ASSOCIATION WITH

HDR

HDR Engineering, Inc.
5700 LAKE WRIGHT DRIVE
NORFOLK, VIRGINIA 23502
757-222-1500

DESIGNED JRM	DRAWN EJLB	PROJECT CRYSTAL SPRING WATER TREATMENT PLANT FOR THE CITY OF ROANOKE, VIRGINIA
CHECKED MKJ	REVIEWED	REFERENCE ARCHITECTURAL
COMM. NO. 200171.01		TITLE REFLECTED CEILING PLANS
CADD NO. 200171A10.DGN		DWG. NO. A-10
DATE AUG 26, 2001		SHEET NO. 21 OF 72
		REV. 0