

WESTERN VIRGINIA WATER AUTHORITY
FALLING CREEK DAM REHABILITATION
BEDFORD COUNTY, VIRGINIA

COULTER BUILDING
601 SOUTH JEFFERSON STREET, SUITE 210
ROANOKE, VIRGINIA 24011

JANUARY 12, 2009
HSMM COMM NO. 61034

HSMM | AECOM

HAYES, SEAY, MATTERN & MATTERN, INC.
1315 FRANKLIN ROAD
ROANOKE, VA 24016
(540) 857-3100 www.hsmm.com

HSMM | AECOM

HAYES, SEAY, MATTERN & MATTERN, INC.
1315 FRANKLIN ROAD
ROANOKE, VA 24016
(540) 857-3100 www.hsmm.com

SEALS



CONSULTANT



WESTERN VIRGINIA
WATER AUTHORITY

FALLING CREEK
DAM RENOVATION

WESTERN VIRGINIA
WATER AUTHORITY

BEDFORD COUNTY, VIRGINIA


REV	DATE	DESCRIPTION	APP
PROJECT NO:	61034	PROJECT PH:	REGULATORY REVIEW
ISSUE DATE:	JANUARY 12, 2009		
DESIGNED BY:	DMH	DRAWN BY:	MEW
CHECKED BY:	CGH	SUBMITTED BY:	DMH

CIVIL


COVER SHEET

G001

LOCATION MAP

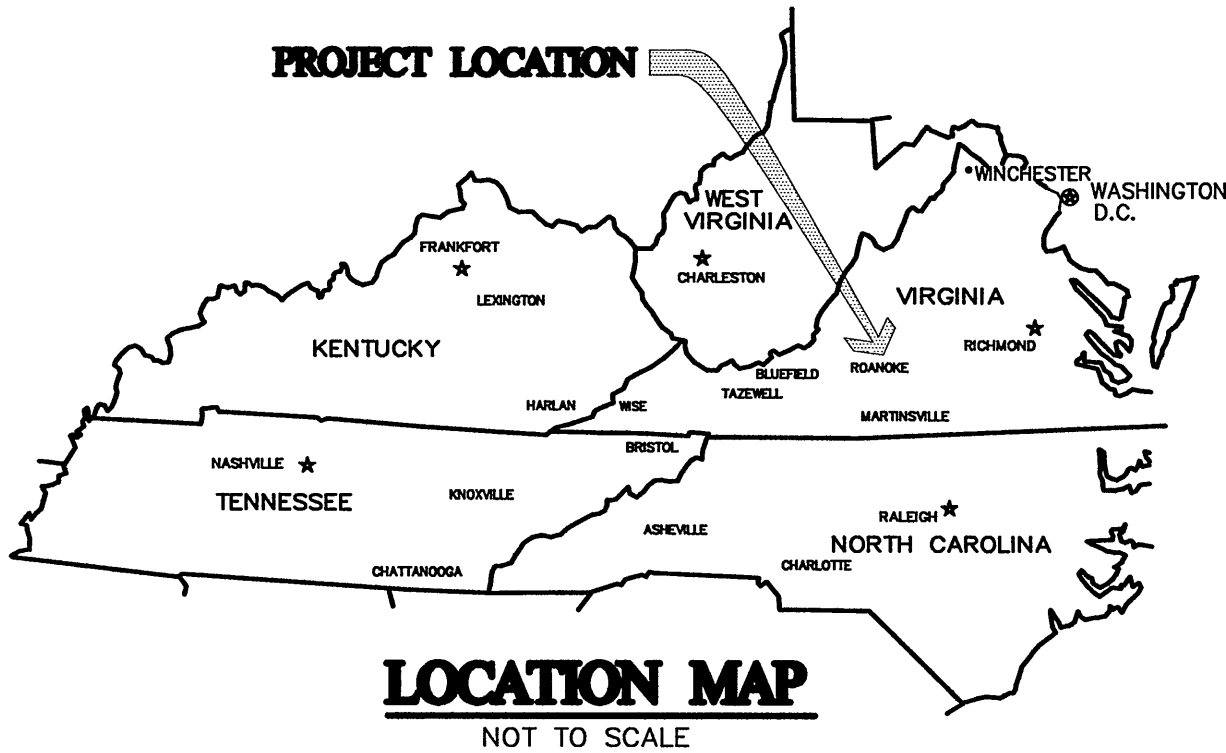

VICINITY MAP

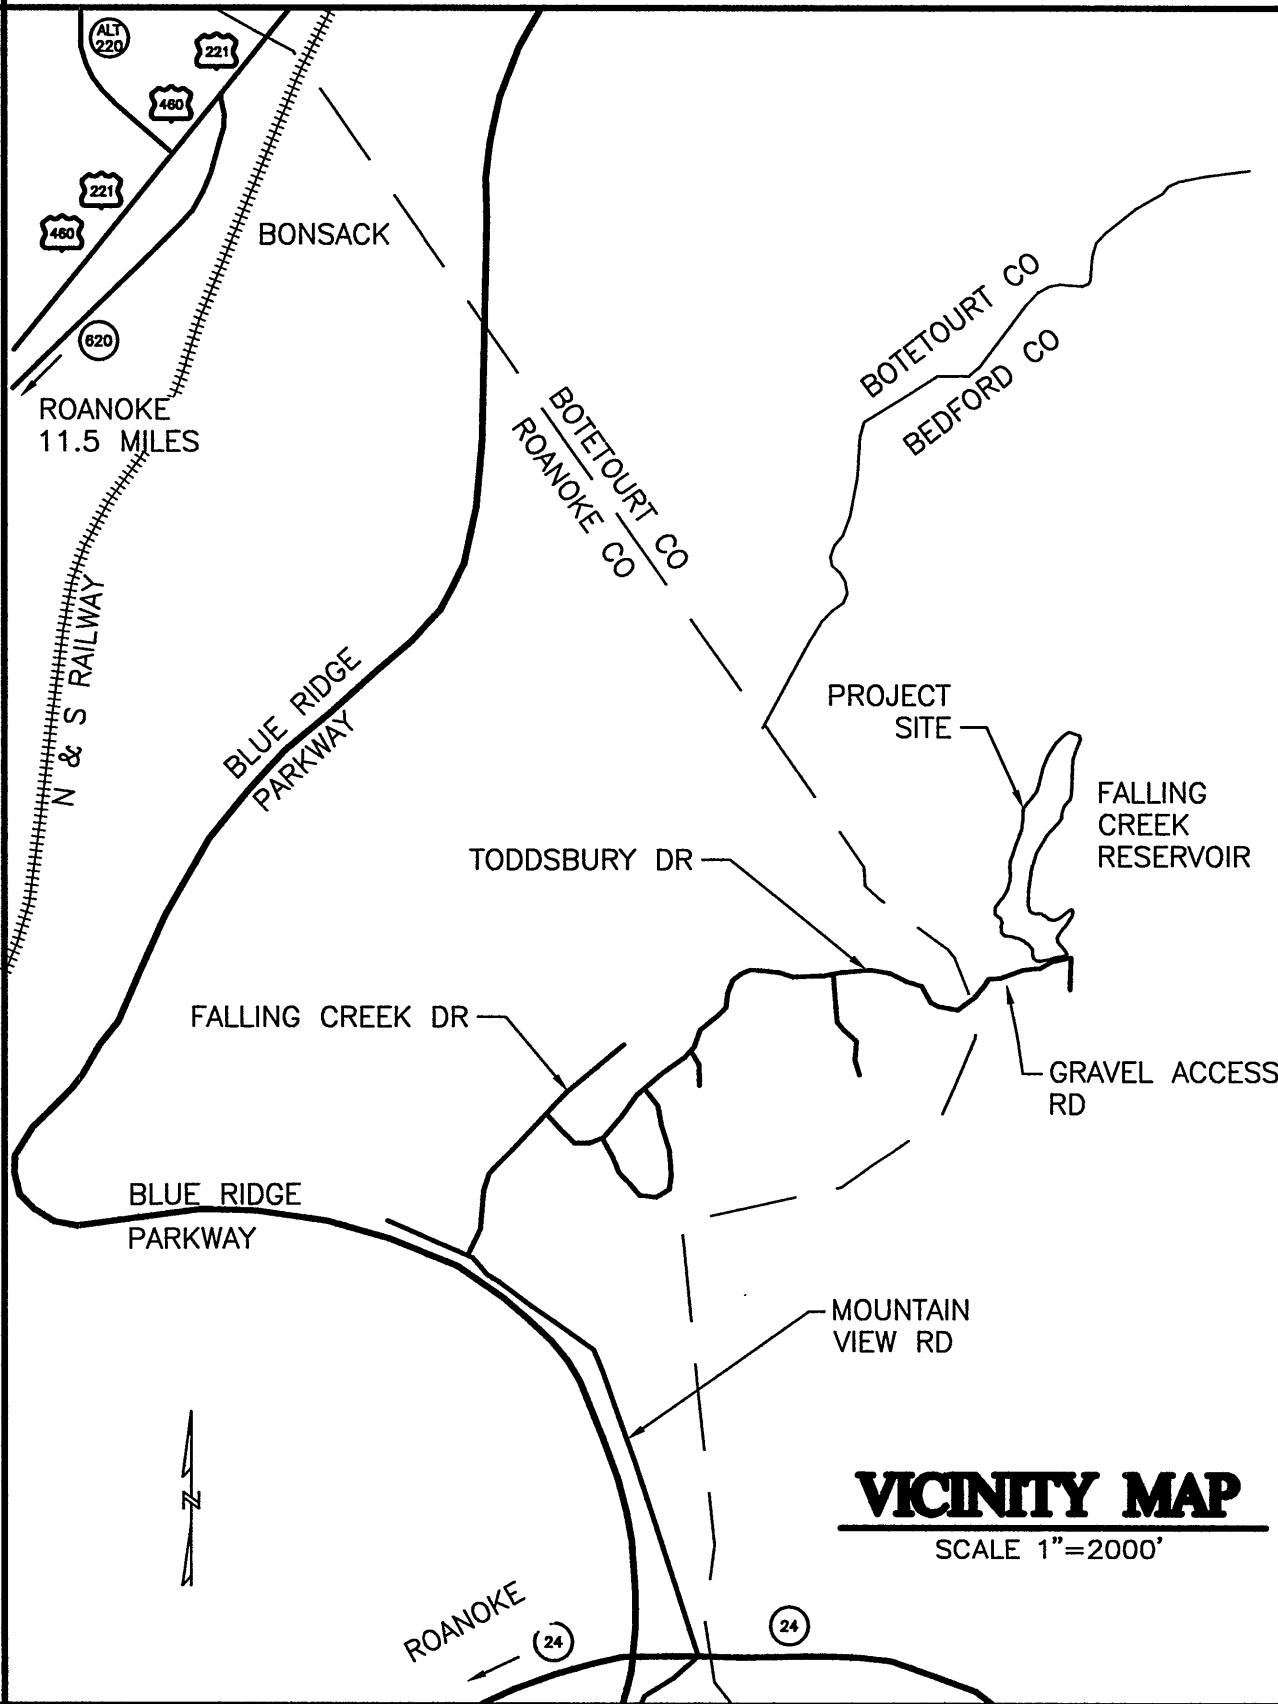

DRAWING INDEX

GENERAL

- G001 COVER SHEET
- G002 GENERAL NOTES AND LEGENDS
- G003 ABBREVIATIONS

CIVIL

- CS101 EXISTING CONDITIONS AND DEMOLITION PLAN
- CS102 SITE PLAN AND DIMENSIONAL LAYOUT
- CS103 UTILITY PLAN
- CS104 GRADING PLAN
- CS105 EROSION CONTROL PLAN
- CS106 DRAINAGE AREA MAP
- CS201 PROFILE RAW WATERLINE 100 RW
- CS202 PROFILE RAW WATERLINE 200 RW
- CS203 PROFILES
- CS204 STORM PIPING AND DRAINAGE PROFILES
- CS301 TYPICAL SECTIONS
- CS302 GABION DROP STRUCTURE SECTIONS
- CS501 DAM DETAILS
- CS502 EROSION AND SEDIMENT CONTROL DETAILS
- CS503 DETAILS
- CS504 VVWA STANDARD DETAILS
- CS601 E&S CONTROL NARRATIVE AND DRAINAGE SUMMARY TABLES

ELECTRICAL

- E001 LEGEND, LIGHTING FIXTURE SCHEDULE, PANELBOARD SCHEDULE, AND DETAILS
- ESD101 ELECTRICAL SITE DEMOLITION PLAN
- ES101 ELECTRICAL SITE PLAN

OWNER:

WESTERN VIRGINIA WATER AUTHORITY
601 SOUTH JEFFERSON STREET
ROANOKE, VIRGINIA 24011
ATTN: MR. BOB BENNINGER, DIRECTOR WATER OPERATIONS
(540) 853-5750
BOB.BENNINGER@WESTERNVAVATER.ORG