


# PROJECT LOCATION MAP

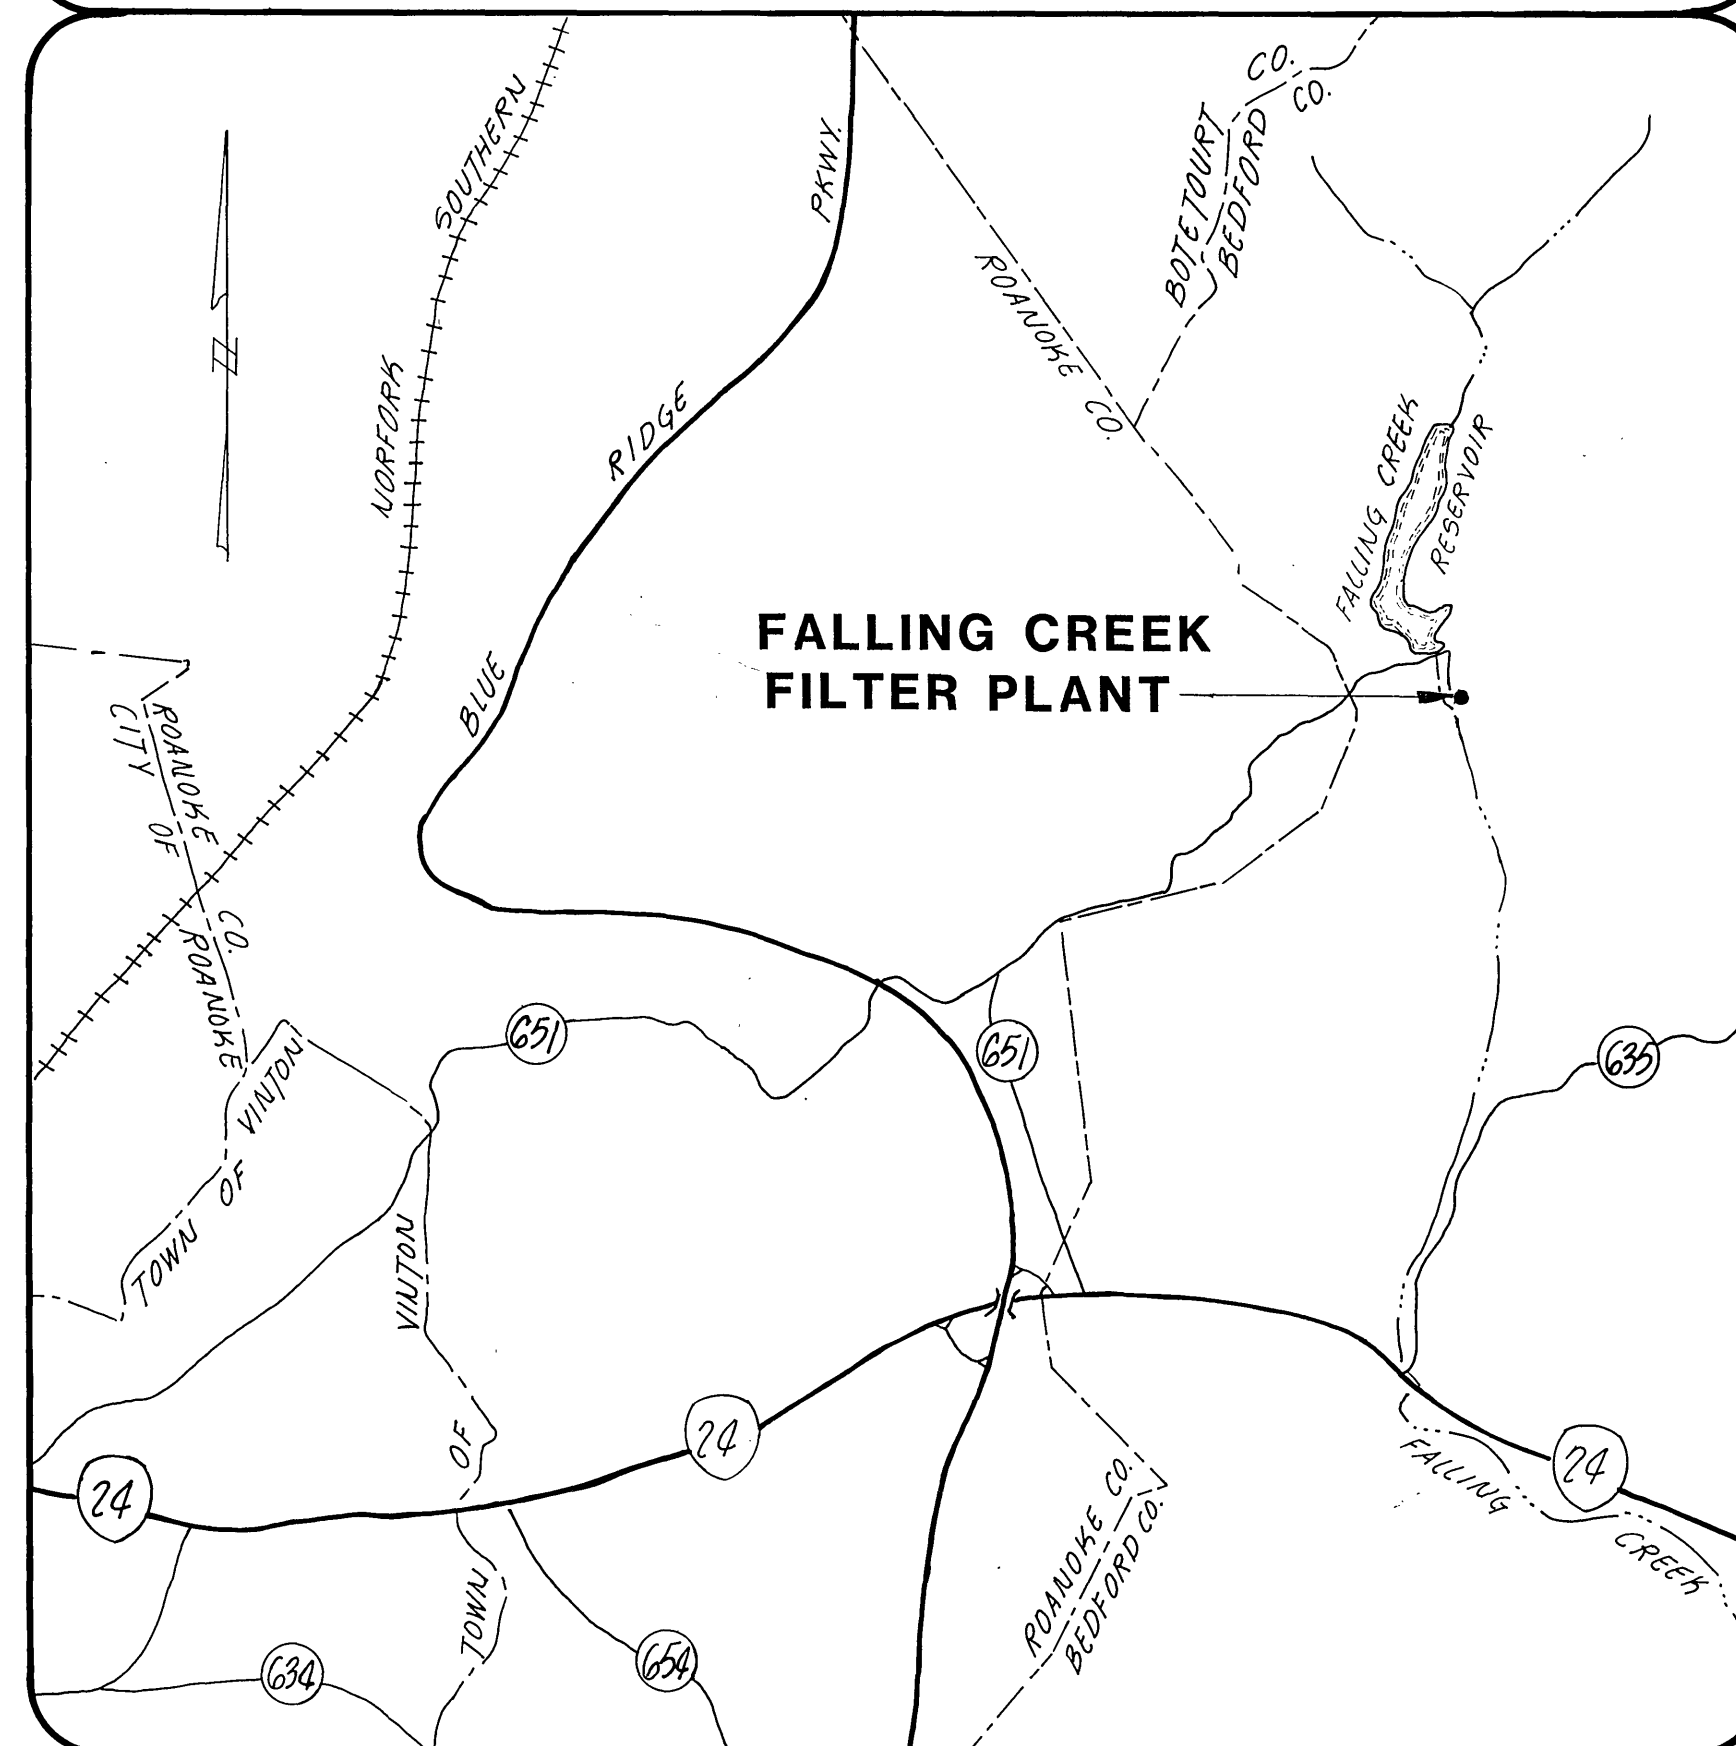

OFFICE OF CITY ENGINEER  
ROOM 350  
MUNICIPAL BUILDING  
215 CHURCH AVENUE, S.W.  
ROANOKE, VIRGINIA 24011



# INDEX OF SHEETS

- 1 TITLE SHEET
- 2 ABBREVIATIONS, LEGEND, GENERAL NOTES, AND VICINITY MAP
- 3 PLAN AND ELECTRICAL DETAILS

# CONSULTING ENGINEERS

**MATTERN AND CRAIG**  
**CONSULTING ENGINEERS**  
**ROANOKE , VIRGINIA**

COMMISSION NUMBER: **570**

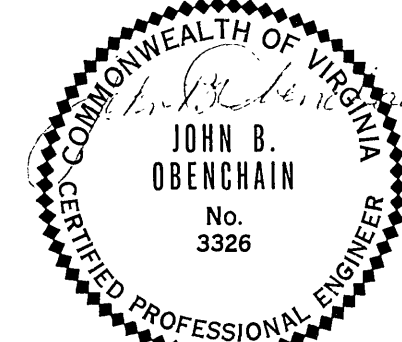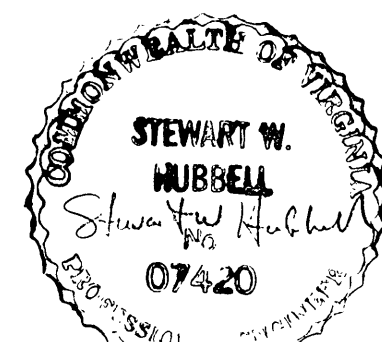

# PROJECT NAME

**FALLING CREEK GENERATOR**  
**REPLACEMENT**

**PROJECT NO. 85-17**

**COMM. NO. 570**

PROJECT NUMBER: **85-17**

REVISION	BY	DESCRIPTION:	DATE
REVISION	BY	DESCRIPTION:	DATE
REVISION	BY	DESCRIPTION:	DATE
REVISION	BY	DESCRIPTION:	DATE

# APPROVED FOR CONSTRUCTION

ROANOKE CITY ENGINEER

DATE

DIRECTOR OF PUBLIC WORKS

DATE

DIRECTOR OF UTILITIES AND OPERATIONS

DATE

DATE

DATE

ADVERTISED DATE: **MAR 16 1986**

SET NUMBER: **FIVE**

SHEET NUMBER: **1** OF **3**