

EXISTING METAL FUEL TANK TO BE REMOVED

EXIST. CONC. SLAB

3' MIN.

48" DIA.







6" MIN.

SEE SECTION TH. SH. FOR BELOW GRADE PORTION OF CRADLE

CONC. CRADLE
2 REQ'D. @ 1/4 POINT
& 3/4 POINT

FUEL TANKS

SCALE 1" = 20'

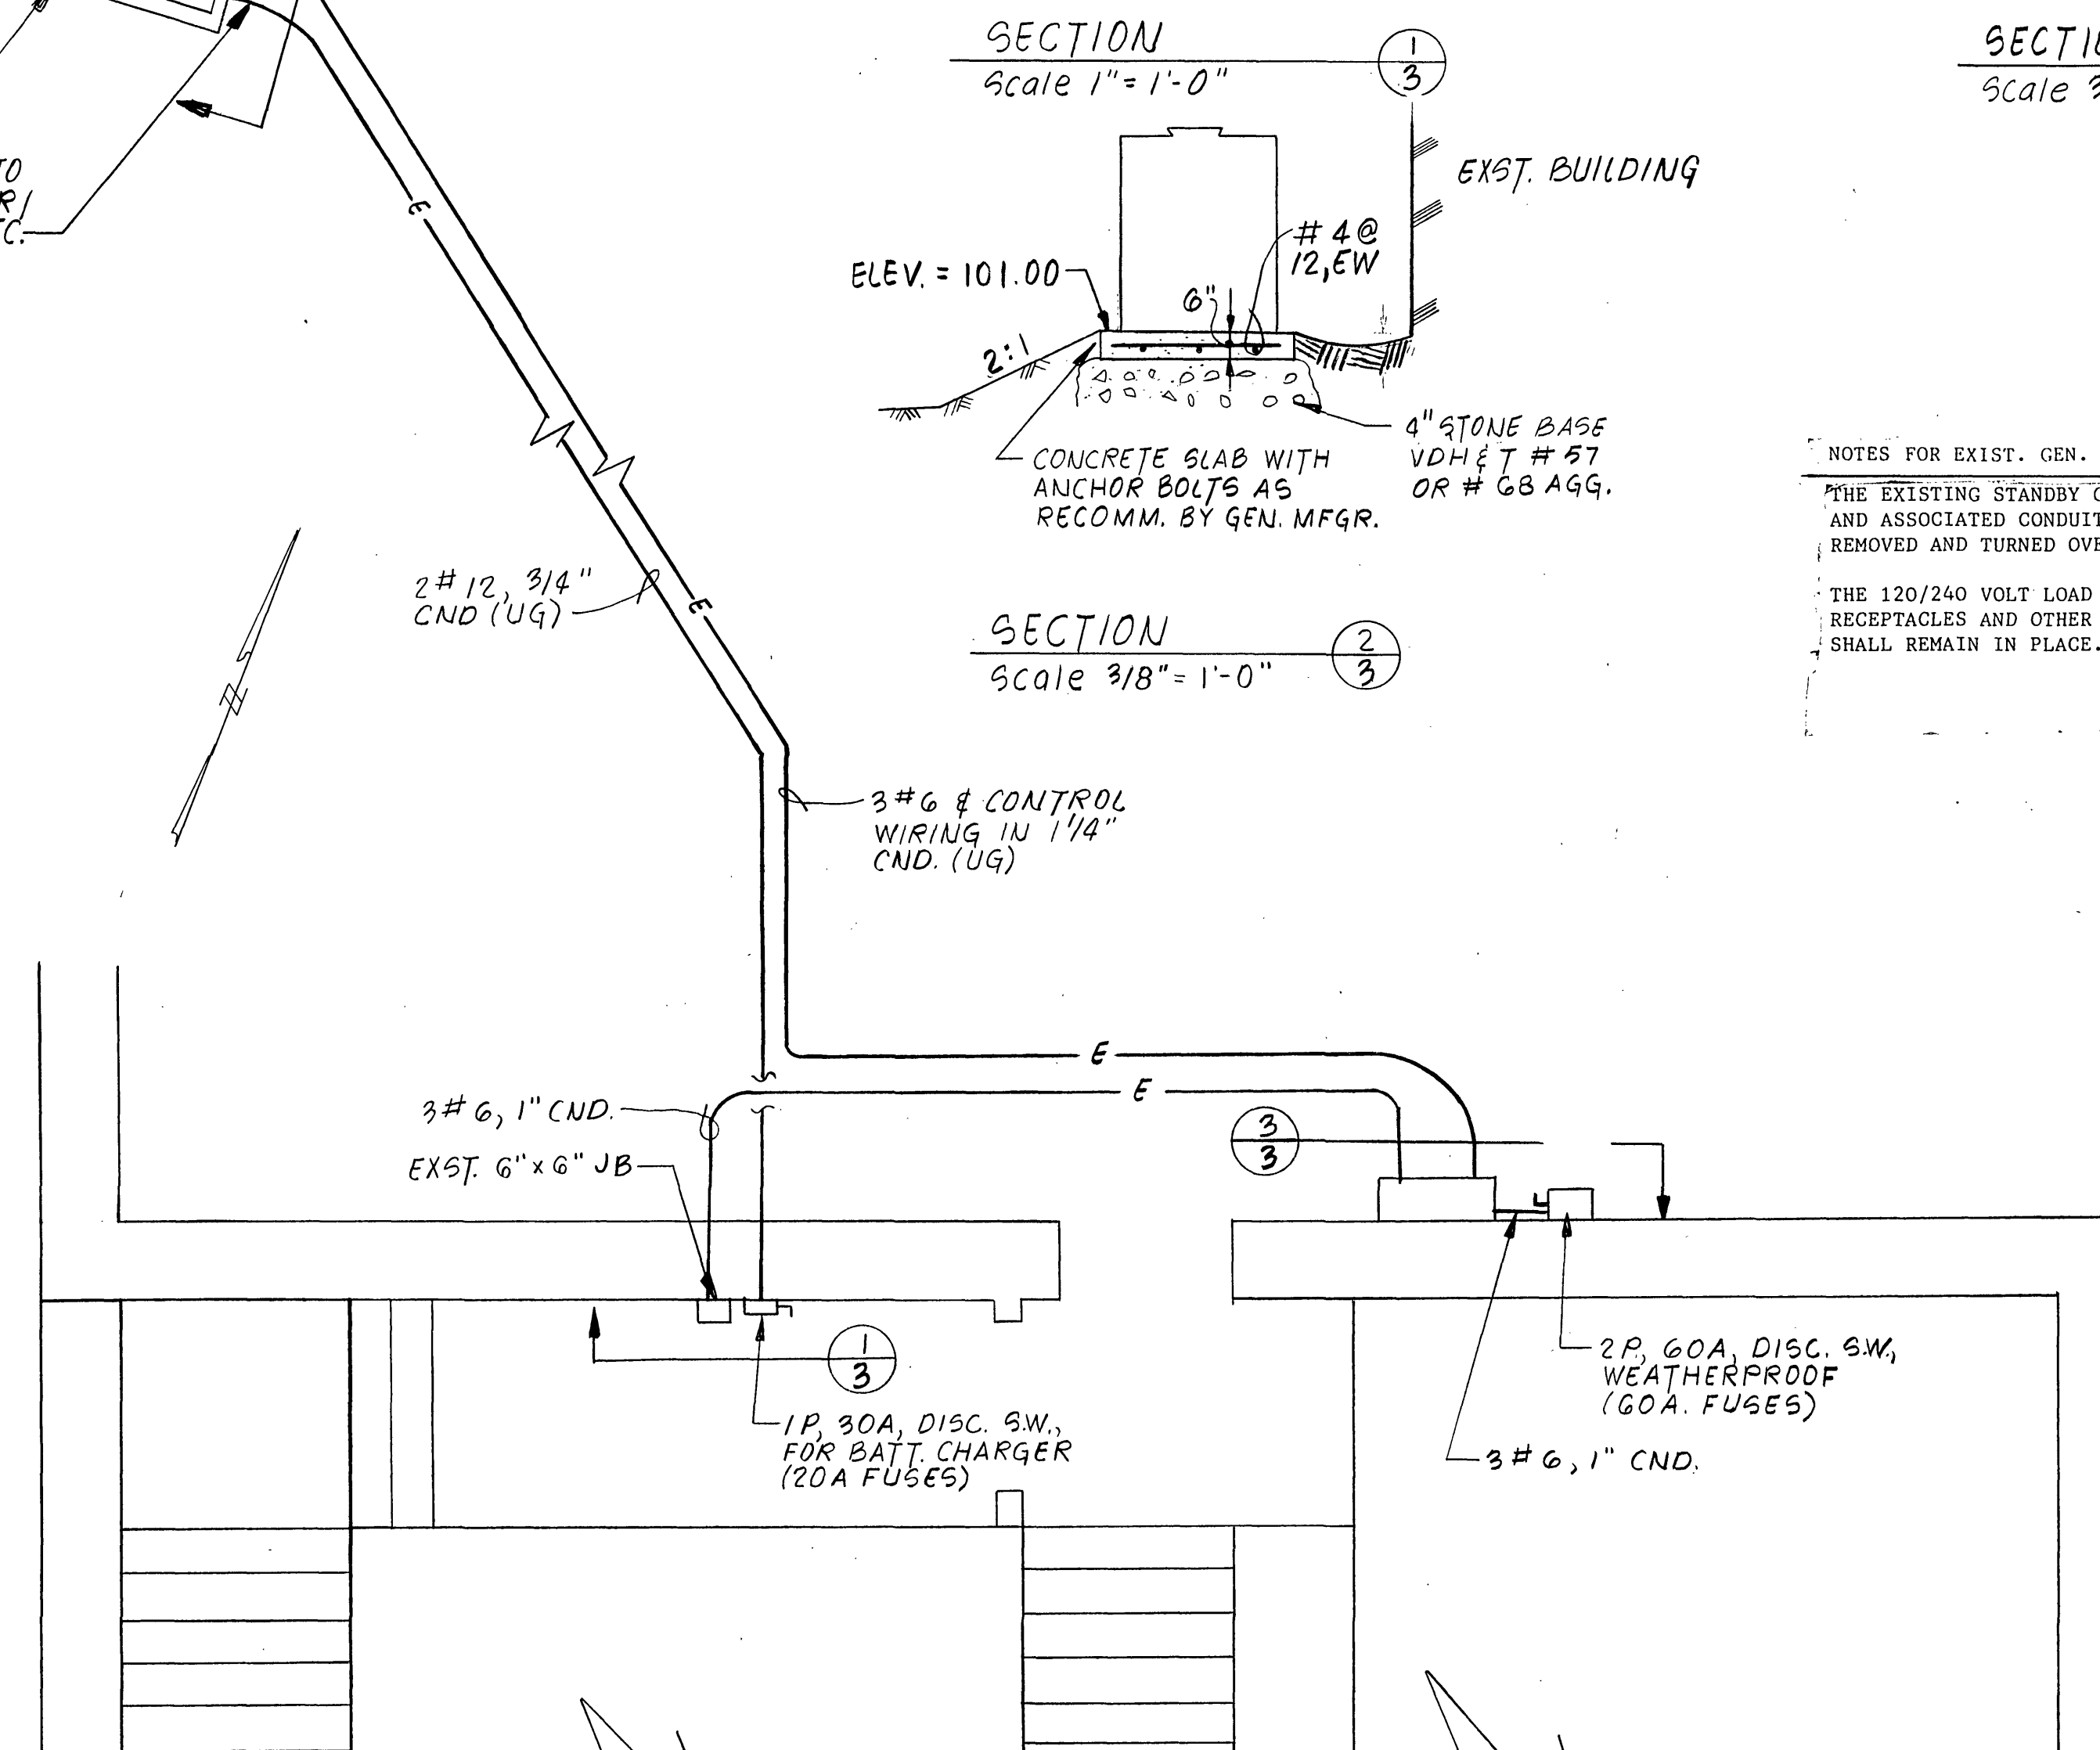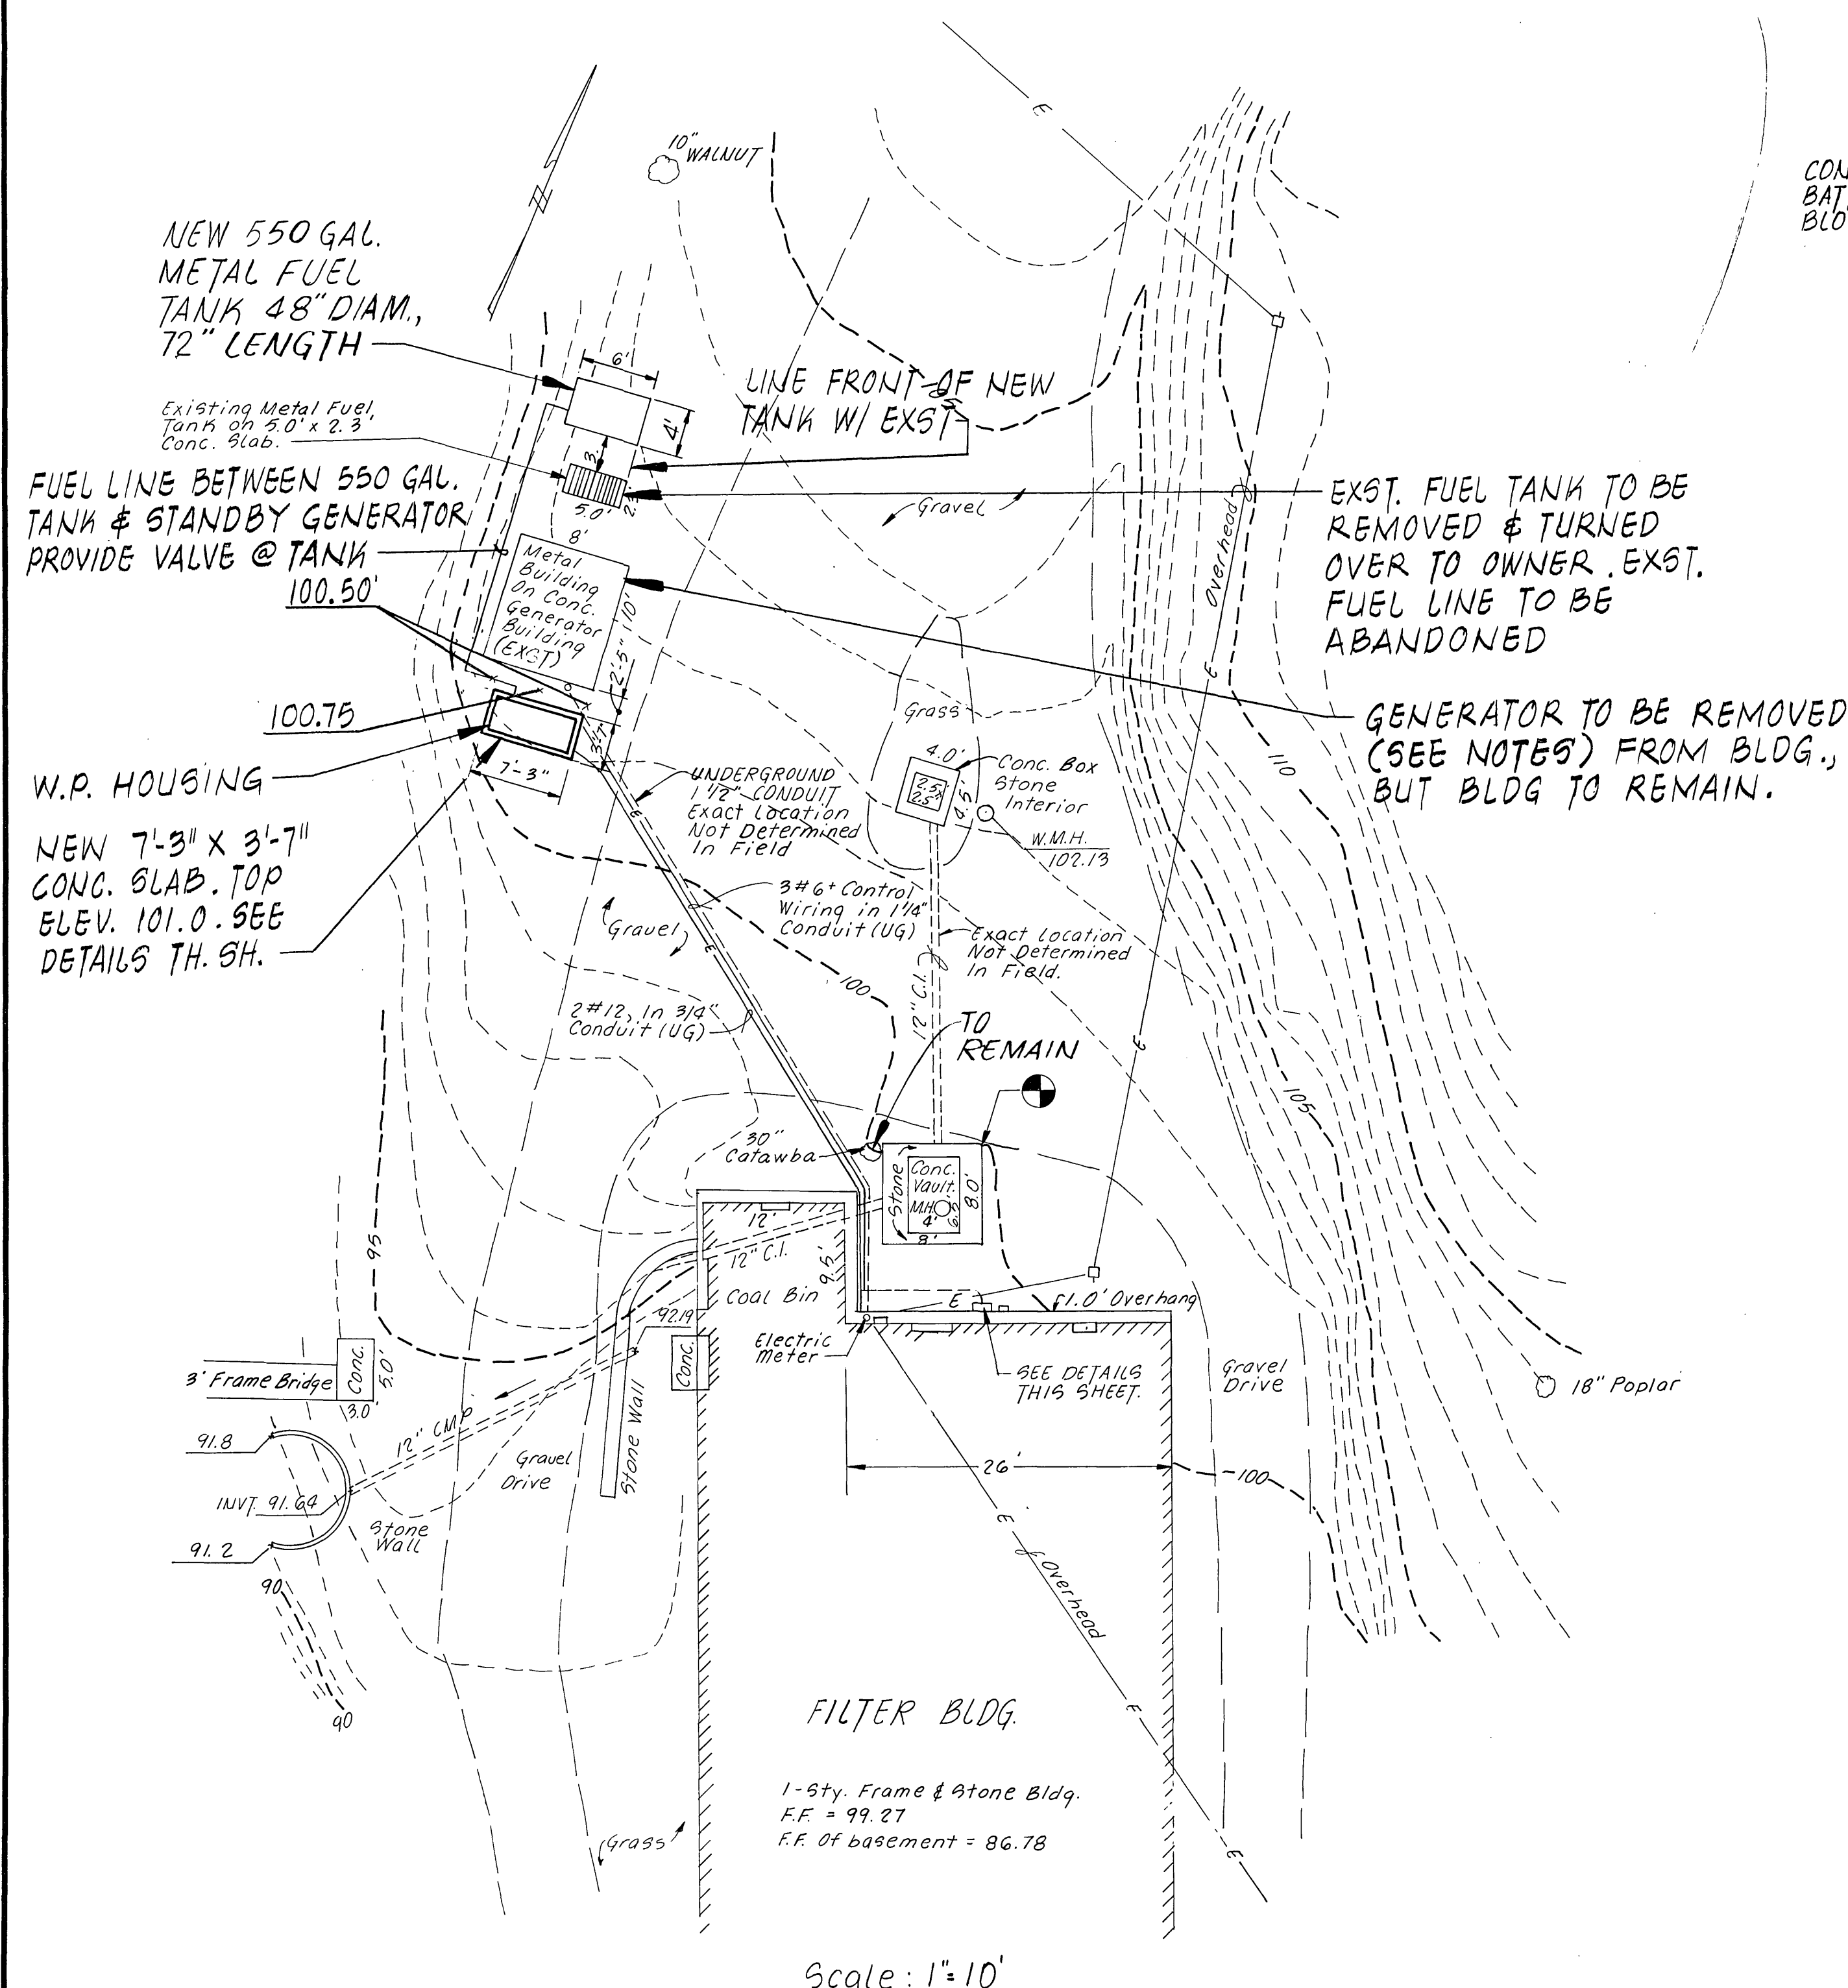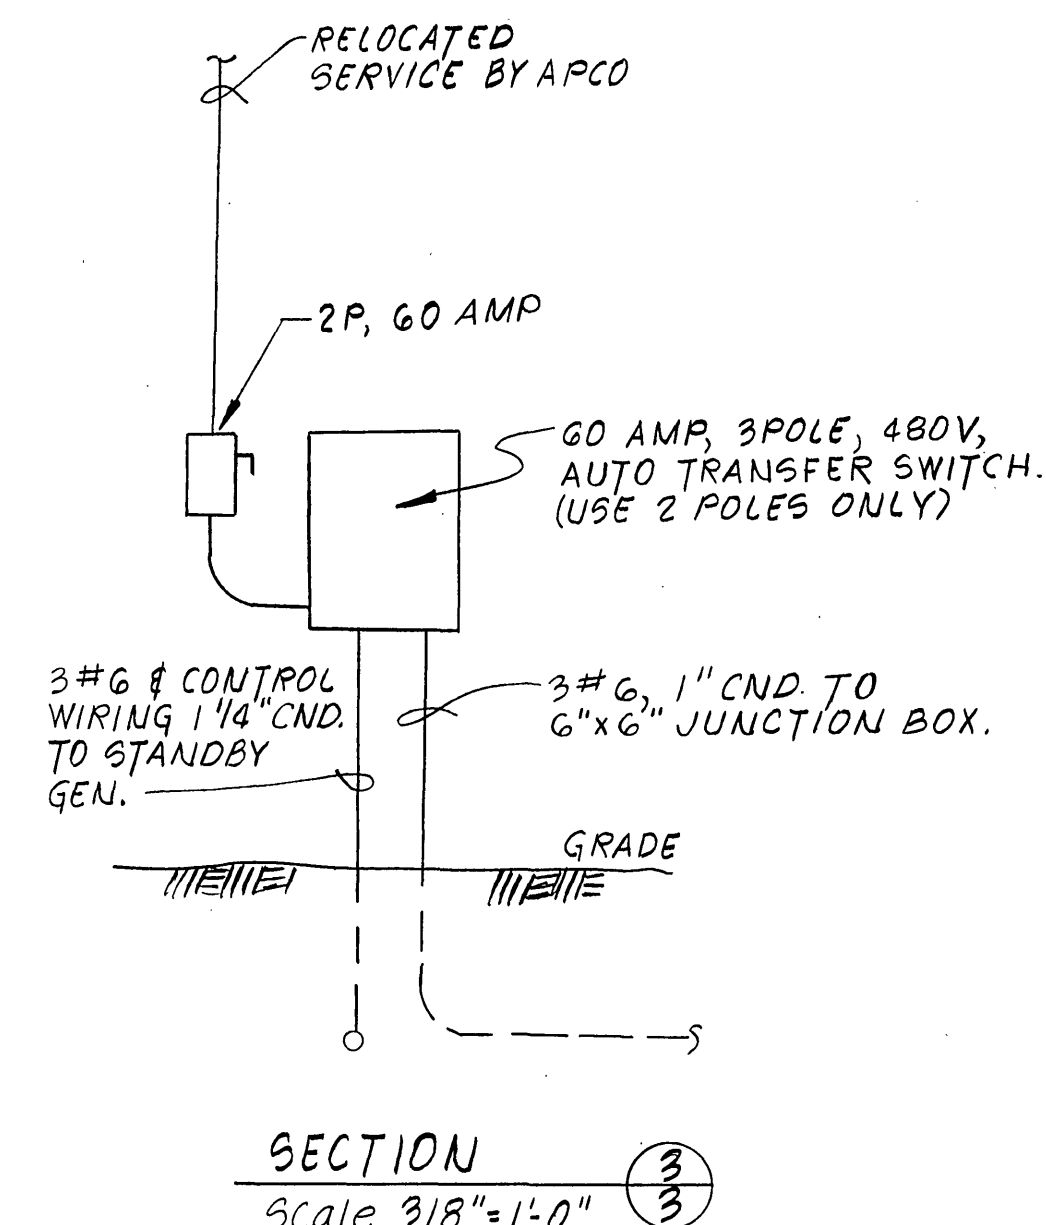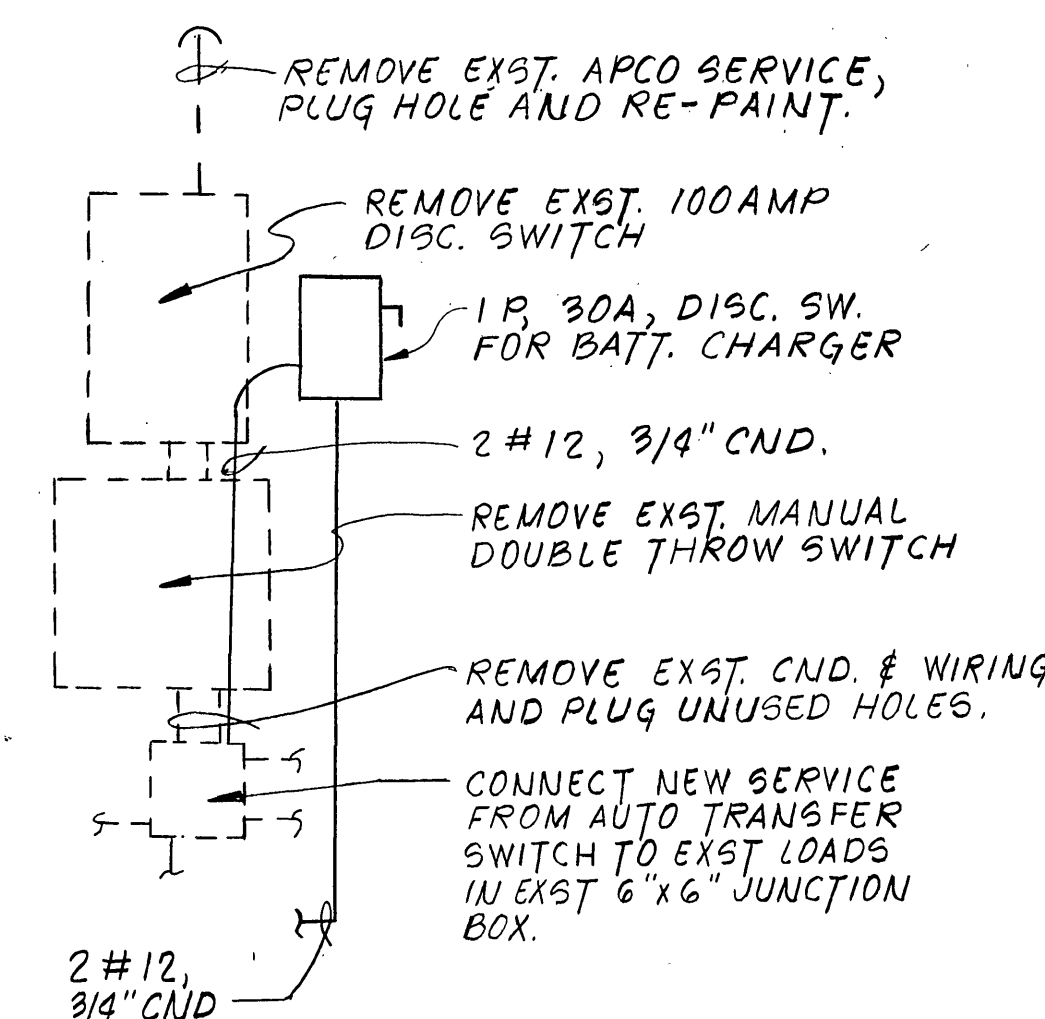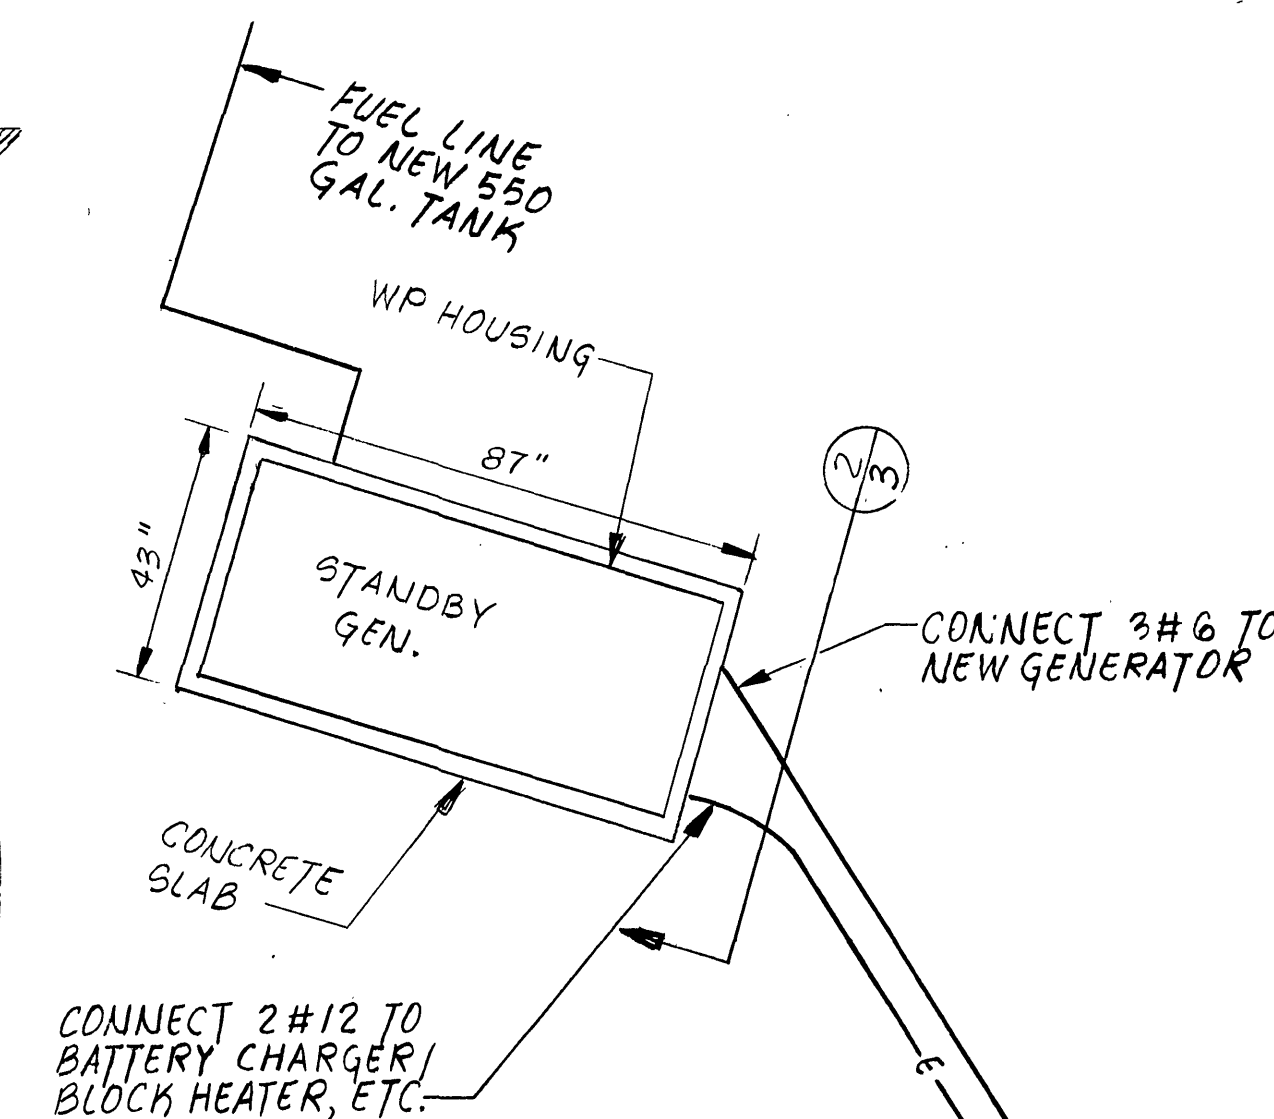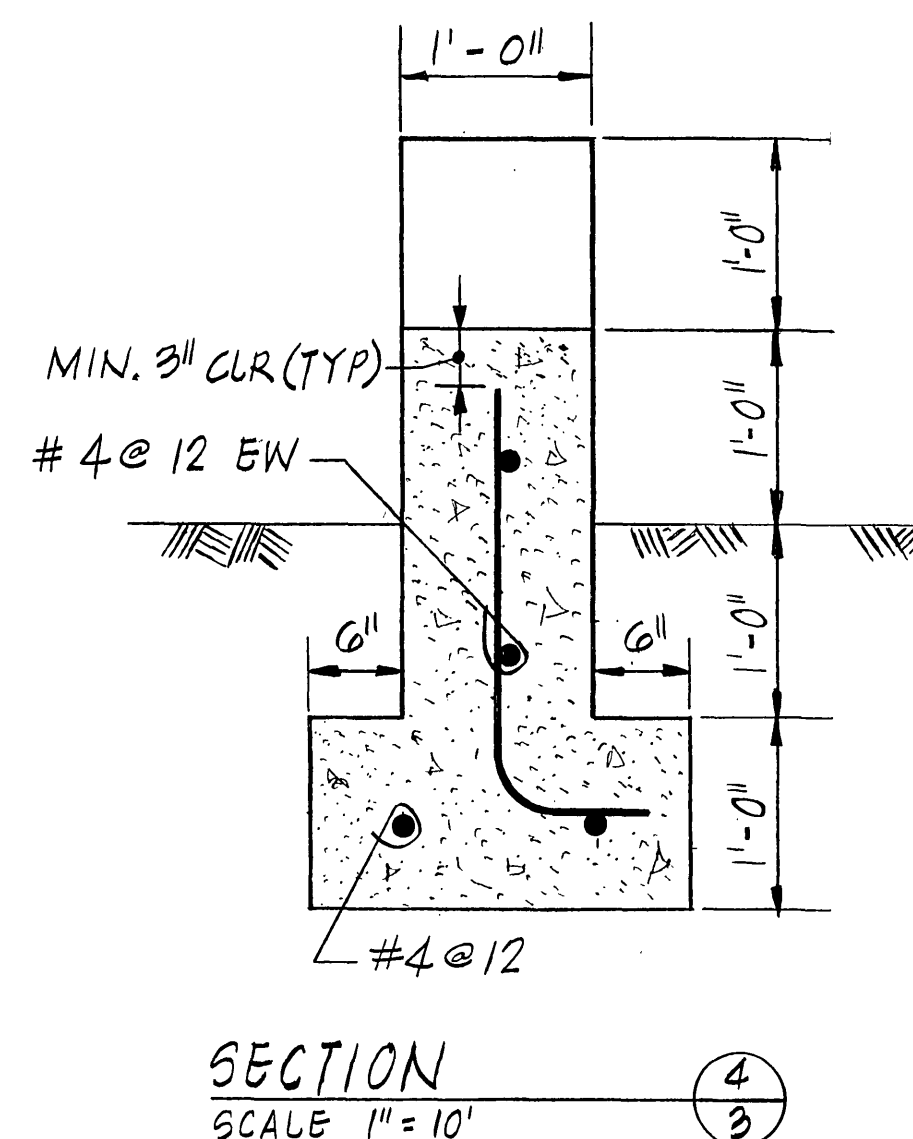

NOTES FOR EXIST. GEN. BLDG.

THE EXISTING STANDBY GENERATOR, DRY TYPE TRANSFORMER, AND ASSOCIATED CONDUIT AND WIRING SHALL BE COMPLETELY REMOVED AND TURNED OVER TO THE OWNER.

THE 120/240 VOLT LOAD CENTER, LIGHTING, SWITCHES, RECEPTACLES AND OTHER MISC. ELECTRICAL EQUIPMENT SHALL REMAIN IN PLACE.

ELECTRICAL DETAILS
EXISTING FILTER BLDG.
Scale 3/8" = 1'-0"

1	1-13-86	REVISED	FSM	
REVISION	DATE	DESCRIPTION	BY	APP
DESIGNED	JRC	FALLING CREEK GENERATOR REPLACEMENT PLAN AND ELECTRICAL DETAILS		
DRAWN	JR			
CHECKED	SWT			
APPROVED				
SUBMITTED				
 Mattern & Craig CONSULTING ENGINEERS		SCALE: NOTED	COMM. NO.	570
		DATE:	SHEET	3