


PROJECT LOCATION MAP

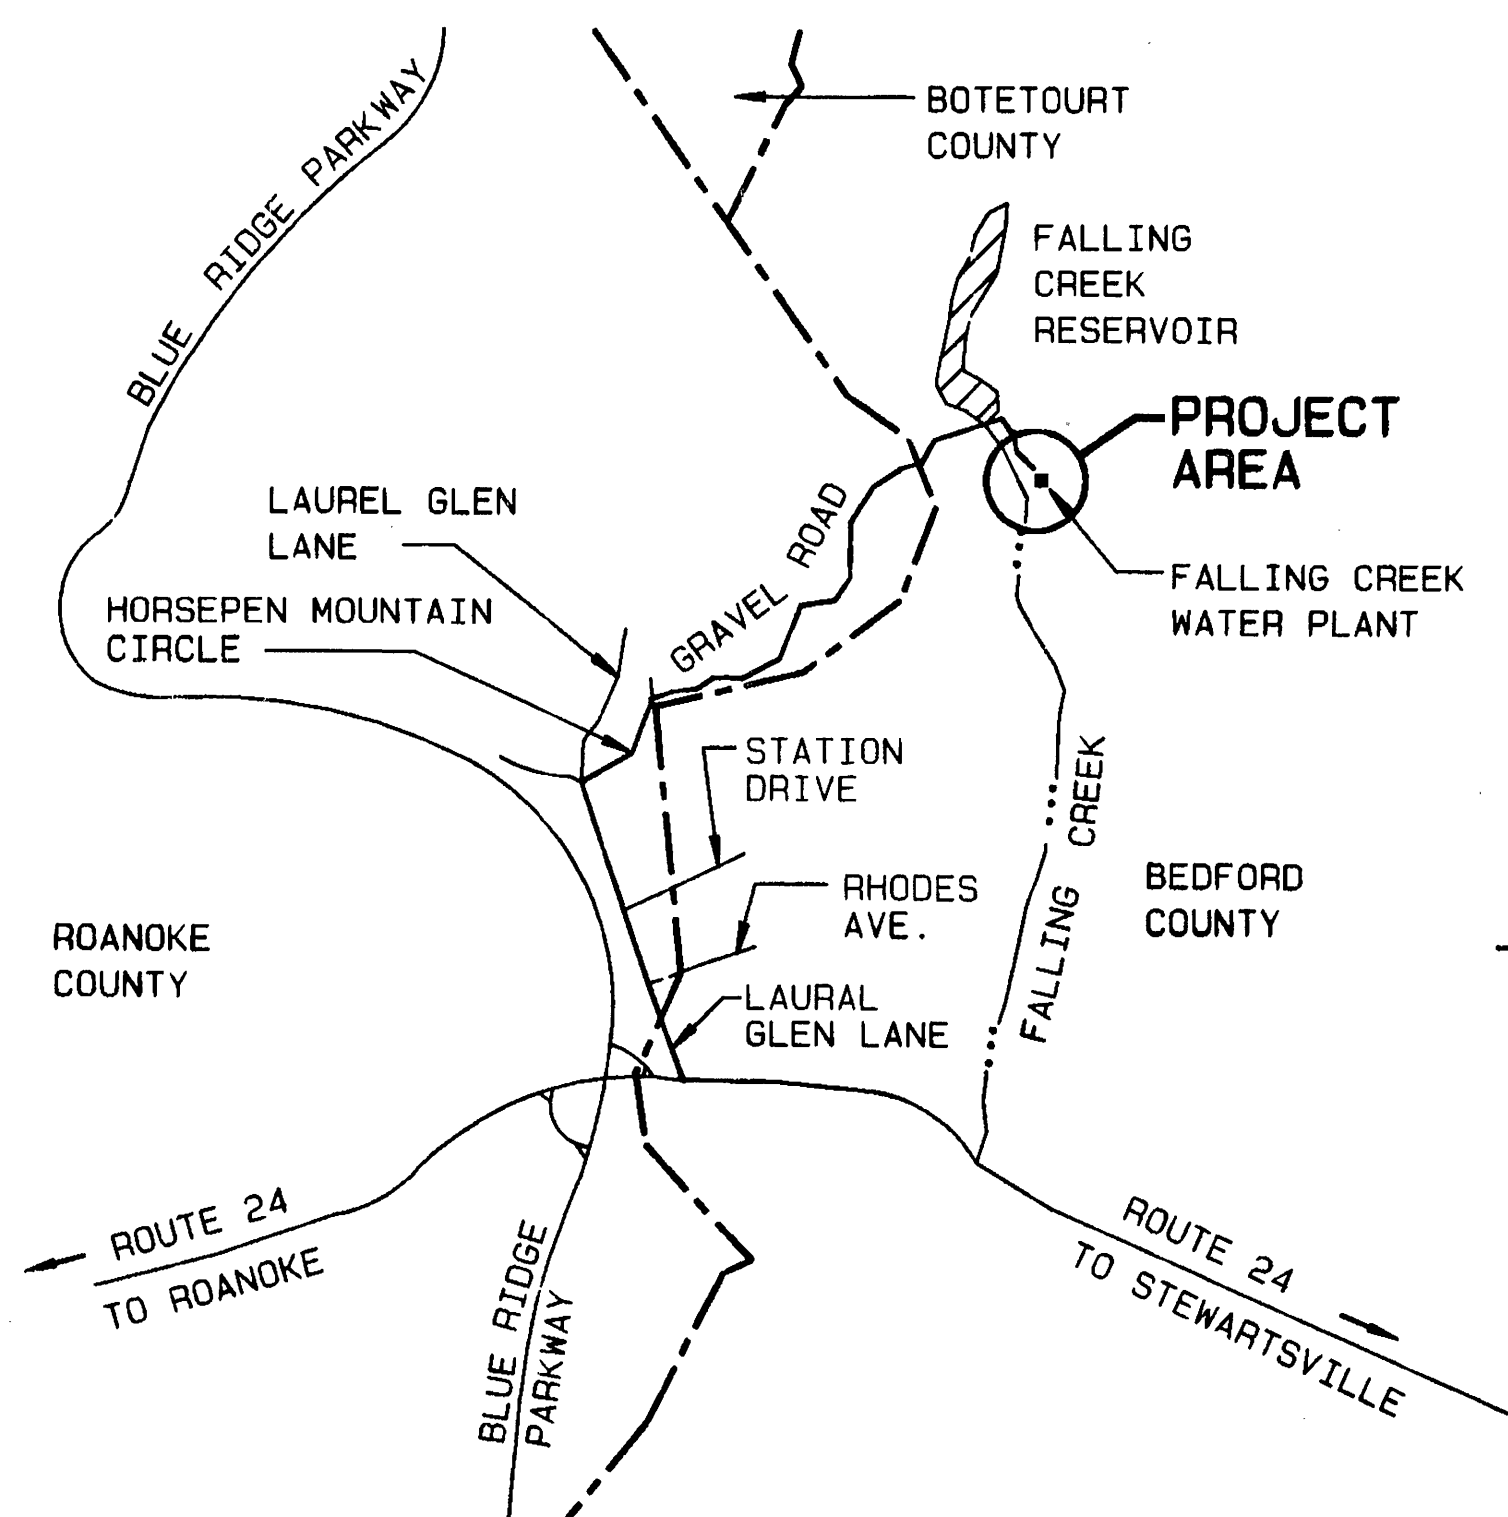

NOT TO SCALE



OFFICE OF CITY ENGINEER
ROOM 350
MUNICIPAL BUILDING
215 CHURCH AVENUE, S.W.
ROANOKE, VIRGINIA 24011

INDEX OF SHEETS

- 1 TITLE
- 2 ABBREVIATIONS AND LEGEND
- 3 GENERAL NOTES
- 4 EXISTING SITE TOPO AND DEMOLITION
- 5 GRADING AND EROSION CONTROL PLAN
- 6 PIPING PLAN AND DIMENSIONAL LAYOUT
- 7 PIPING PROFILE AND DETAILS
- 8 NEW RESERVOIR - PLAN AND SECTIONS
- 9 MISCELLANEOUS DETAILS AND SECTIONS


CONSULTING ENGINEERS



CONSULTING ENGINEERS
SURVEYORS

701 FIRST STREET
ROANOKE, VIRGINIA

COMMISSION NUMBER: 1249

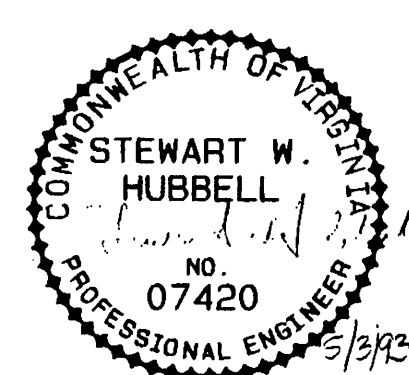

PROJECT NAME

FALLING CREEK FINISHED
WATER RESERVOIR
CITY OF ROANOKE, VIRGINIA

PROJECT NUMBER: 6240

1	SWH	DESCRIPTION: RECORD DRAWINGS	8-9-94
REVISION BY			DATE
		DESCRIPTION:	
REVISION BY			DATE
		DESCRIPTION:	
REVISION BY			DATE
		DESCRIPTION:	
REVISION BY			DATE

APPROVED FOR CONSTRUCTION

Charles M. Huffine 5-25-93
ROANOKE CITY ENGINEER DATE

William F. Cline 5-25-93
DIRECTOR OF PUBLIC WORKS DATE

Det. D. J. 5/25/93
DIRECTOR OF PUBLIC UTILITIES AND OPERATIONS DATE

DATE

DATE

ADVERTISED DATE: 5-30-93

SET NUMBER: _____

SHEET NUMBER: 1 OF 9