



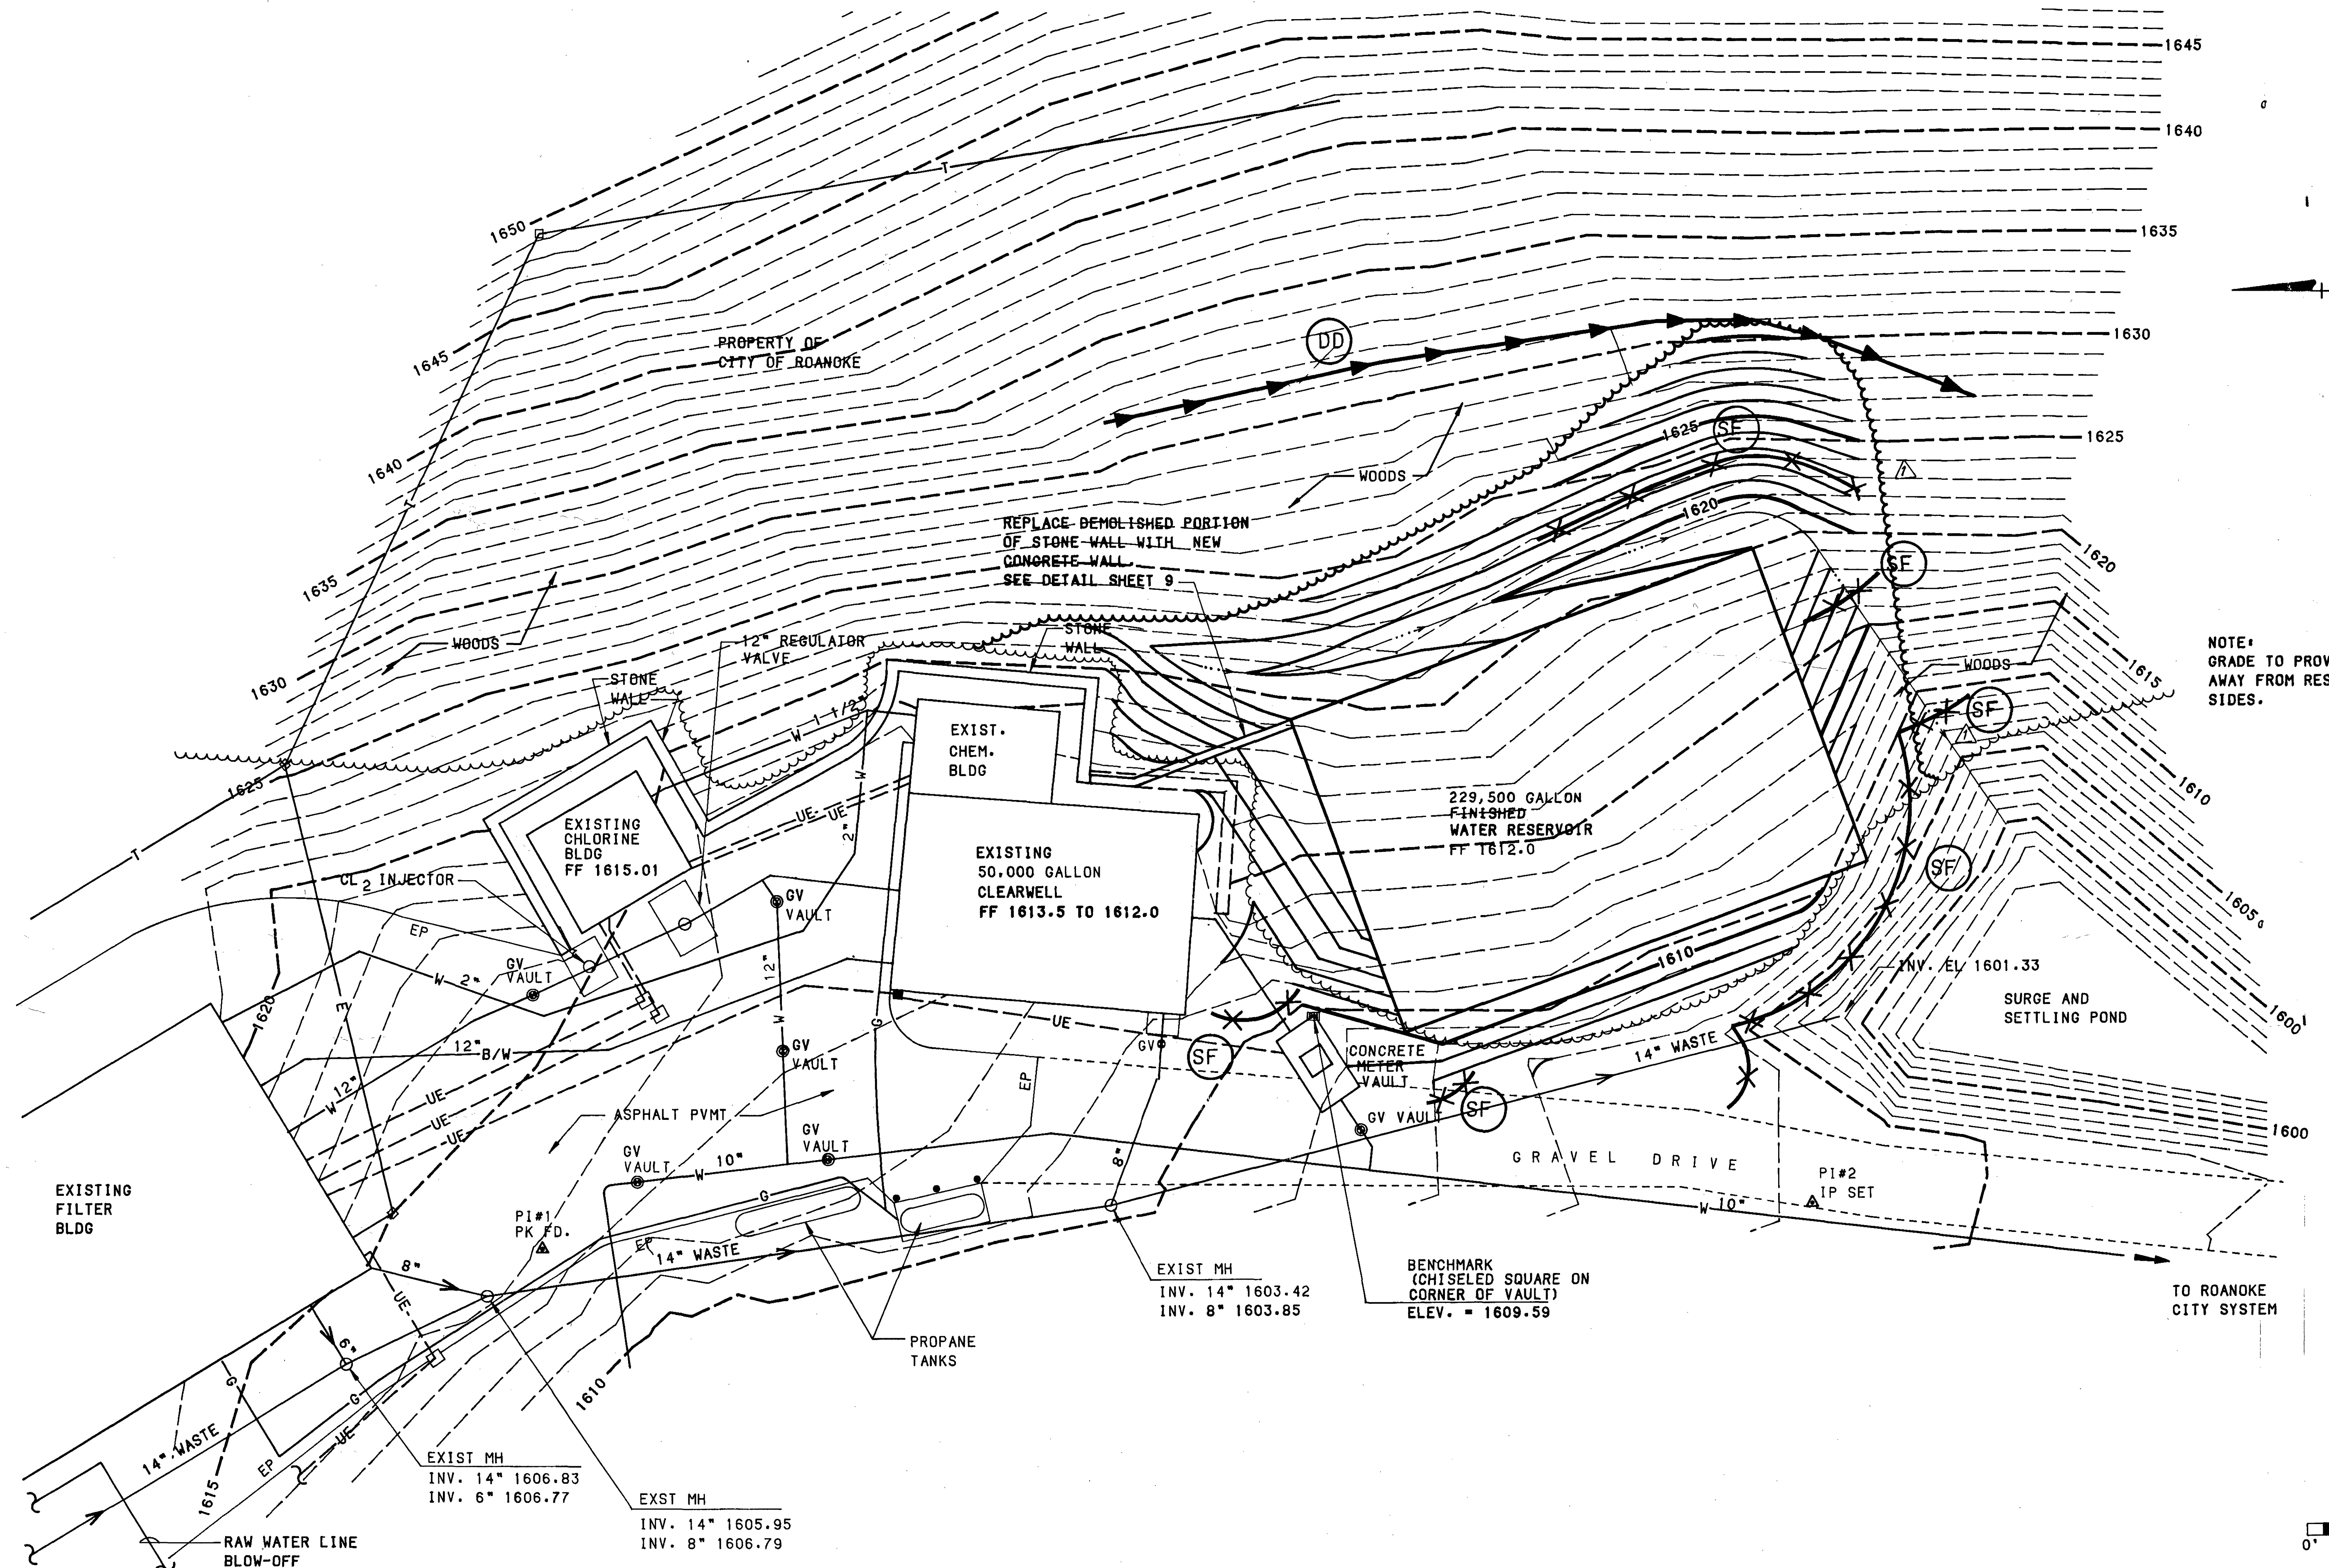

Mattern & Craig
CONSULTING ENGINEERS - SURVEYORS

DESIGNED: **RWB**
DRAWN: **FMP**
CHECKED: **JMD**

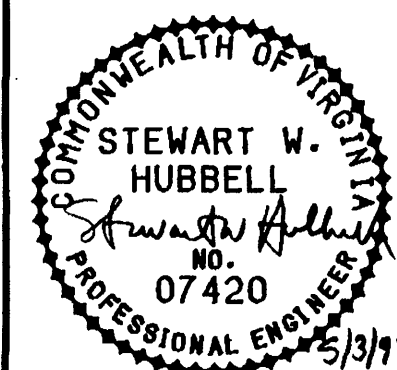

REV.	DATE	DESCRIPTION	BY	APP.
1	5-18-93	REVISED PER SC6 COMMENTS	SMM	RWB
2	8-9-94	RECORD DRAWING	AGB	

DATE
MAY
1993
COMM.
1249

FALLING CREEK FINISHED WATER RESERVOIR
CITY OF ROANOKE, VIRGINIA
GRADING AND EROSION CONTROL PLAN

SHEET
5