


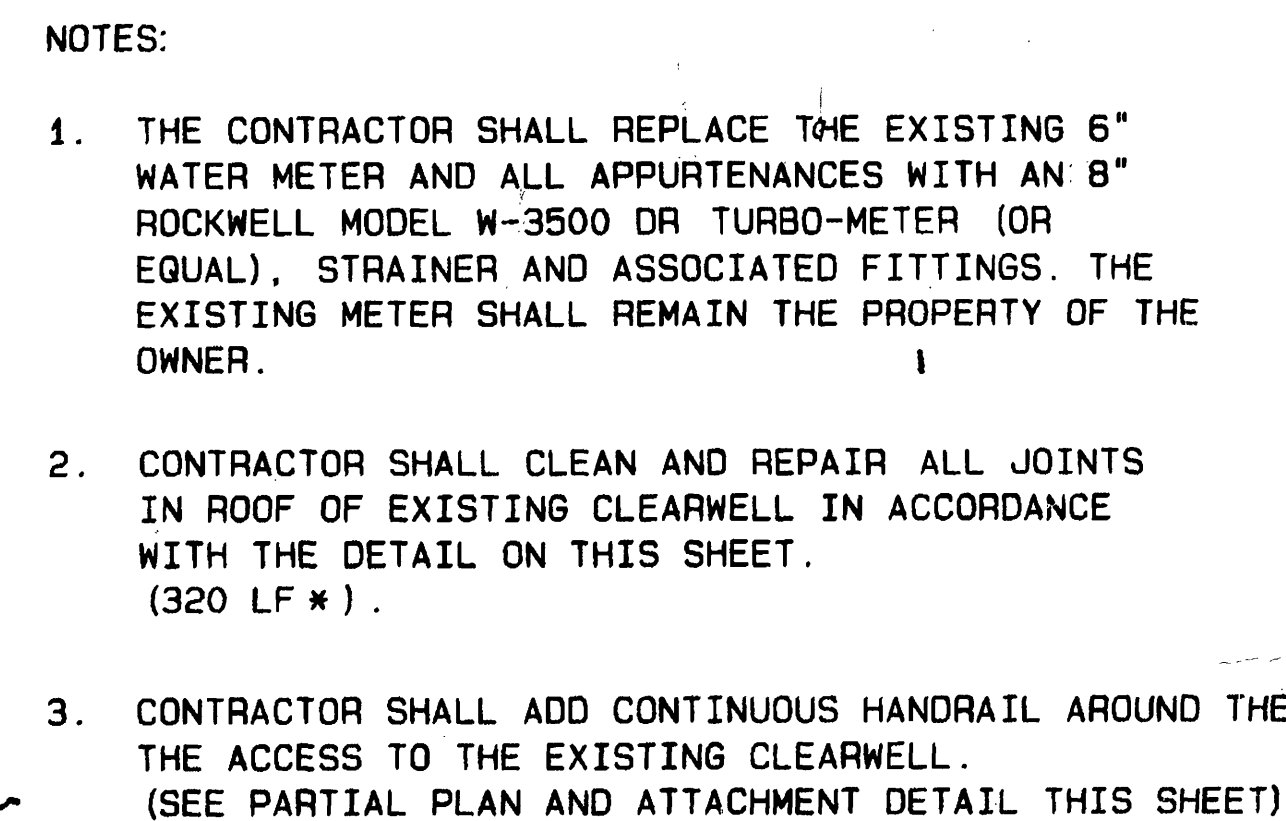

SCALE: NONE



CP	NORTHING	EASTING
PI #1	5160.0624	4994.4105
PI #2	5000.0000	5000.0000
CP #501	5065.5718	5061.2053
CP #502	5007.3109	5082.4105
CP #503	4992.9460	5042.9435
CP #504	5051.2070	5021.7382
CP #520	5147.3901	5032.8644
CP #521	5125.7990	5021.3709
CP #522	5128.5230	5028.4318
CP #523	5118.7783	5004.8615
CP #524	5102.4966	5011.0443
CP #525	5071.9955	5031.3179
CP #526	5066.9039	5007.2168
CP #528	5085.4050	5052.8858

TO ROANOKE CITY
WATER DISTRIBUTION SYSTEM


SCALE
1" = 10'



0' 10' 20'



DESIGNED:	RWB
DRAWN:	FMP
CHECKED:	JMD

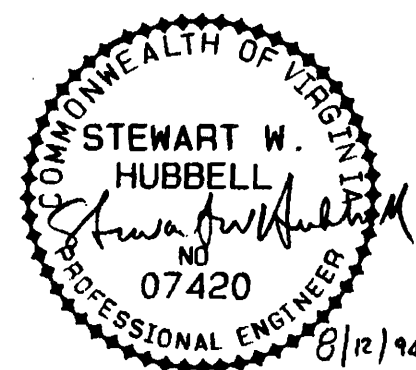

REV.	DATE	DESCRIPTION	BY	APP
1	8-9-94	RECORD DRAWING	ASB	Sw

DATE
MAY
1993
COMM.
1249

FALLING CREEK FINISHED WATER RESERVOIR
CITY OF ROANOKE, VIRGINIA

PIPING PLAN AND DIMENSIONAL LAYOUT

SHEET

6