


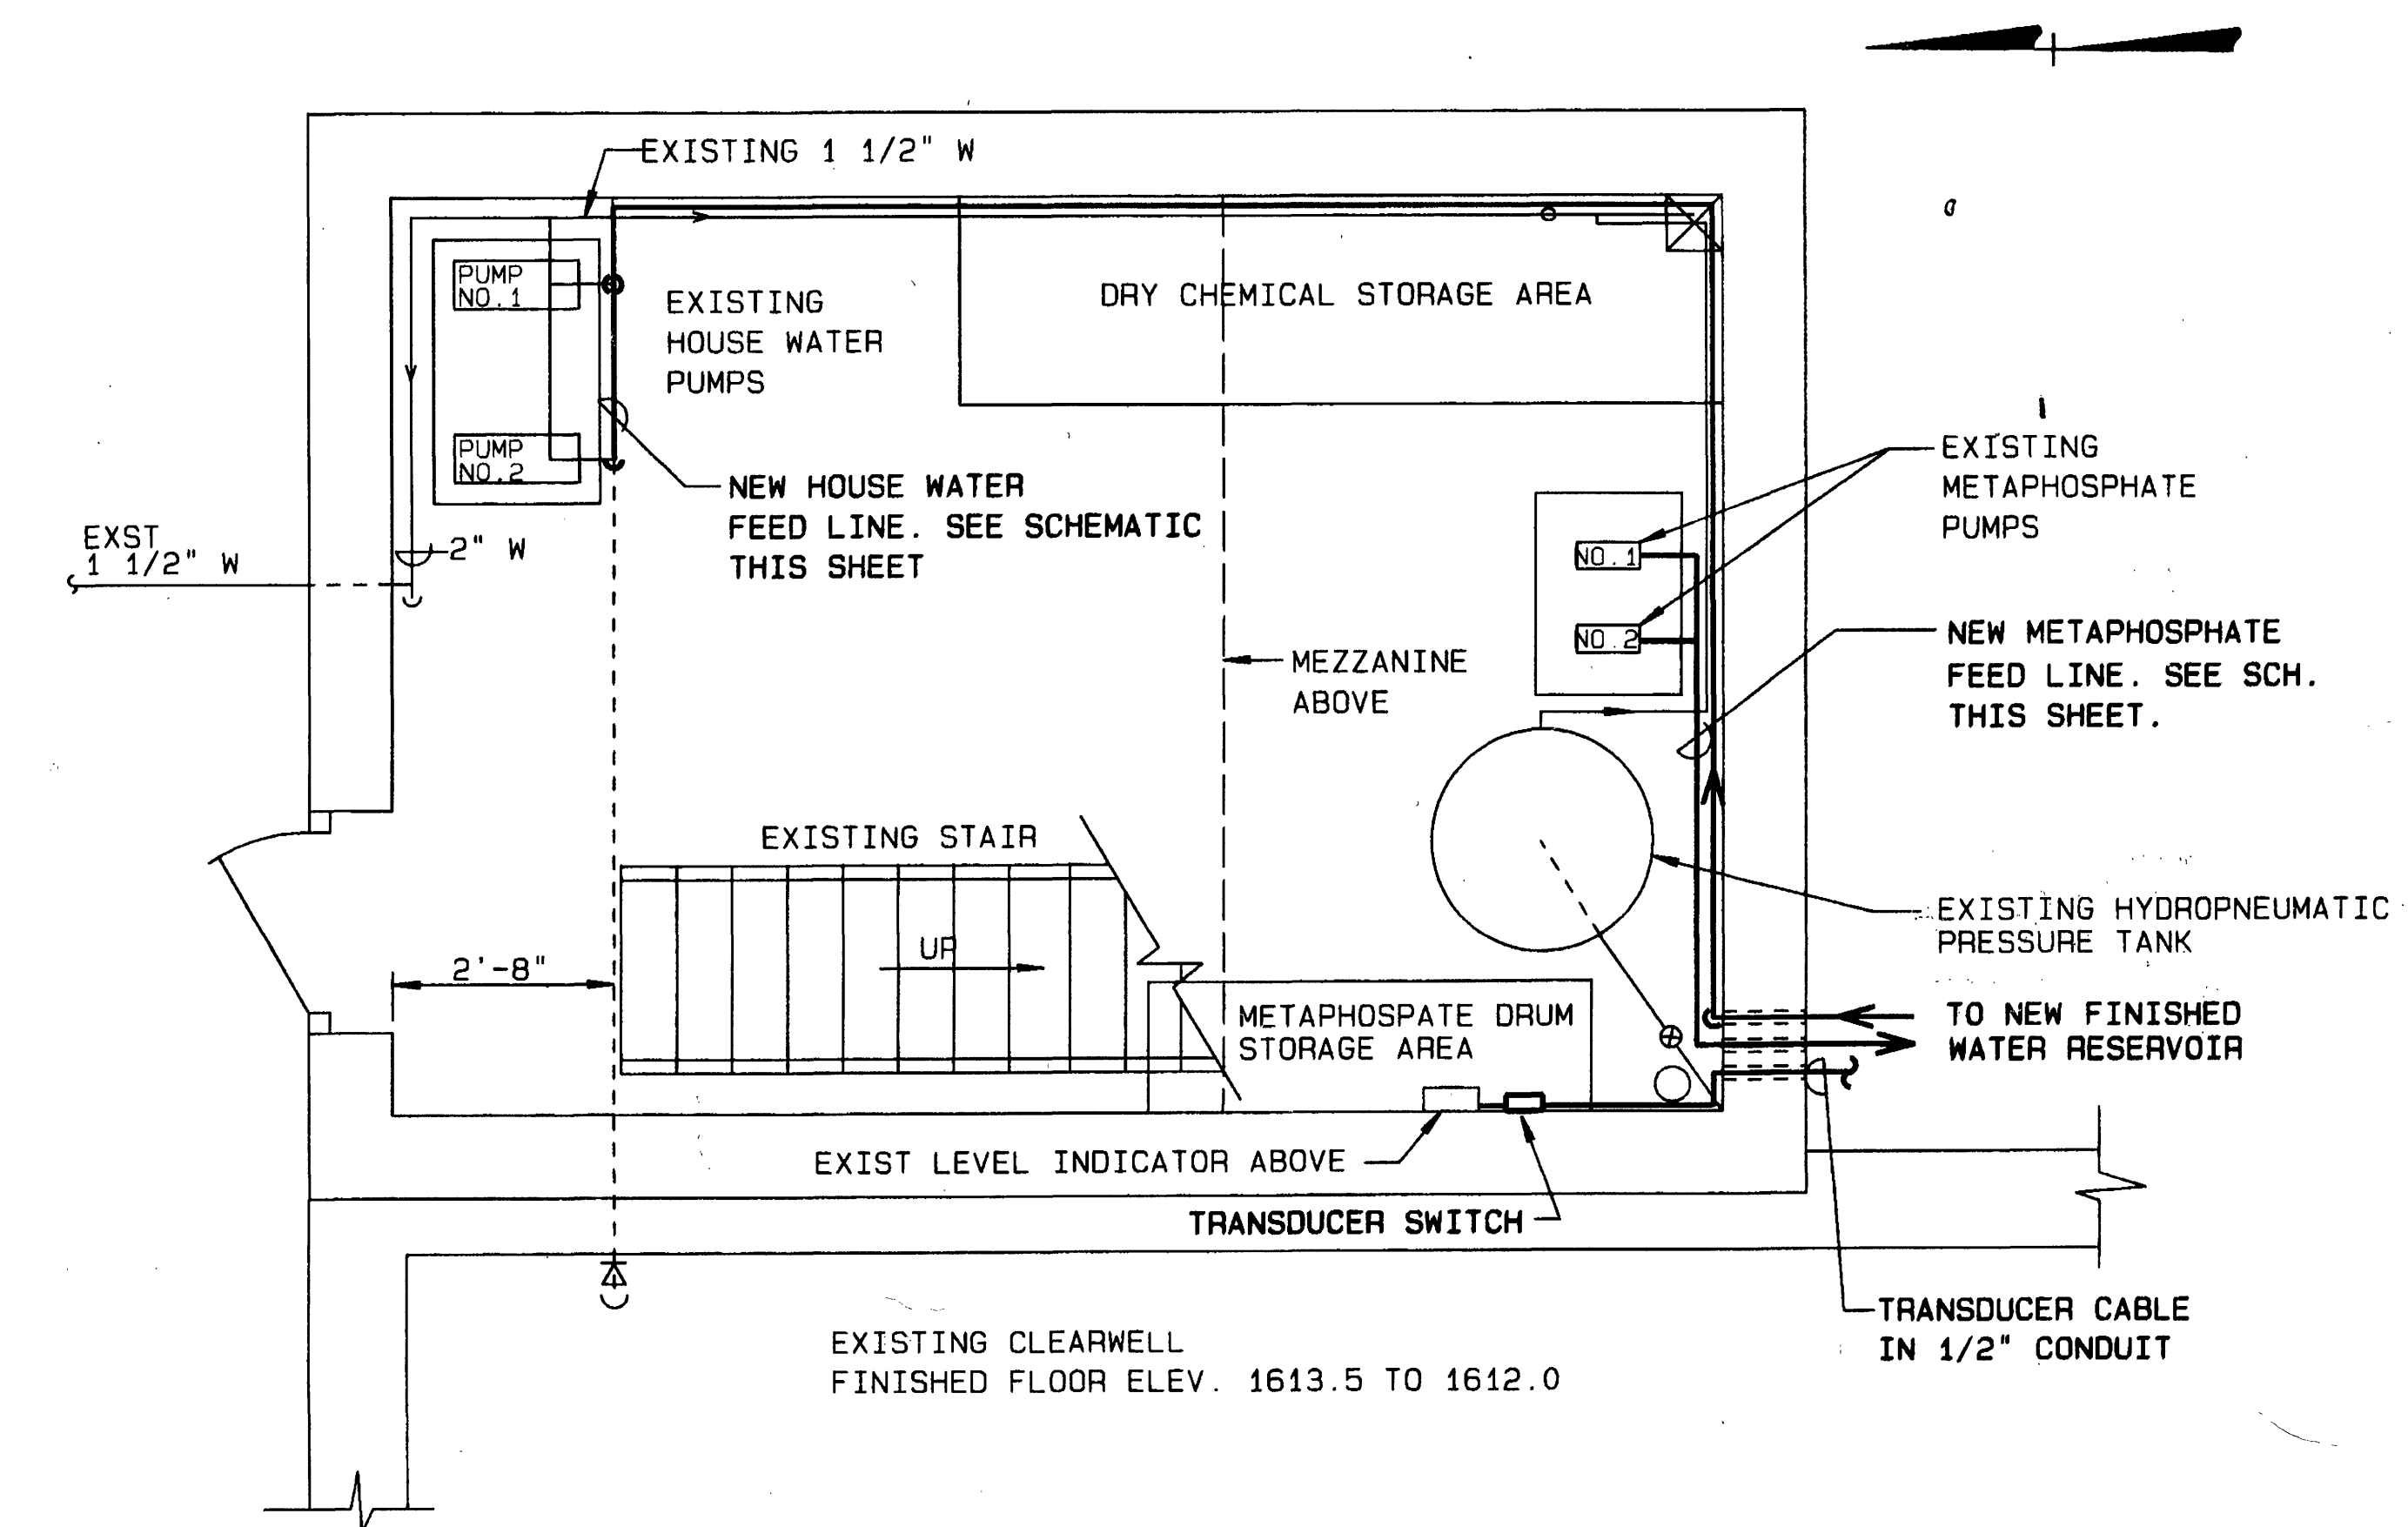


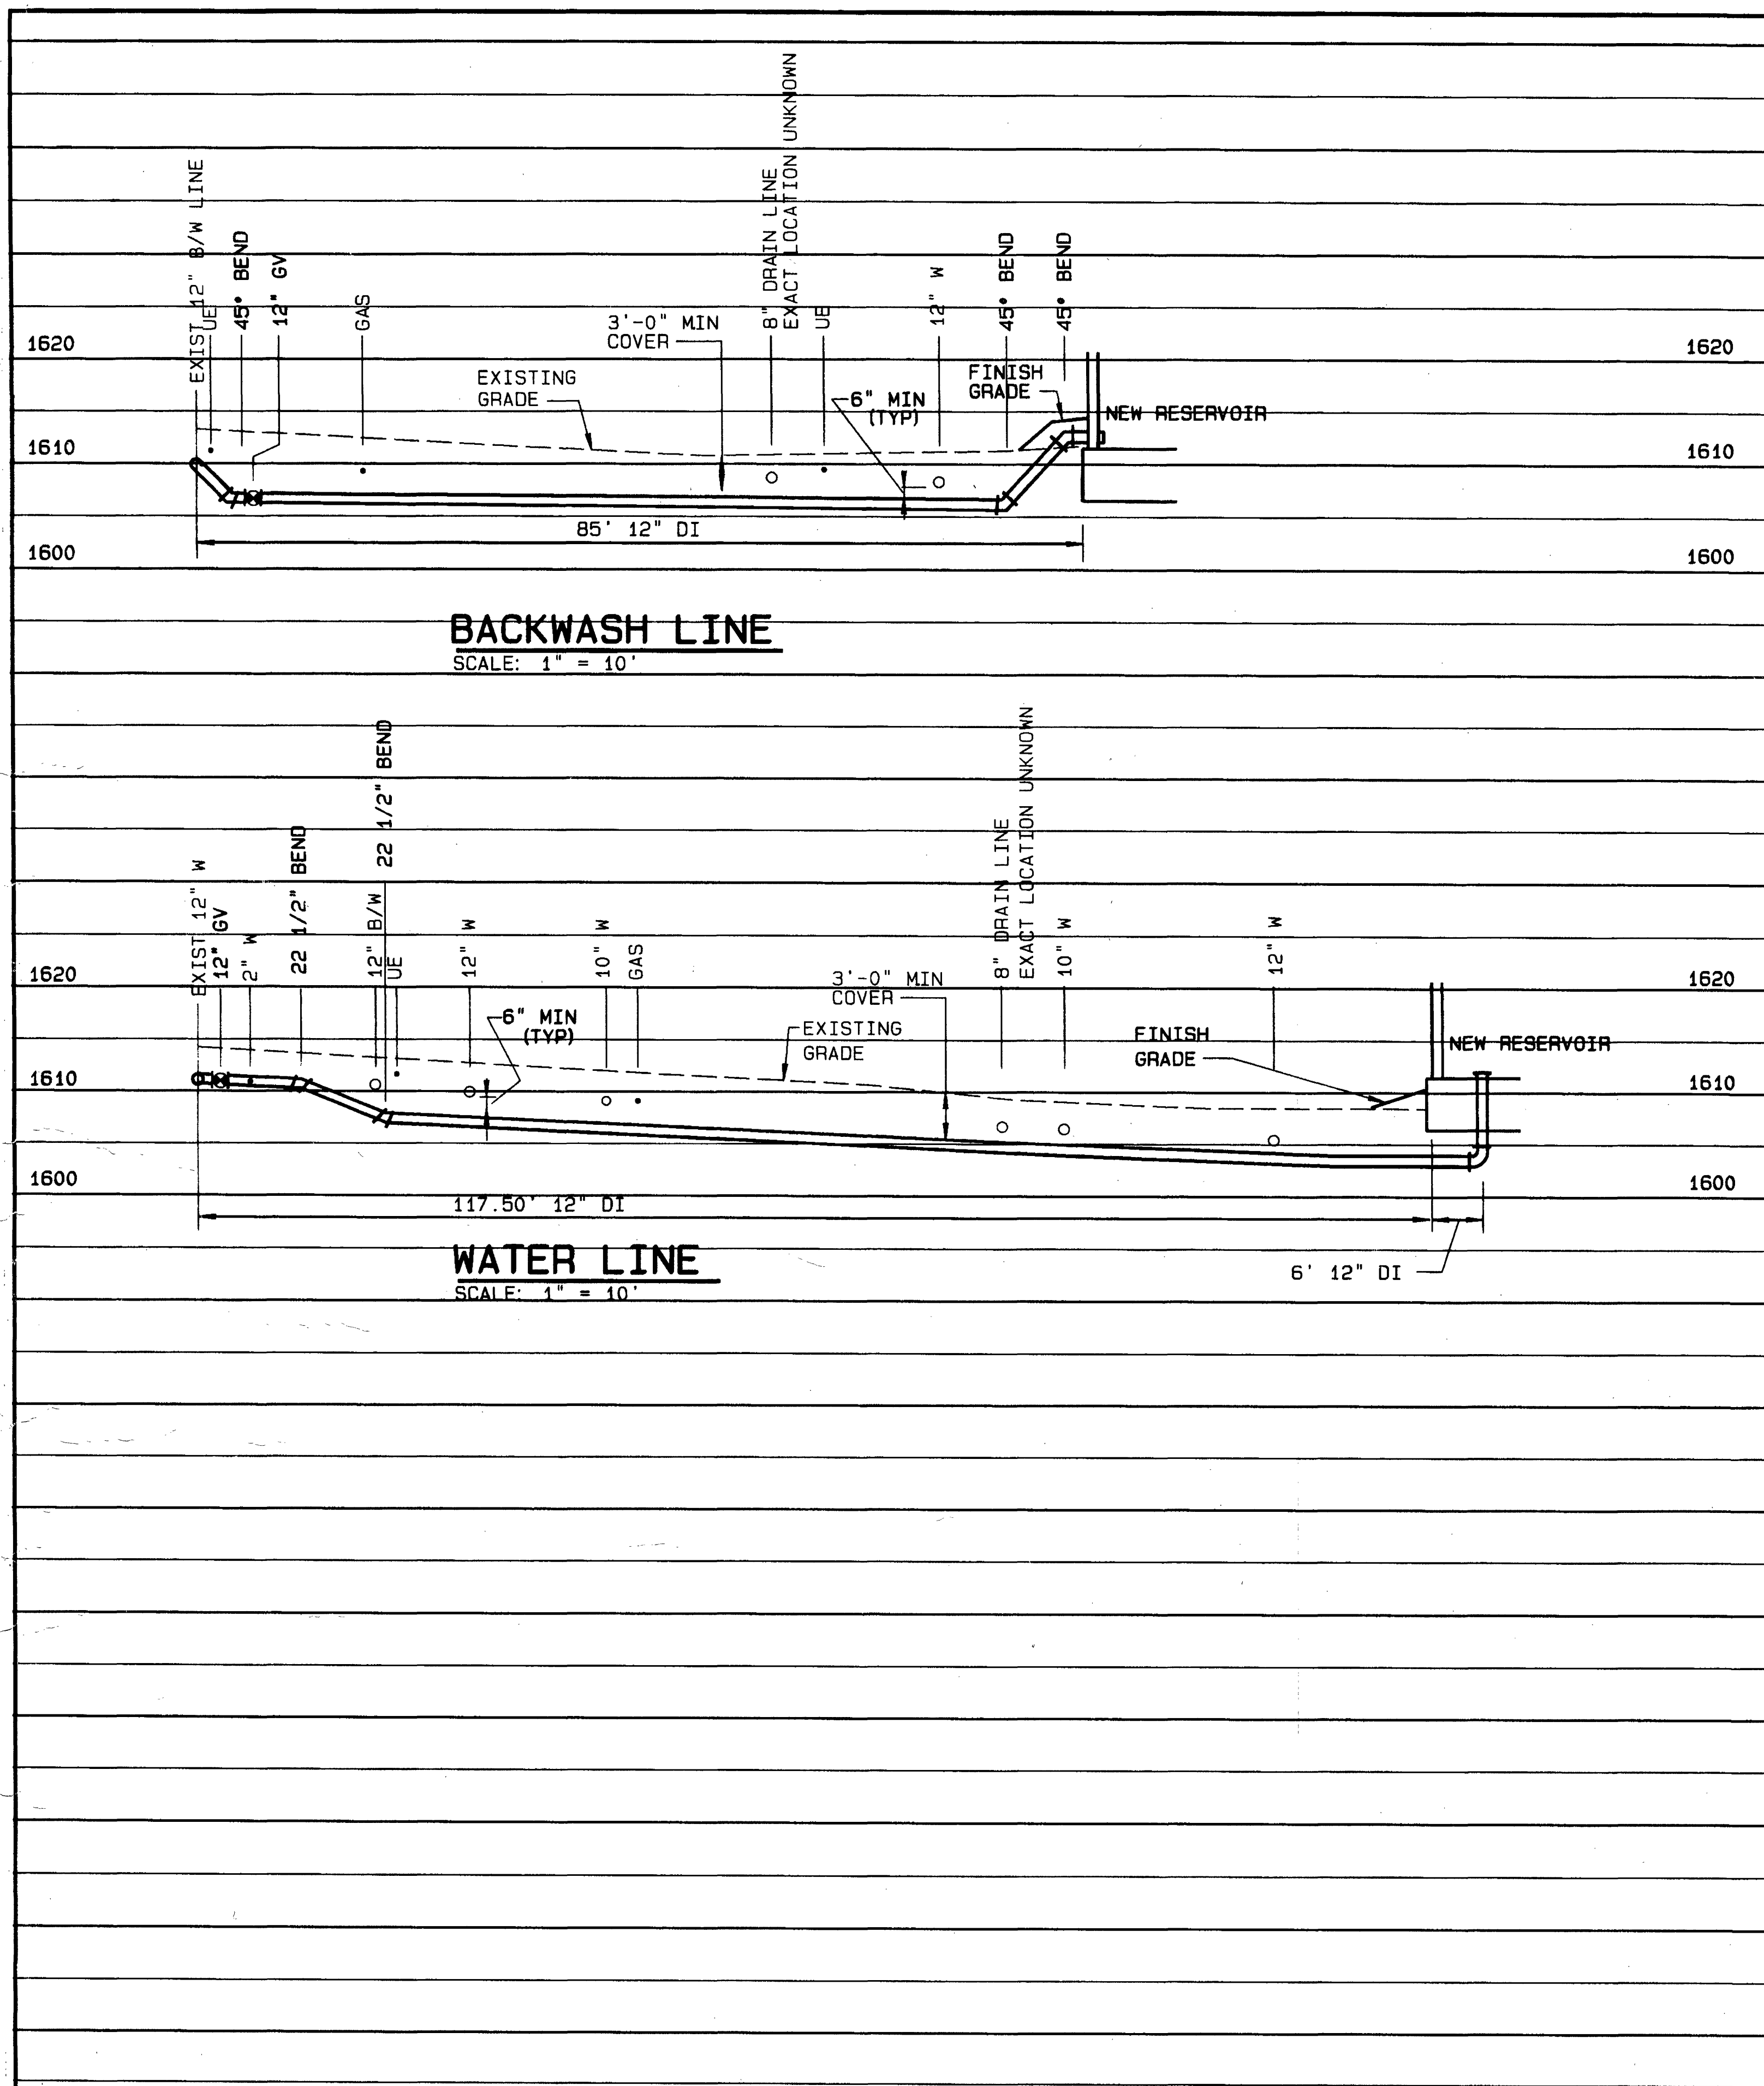


EXISTING CHEMICAL BLDG. - 1ST FLOOR PLAN EQUIPMENT LAYOUT
SCALE: 1/2" = 1'-0"

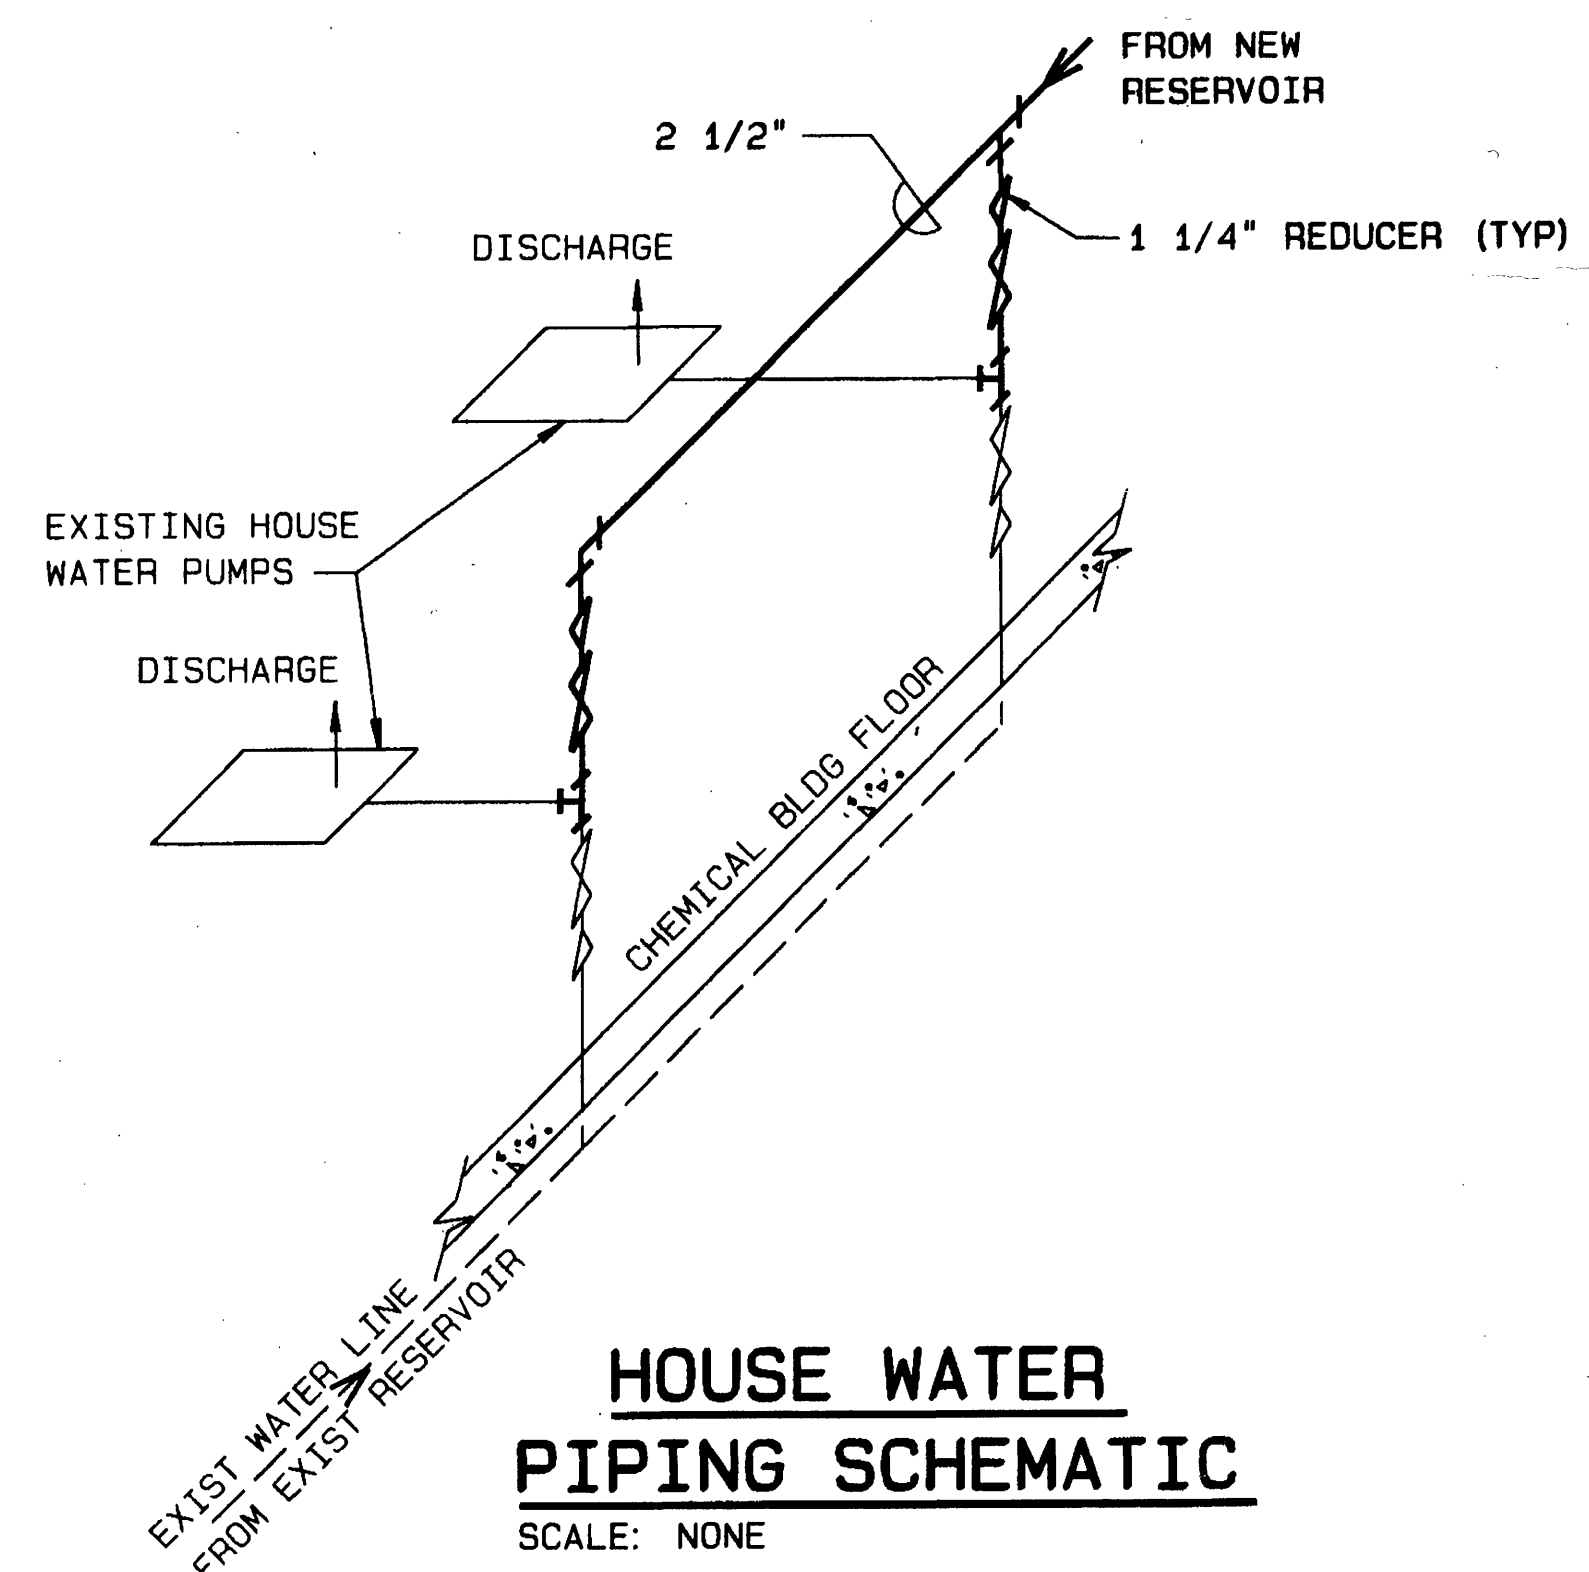

**HOUSE WATER
PIPING SCHEMATIC**
SCALE: NONE

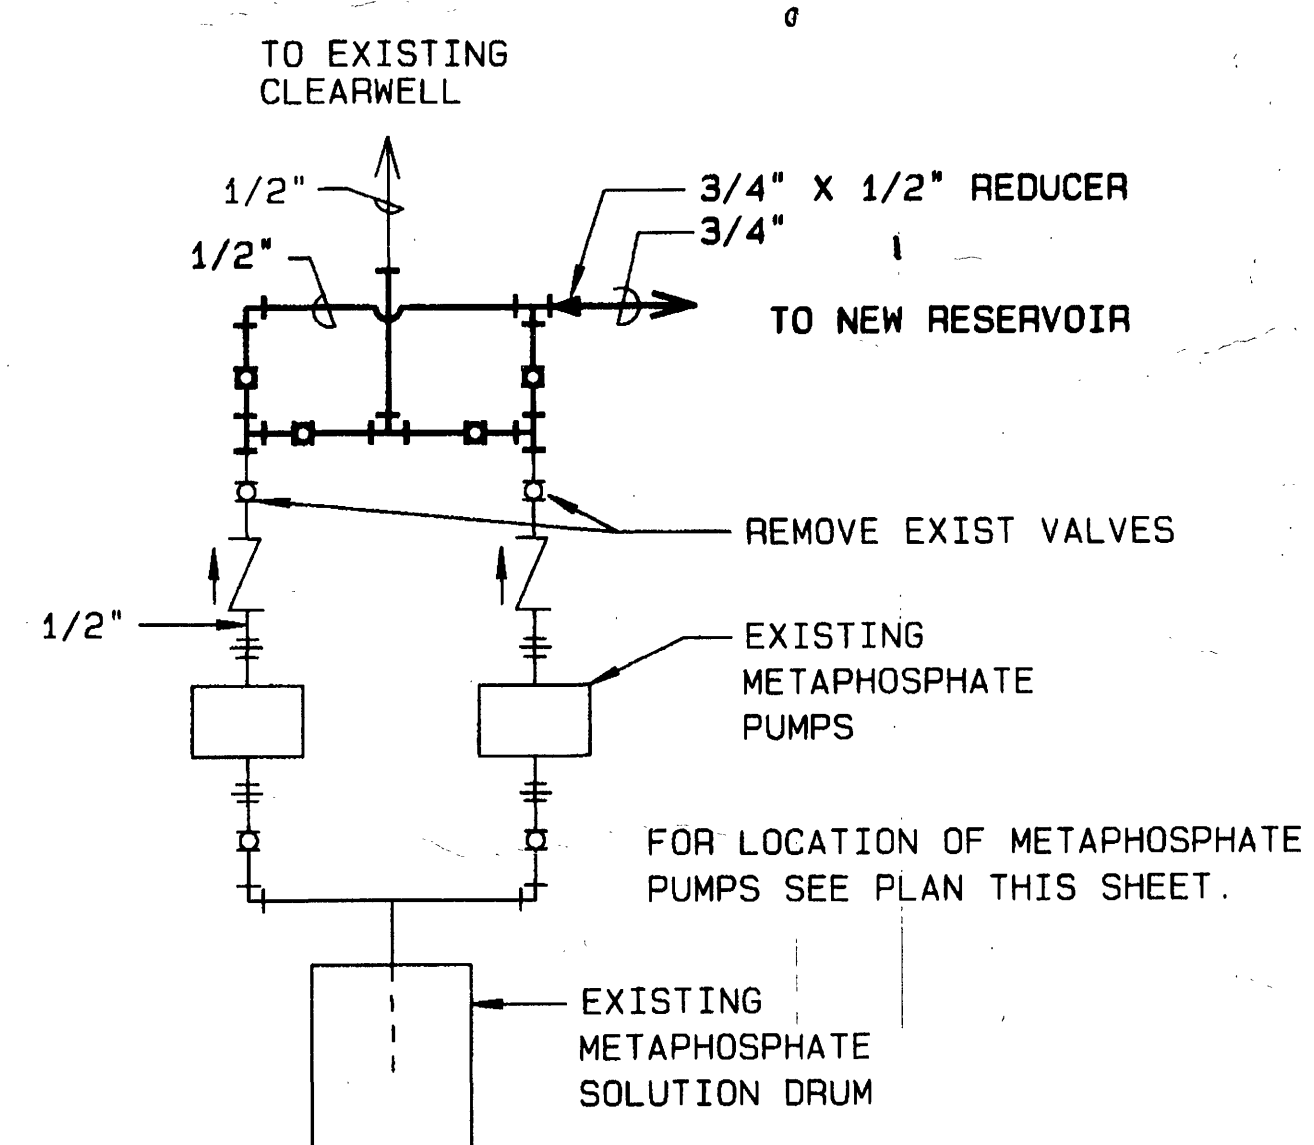

**METAPHOSPHATE
PIPING SCHEMATIC**
SCALE: NONE

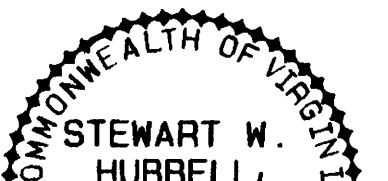 Mattern & Craig CONSULTING ENGINEERS - SURVEYORS	DESIGNED:	RWB		REV.	DATE	DESCRIPTION	BY	APP.	DATE	FALLING CREEK FINISHED WATER RESERVOIR CITY OF ROANOKE, VIRGINIA PIPING PROFILES AND DETAILS	SHEET 7
	DRAWN:	FMP		8-9-94	RECORD DRAWING	ASB	SWH	MAY 1993			
	CHECKED:	JMD						1249			