




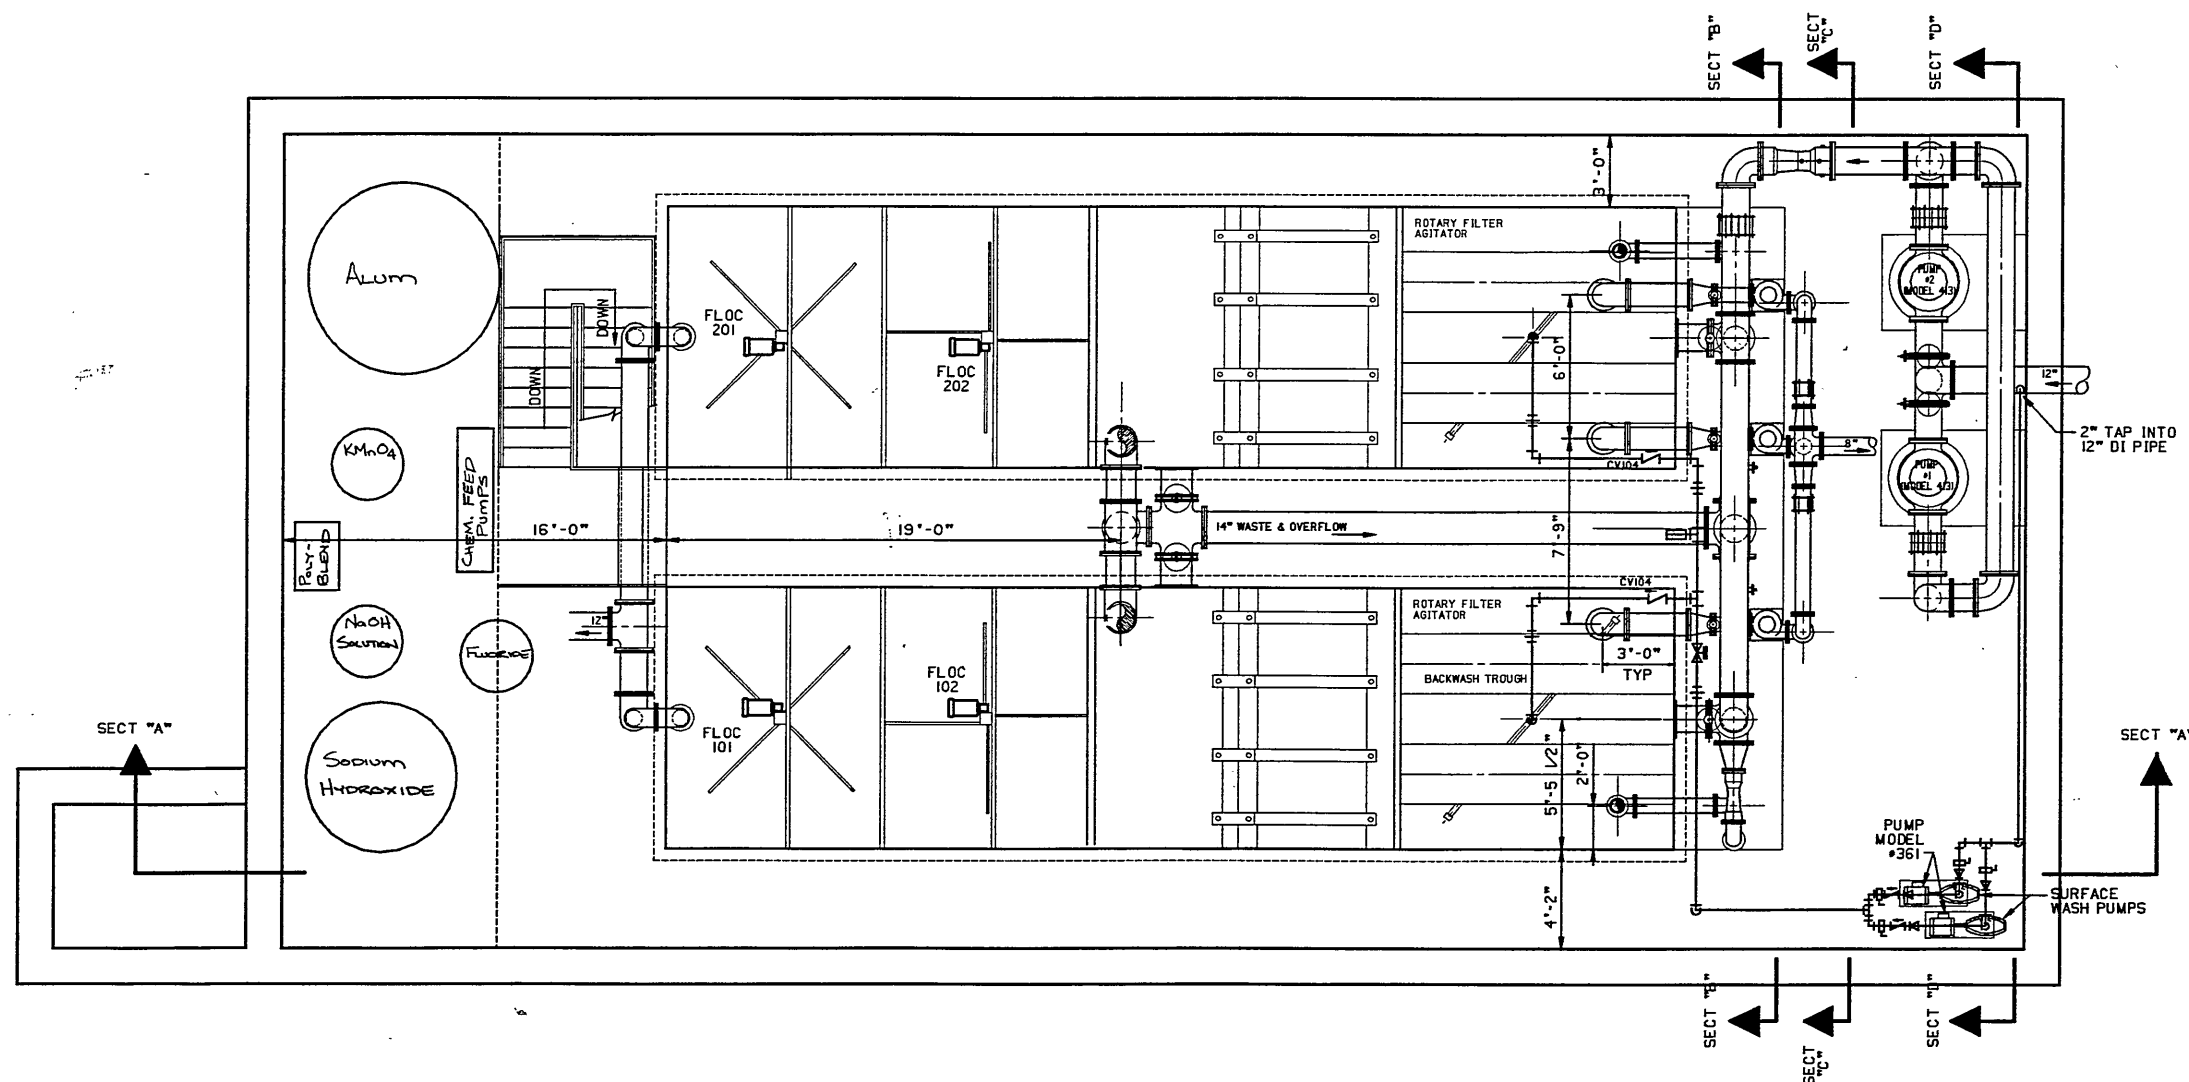


FLOOR PLAN
SCALE: 1/4"=1'-0"

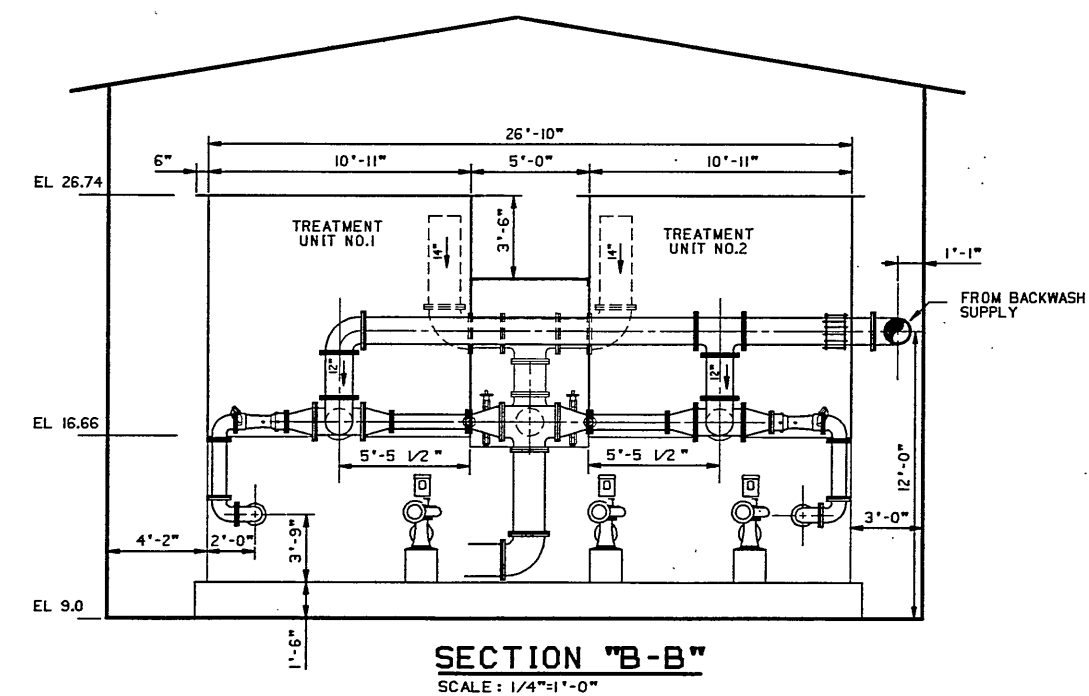


SECTION "B-B"
SCALE: 1/4"=1'-0"

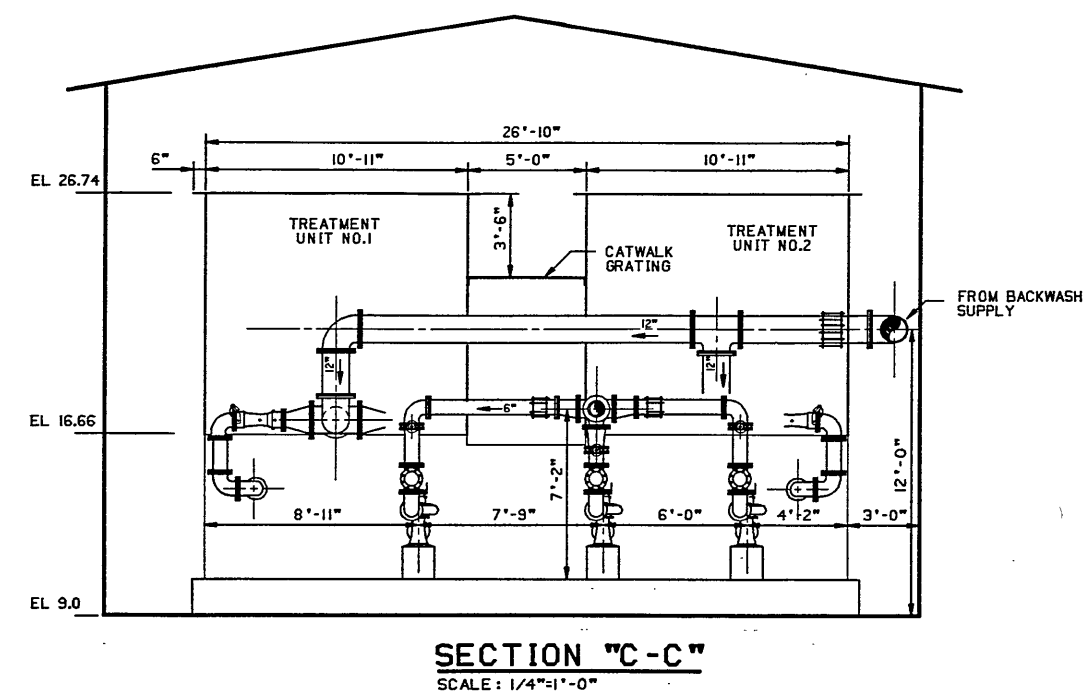

SECTION "C-C"
SCALE: 1/4"=1'-0"

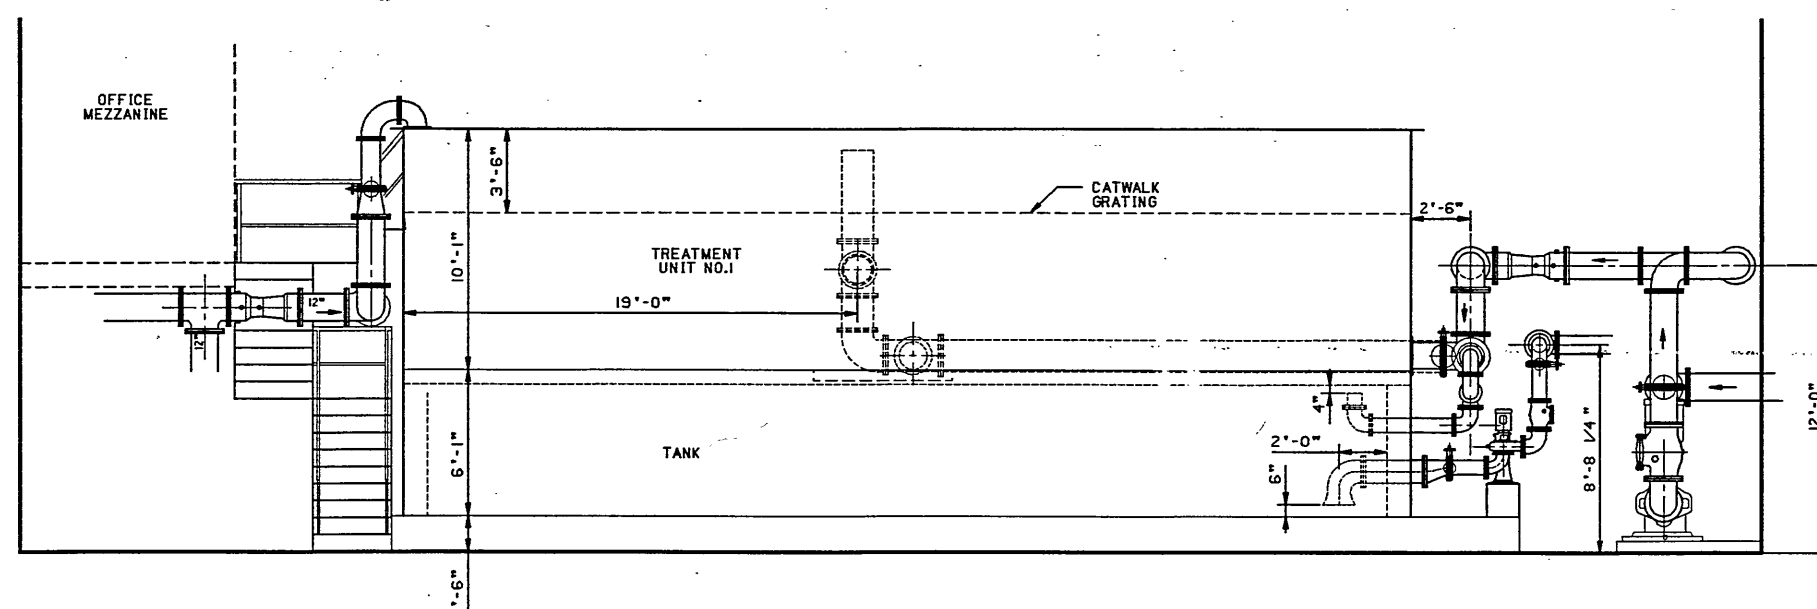

SECTION "A-A"
SCALE: 1/4"=1'-0"

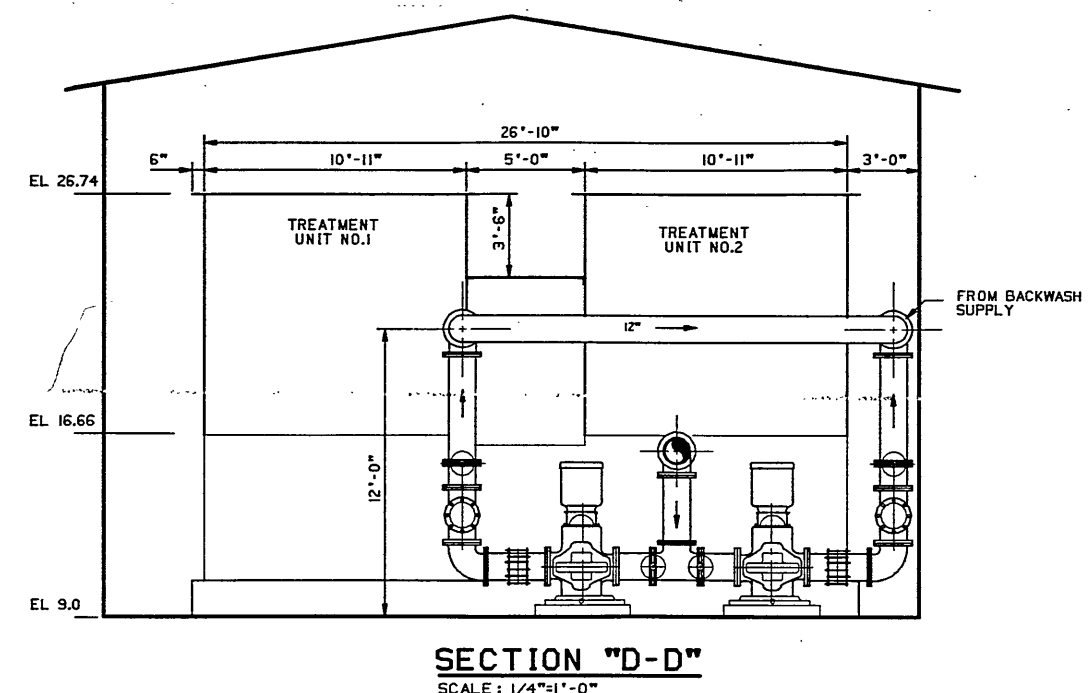

SECTION "D-D"
SCALE: 1/4"=1'-0"

REVISION	DATE	DESCRIPTION	BY	APP
DESIGNED	TSK	FALLING CREEK WATER PLANT CITY OF ROANOKE, VIRGINIA		
DRAWN	KSJ			
CHECKED				
APPROVED				
SUBMITTED				
HAYES, SEAY, MATTERN & MATTERN		SCALE	CONC.	
ARCHITECTS - ENGINEERS - PLANNERS		1/4"=1'-0"	NO.	4296
ROANOKE, VIRGINIA		DATE	SHEET	