

CHLORINE BUILDING DEMOLITION NOTES:

CIVIL

1. FOR EQUIPMENT AND APPURTENANCE REMOVAL, SEE DEMOLITION PLAN SHEET A3.

ARCHITECTURAL

2. REMOVE EXISTING DOORS AND HARDWARE AND PREPARE EXISTING SOUTHWEST FRAME TO RECEIVE NEW DOOR AND HARDWARE.
3. REMOVE EXISTING NORTHEAST DOOR FRAME AND PREPARE STONEWALL JAMBS FOR THE NEW WORK.
4. REMOVE COAL STOVE AND CHIMNEY AND PATCH OPENING.
5. REMOVE PORTION OF CONCRETE ROOF FOR NEW MECHANICAL WORK.
6. REMOVE CHLORINATOR VENTS AND PATCH OPENING.

ELECTRICAL

7. REMOVE APPROXIMATELY 2 RECEPTACLES, 3 LIGHT & FAN FIXTURES, 4 JUNCTION BOXES, 2 MOTORS, WIREWAY, FAN AND ALL WIRING AND CONDUIT.
8. FOR ELECTRICAL LEGEND, SEE SHEET E2.

CHEMICAL BUILDING DEMOLITION NOTES:

CIVIL




1. FOR EQUIPMENT AND APPURTENANCE REMOVAL, SEE DEMOLITION PLAN SHEET A3.

ARCHITECTURAL

2. REMOVE EXISTING DOOR AND HARDWARE AND PREPARE FRAME FOR NEW DOOR AND HARDWARE.
3. REMOVE COAL STOVE AND CHIMNEY COMPLETE AND PATCH OPENING.
4. REMOVE EXISTING WINDOWS AND PREPARE OPENINGS TO RECEIVE THE NEW WINDOWS.

ELECTRICAL

5. REMOVE APPROXIMATELY 3 RECEPTACLES, 4 LIGHT AND MOTOR SWITCHES, 1 DISCONNECT SWITCH, 3 LIGHTING FIXTURES, 1 MOTOR AND ALL WIRING AND CONDUIT.
6. FOR ELECTRICAL LEGEND, SEE SHEET E2.

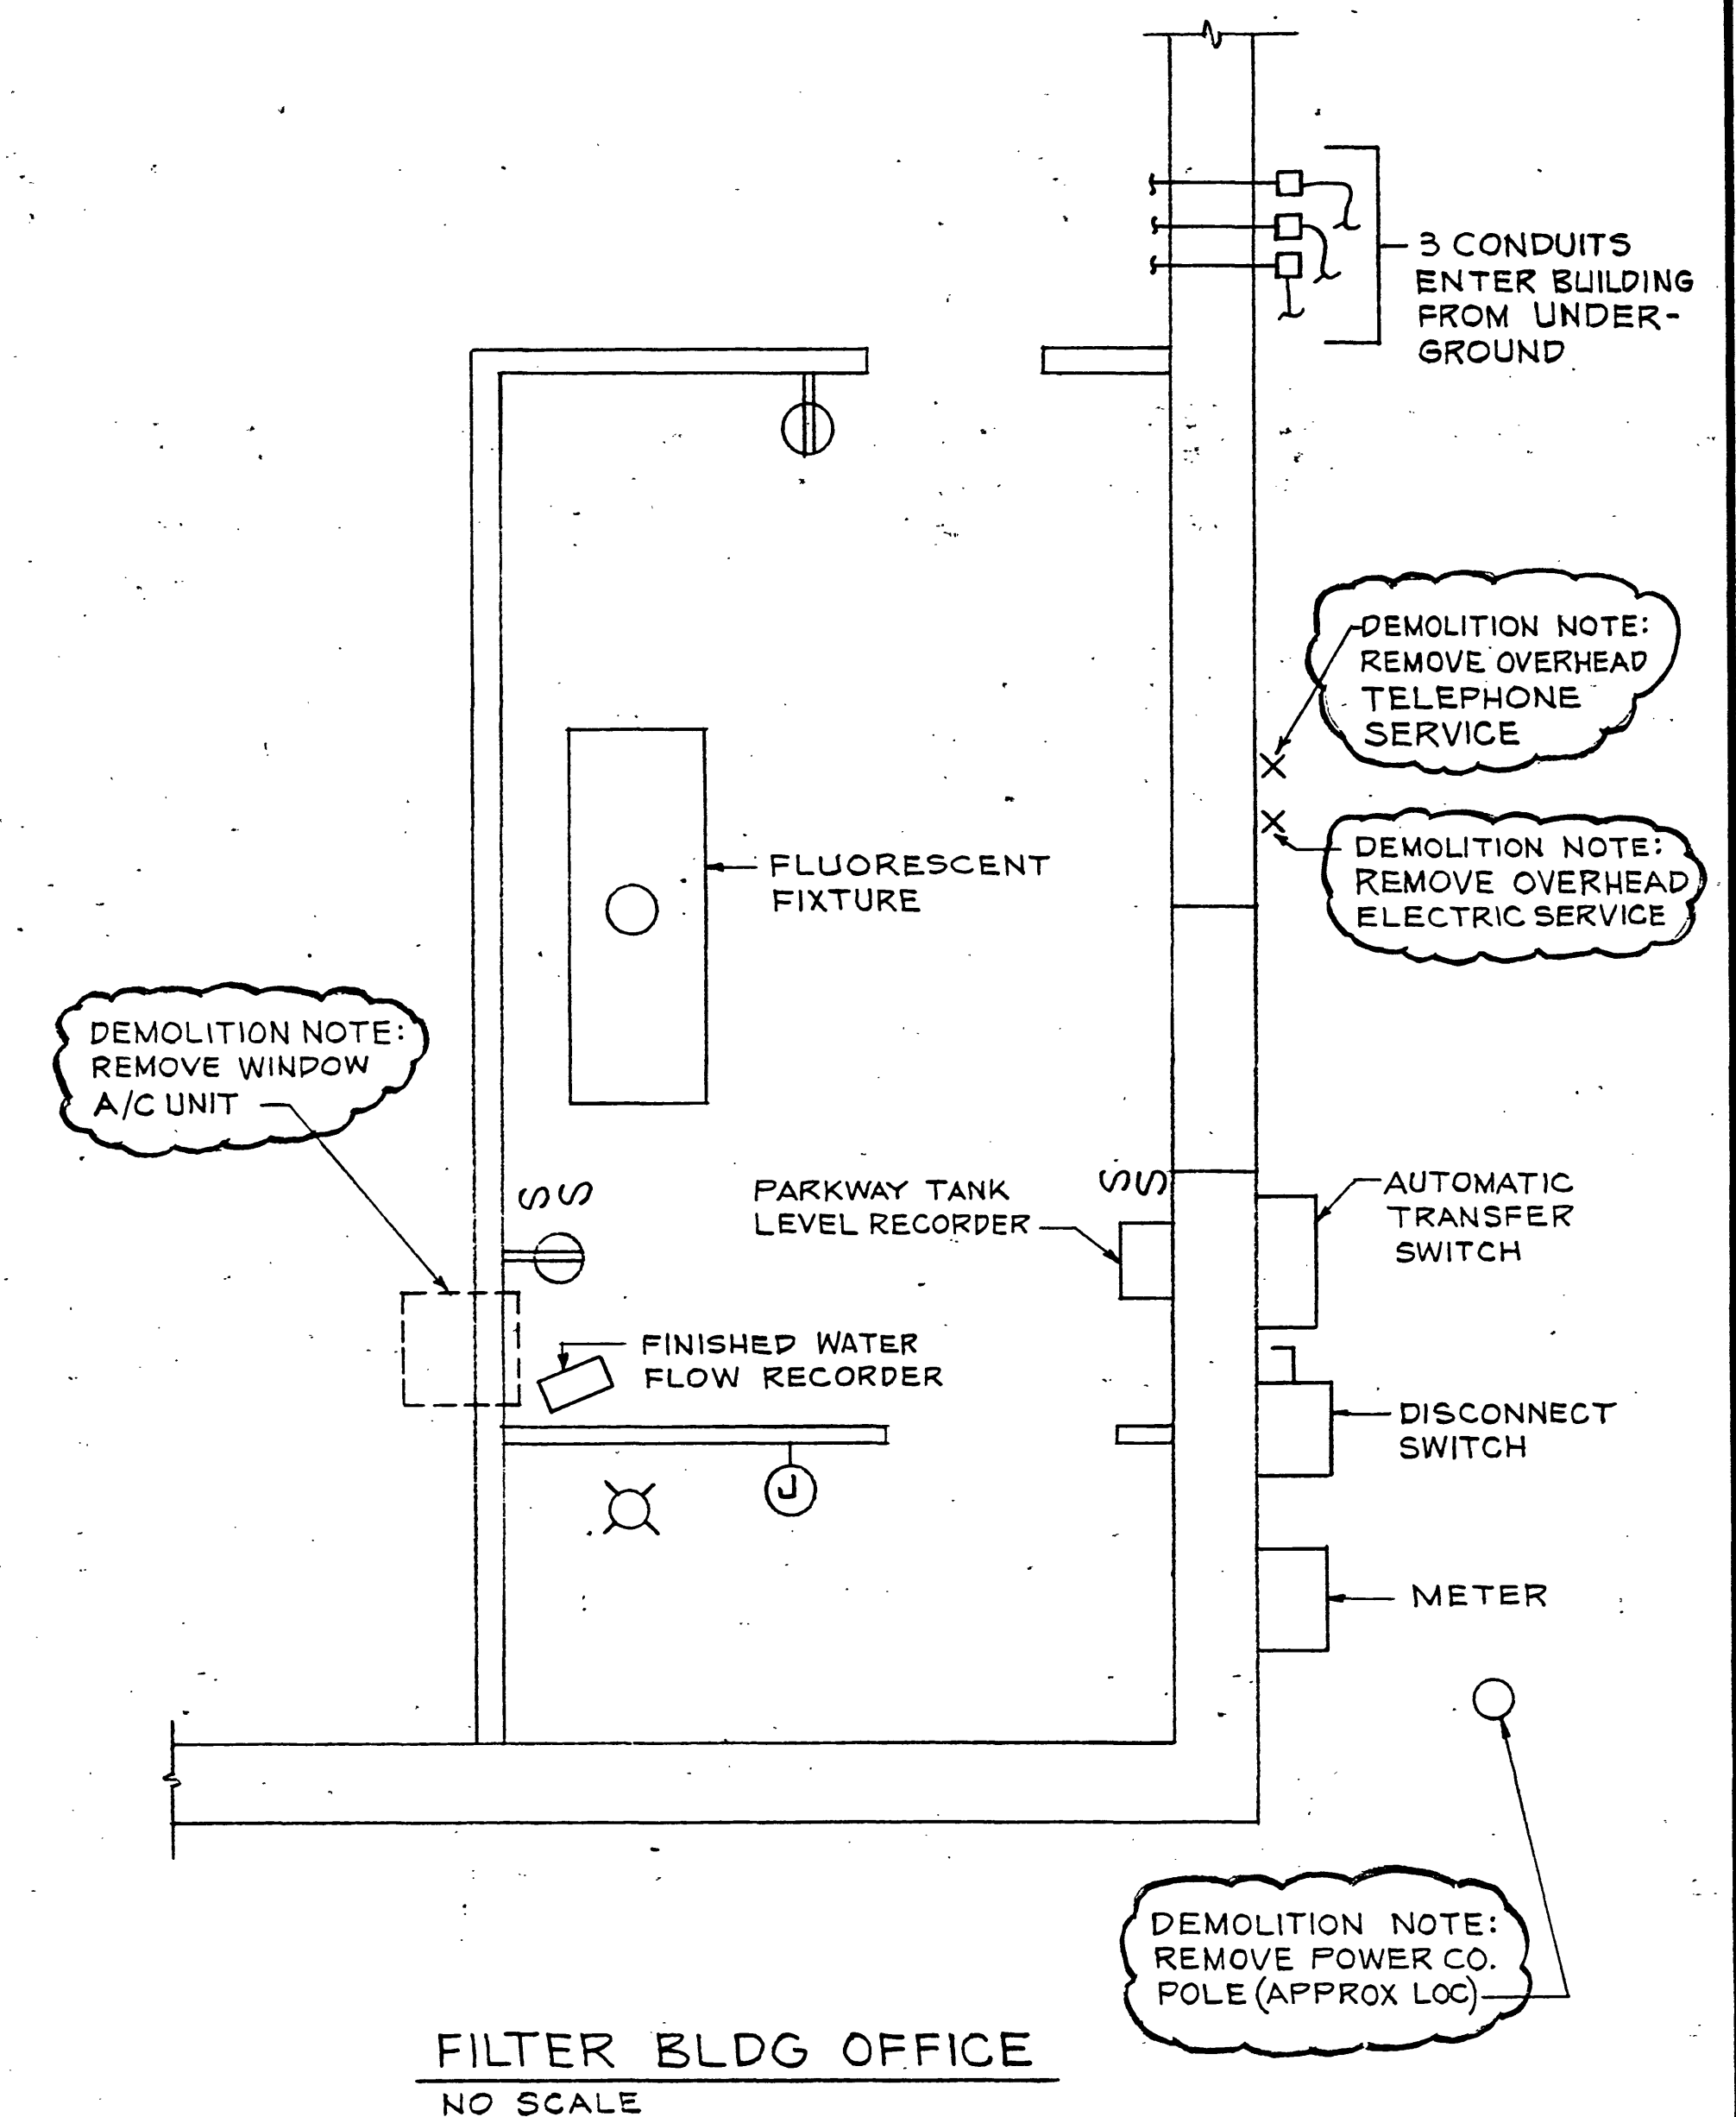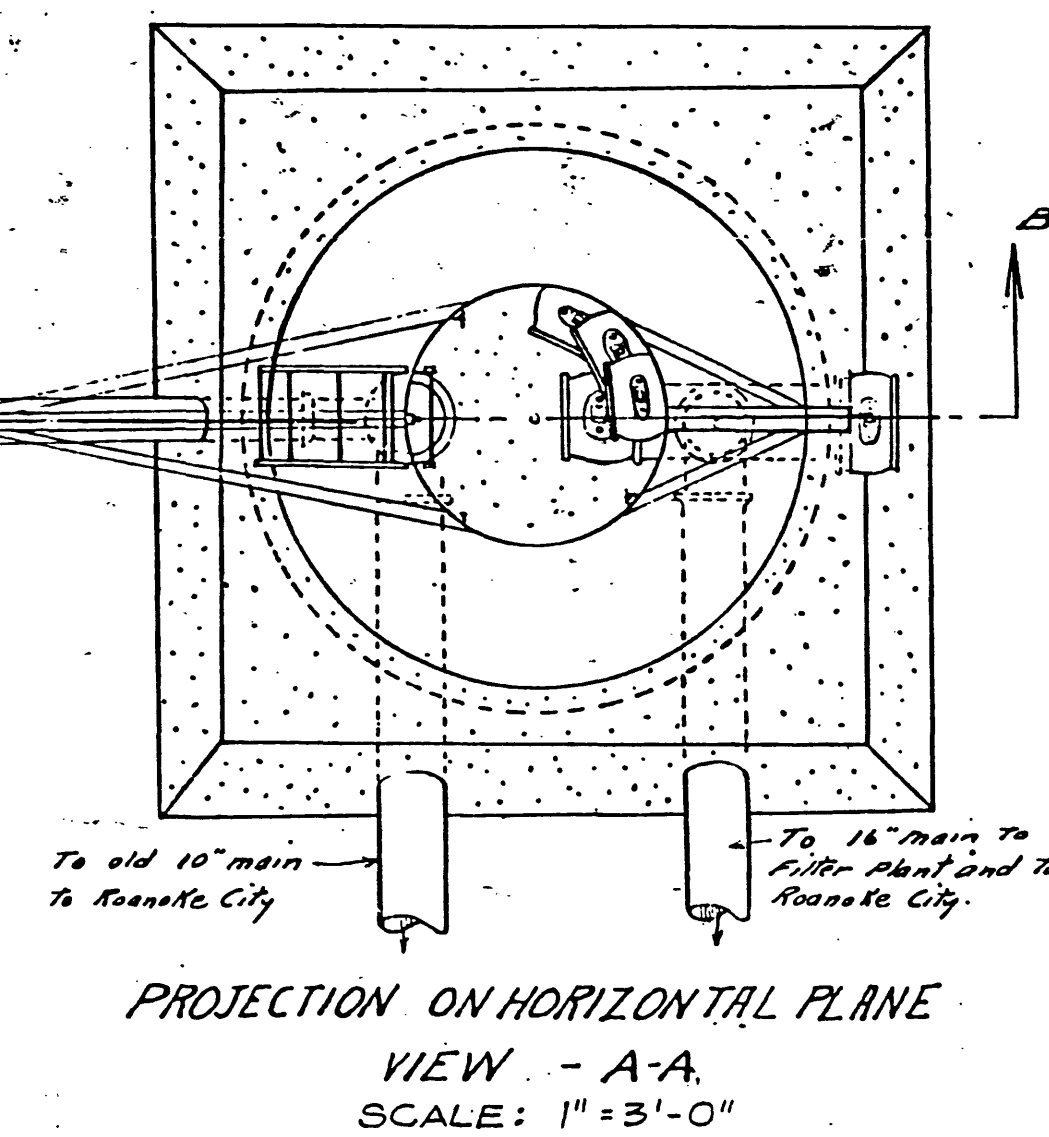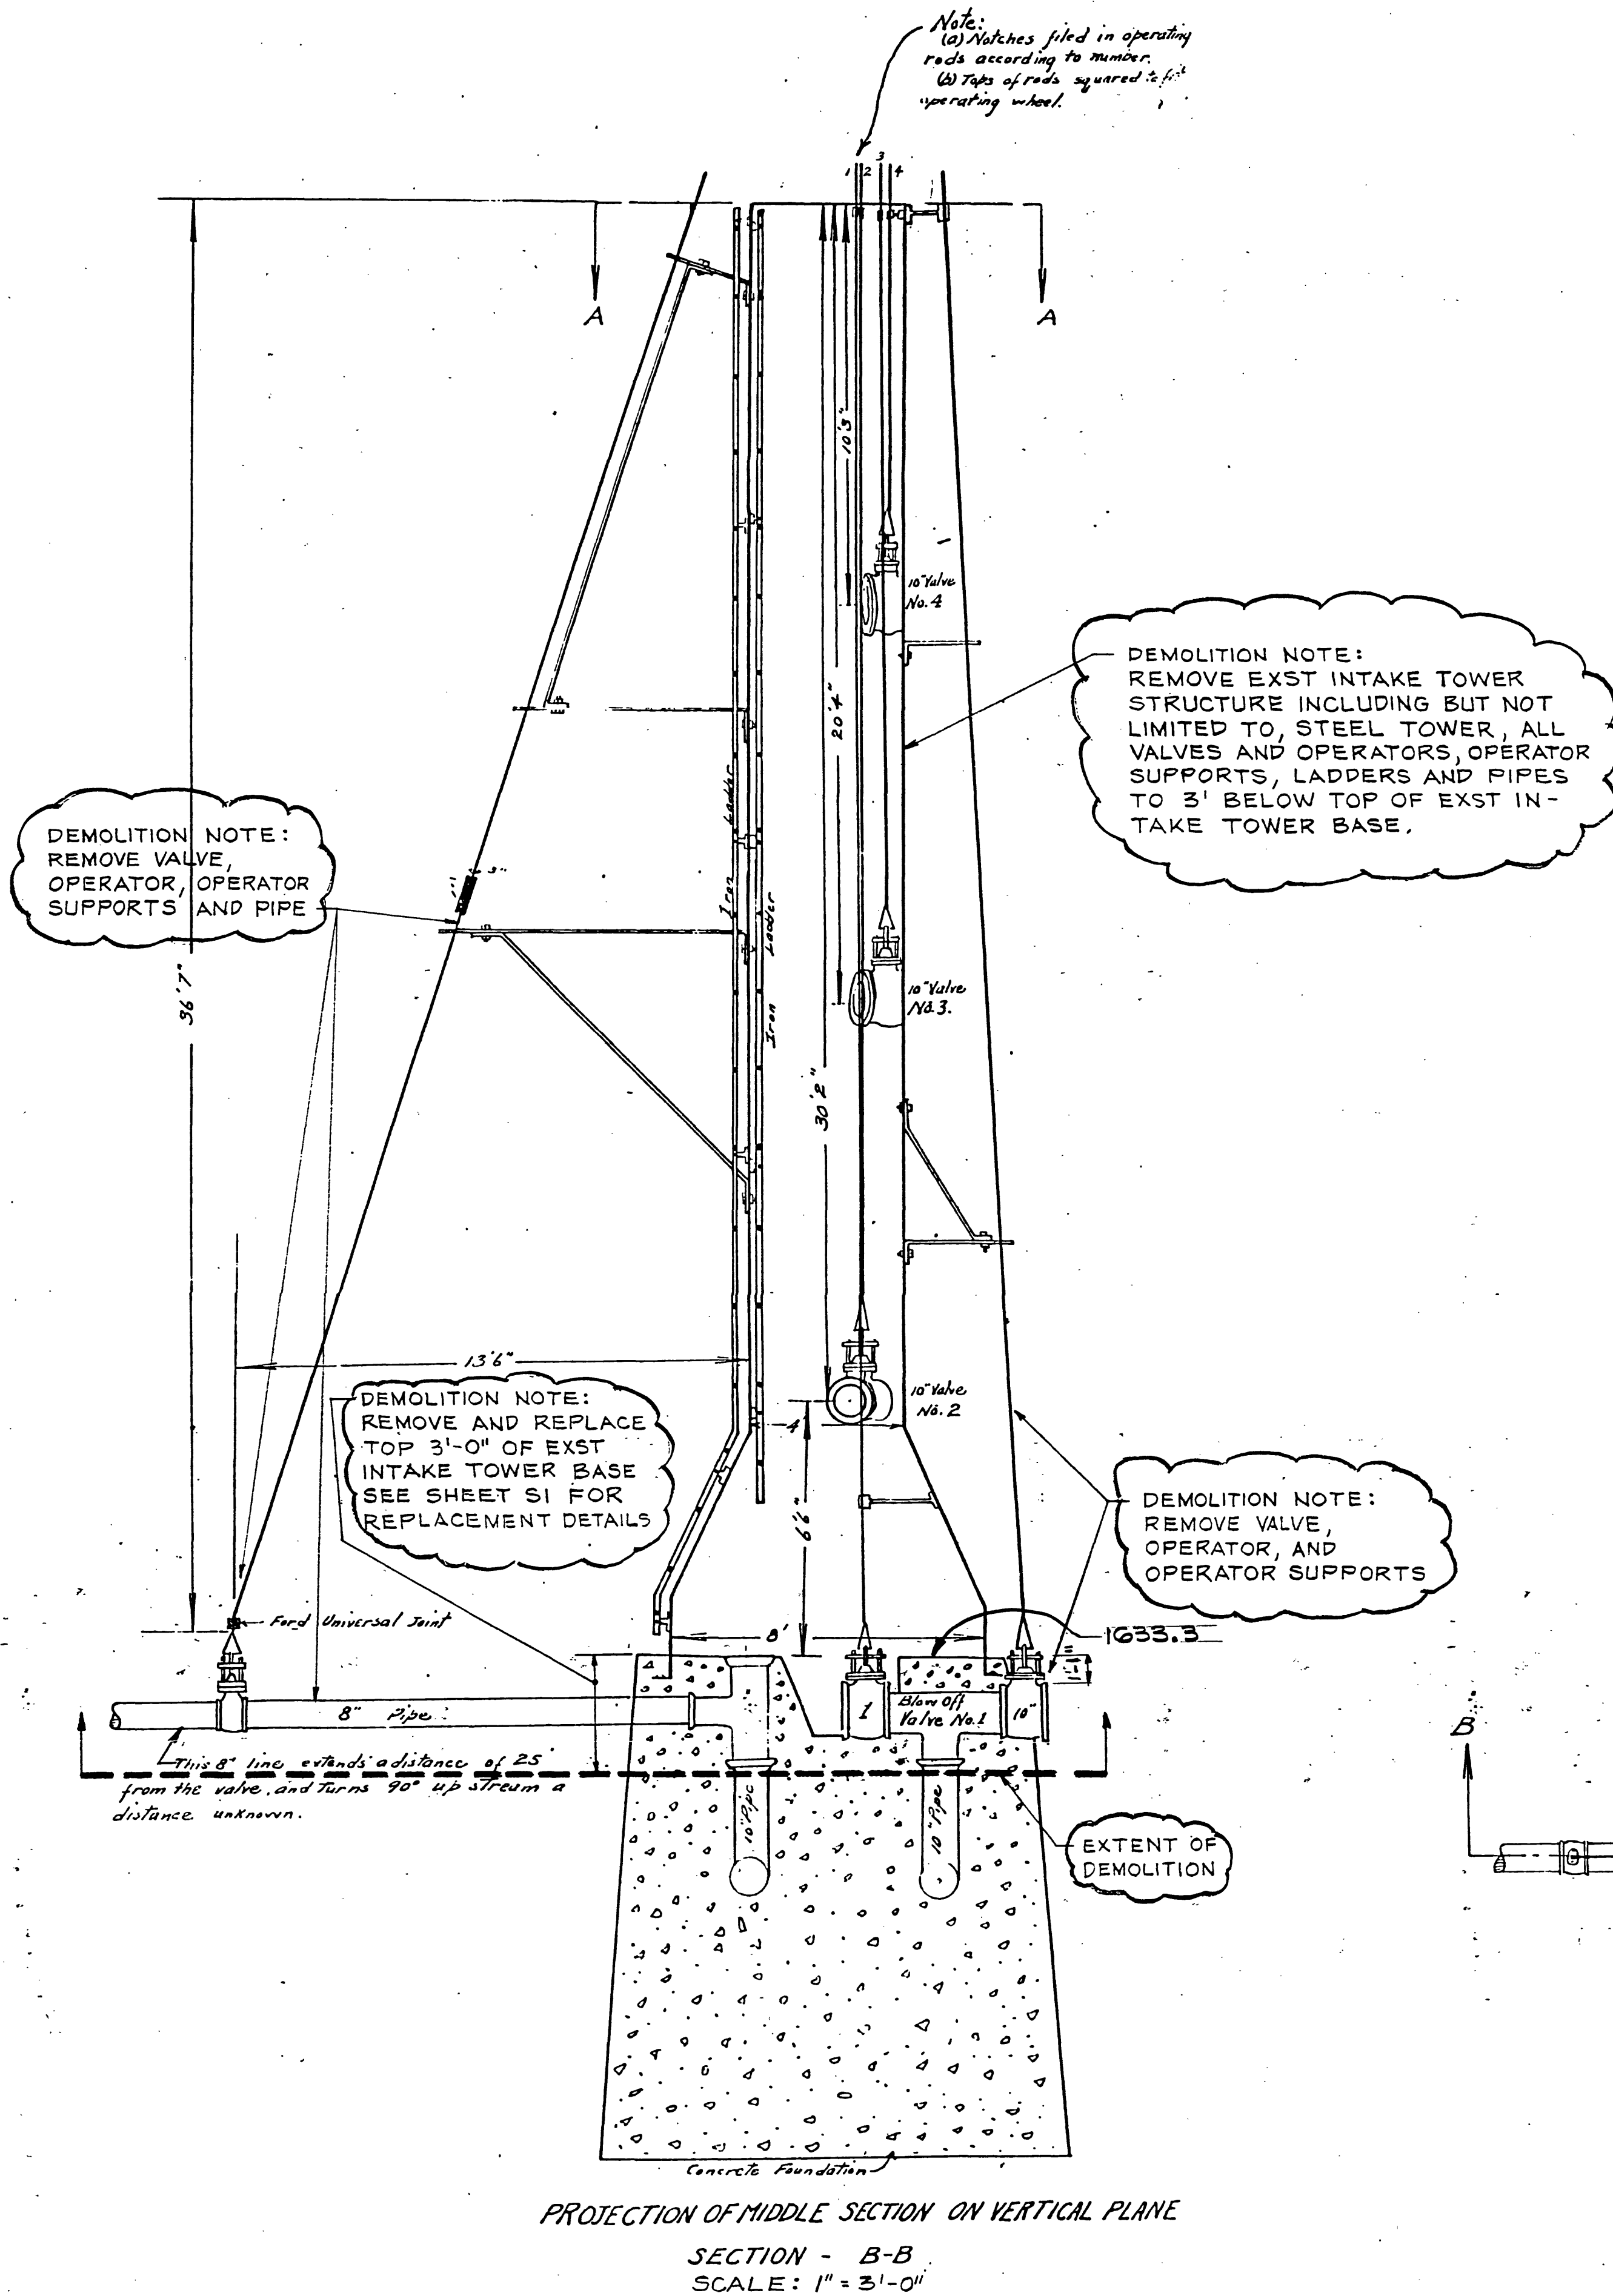

FILTER BLDG OFFICE DEMOLITION NOTE:

CIVIL

1. REMOVE PARKWAY TANK CIRCULAR PEN LEVEL RECORDER AND FINISHED WATER FLOW RECORDER. TRANSMITTER WIRING SHALL BE RECONNECTED TO NEW RECEIVERS.


ARCHITECTURAL

2. REMOVE DOORS, WINDOWS, AND FRAMES COMPLETE.
3. REMOVE PARTITIONS, FLOORS, CEILING, AND OFFICE LEVEL STRUCTURE AND SUPPORTS DOWN TO LOWER LEVEL FLOOR SLAB OR TOP OF STONEWALLS.
4. SEE GENERAL NOTE ON SHEET P2 FOR DEMOLITION OF ROOF AND ENDWALLS.

ELECTRICAL

5. REMOVE APPROX 2 RECEPTACLES, 4 LIGHT SWITCHES, 2 LIGHTING FIXTURES, 1 JUNCTION BOX, 1 THRU THE WALL A/C UNIT AND ALL WIRING AND CONDUIT.

STACK
AT FALLING CREEK RESERVOIR, BEDFORD COUNTY, VIRGINIA.
FROM DATA AVAILABLE AFTER COMPLETION OF WORK OF THE DEEP SEA DIVER.
ROANOKE WATER WORKS COMPANY — ROANOKE, VIRGINIA, OCTOBER 9, 1931.
DRAWN & TRACED BY — H.M. HARRIS, DRAFTSMAN.

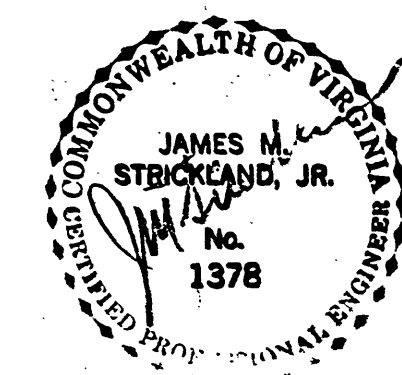

8/93 RECORD DRAWING			
REVISION	DATE	DESCRIPTION	BY APP
DESIGNED	TSK		
DRAWN	RLA		
CHECKED	MD		
APPROVED	J.P.		
SUBMITTED	RL		
FALLING CREEK WATER PLANT CITY OF ROANOKE, VIRGINIA			
DEMOLITION VALVE TOWER AND FILTER BLDG OFFICE			
HAYES, SEAY, MATTERN & MATTERN ARCHITECTS - ENGINEERS - PLANNERS ROANOKE, VIRGINIA		SCALE AS SHOWN	COMM. NO. 4296 DATE 30 MAY 1989 SHEET D1