




PROFILE	BY	DATE
SURVEYED		
PLOTTED		
GRADES CHECKED		
B. M.'s NOTED		

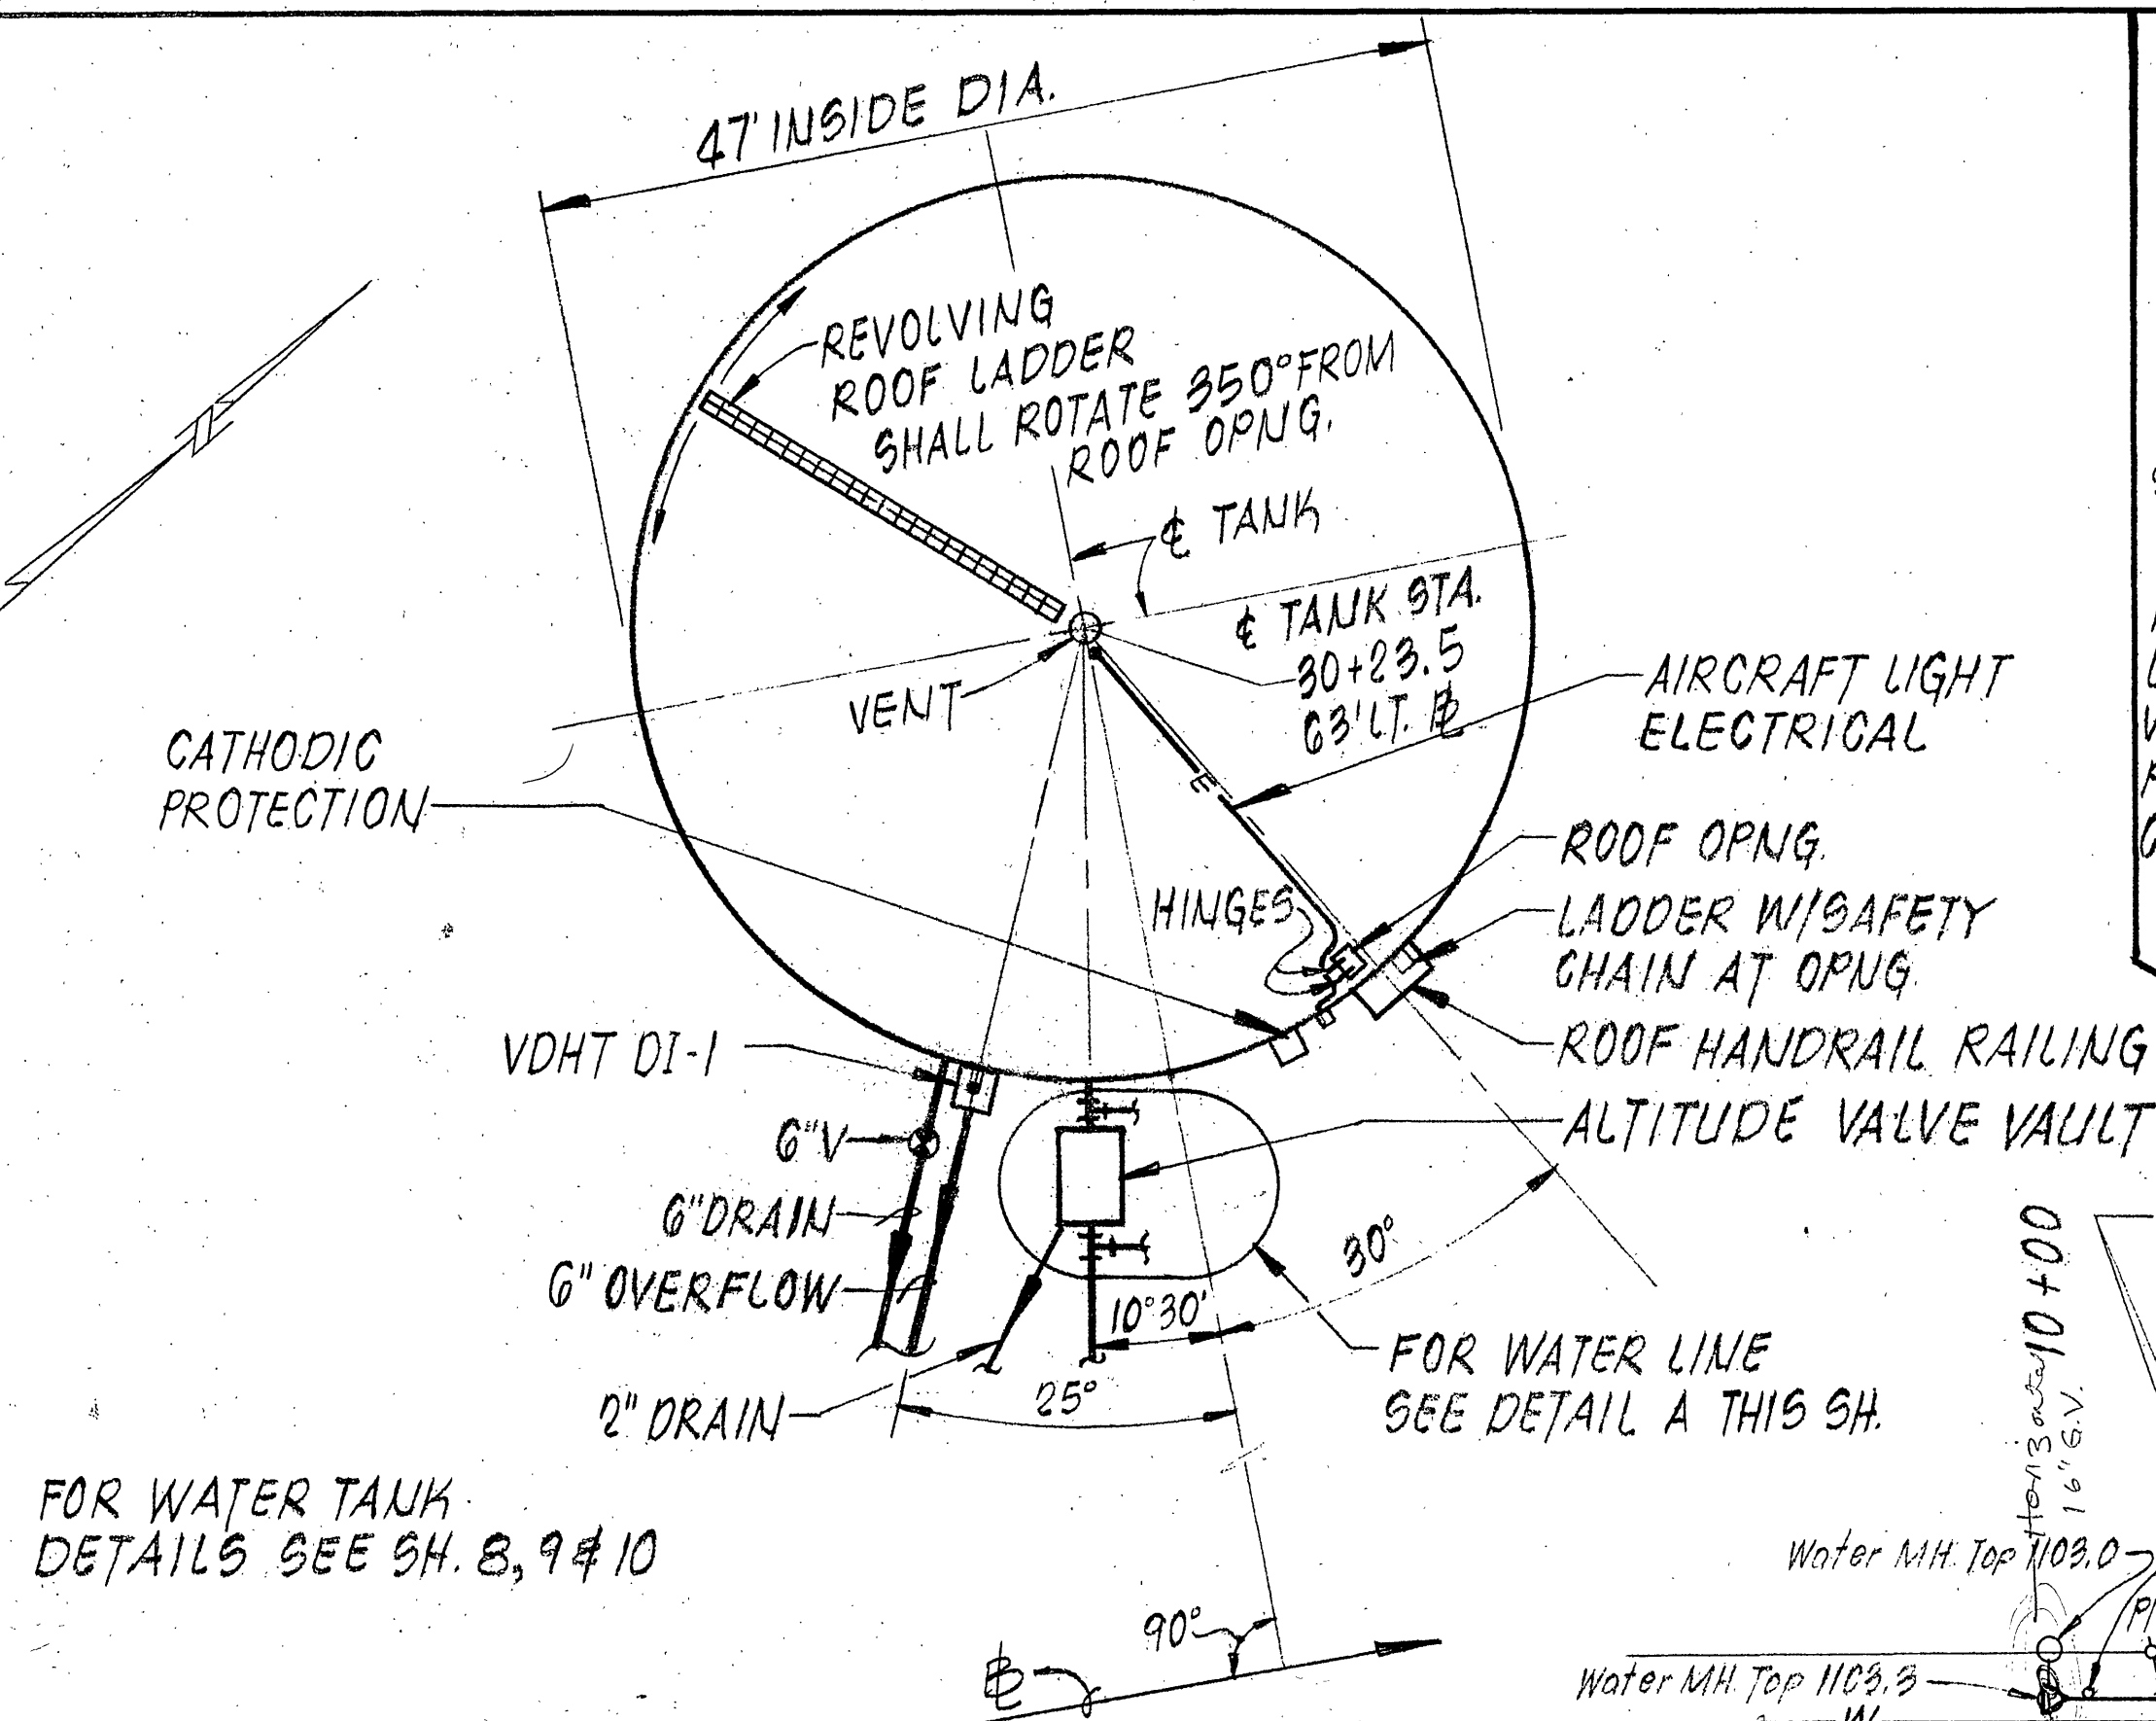


WATER TANK ROOF PLAN
NO SCALE

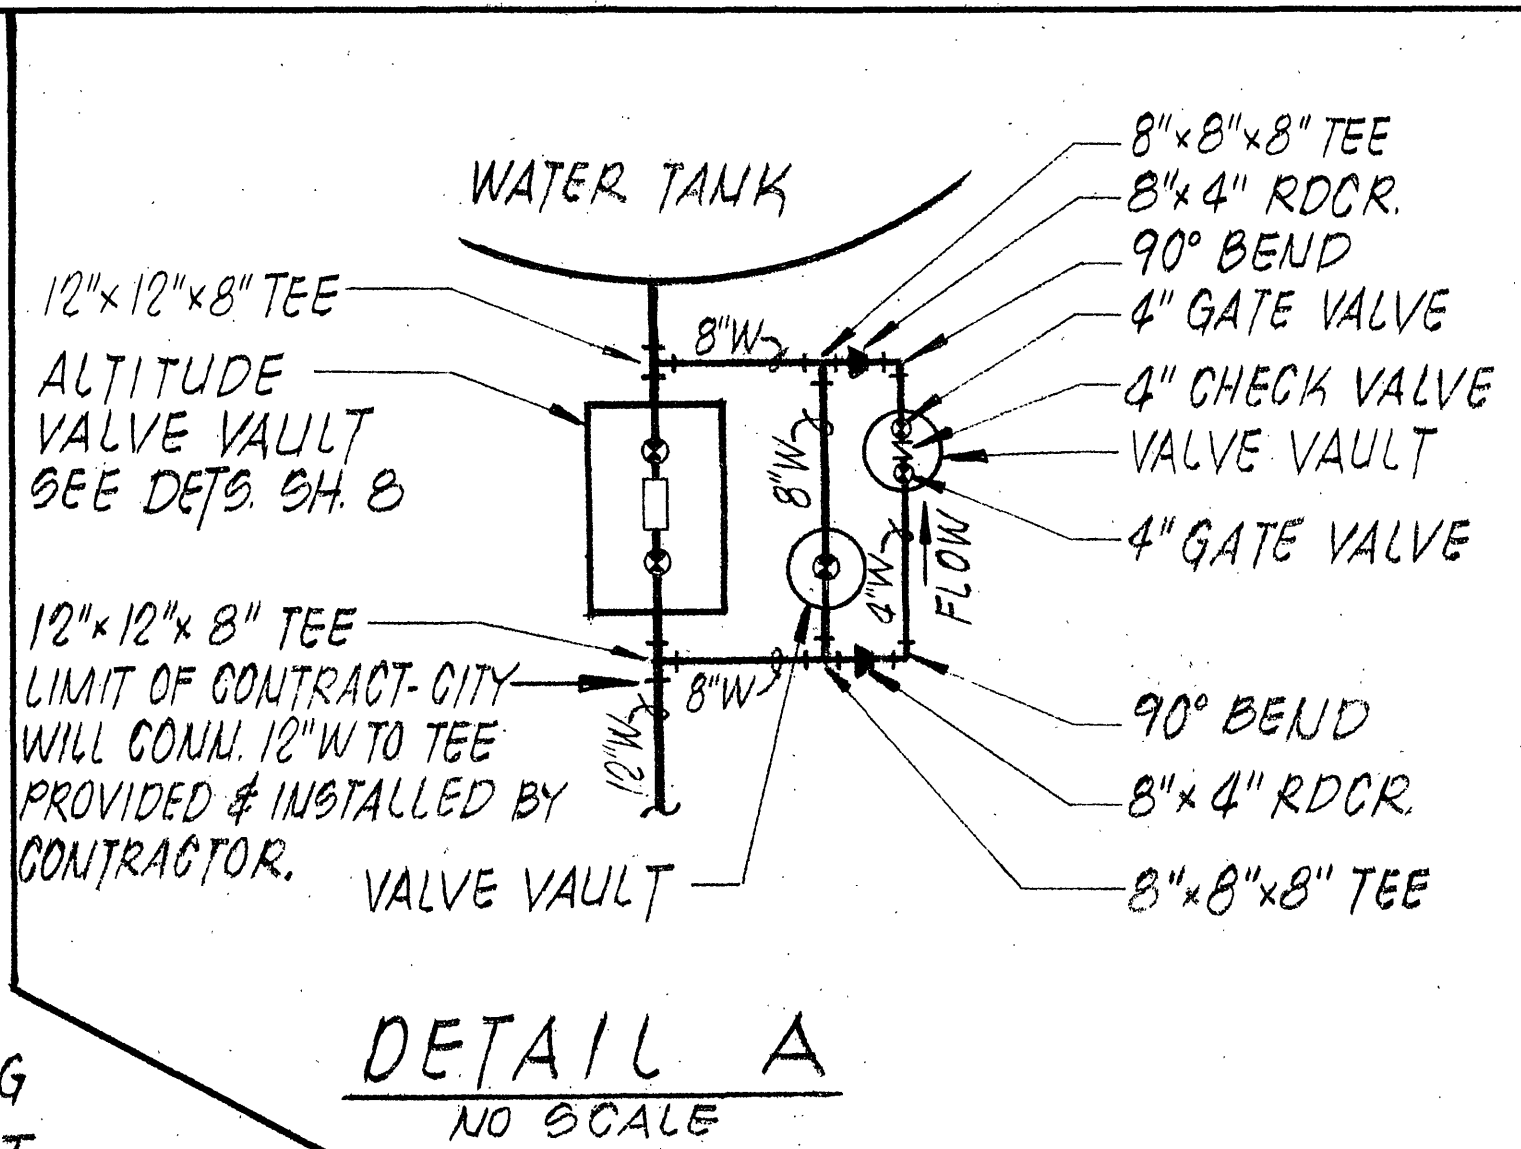


DETAIL A
NO SCALE

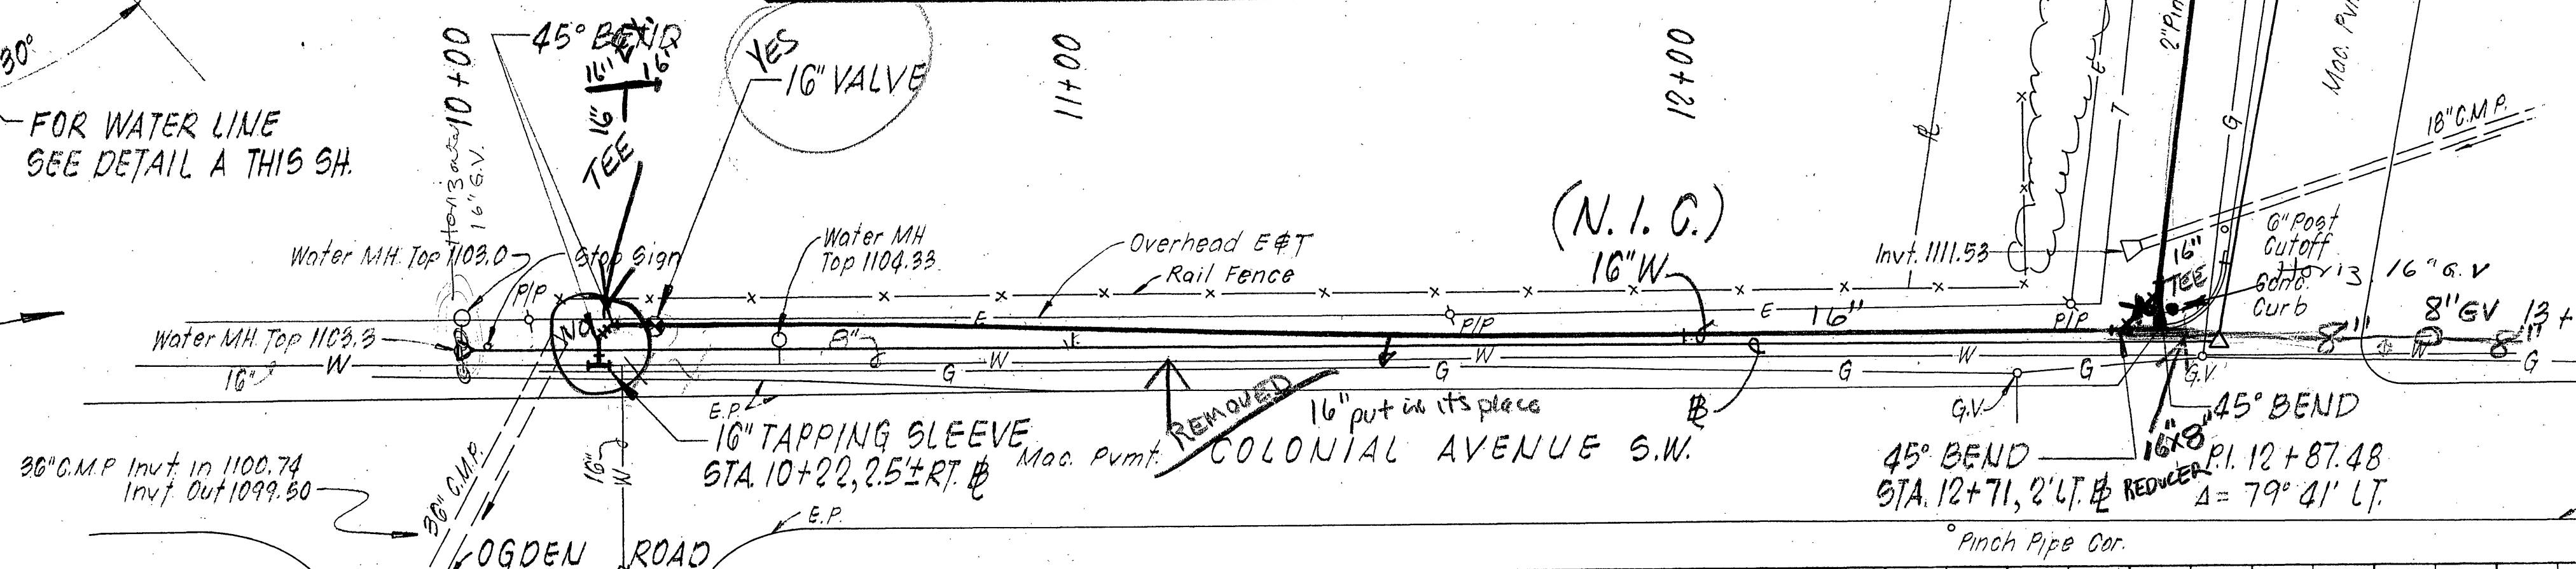

W.L. LOCATION CHART	
STA.	OFFSET
11+00	3 LT. E
11+62	1.5' LT. E
12+00	1.5' LT. E
13+50	15' LT. E

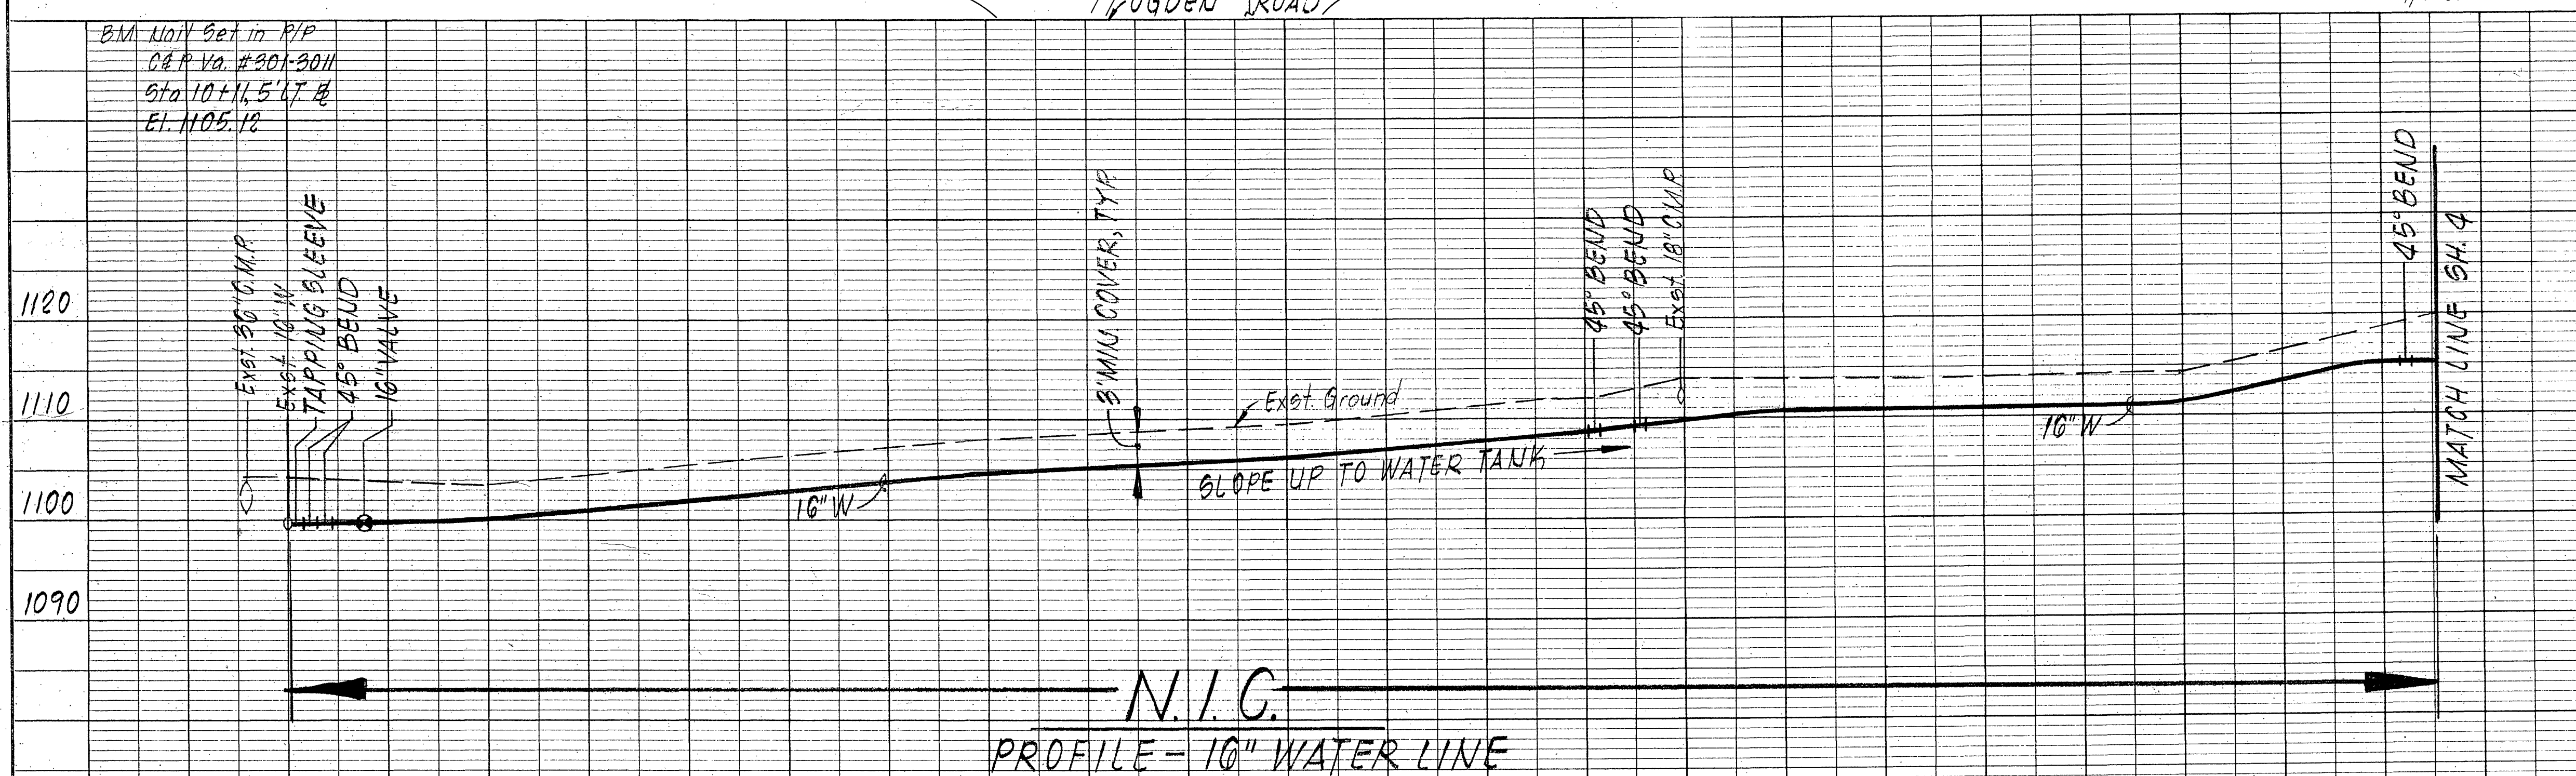

NOTE: WATER LINE BET STA 10+00 & 14+50 N.Y.C.

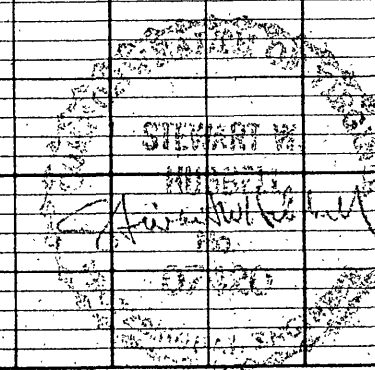

Scale: Horz. $1'' = 20'$
Vert. $1'' = 10'$

REVISION	DATE	DESCRIPTION	BY	APP
DESIGNED	<i>PSM</i>	GRANDIN COURT WATER TANK #3		
DRAWN	<i>RSW</i>			
CHECKED	<i>SWH</i>			
APPROVED				
SUBMITTED	<i>SWH</i>			
Mattern and Craig CONSULTING ENGINEERS ROANOKE, VIRGINIA			SCALE: NOTED DATE: MAY 1984	COMM. NO. 470 SHEET 3