

 


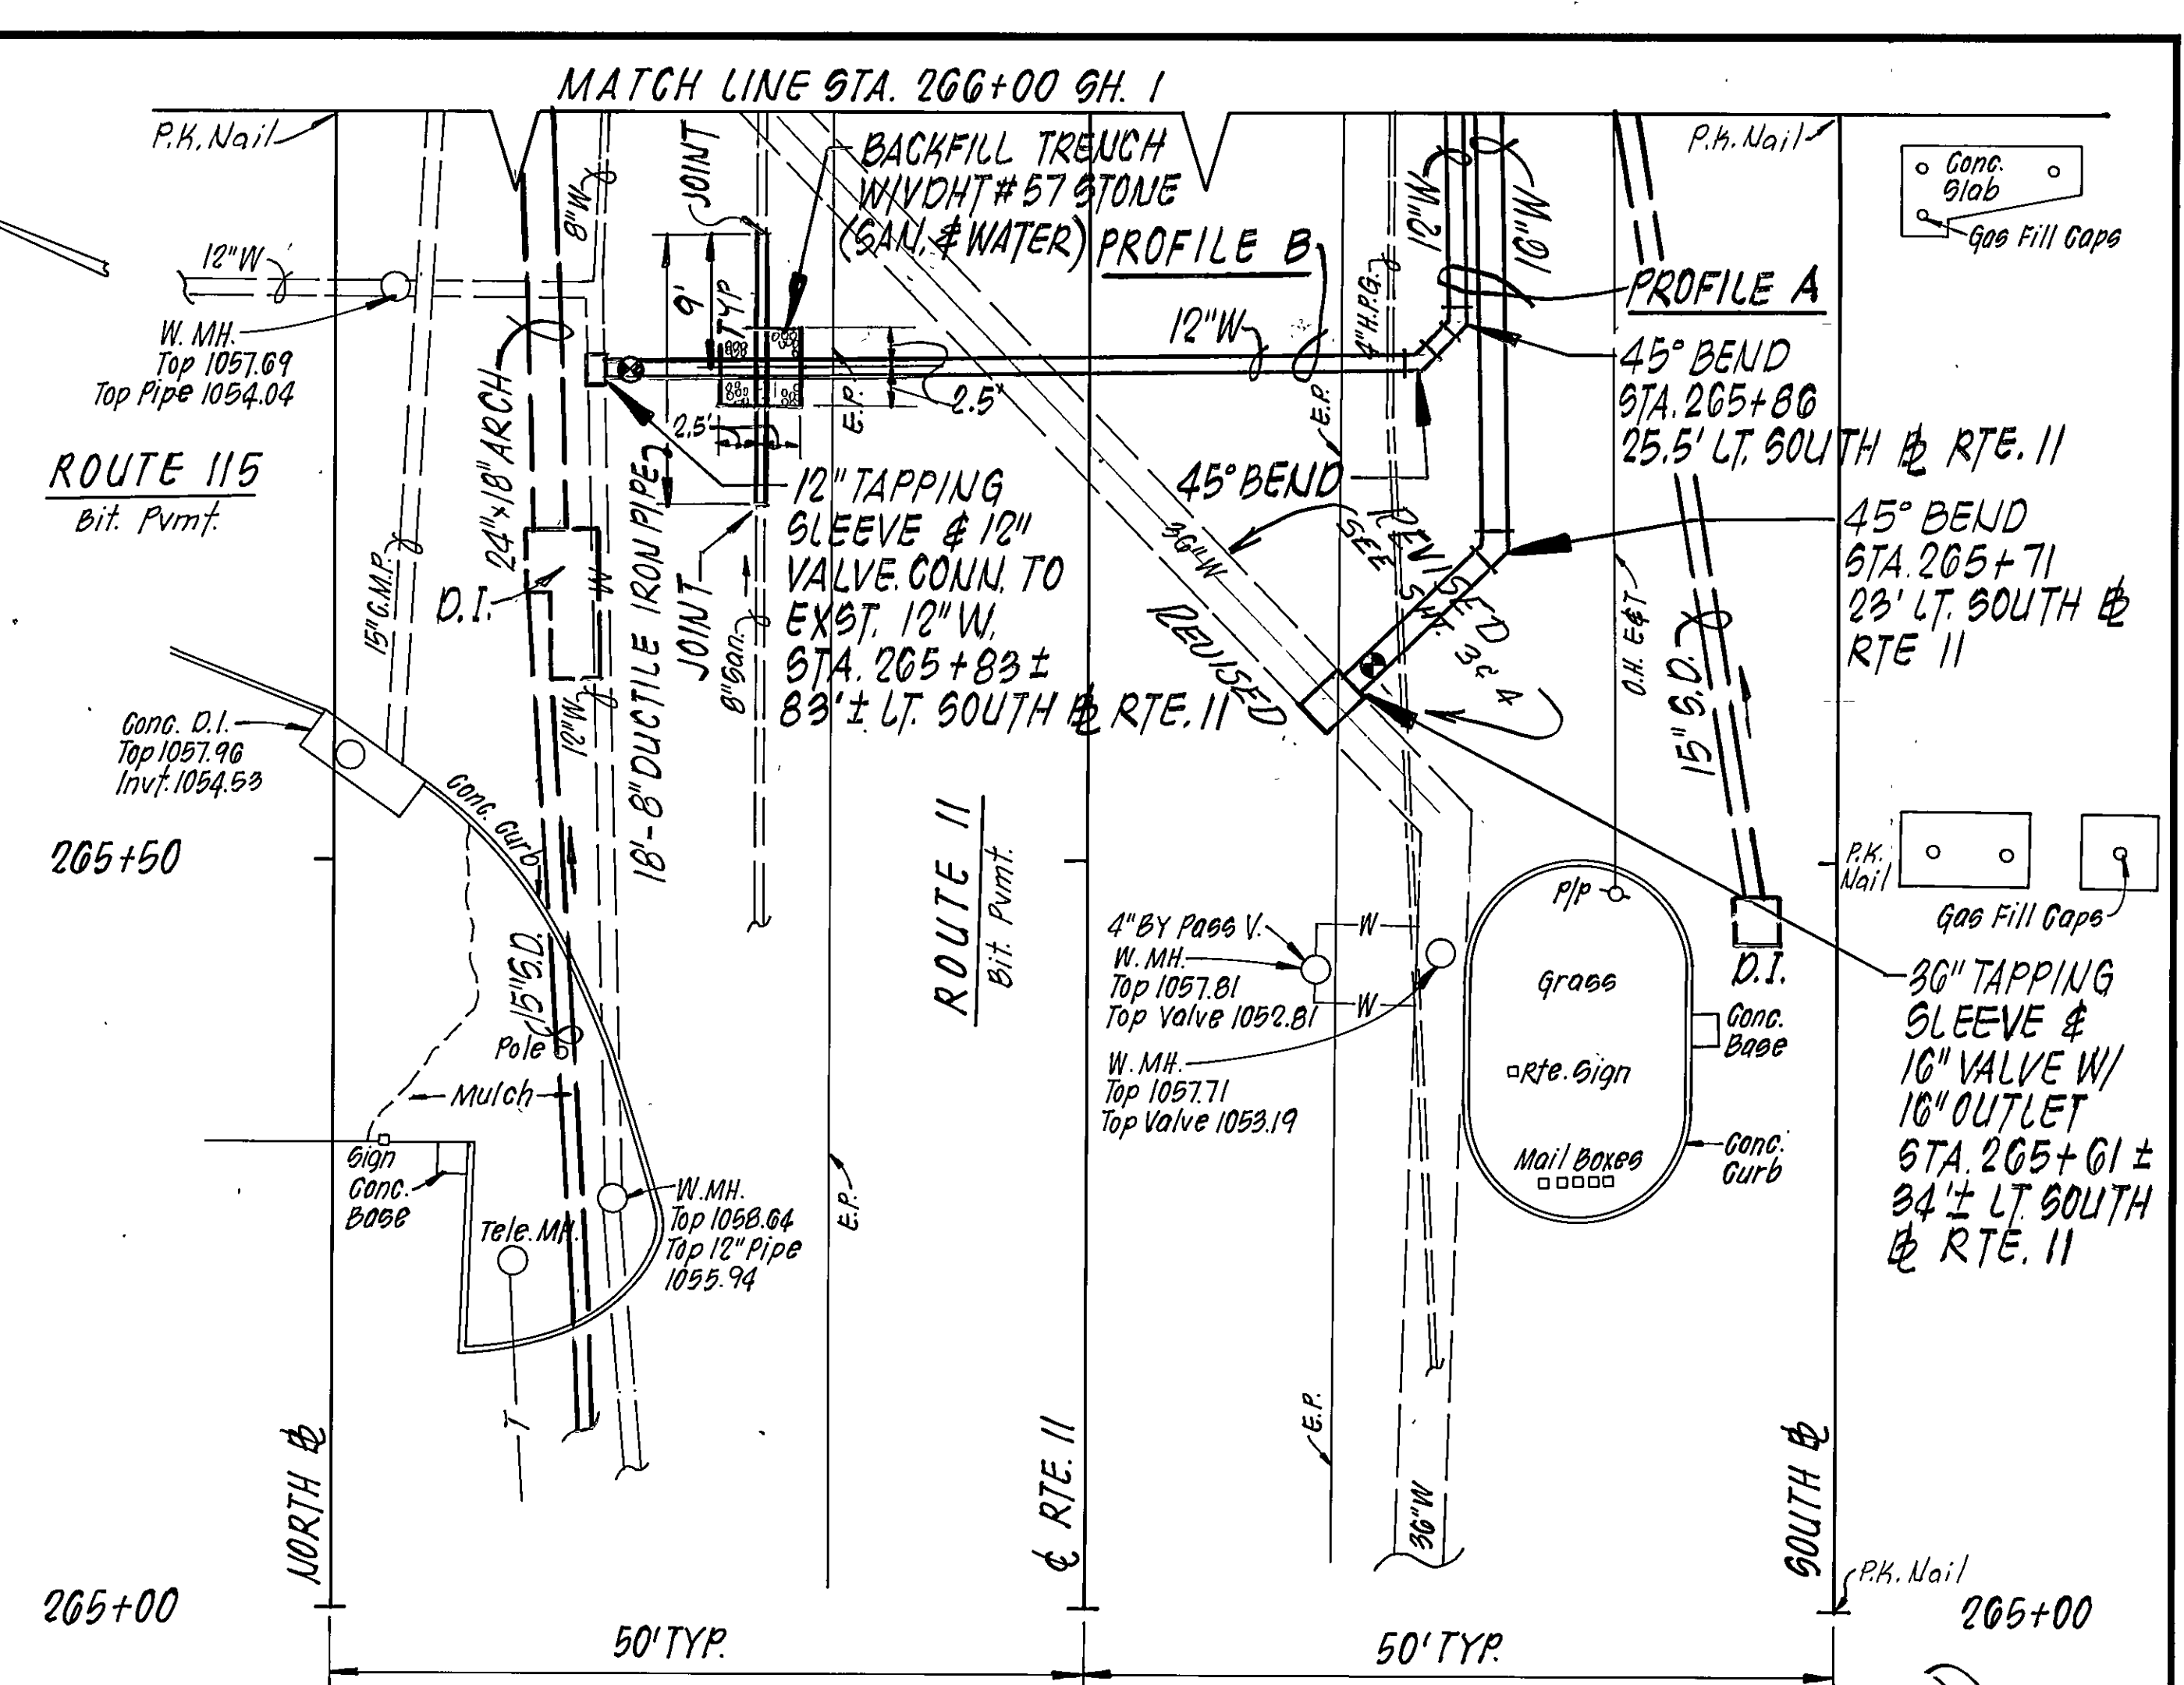

PROFILE A (CONT.)-16" WATER
(DISCHARGE) LINE

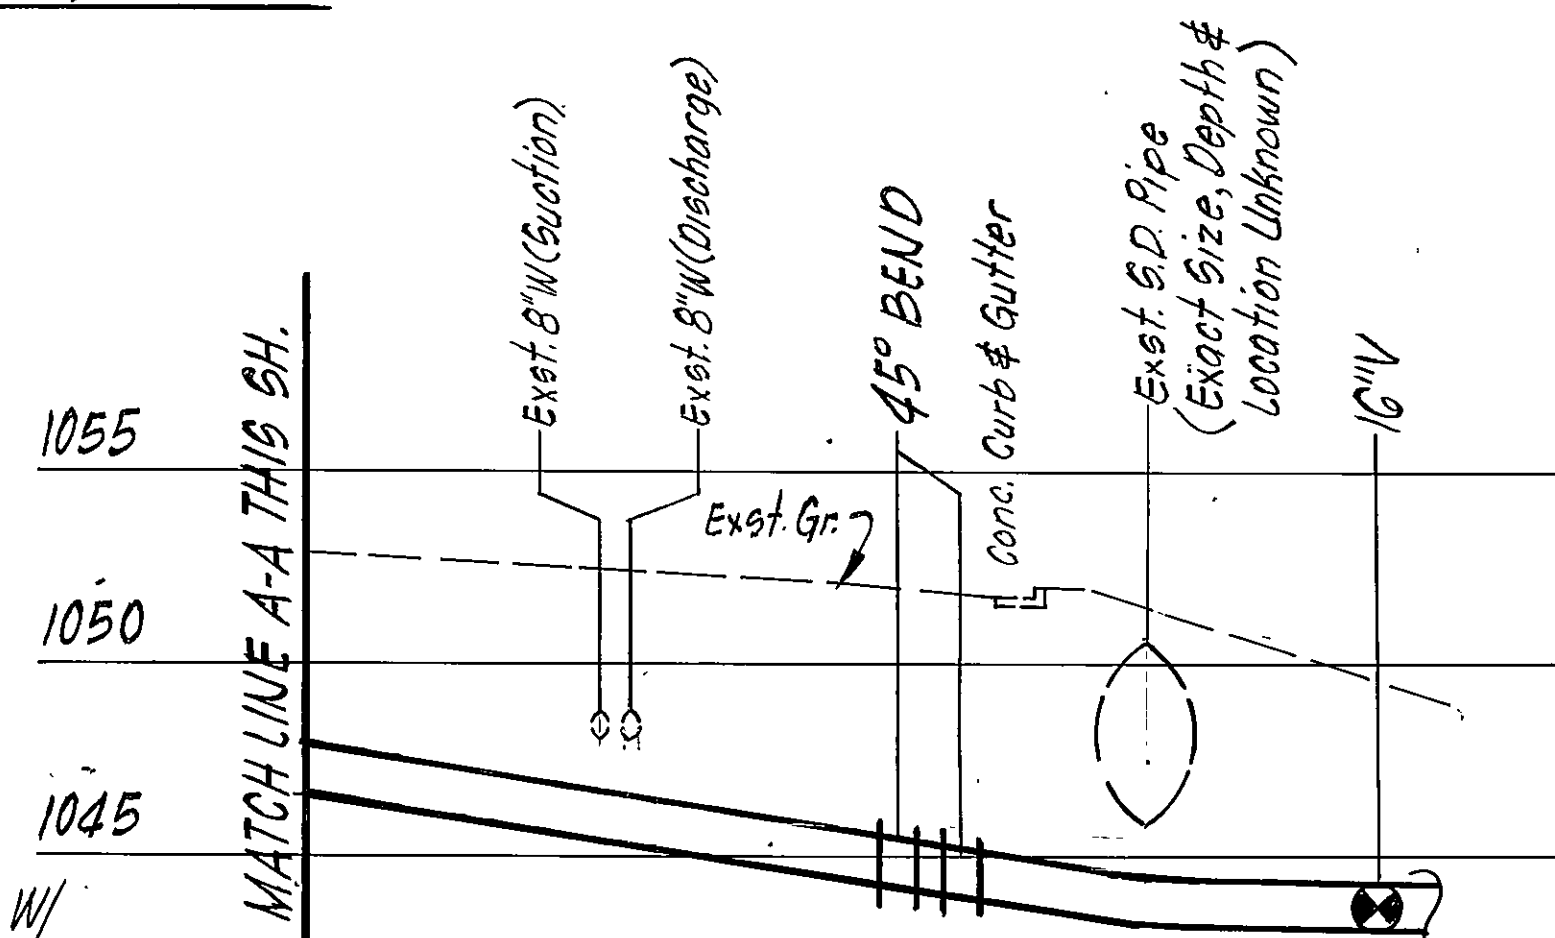

45° BEND/16"
 SUCTION & 12"
 DISCHARGE)
 45° BEND/16"
 SUCTION & 12"
 DISCHARGE
 12" x 12" x 12" TEE (12" DISCHARGE)
 ONLY-SEE PROFILE
 16" x 12" REDUCER
 (DISCHARGE ONLY)



SCALE: HORZ. 1"=10'
VERT. 1"=5'

REVISION	DATE	DESCRIPTION	BY	APP.	
DESIGNED	BSM	PLANTATION ROAD WATER LINE / HOLLINS PUMPING STATION <u>PLAN AND PROFILE</u> CITY OF ROANOKE			
DRAWN	BSM				
CHECKED	SWA				
APPROVED					
SUBMITTED					

PROJECT NO 84-08 Proposal - Not all was installed this way