


PROJECT LOCATION MAP

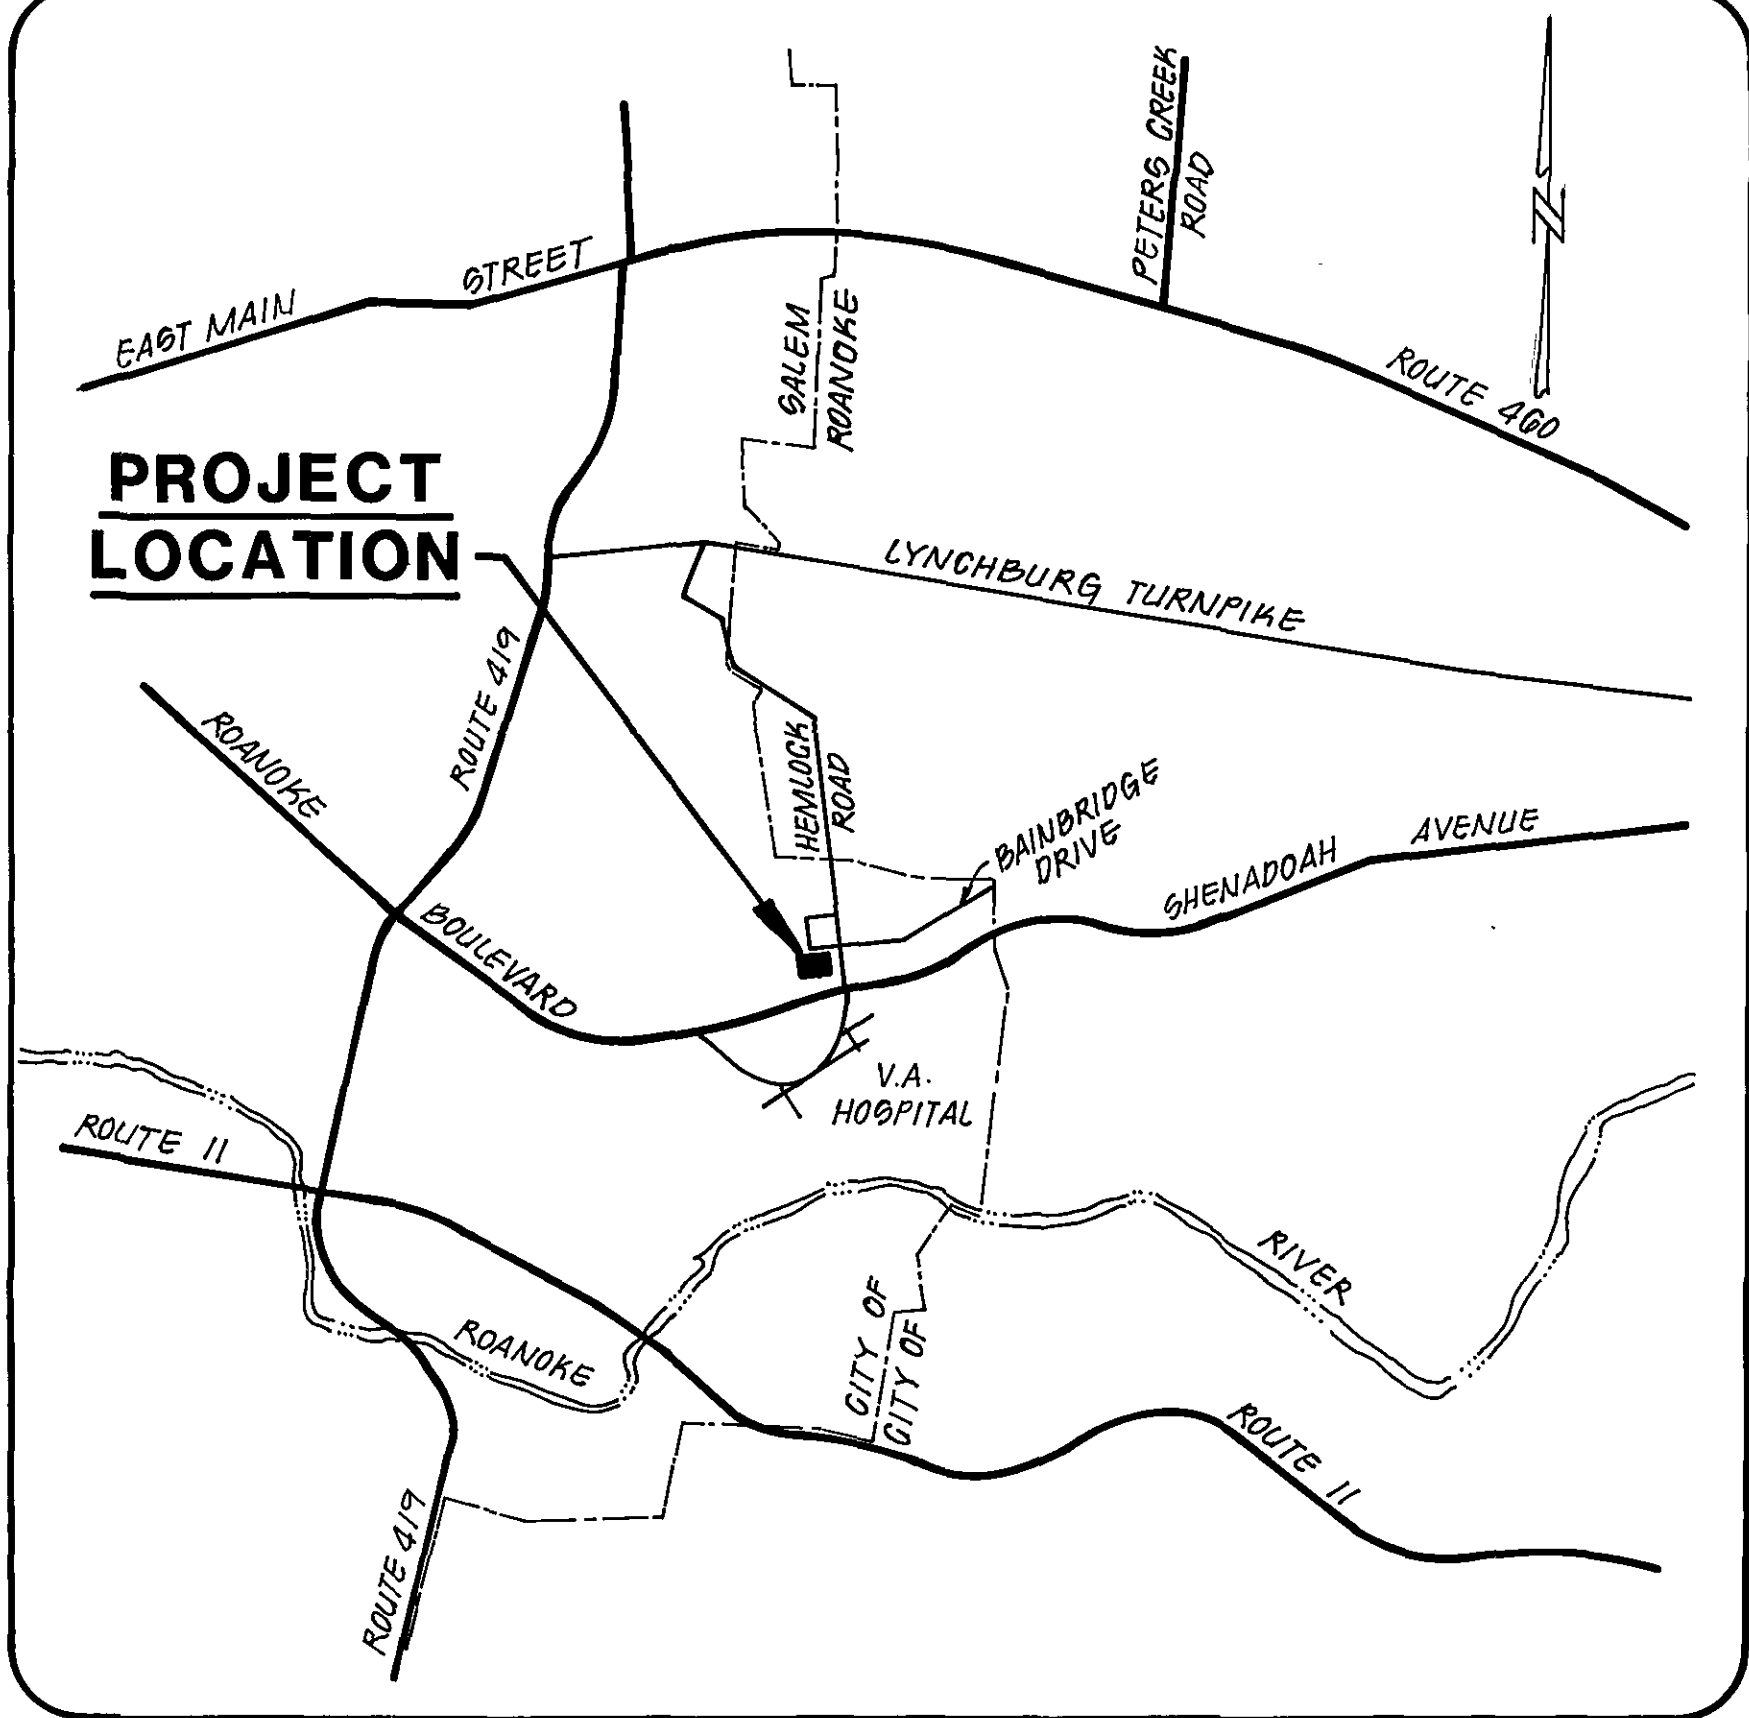

OFFICE OF CITY ENGINEER
ROOM 350
MUNICIPAL BUILDING
215 CHURCH AVENUE, S.W.
ROANOKE, VIRGINIA 24011


INDEX OF SHEETS

SHEET NUMBER	TITLE
1	COVER SHEET
2	ABBREVIATIONS
3	LEGEND
4	GENERAL NOTES
5	SITE PLAN
6	ARCHITECTURAL PLAN
7	ARCHITECTURAL DETAIL
8	PIPING AND EQUIPMENT PLAN
9	SECTIONS
	MECHANICAL PLAN
	ELECTRICAL PLAN

CONSULTING ENGINEERS

MATTERN AND CRAIG
CONSULTING ENGINEERS
ROANOKE, VIRGINIA

COMMISSION NUMBER: **566**

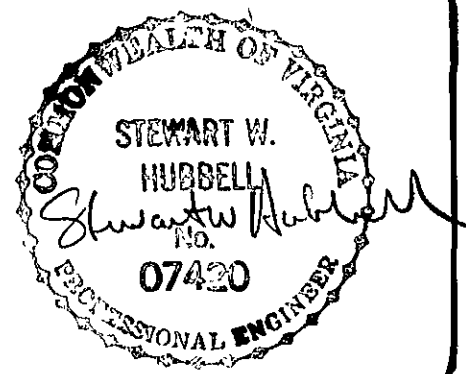

PROJECT NAME

ROANOKE CITY - SALEM
INTERCONNECT PUMPING STATION

PROJECT NUMBER **85-14**

REVISION	BY	DESCRIPTION	DATE
REVISION	BY	DESCRIPTION	DATE
REVISION	BY	DESCRIPTION	DATE
REVISION	BY	DESCRIPTION	DATE

APPROVED FOR CONSTRUCTION

<i>Charles M. Hill</i> ROANOKE CITY ENGINEER	<u>9/18/86</u> DATE
<i>William J. Clark</i> DIRECTOR OF PUBLIC WORKS	<u>9-25-86</u> DATE
<i>St. B. Lin</i> DIRECTOR OF UTILITIES AND OPERATIONS	<u>9/18/86</u> DATE
<i>John D. Abbott</i> SALEM CITY ENGINEER	<u>9/22/86</u> DATE
	DATE

ADVERTISED DATE: **NOV. 23, 1986**

SET NUMBER: _____

SHEET NUMBER **1** OF **9**

RECORD DRAWING