
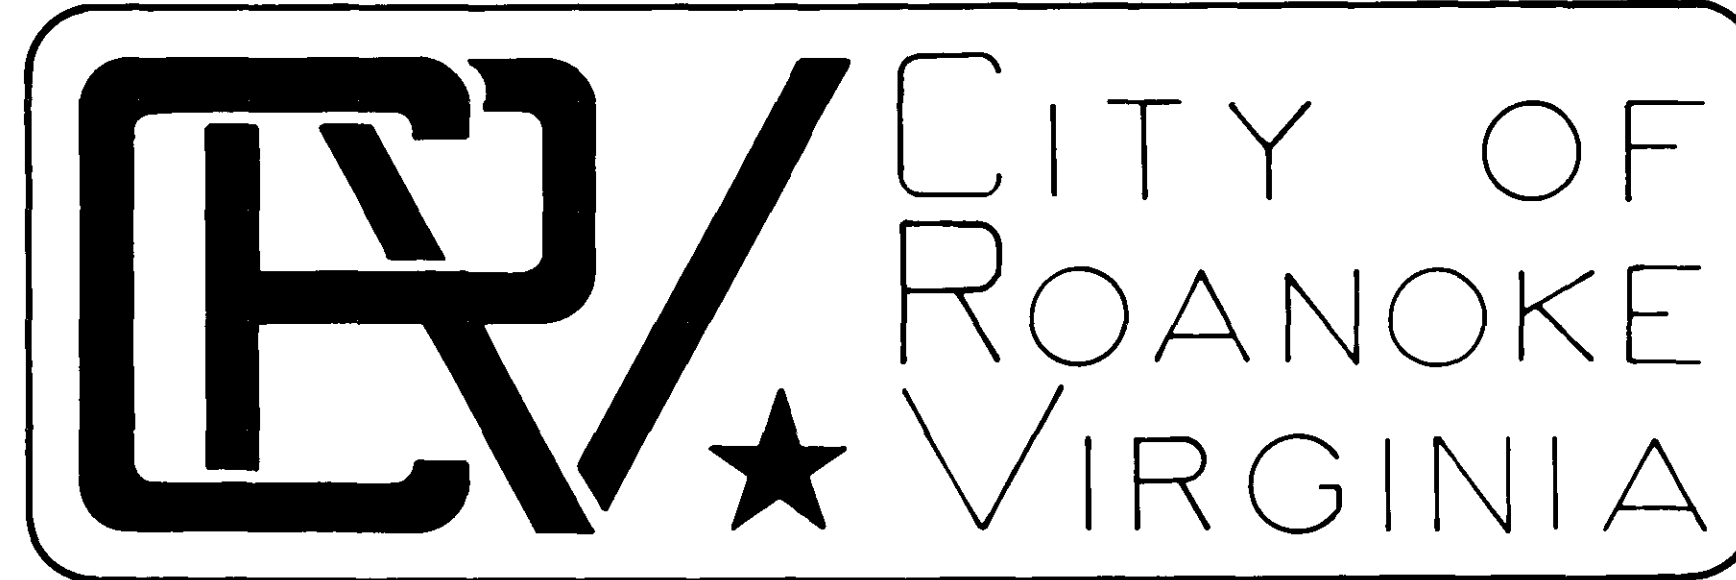


PROJECT LOCATION MAP

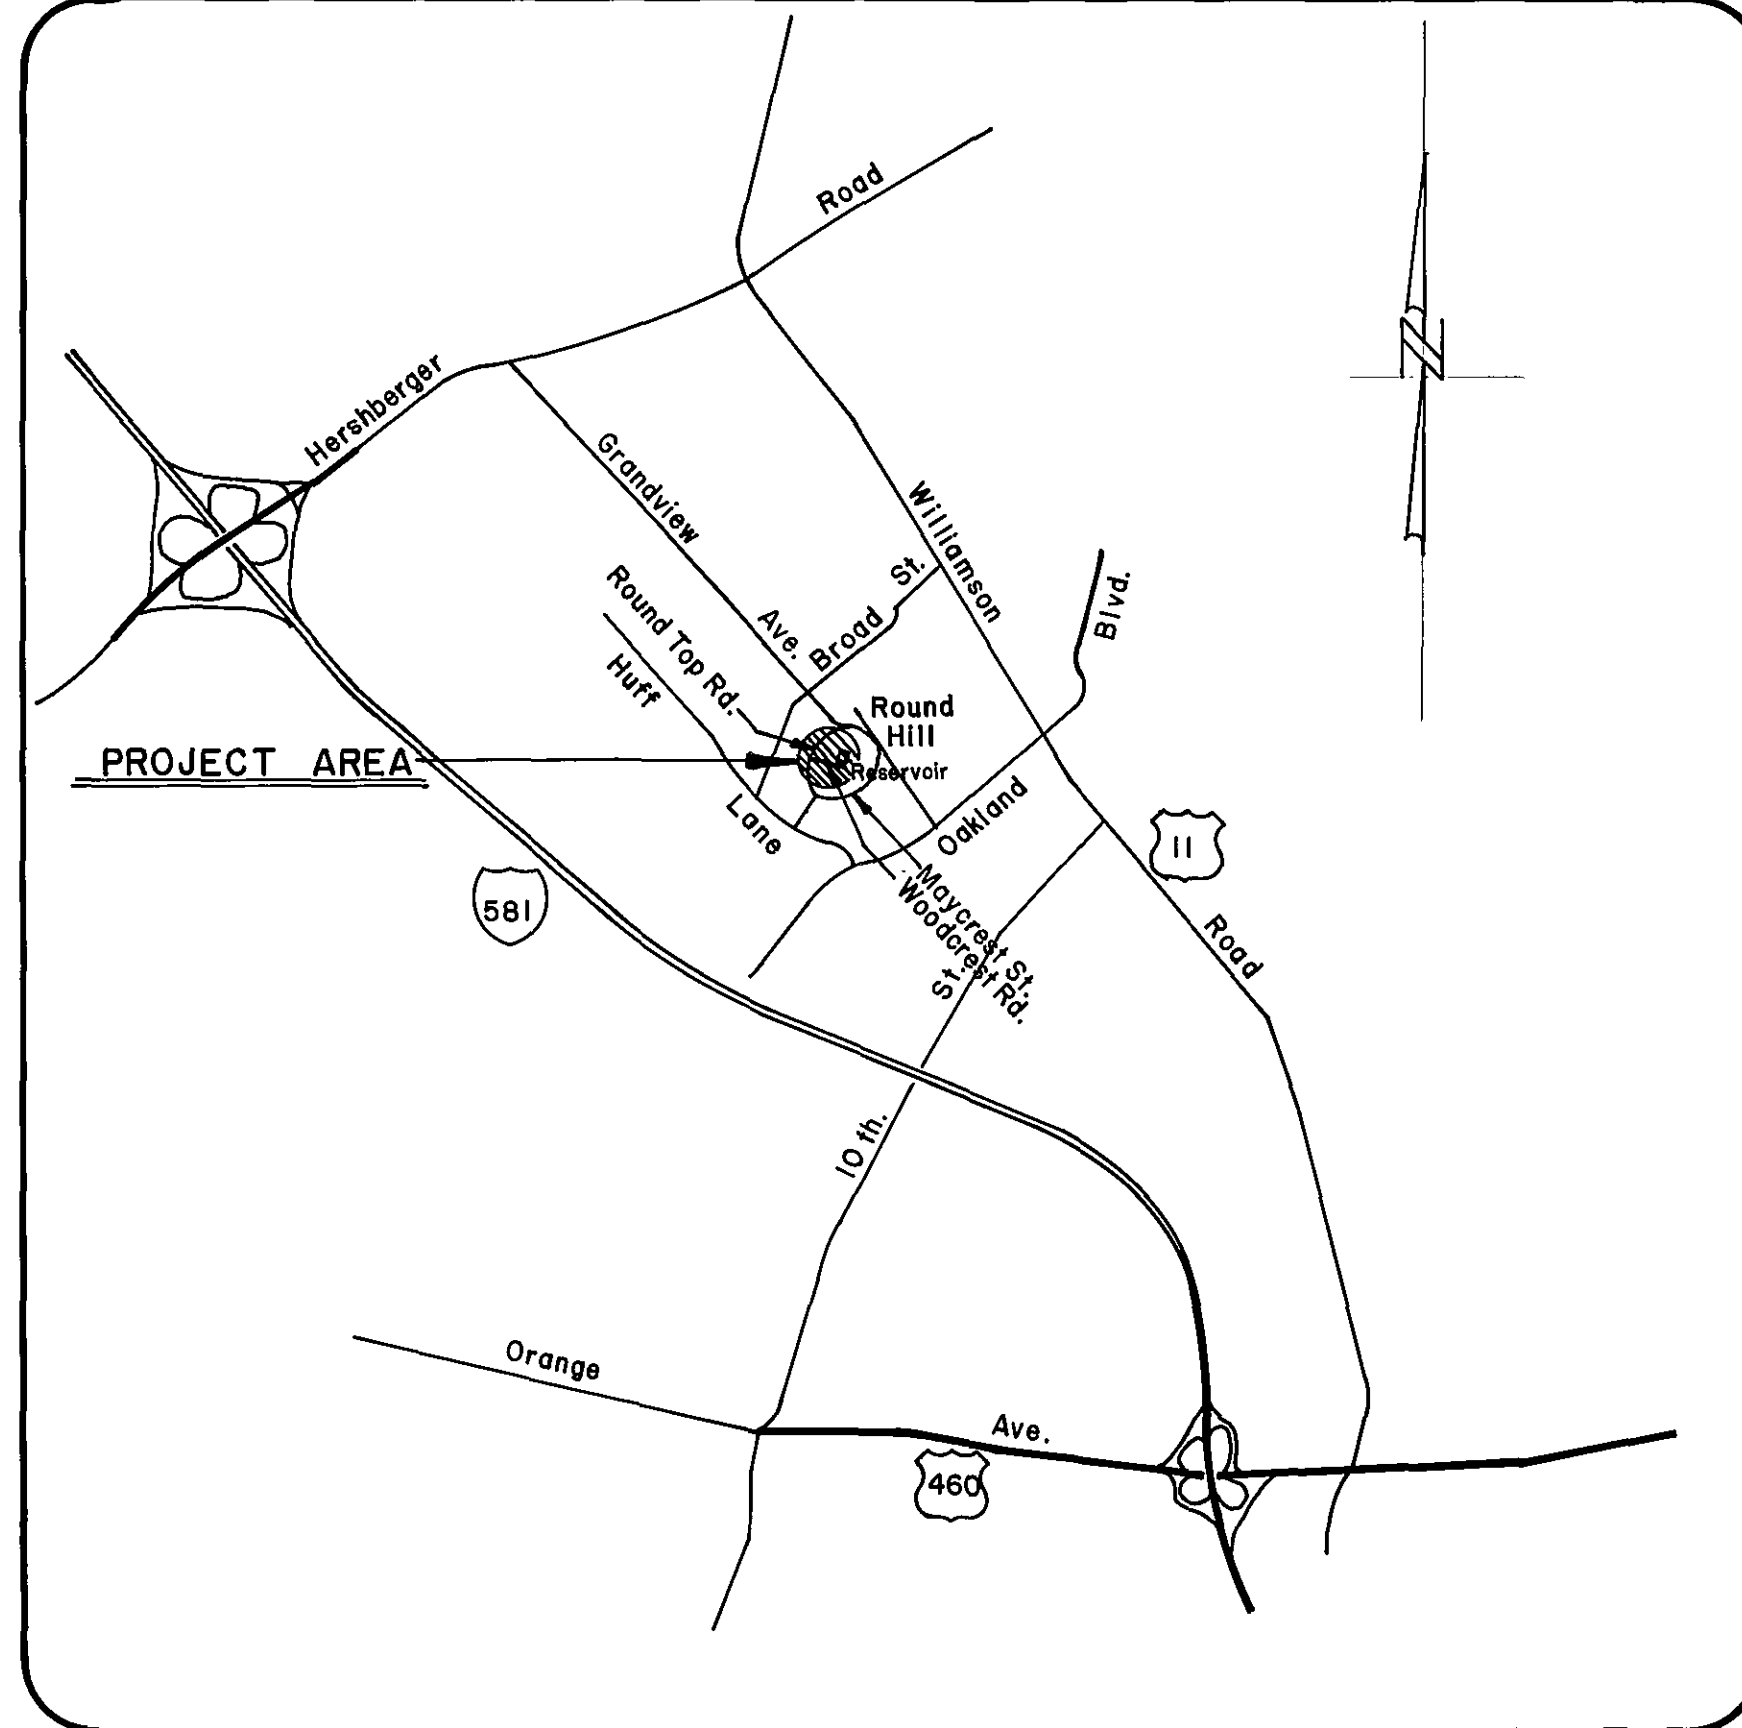

OFFICE OF CITY ENGINEER
ROOM 350
MUNICIPAL BUILDING
215 CHURCH AVENUE, S.W.
ROANOKE, VIRGINIA 24011

INDEX OF SHEETS

SHEET NO.	TITLE
1.	COVER SHEET
2.	ABBREVIATIONS, LEGEND AND GENERAL NOTES AND VICINITY MAP
3.	SITE PLAN AND DETAILS
4.	ARCHITECTURAL PLAN, SECTIONS AND DETAILS
5.	MECHANICAL AND ELECTRICAL PLAN

CONSULTING ENGINEERS

MATTERN & CRAIG
CONSULTING ENGINEERS
SUITE 401
707 S. JEFFERSON ST.
ROANOKE, VIRGINIA

COMMISSION NUMBER: 635



PROJECT NAME

ROUND HILL PUMP STATION

PROJECT NUMBER: 86-09A

REVISION	BY	DESCRIPTION	DATE
REVISION	BY	DESCRIPTION	DATE
REVISION	BY	DESCRIPTION	DATE
REVISION	BY	DESCRIPTION	DATE

APPROVED FOR CONSTRUCTION

Charles M. Hufnagel ROANOKE CITY ENGINEER	8/14/86 DATE
William F. Clark DIRECTOR OF PUBLIC WORKS	8-14-86 DATE
Bill B. Bice DIRECTOR OF UTILITIES AND OPERATIONS	8/14/86 DATE
	DATE
	DATE

ADVERTISED DATE:

SET NUMBER:

SHEET NUMBER: 1 OF 5

RECORD DRAWING