


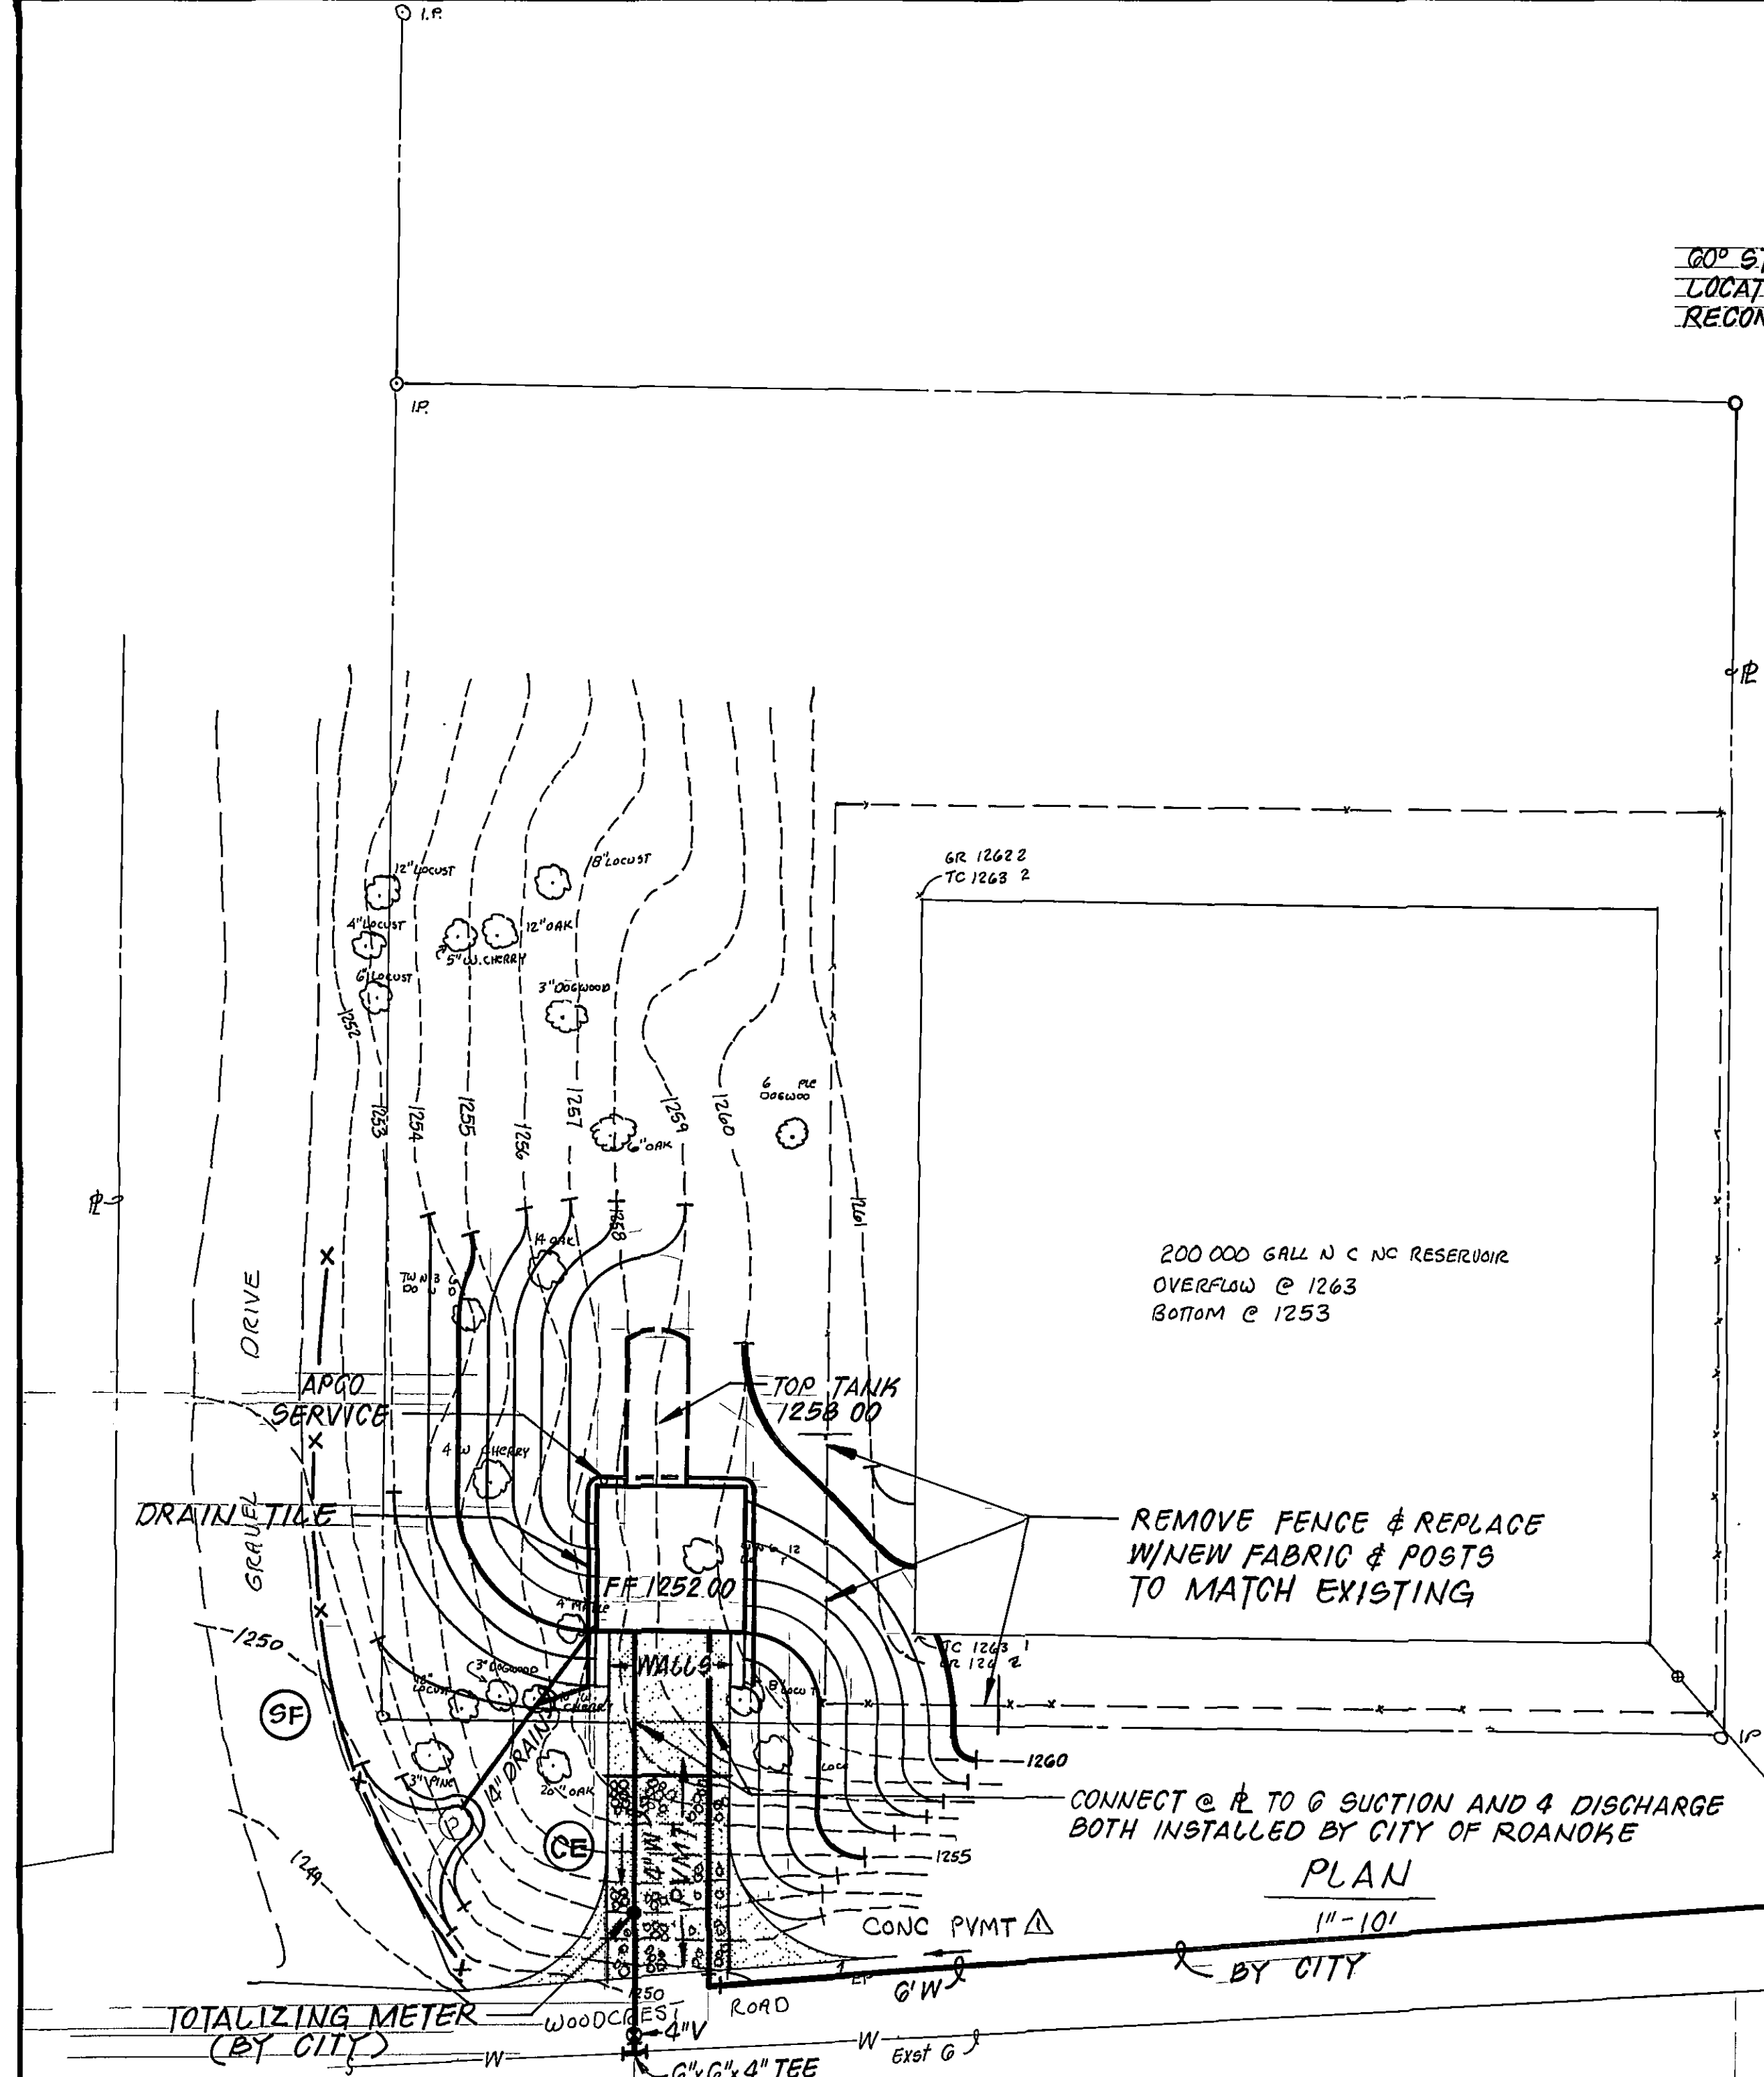
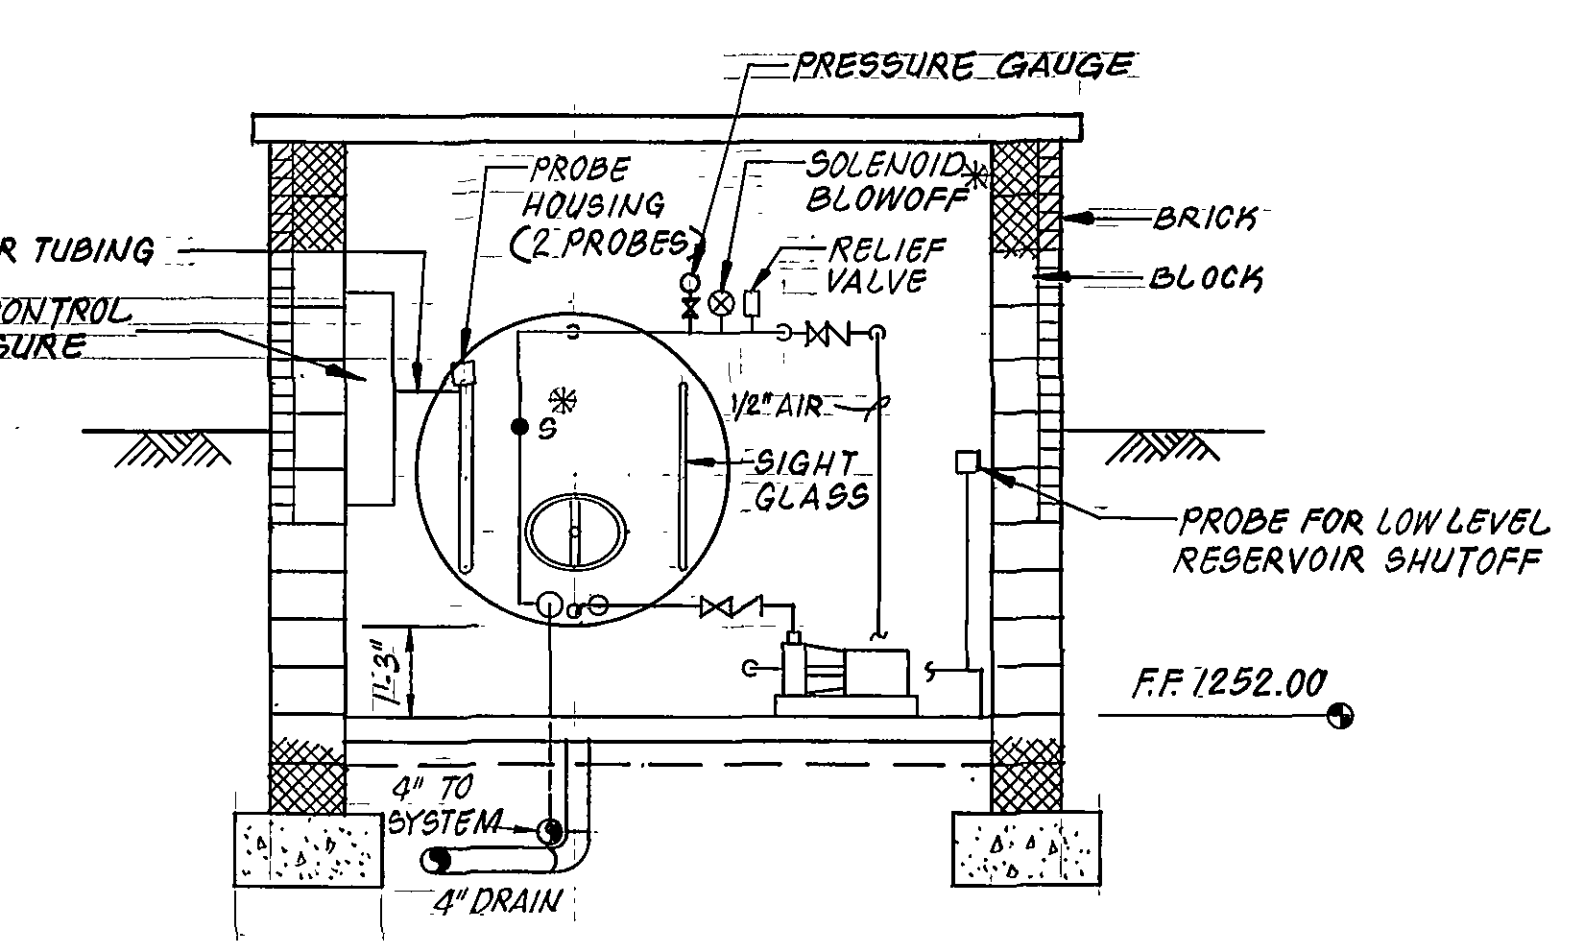
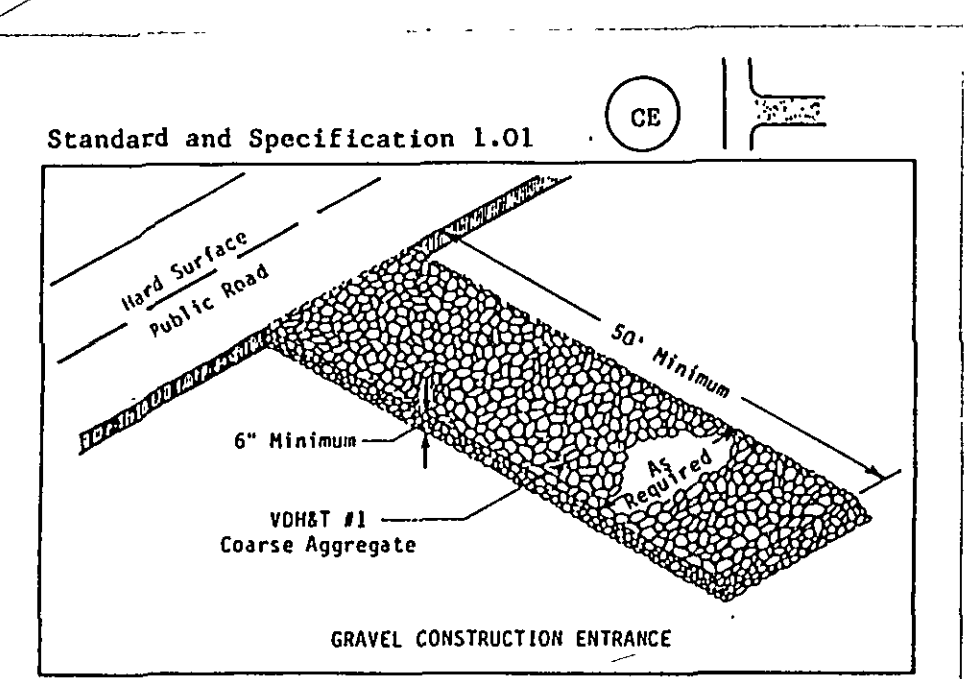
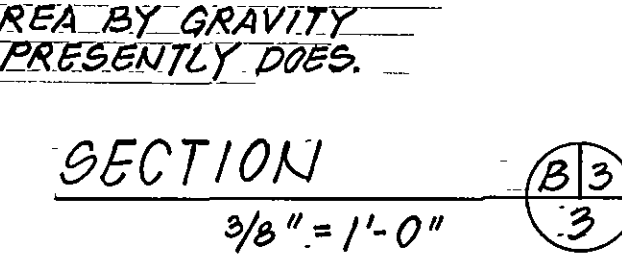
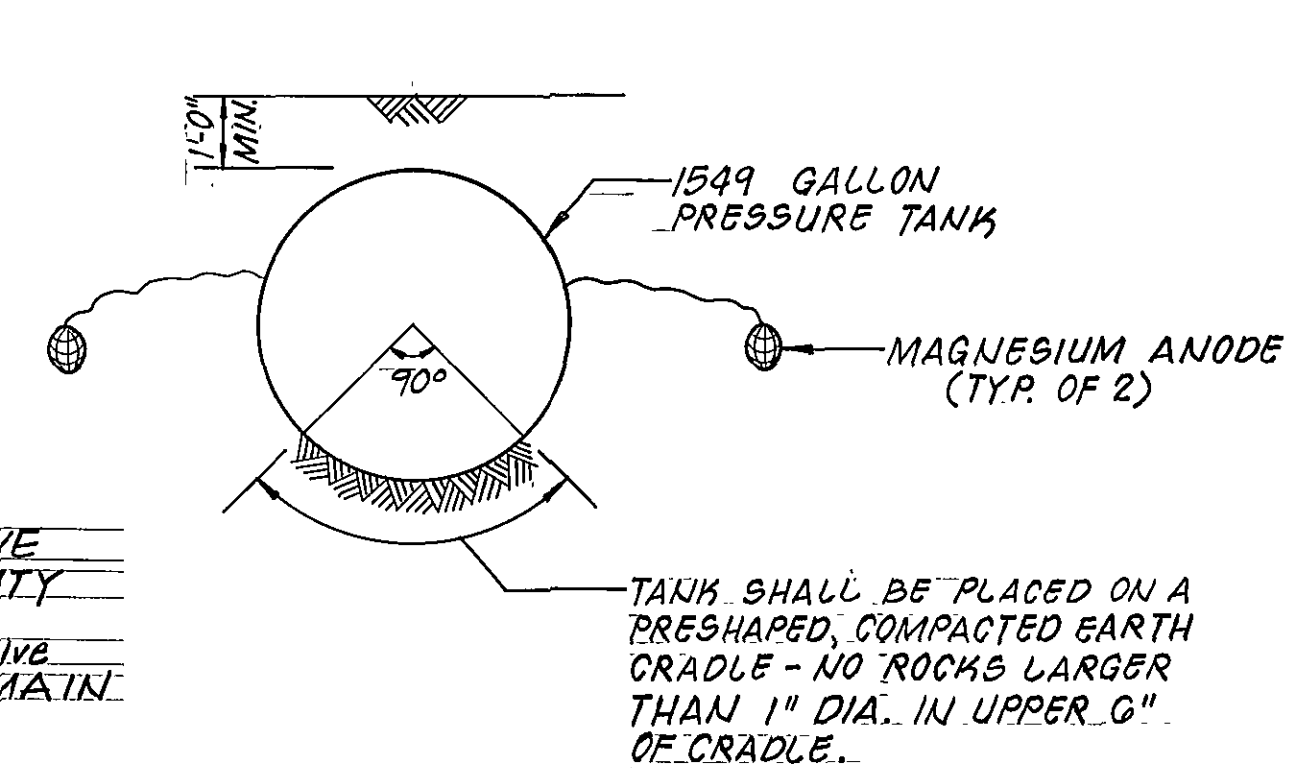
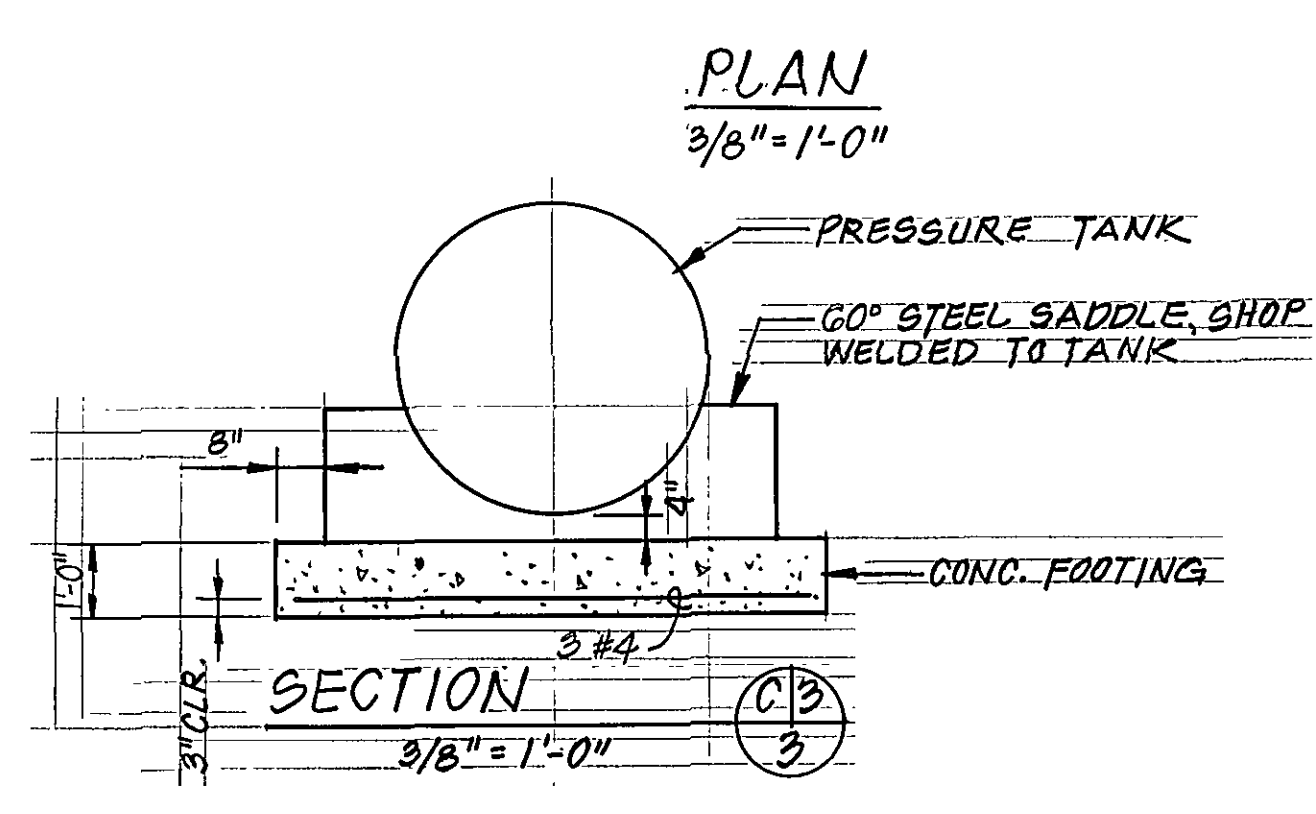


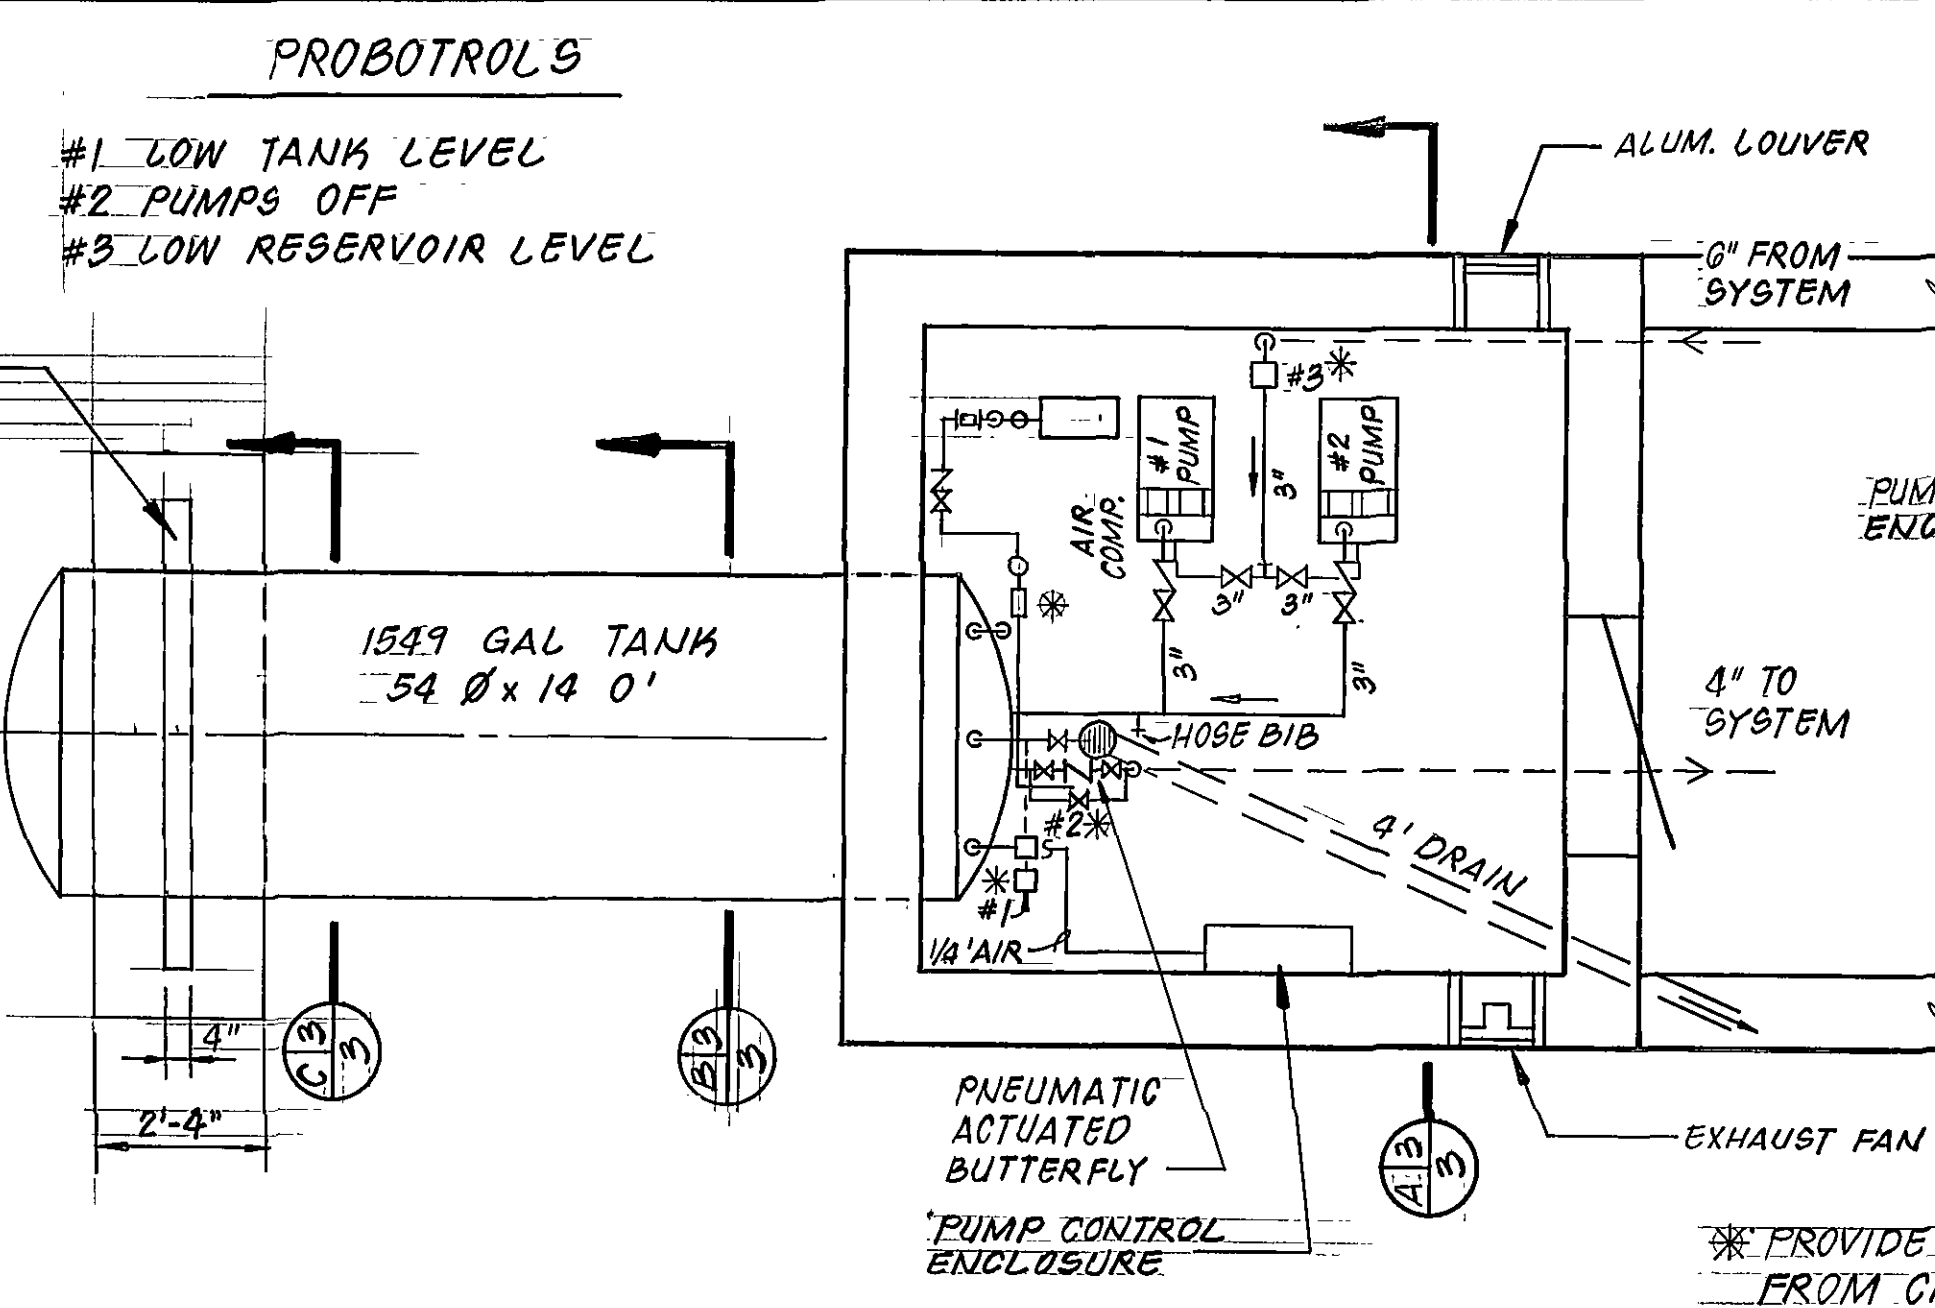


- S THREE WAY SOLENOID
- ⊗ GATE (OR GLOBE) VALVE
- ⌋ CHECK VALVE
- ⊖ PR PRESSURE REGULATOR
- PROBOTROL

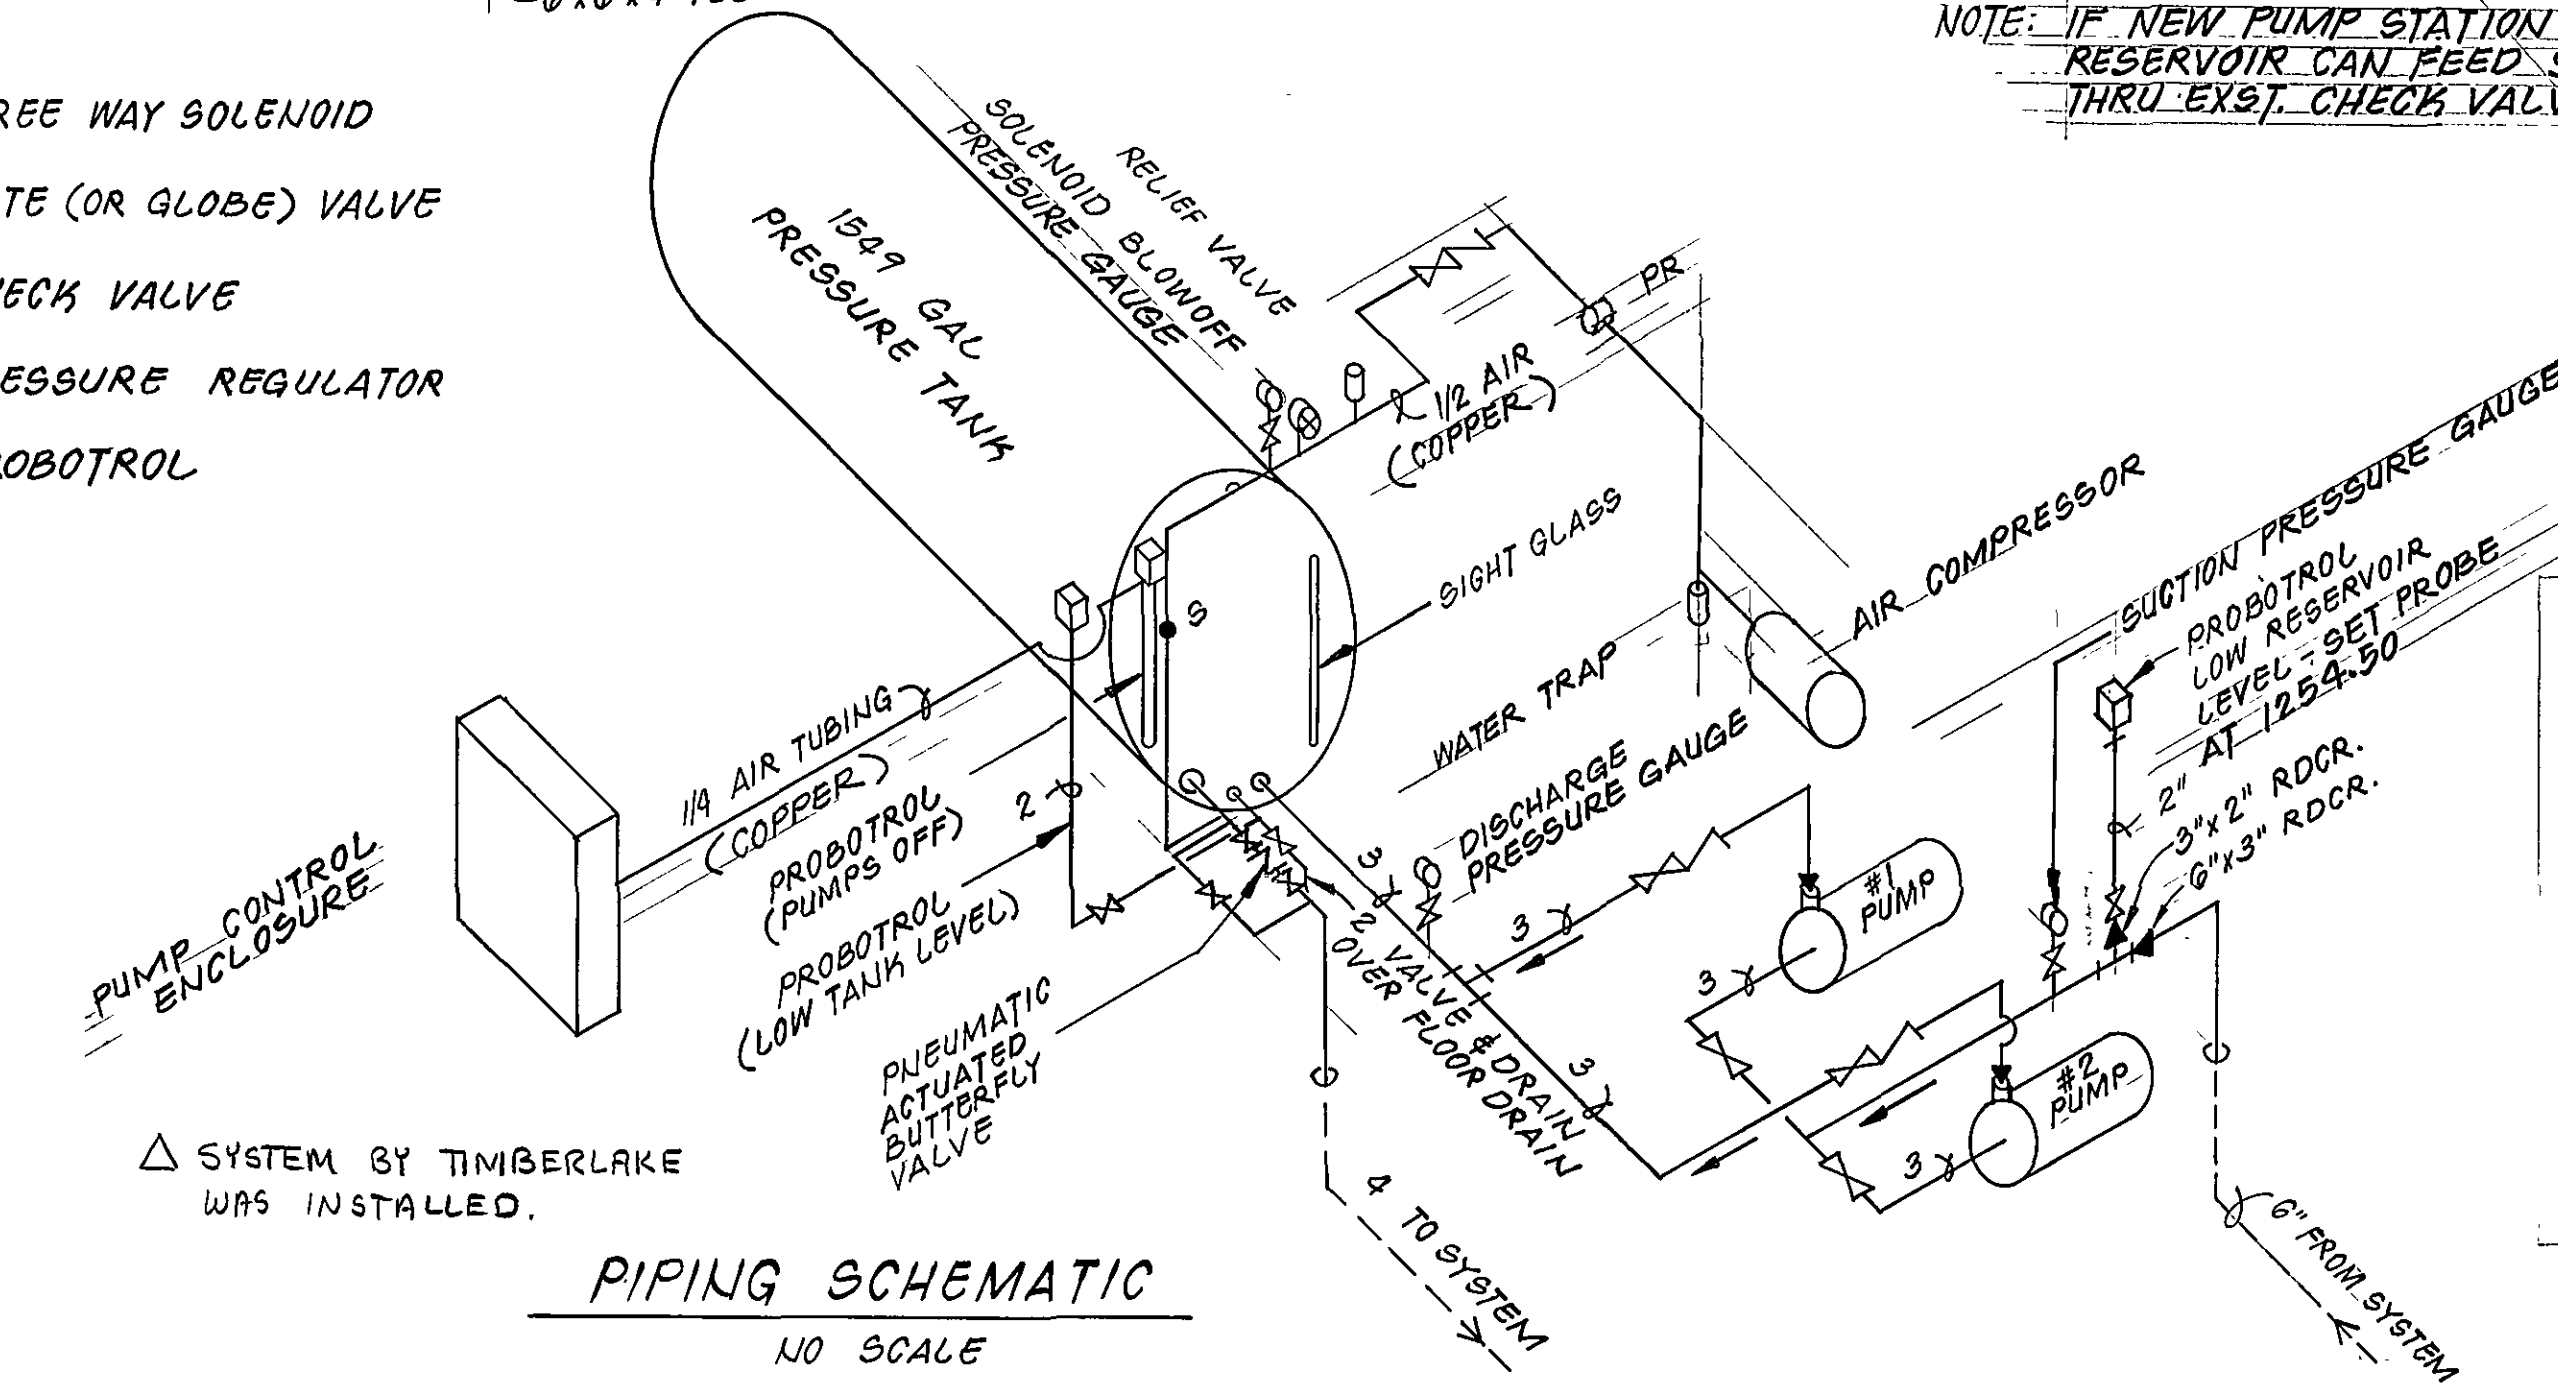


\* PROVIDE 120 VOLT CONN. TO PROBOTROL AND SOLENOID FROM CKT. A-10 VIA PUMP CONTROL ENCLOSURE FOR CONTROL.

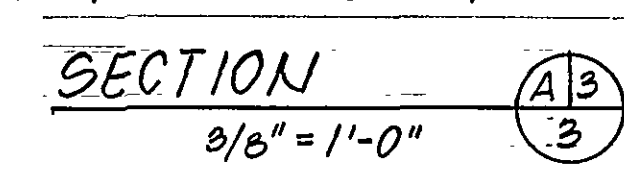

| TANK OPENINGS  |         |             |
|----------------|---------|-------------|
| LABEL          | SIZE    | SERVICE     |
| A              | 4"      | OUTLET      |
| B              | 3"      | INLET       |
| C              | 2"      | DRAIN       |
| D <sub>1</sub> | 2"      | PROBES (2)  |
| D <sub>2</sub> | 1/2"    | SIGHT GLASS |
| D <sub>3</sub> | 1/2"    | AIR CONN.   |
| E              | 11"x15" | CLEANOUT    |

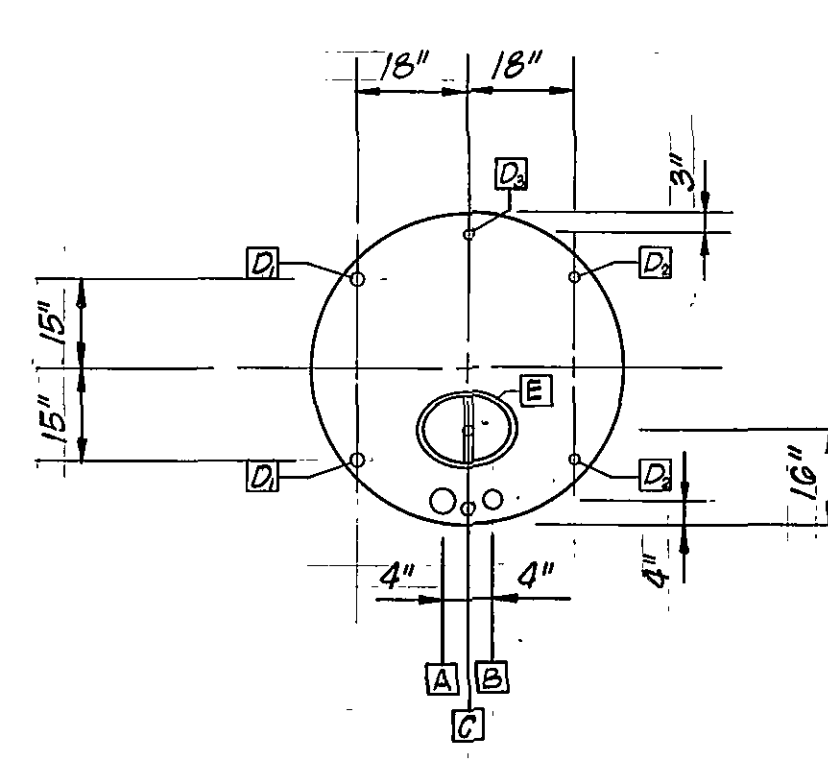

END OF TANK  
3/8" = 1'-0"

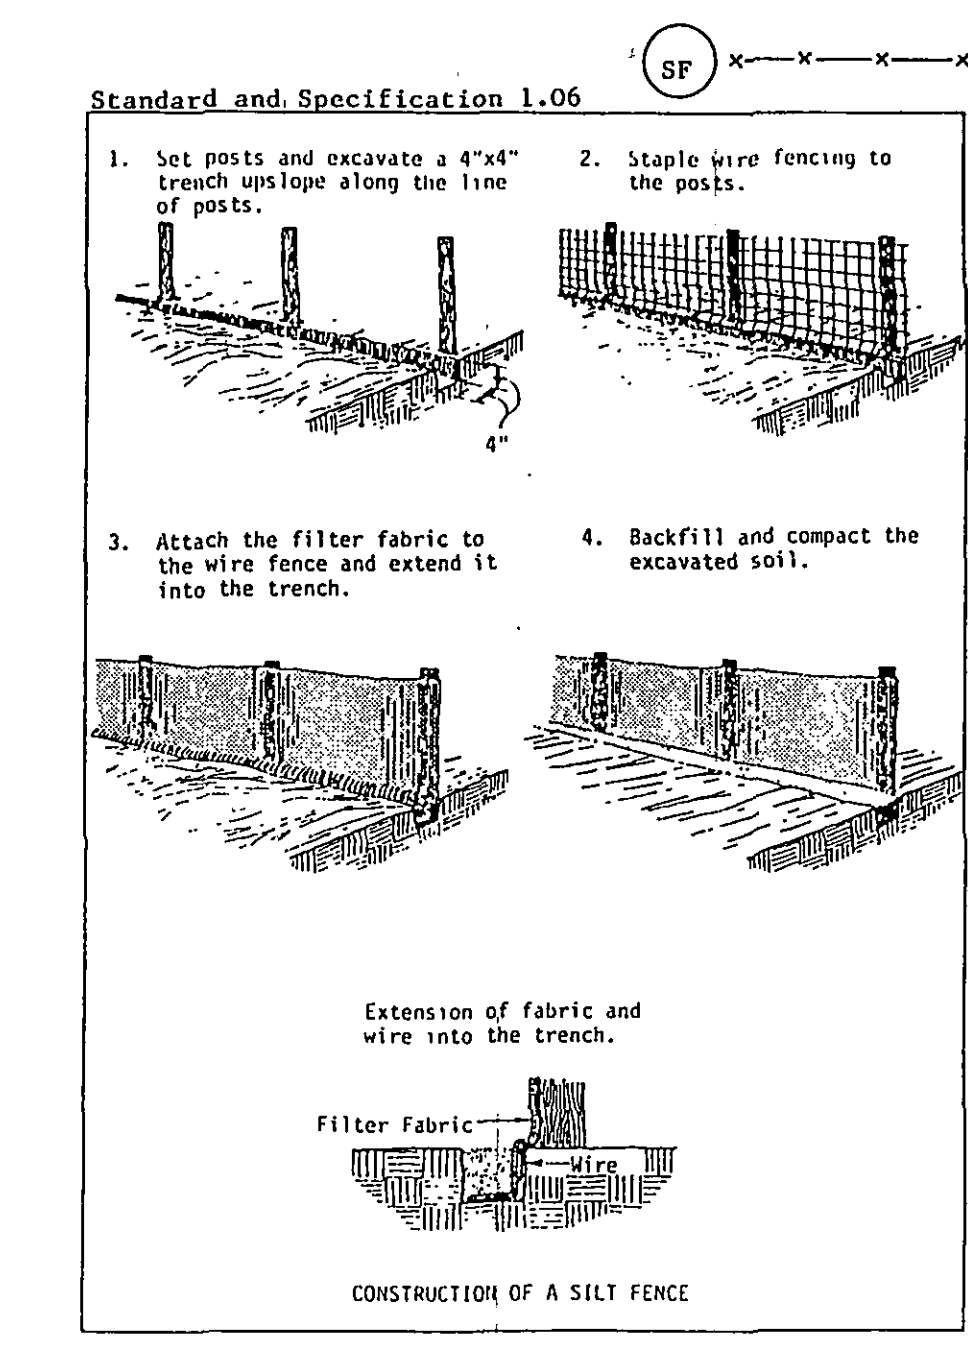

RECORD DRAWING

|                         |          |             |               |      |
|-------------------------|----------|-------------|---------------|------|
| REVISION                | DATE     | DESCRIPTION | BY            | APP. |
| 1                       | 12/10/87 | RECORD DWG  | SWH           |      |
| DESIGNED                |          |             |               |      |
| DRAWN                   |          |             |               |      |
| CHECKED SWH             |          |             |               |      |
| APPROVED                |          |             |               |      |
| SUBMITTED               |          |             |               |      |
| ROUND HILL PUMP STATION |          |             |               |      |
| SITE PLAN AND DETAILS   |          |             |               |      |
| SCALE: NOTED            |          |             | COMM. NO. 635 |      |
| DATE: MAY '86           |          |             | SHEET 3       |      |

Mattern & Craig  
CONSULTING ENGINEERS