



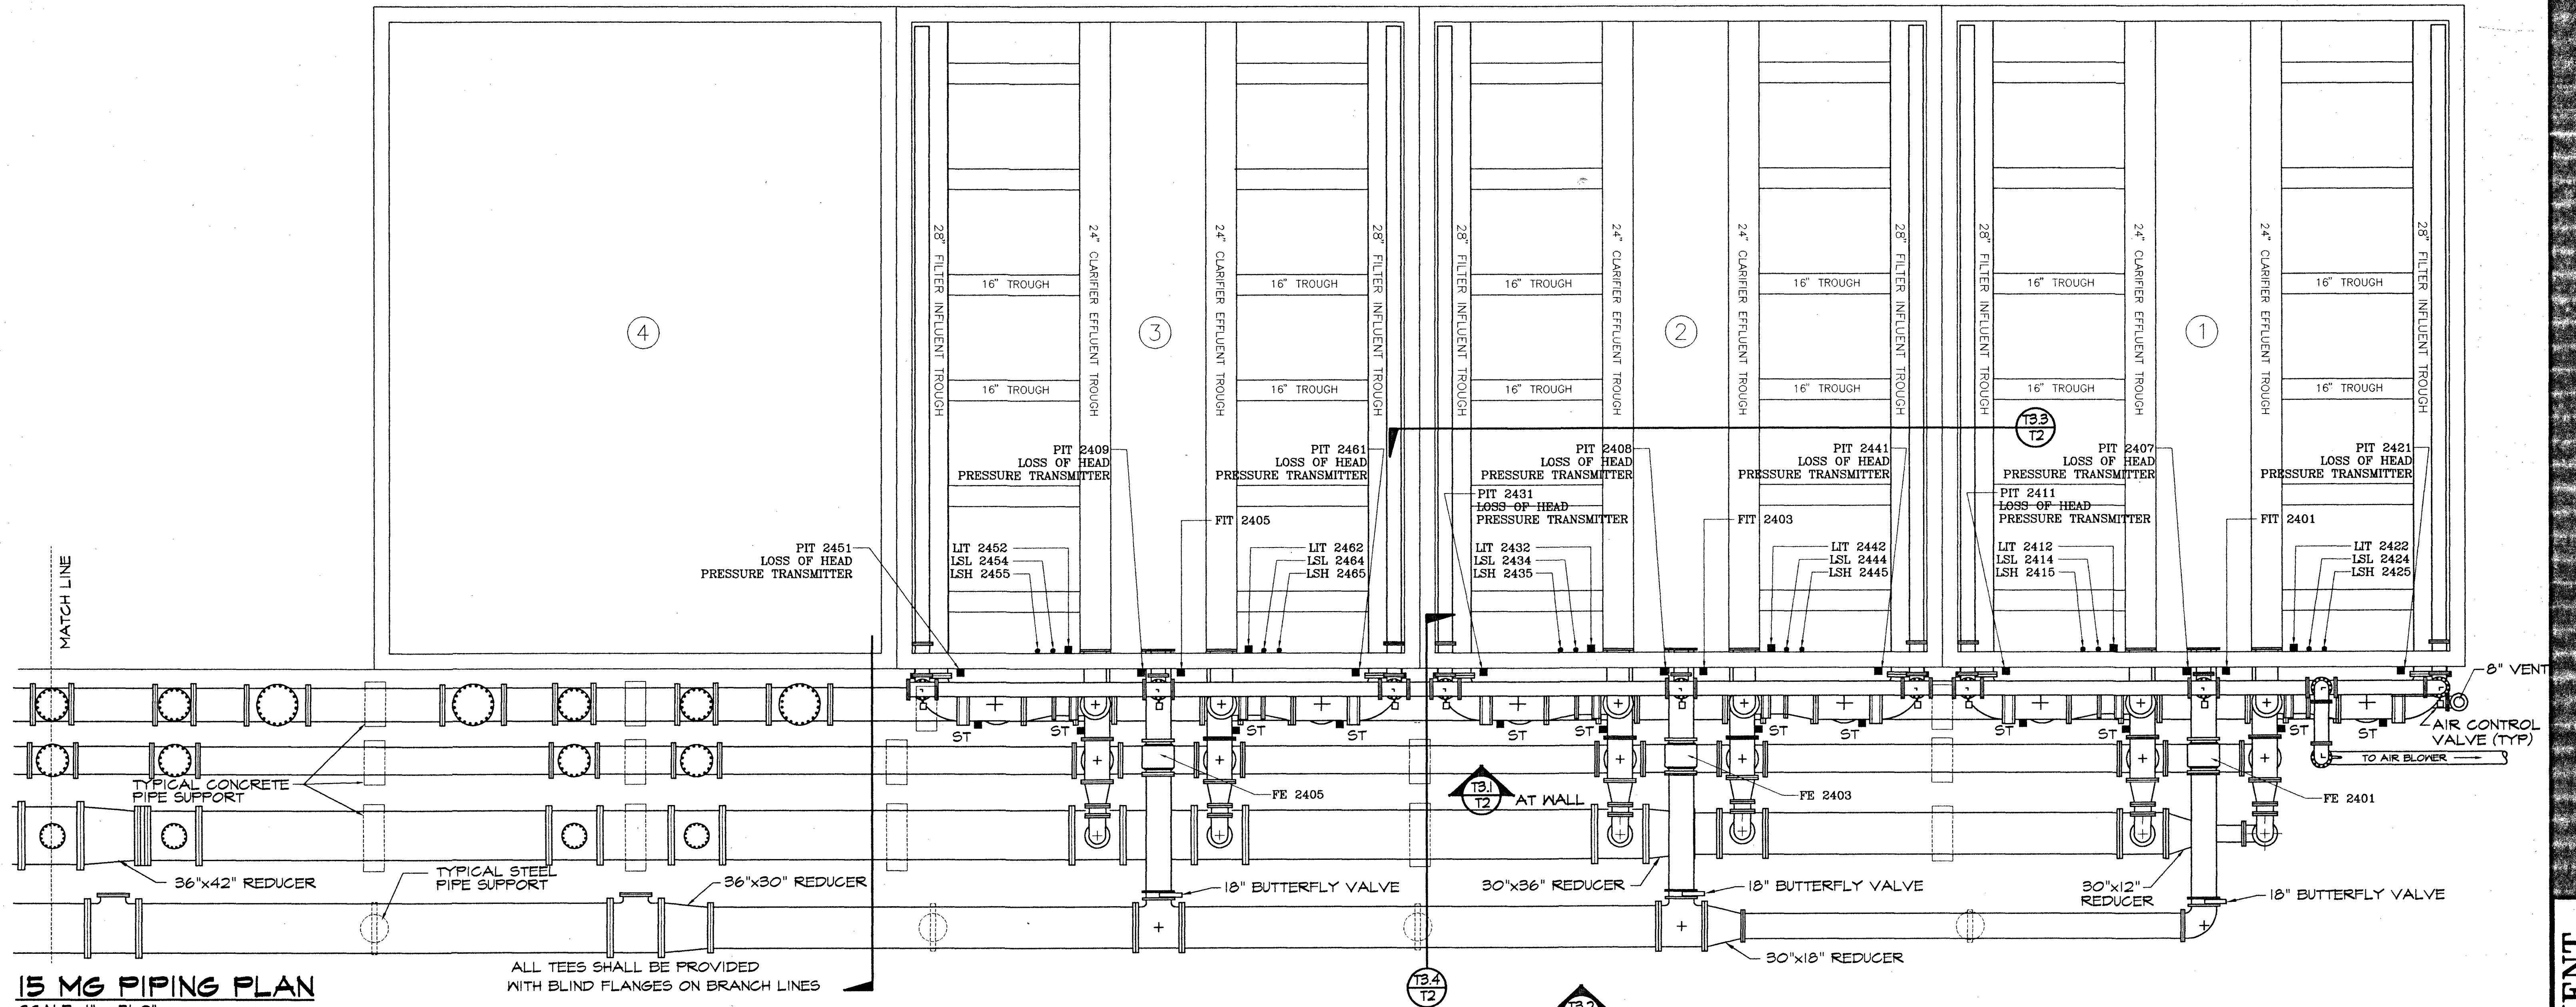


15 MG PIPING PLAN
SCALE 1" = 5'-0"


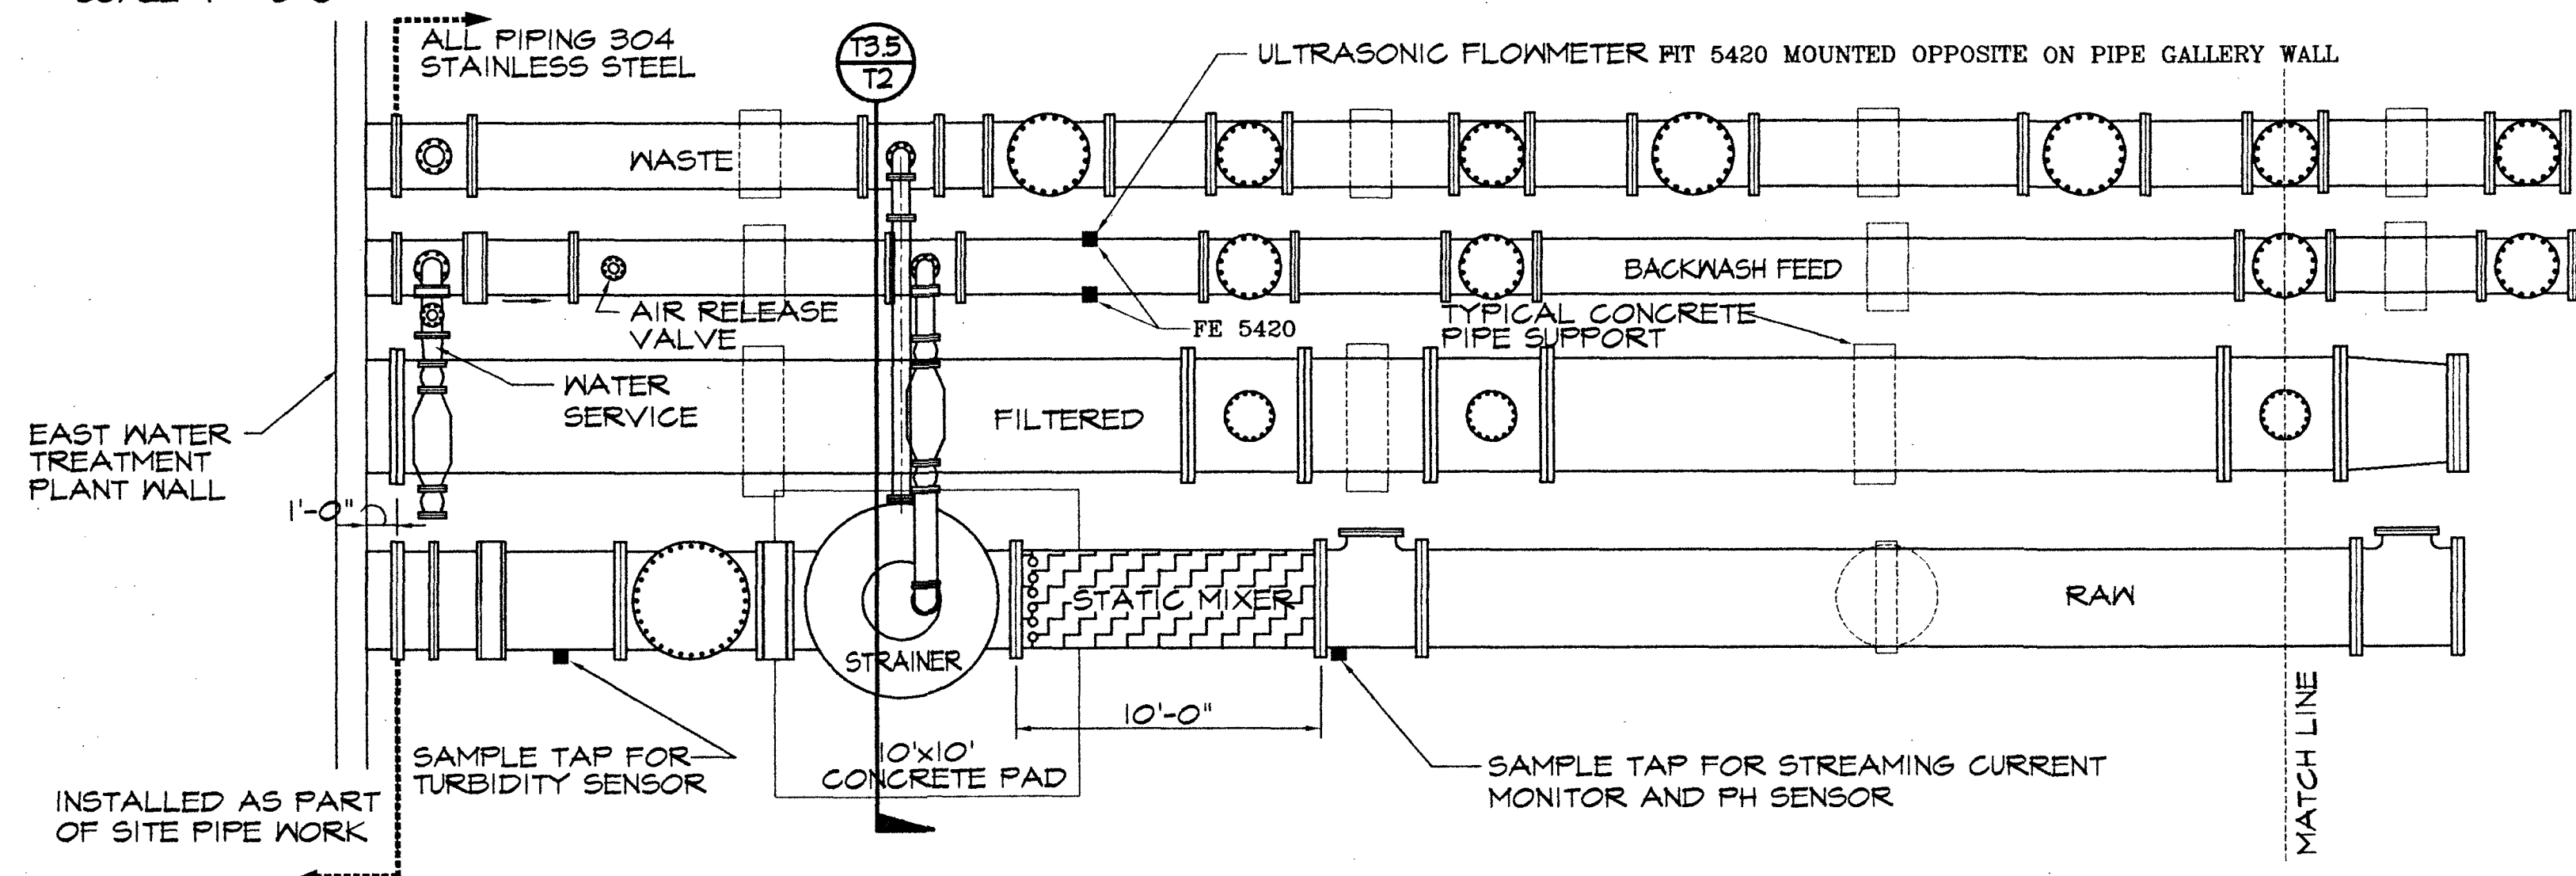


15 MG PIPING PLAN
SCALE 1" = 5'-0"

- NOTES
1. ALL PIPING AND FITTINGS INSTALLED IN THE PIPE GALLERY SHALL BE 304 STAINLESS STEEL
 2. SEE SHEETS T5 THROUGH T11 FOR SEPARATE PIPING DETAILS
 3. ALL TREATMENT BASIN EQUIPMENT AND MATERIALS TO BE SUPPLIED BY OTHERS
 4. SEE WHEELABRATOR PROPOSAL IN SPECS FOR INTERIOR BASIN ARRANGEMENT
 5. ST INDICATES SAMPLE TAP FOR TURBIDITY SENSOR

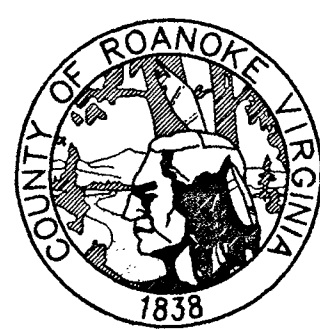

ROANOKE COUNTY WATER TREATMENT FACILITY

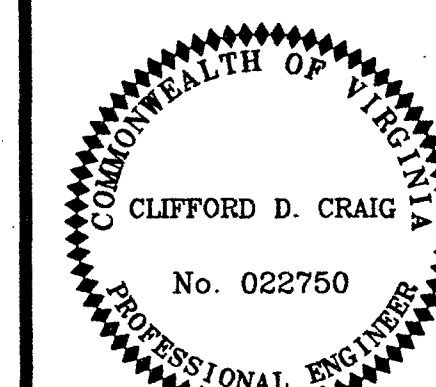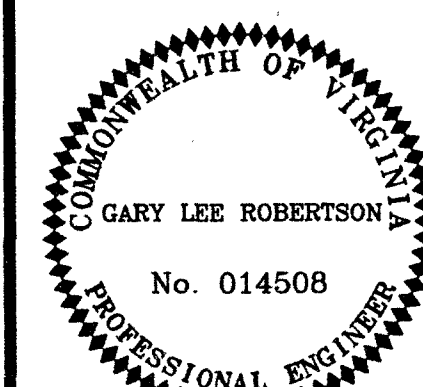

TREATMENT BUILDING TREATMENT SYSTEM PLAN

DESIGN ENGINEER
CLIFFORD D. CRAIG

COMMISSION NUMBER
1913

ROU NUMBER
WTF-1

DATE
9 SEPT. 1994

T2