



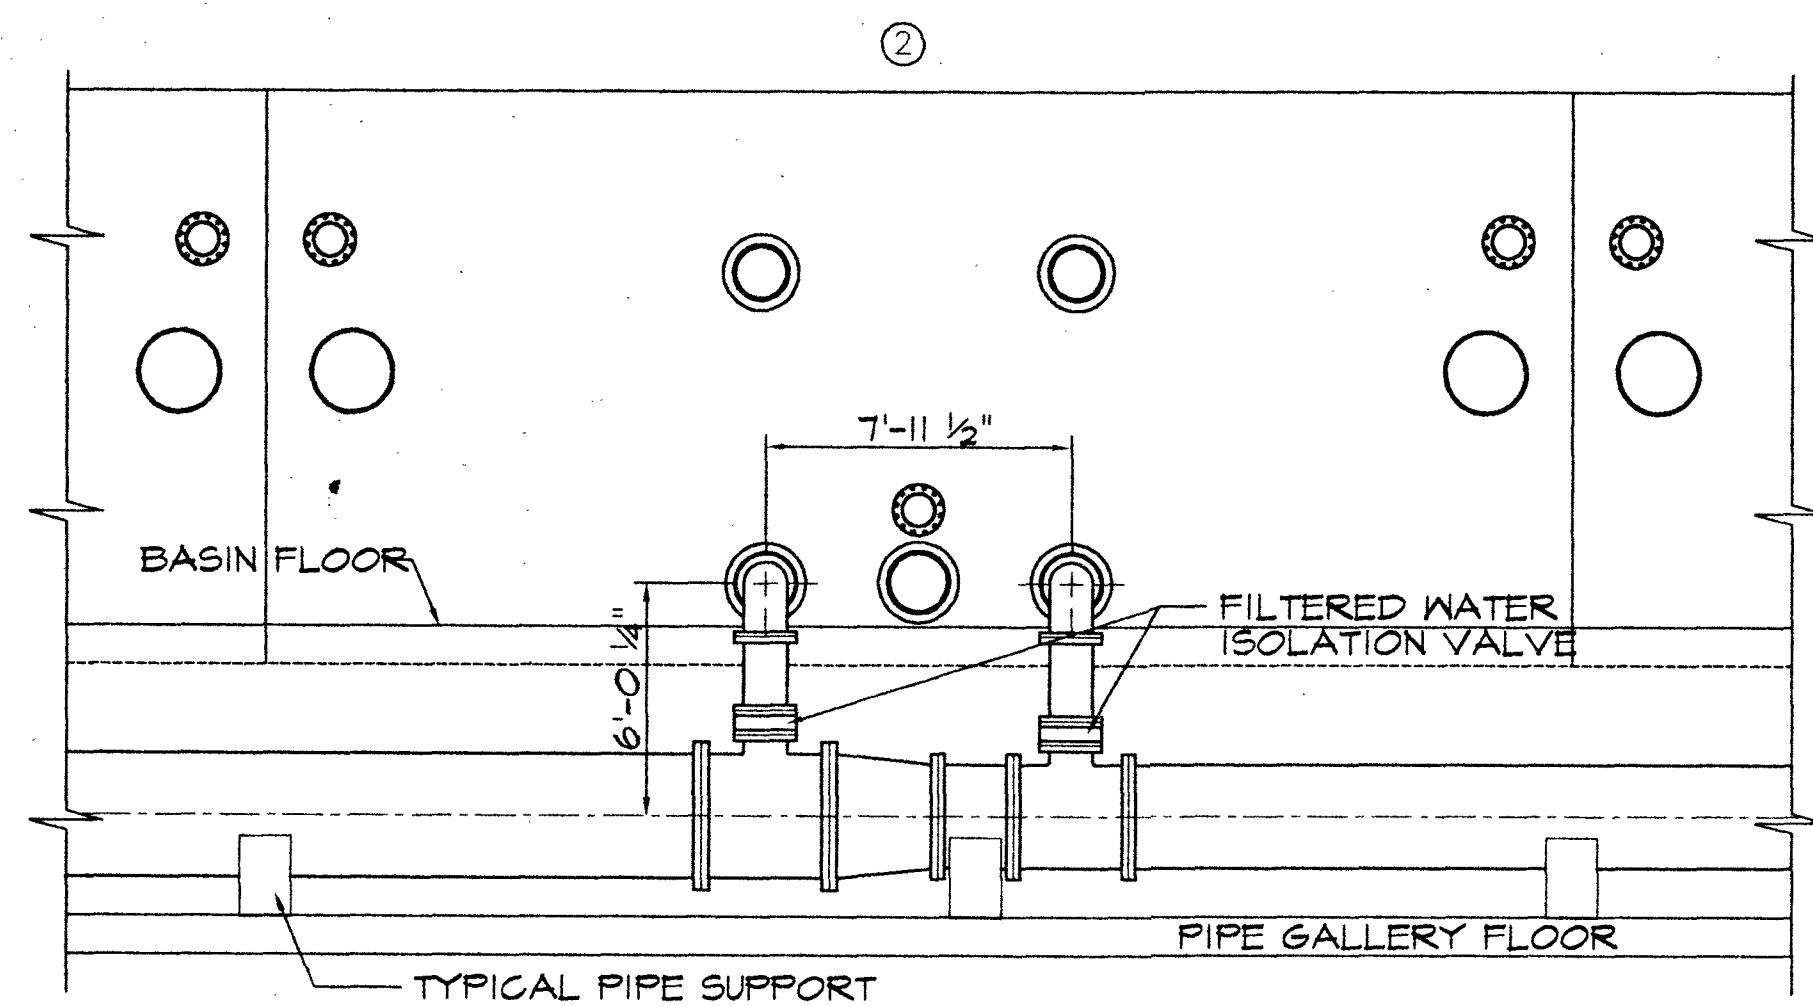


BASIN #2 - FILTERED PIPING ELEVATION
SCALE 1" = 5'-0"

T6.1
T6

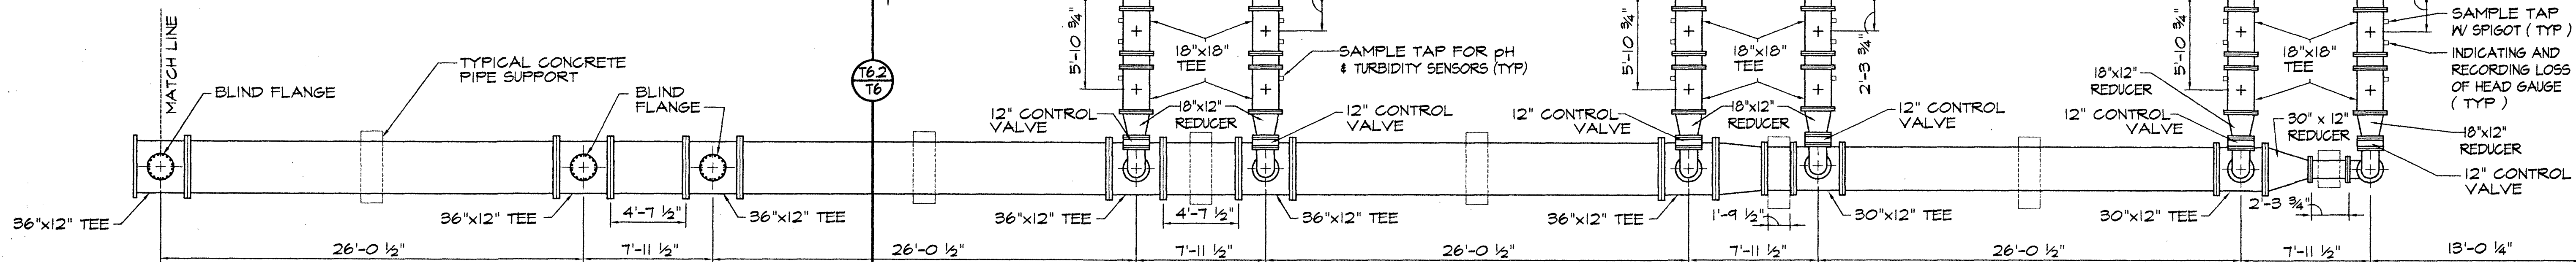


FILTERED PIPING PLAN
SCALE 1" = 5'-0"

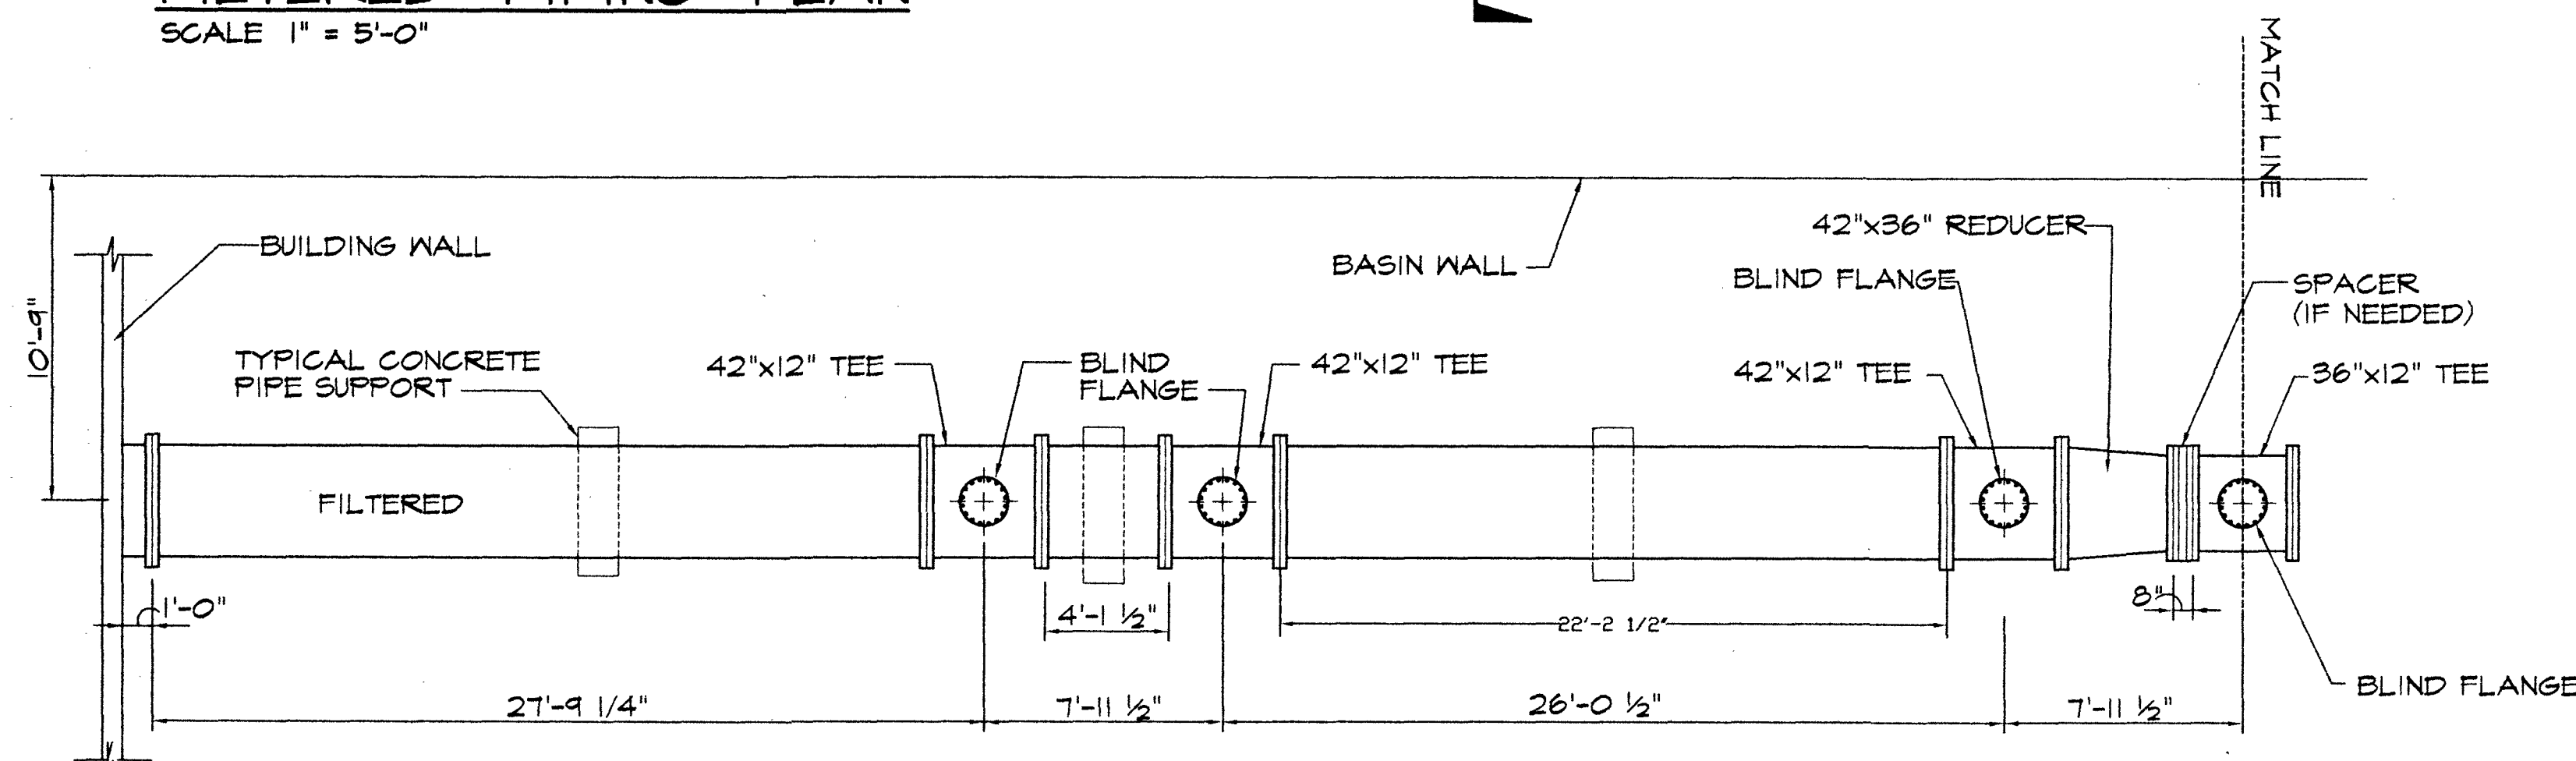


FILTERED PIPING PLAN
SCALE 1" = 5'-0"

- NOTES:
1. ALL FILTERED PIPING AND FITTINGS TO BE 304 STAINLESS STEEL RATED AT 125 PSI
 2. ALL CONTROL VALVES TO BE SUPPLIED BY OTHERS
 3. CONTROL VALVE: MOTORIZED MODULATING BUTTERFLY VALVE WITH HAND OPERATOR
 4. CONTROL VALVE (ON/OFF): MOTORIZED ON/OFF BUTTERFLY VALVE WITH HAND OPERATOR


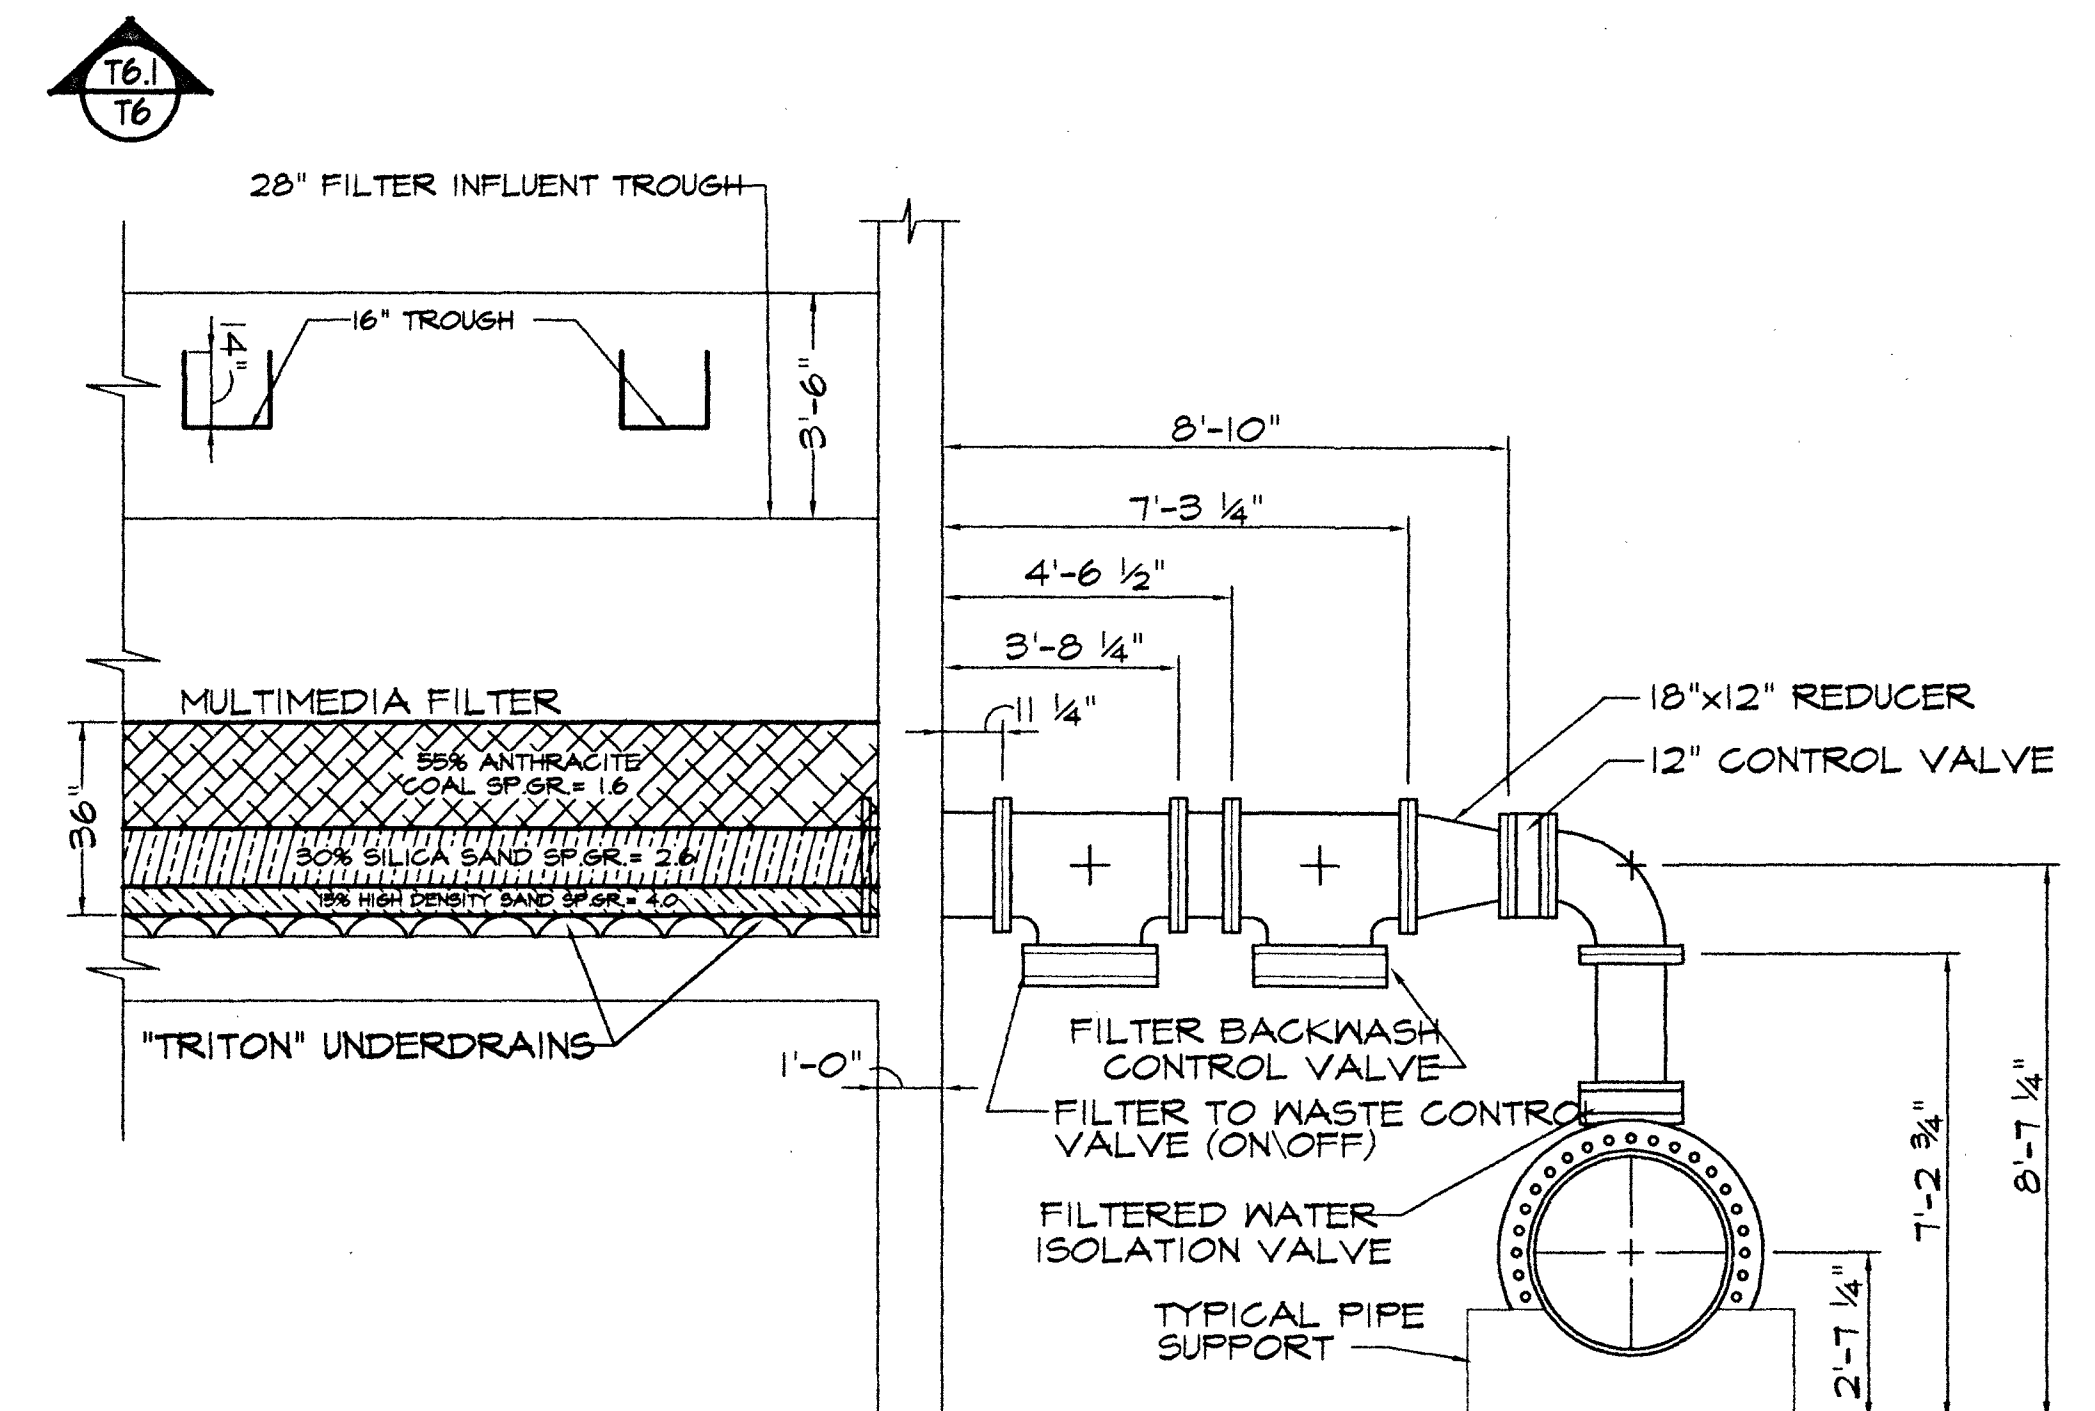


SECTION - FILTERED
SCALE 1" = 3'-0"

T6.2
T6

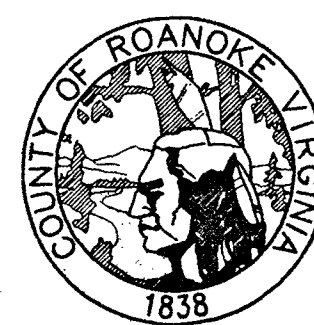

ROANOKE COUNTY WATER TREATMENT FACILITY

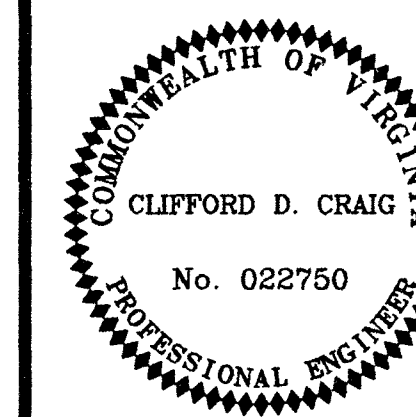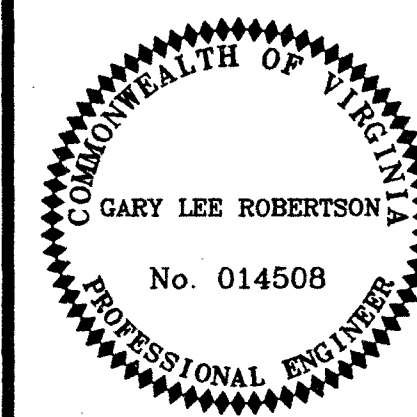

FILTERED PIPING DIAGRAM

DESIGN ENGINEER
CLIFFORD D. CRAIG

COMMISSION NUMBER
1913

ROUD NUMBER
WTF-1

DATE
9 SEPT. 1994

T6