




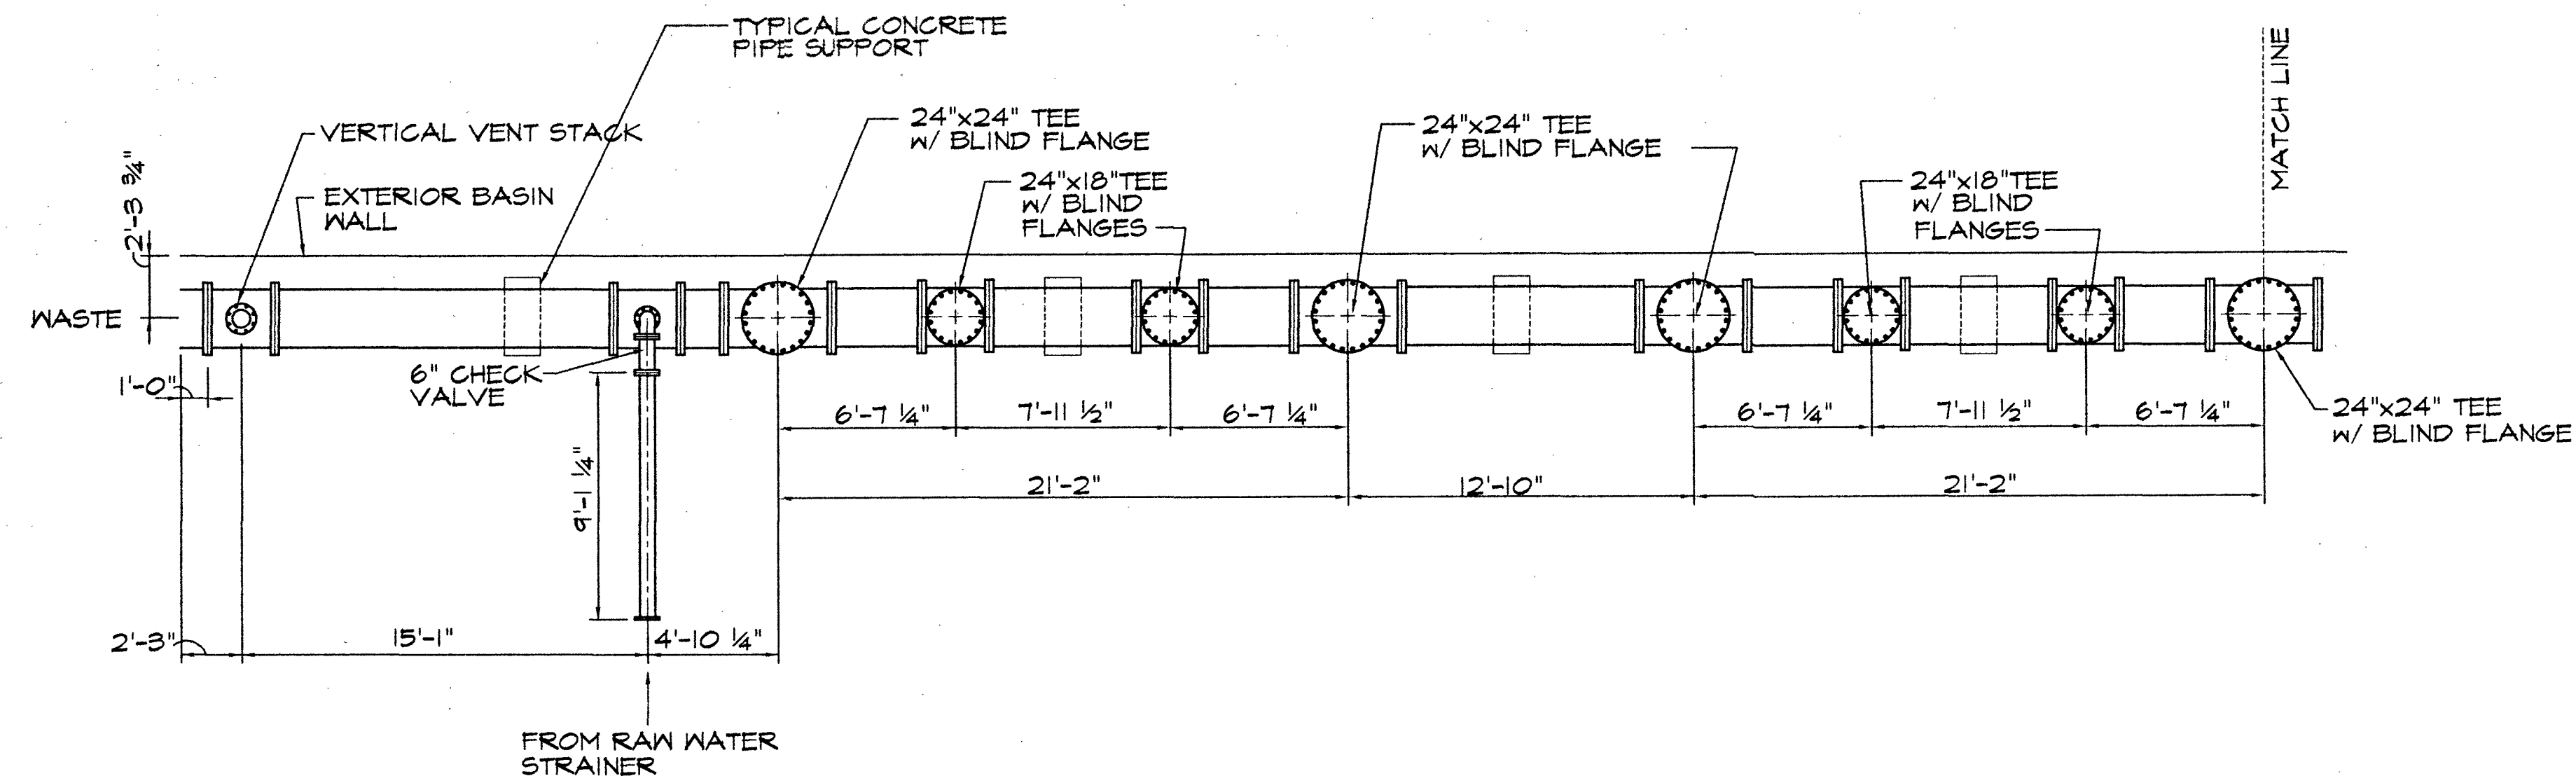


WASTE PIPING PLAN
SCALE 1" = 5'-0"

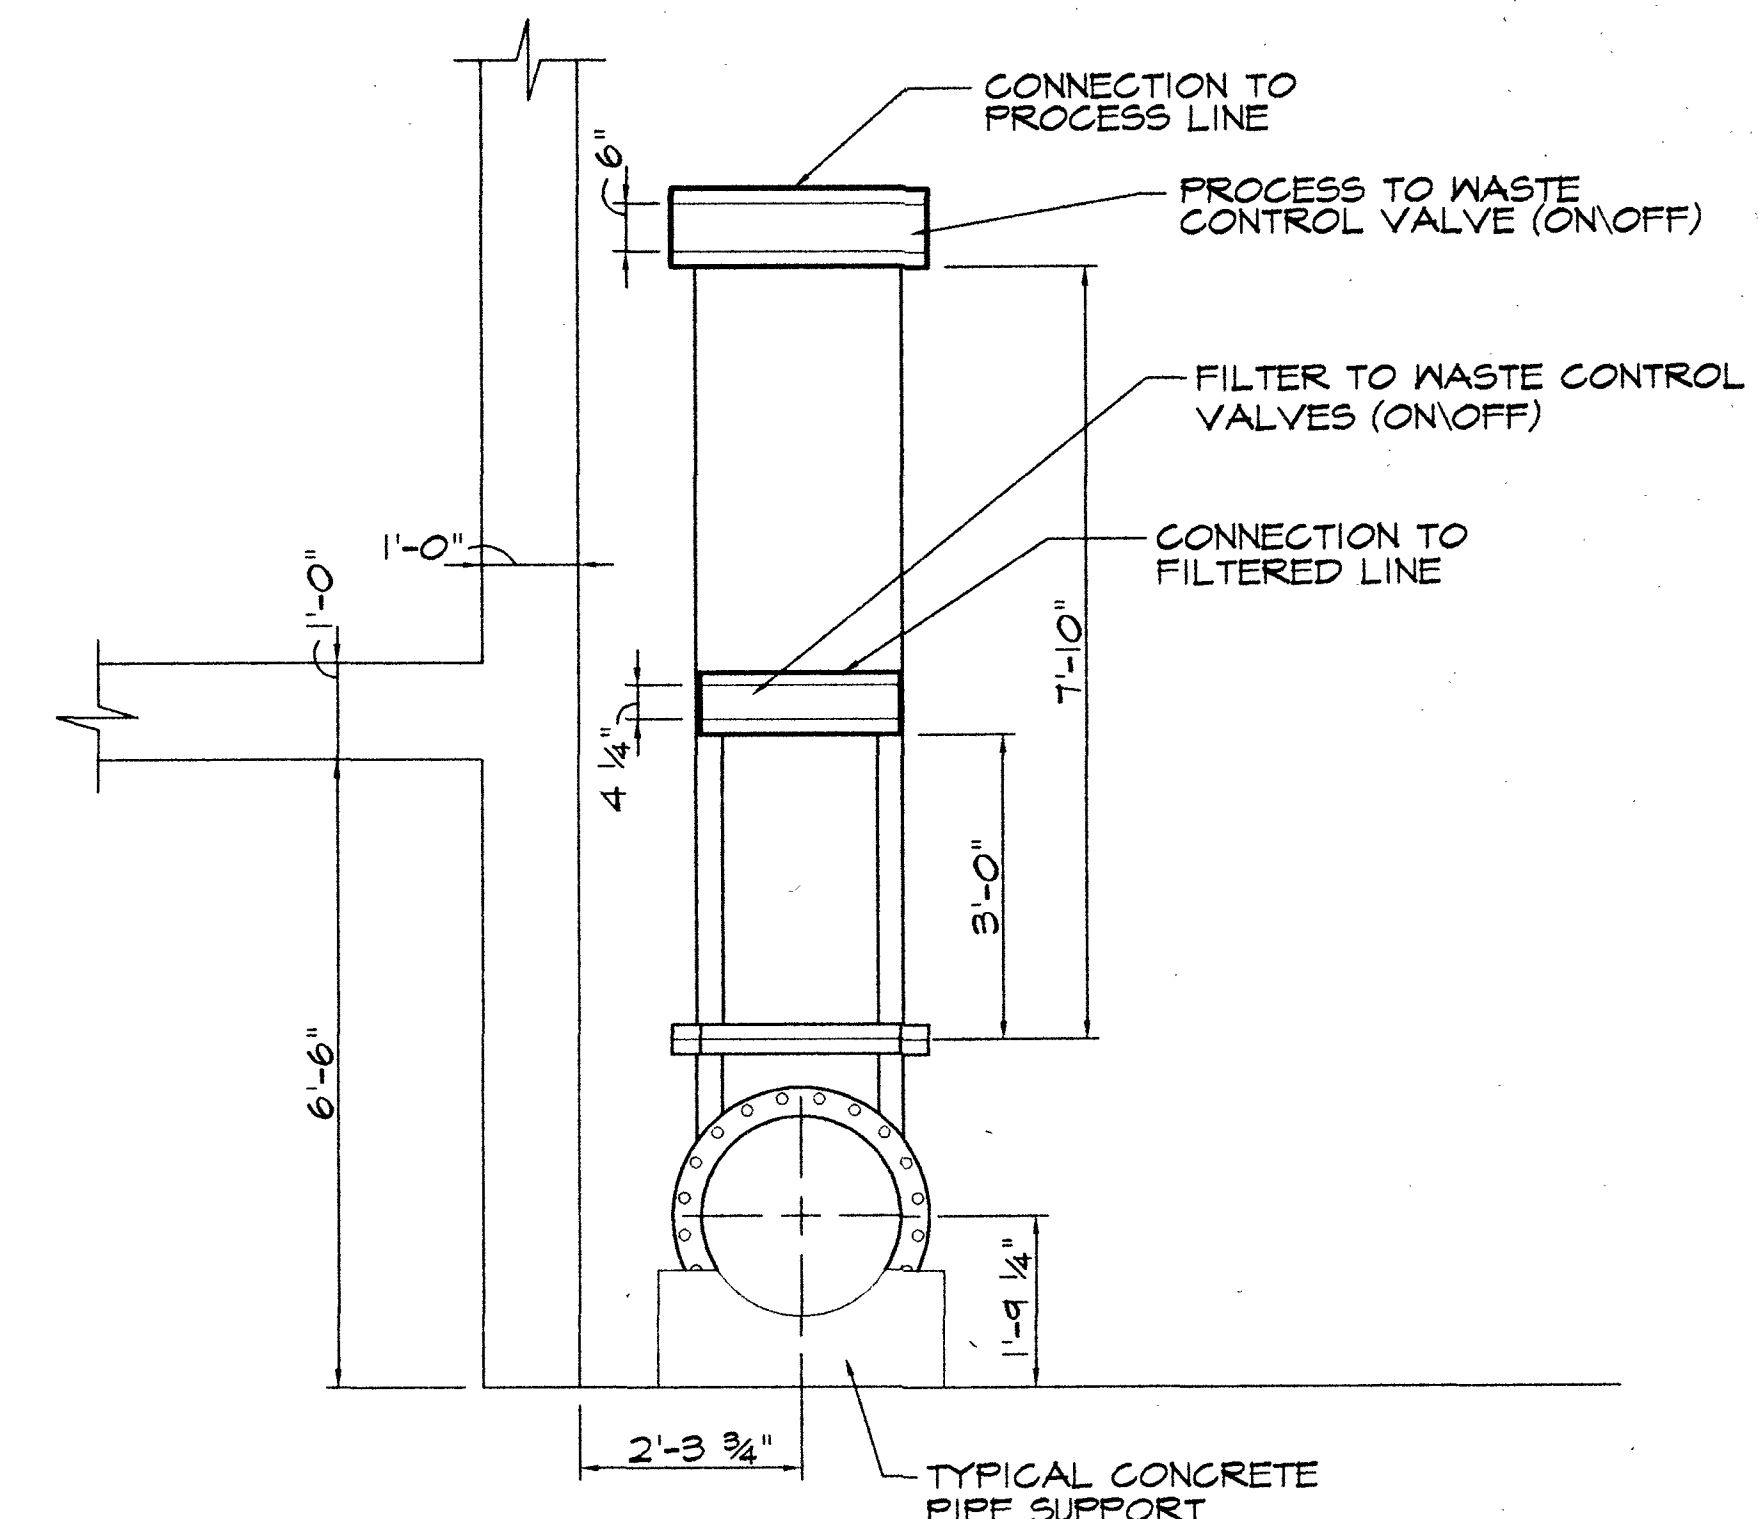

WASTE PIPING SECTION
SCALE 1" = 2'-0" • OUTSIDE BUILDING WALL

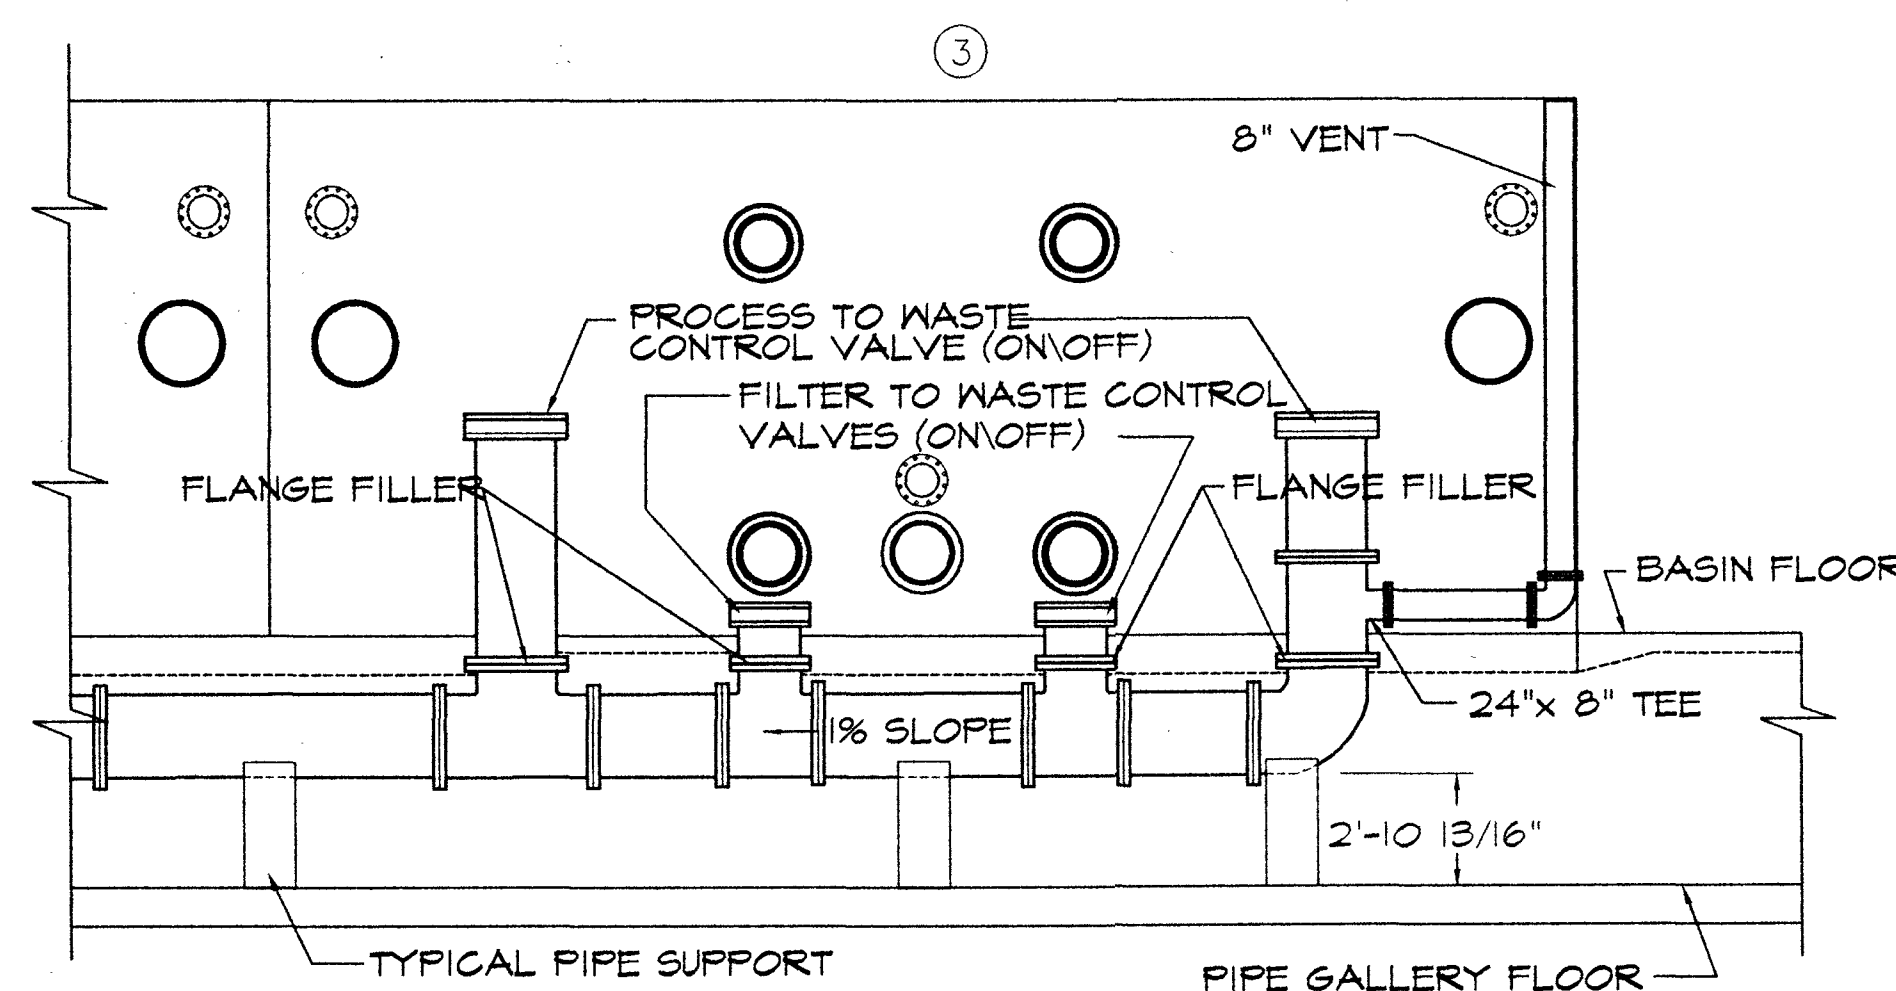


BASIN #3 - WASTE PIPING ELEVATION
SCALE 1" = 5'-0"


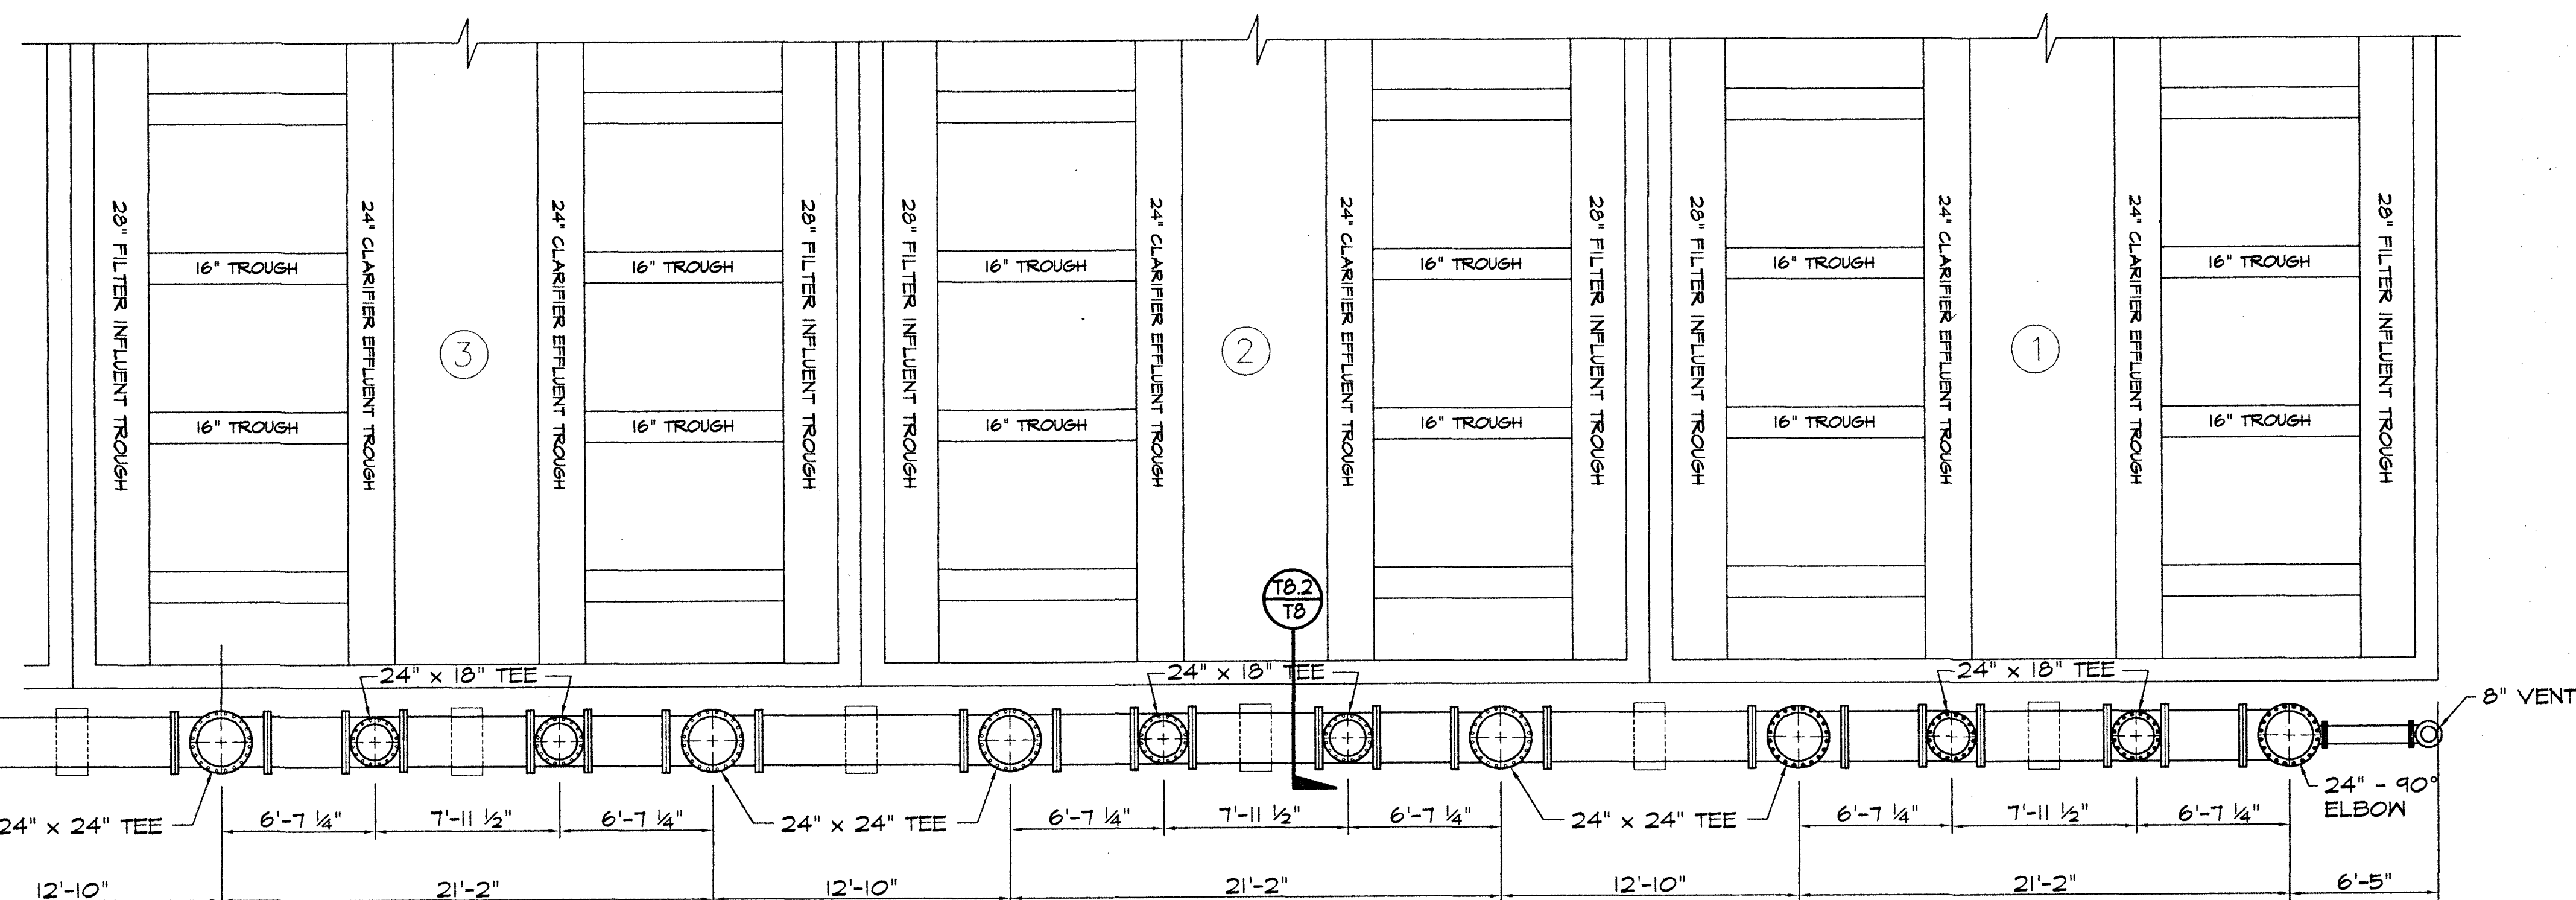


WASTE PIPING PLAN
SCALE 1" = 5'-0"

- NOTES
1. ALL WASTE PIPING TO BE 304 STAINLESS STEEL RATED AT 125 PSI
 2. ALL CONTROL VALVES TO BE SUPPLIED BY OTHERS
 3. CONTROL VALVE (ON/OFF): MOTORIZED ON/OFF BUTTERFLY VALVE WITH HAND OPERATOR

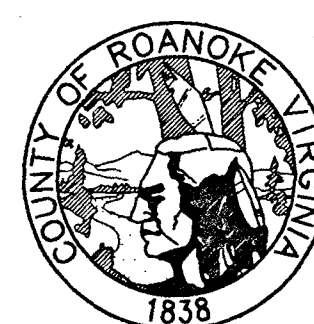

ROANOKE COUNTY WATER TREATMENT FACILITY

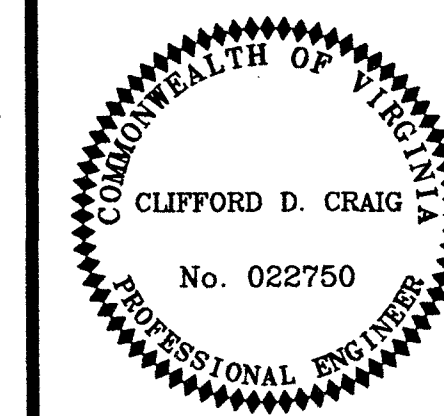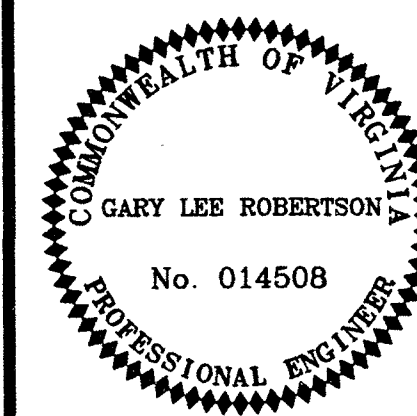

WASTE PIPING DIAGRAM

DESIGN ENGINEER
CLIFFORD D. CRAIG

COMMISSION NUMBER
1913

ROUD NUMBER
WTF-1

DATE
12 SEPT. 1994

T8