



AIR PIPING FRONT ELEVATION
SCALE 1" = 5'-0"

T9.1
T9

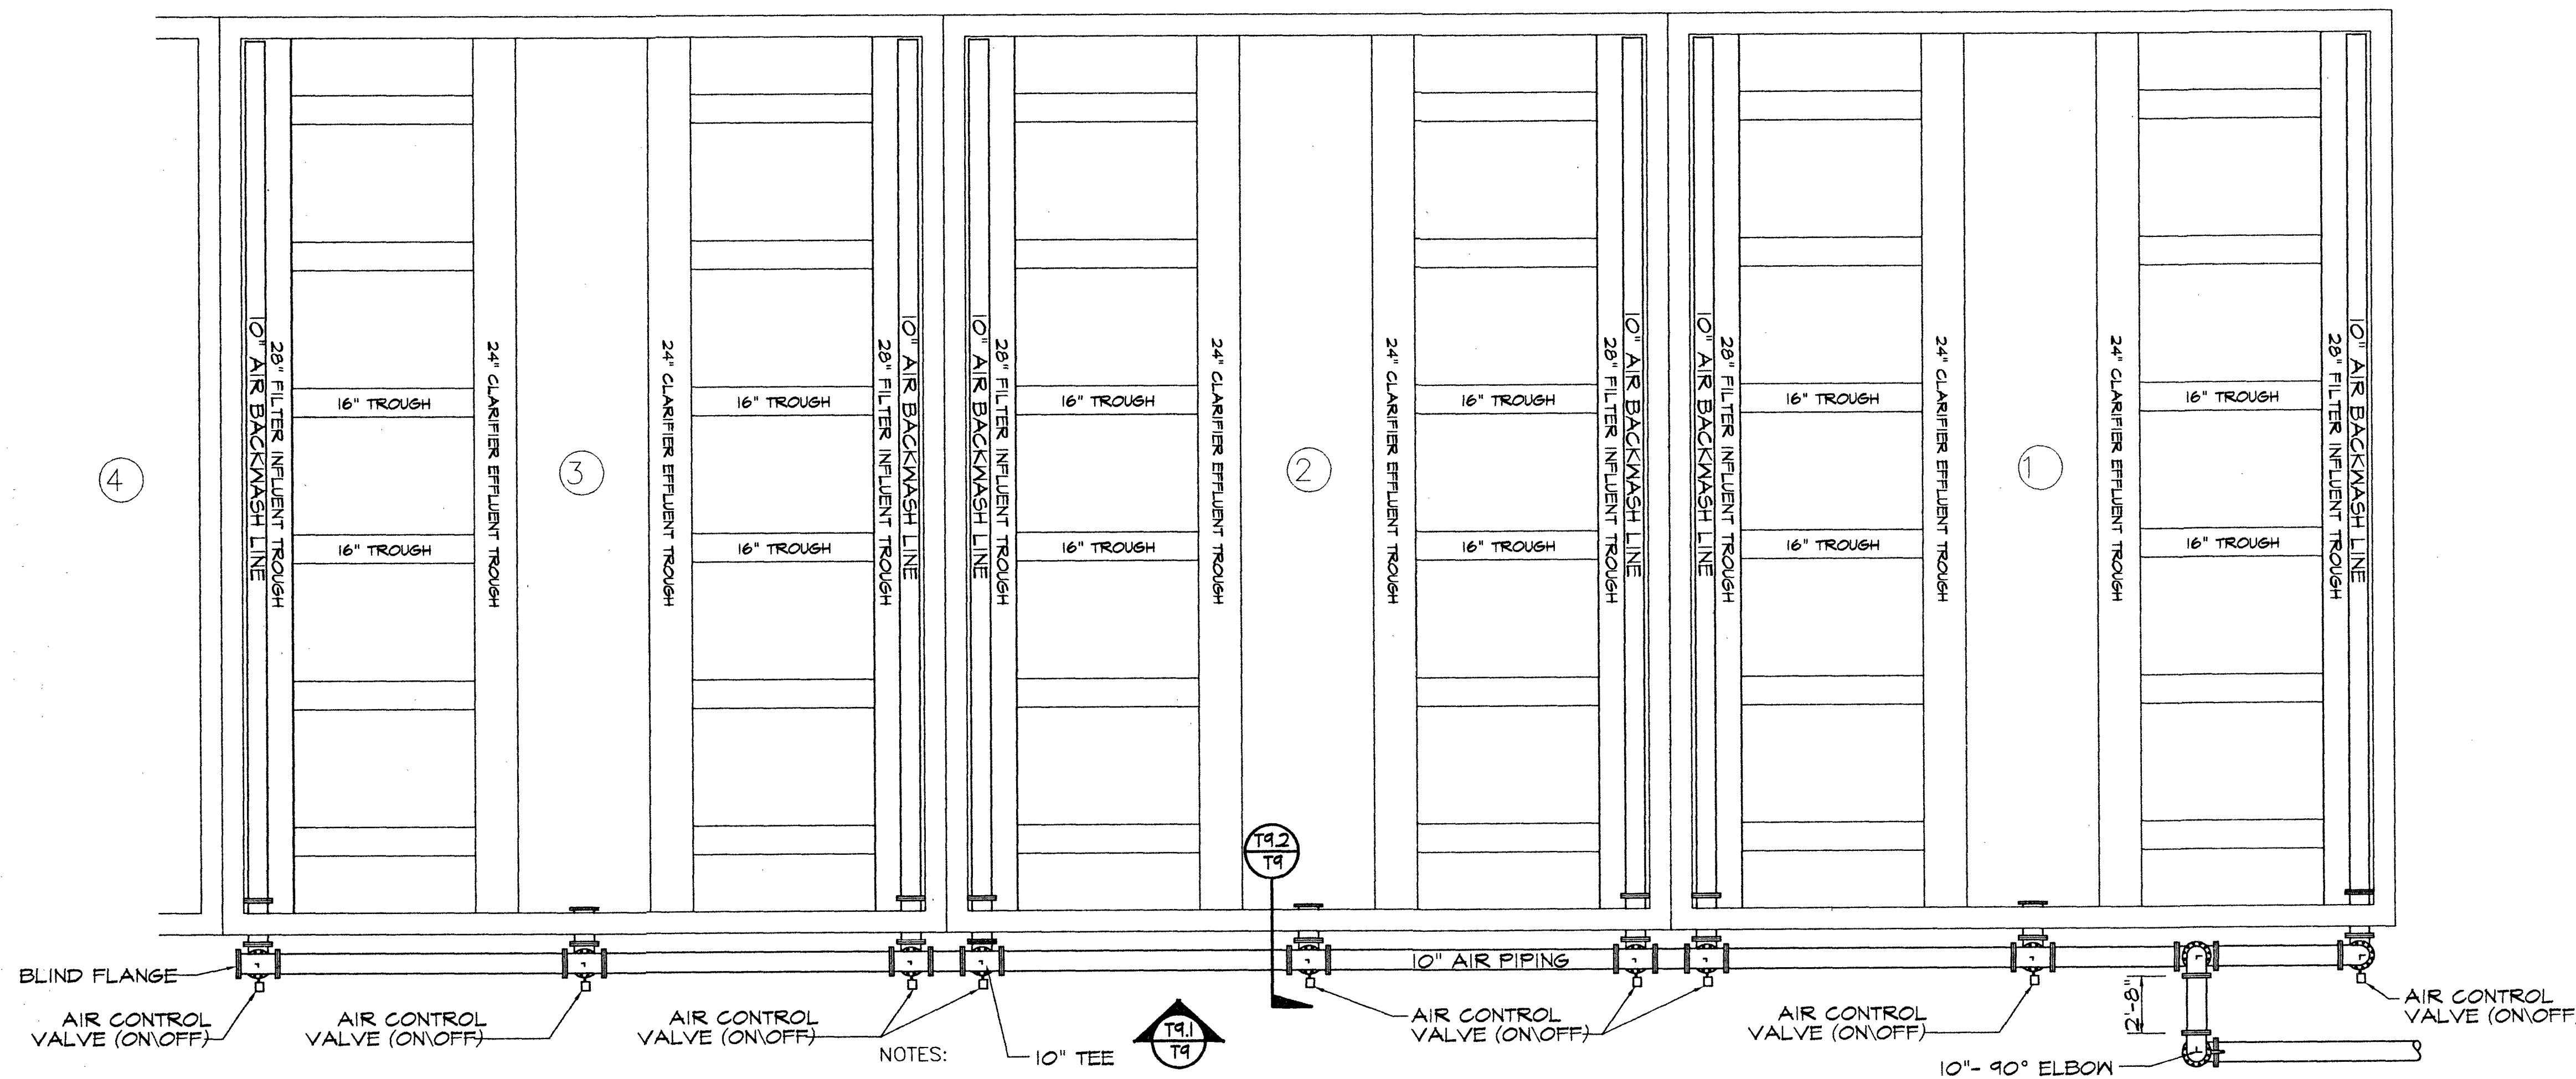


AIR PIPING PLAN
SCALE 1" = 5'-0"

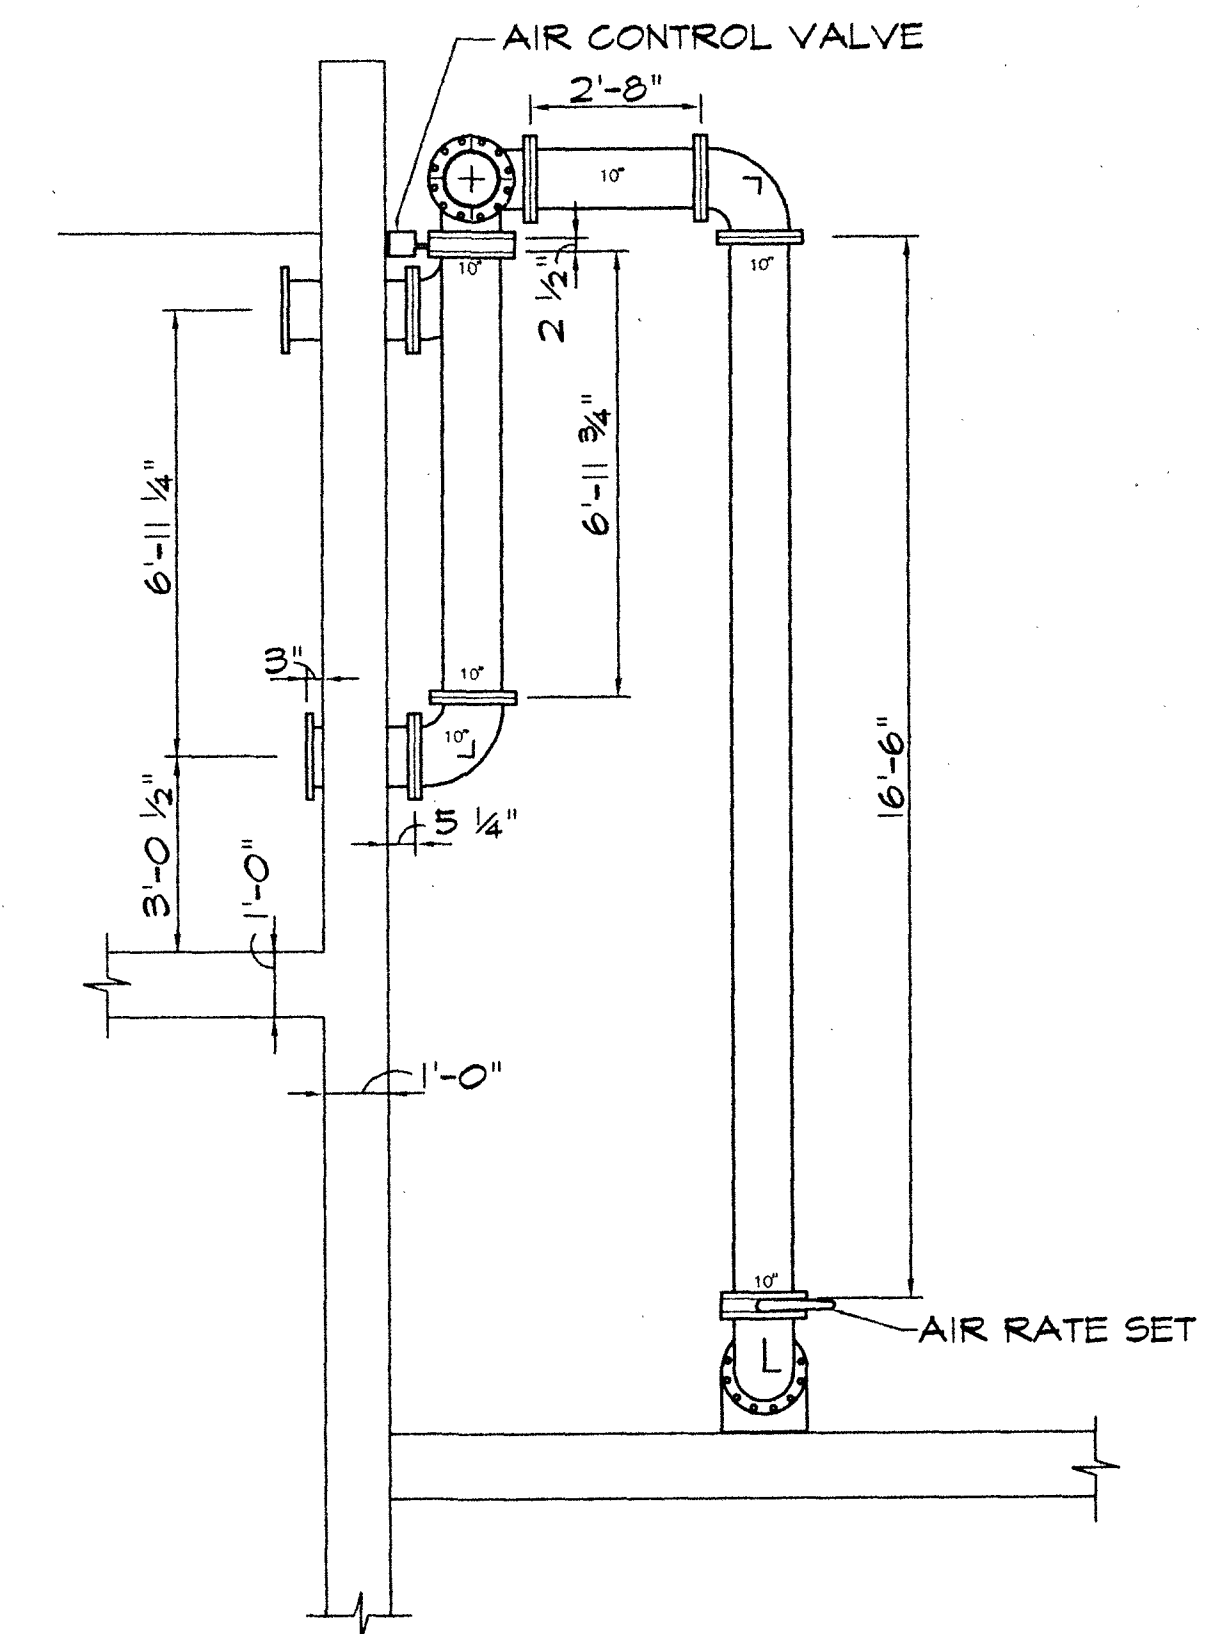



AIR PIPING SECTION
NOT TO SCALE

T9.2
T9

- NOTES
1. ALL AIR PIPING AND FITTINGS TO BE 304 STAINLESS STEEL RATED AT 125 PSI
 2. ALL CONTROL VALVES TO BE SUPPLIED BY OTHERS
 3. CONTROL VALVE (ON/OFF): MOTORIZED ON/OFF BUTTERFLY VALVE WITH HAND OPERATOR
 4. AIR PIPING ON INSIDE OF BASINS SHALL BE SECURELY FASTENED TO CONCRETE BASIN WALL USING OWNER APPROVED STAINLESS STEEL BRACKETS.

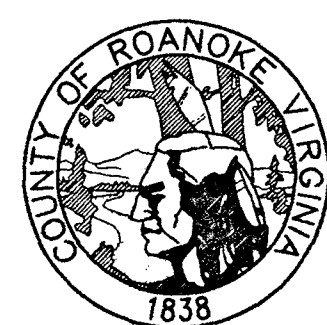

**ROANOKE COUNTY
WATER TREATMENT
FACILITY**

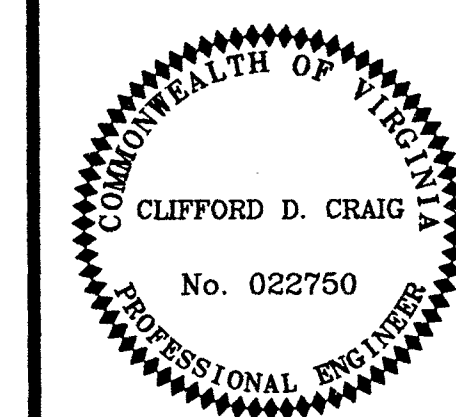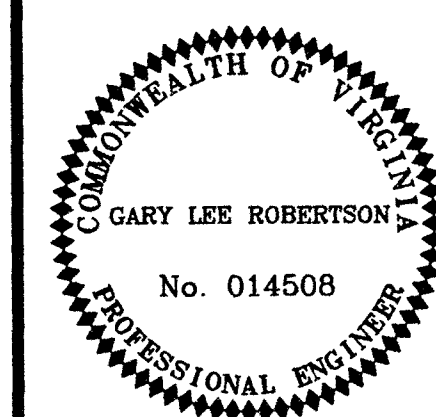

AIR PIPING DIAGRAM

DESIGN ENGINEER
CLIFFORD D. CRAIG

COMMISSION NUMBER
1913

RCUD NUMBER
WTF-1

DATE
9 SEPT. 1994

T9