

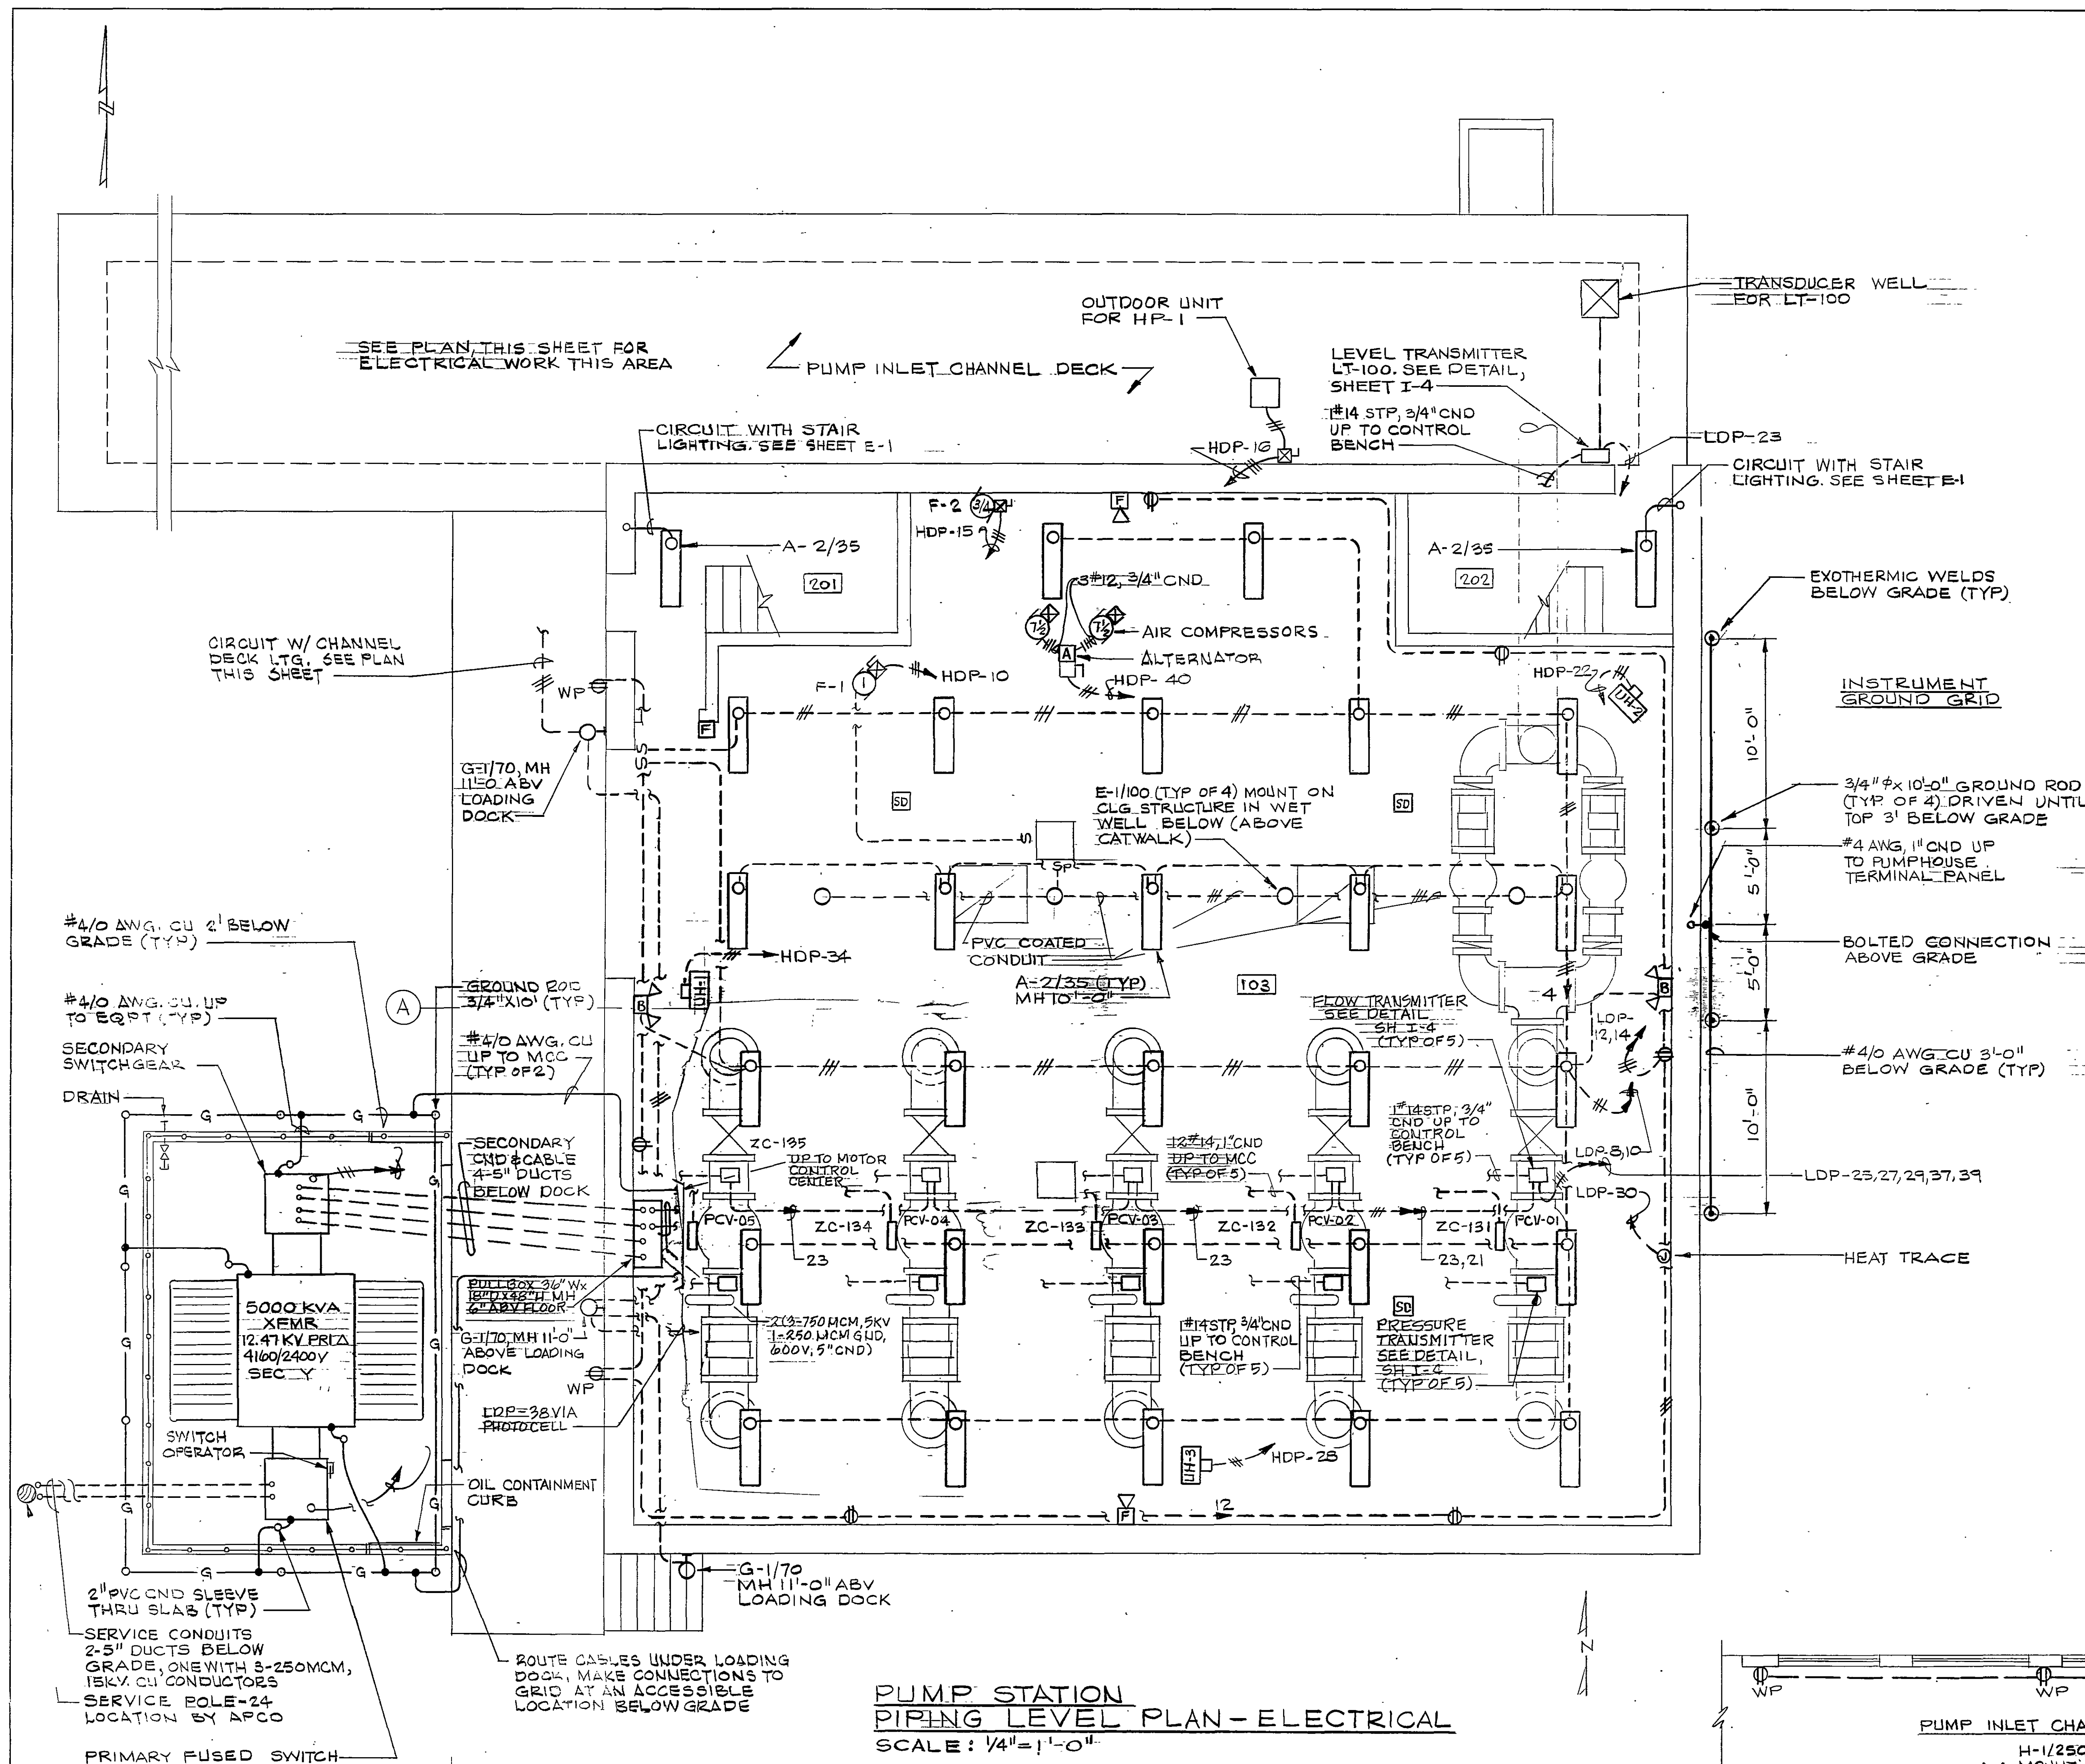


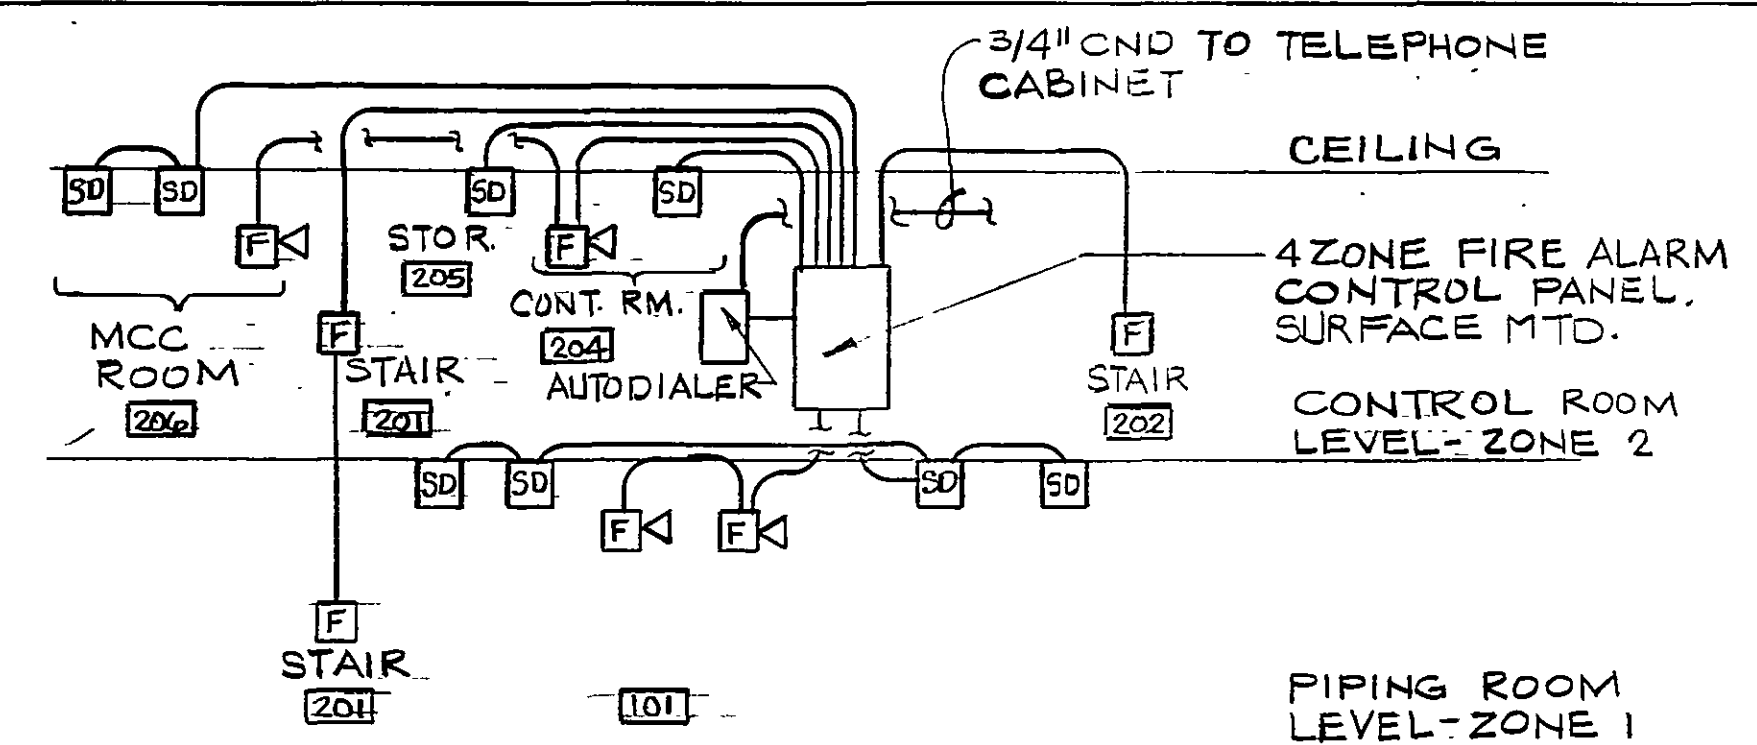


**PUMP STATION
PIPING LEVEL PLAN - ELECTRICAL**
SCALE: 1/4" = 1'-0"


GRAPHIC SCALE

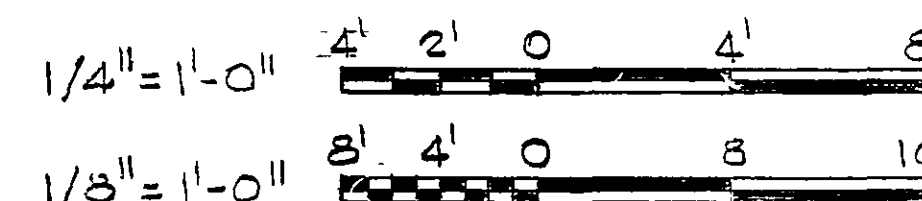

FIRE ALARM RISER DIAGRAM
NO SCALE
NOTE: ZONES 3 AND 4 ARE SPARE

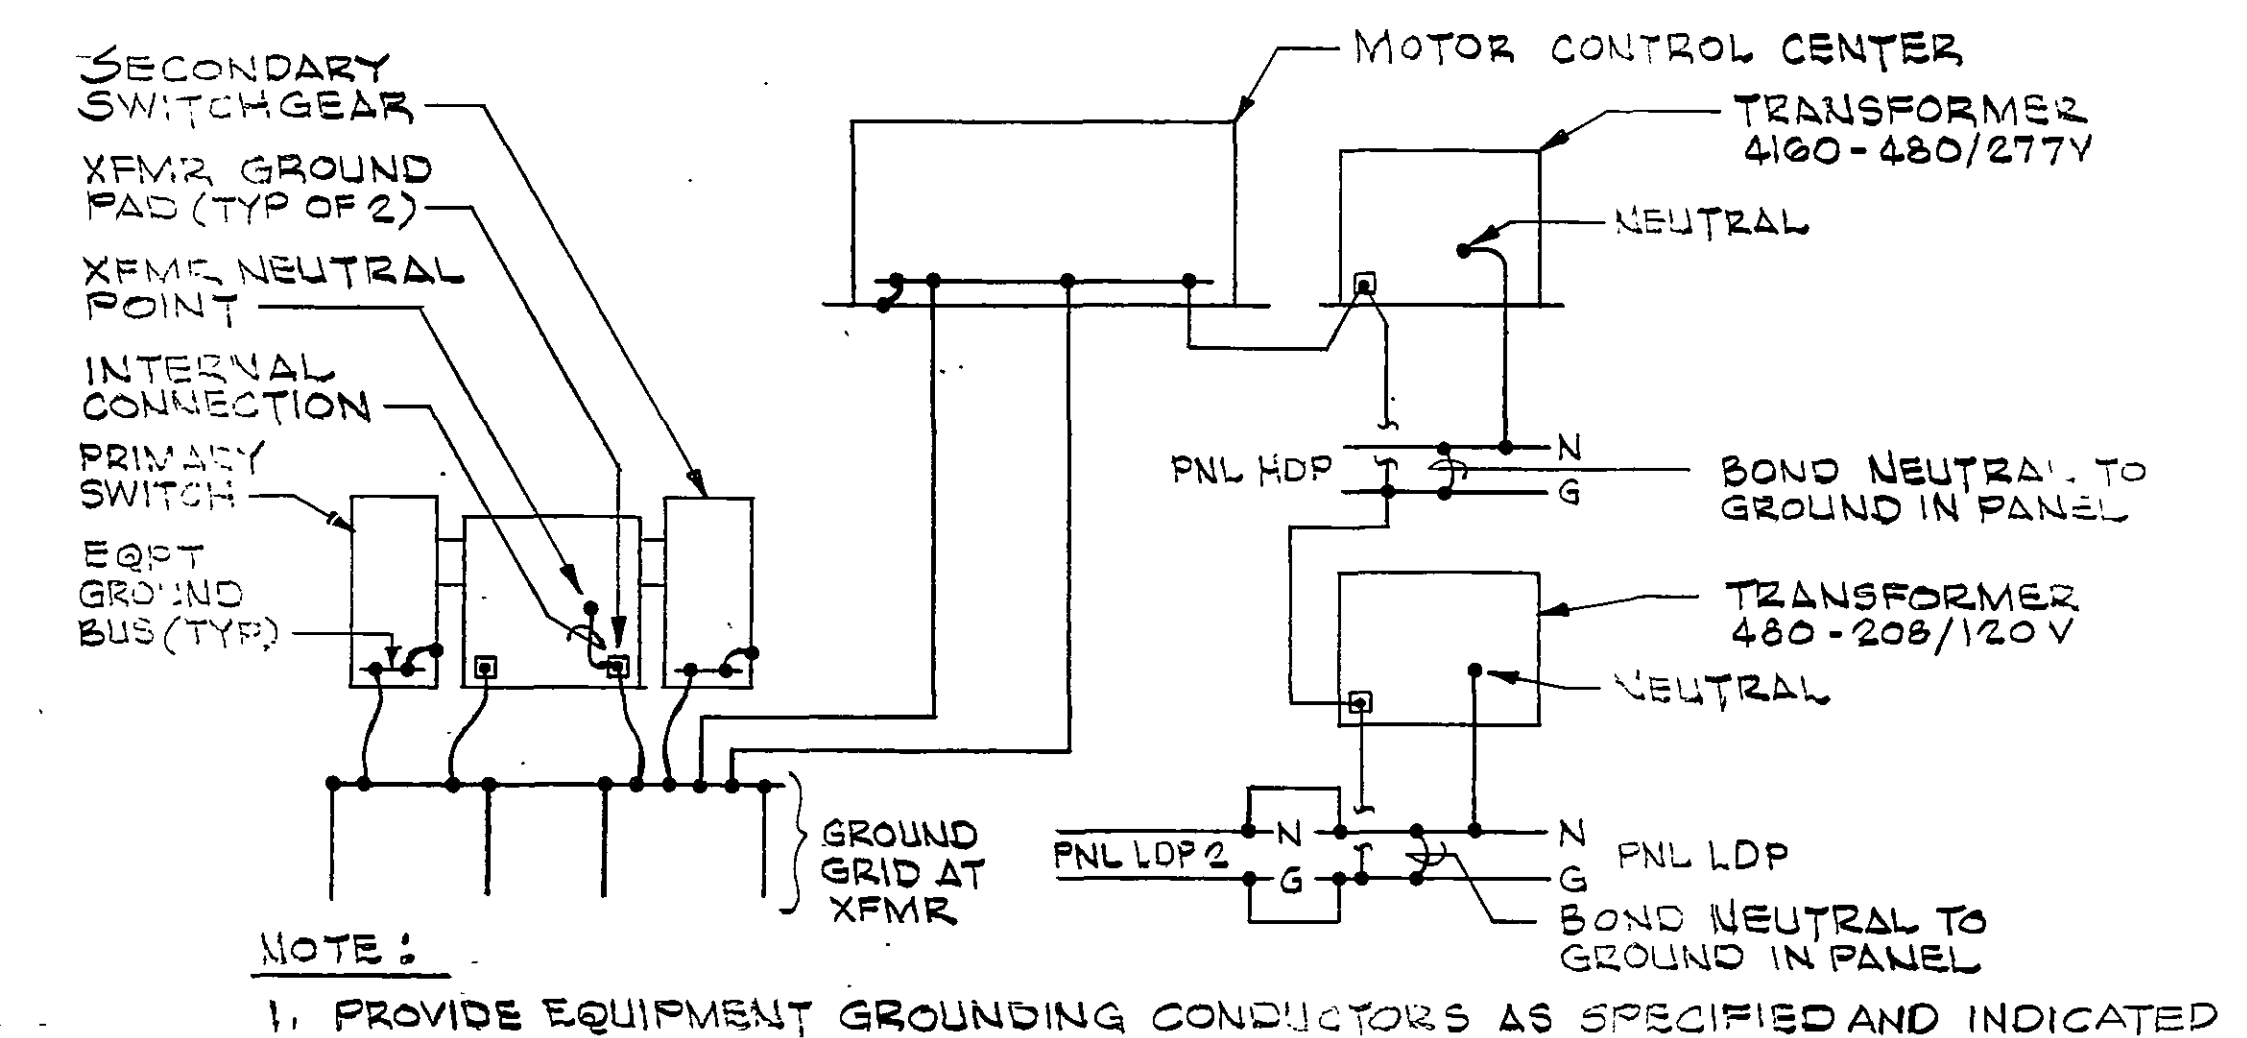


POWER SYSTEM GROUNDING DIAGRAM
NO SCALE

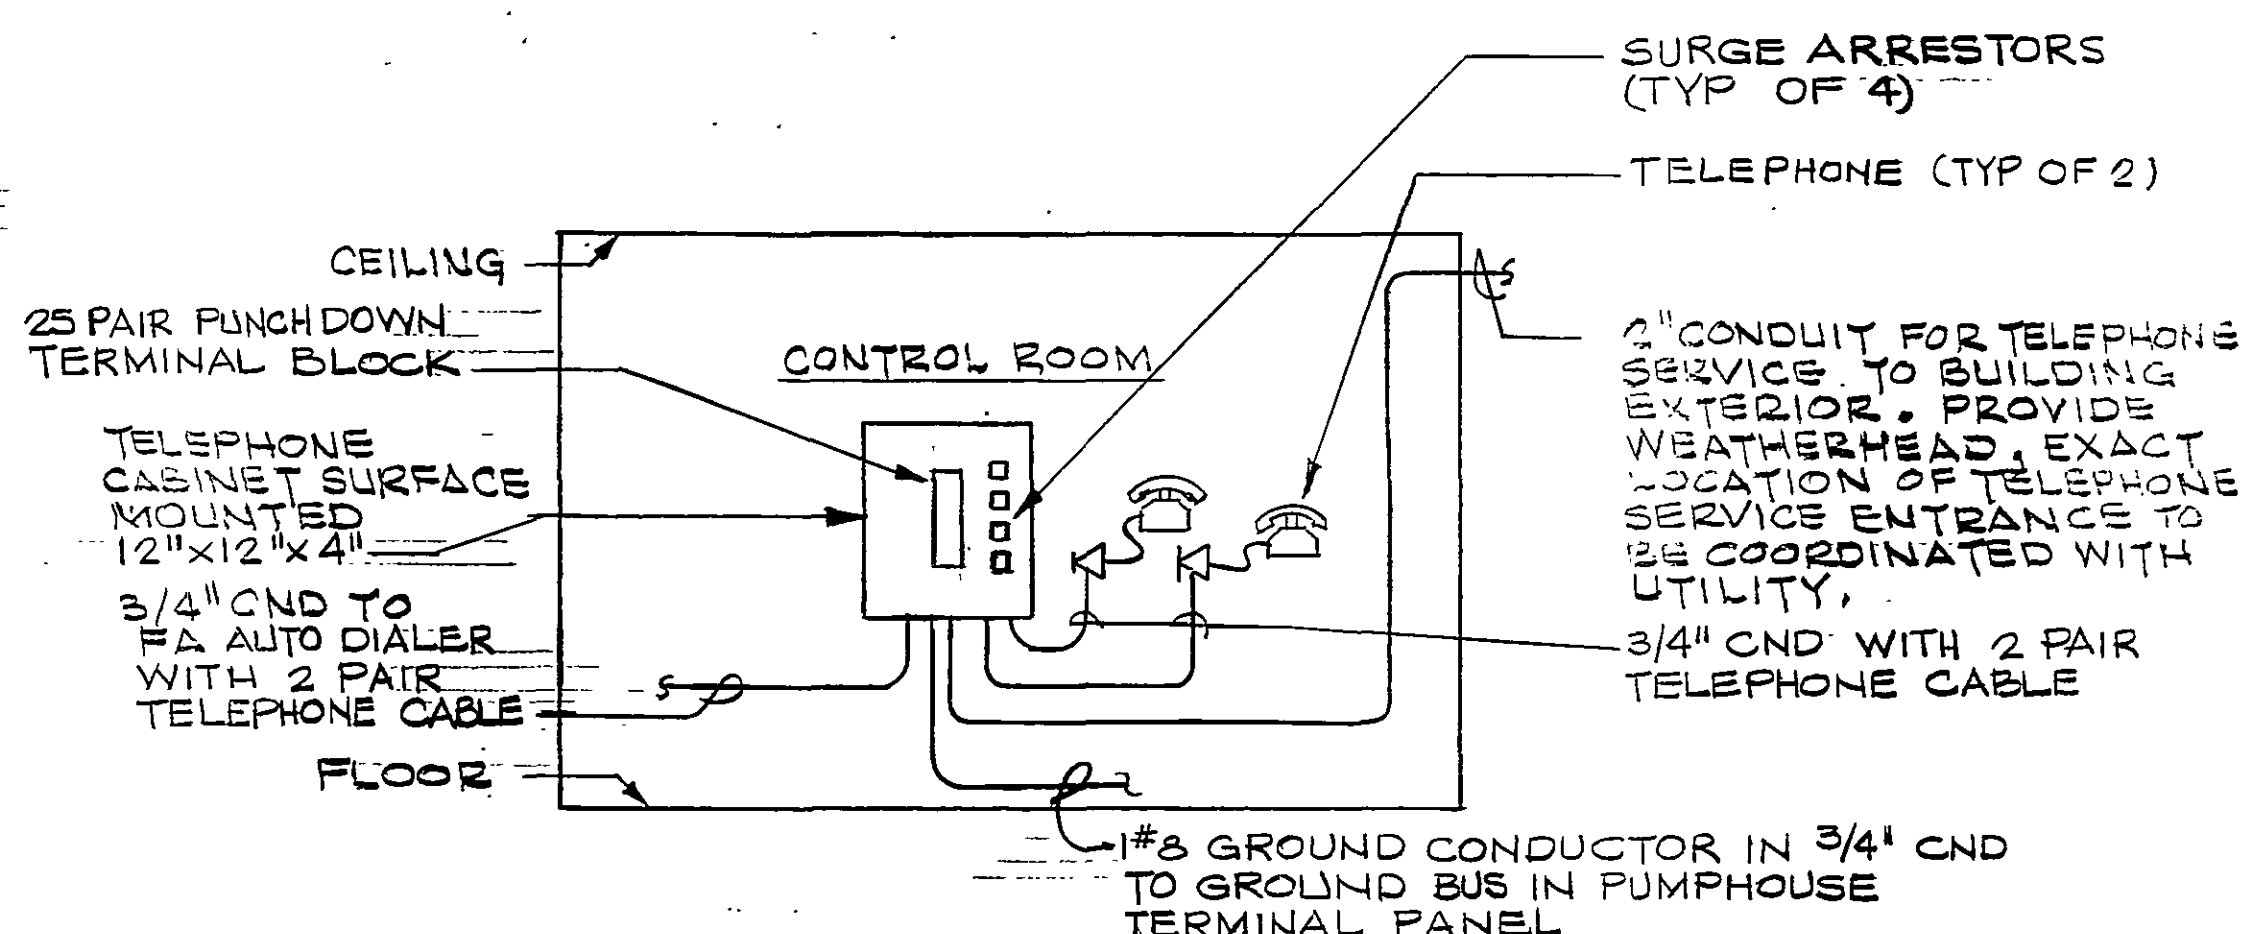


TELEPHONE RISER DIAGRAM
NO SCALE

PROVIDE AND CONNECT ALL TELEPHONES AND WIRING ON PREMISES. PROVIDE TELEPHONE SERVICE ENTRANCE CONDUIT. TELEPHONE CO. SHALL PROVIDE CONDUCTORS INTO TERMINAL CABINET AND CONNECT SERVICE.

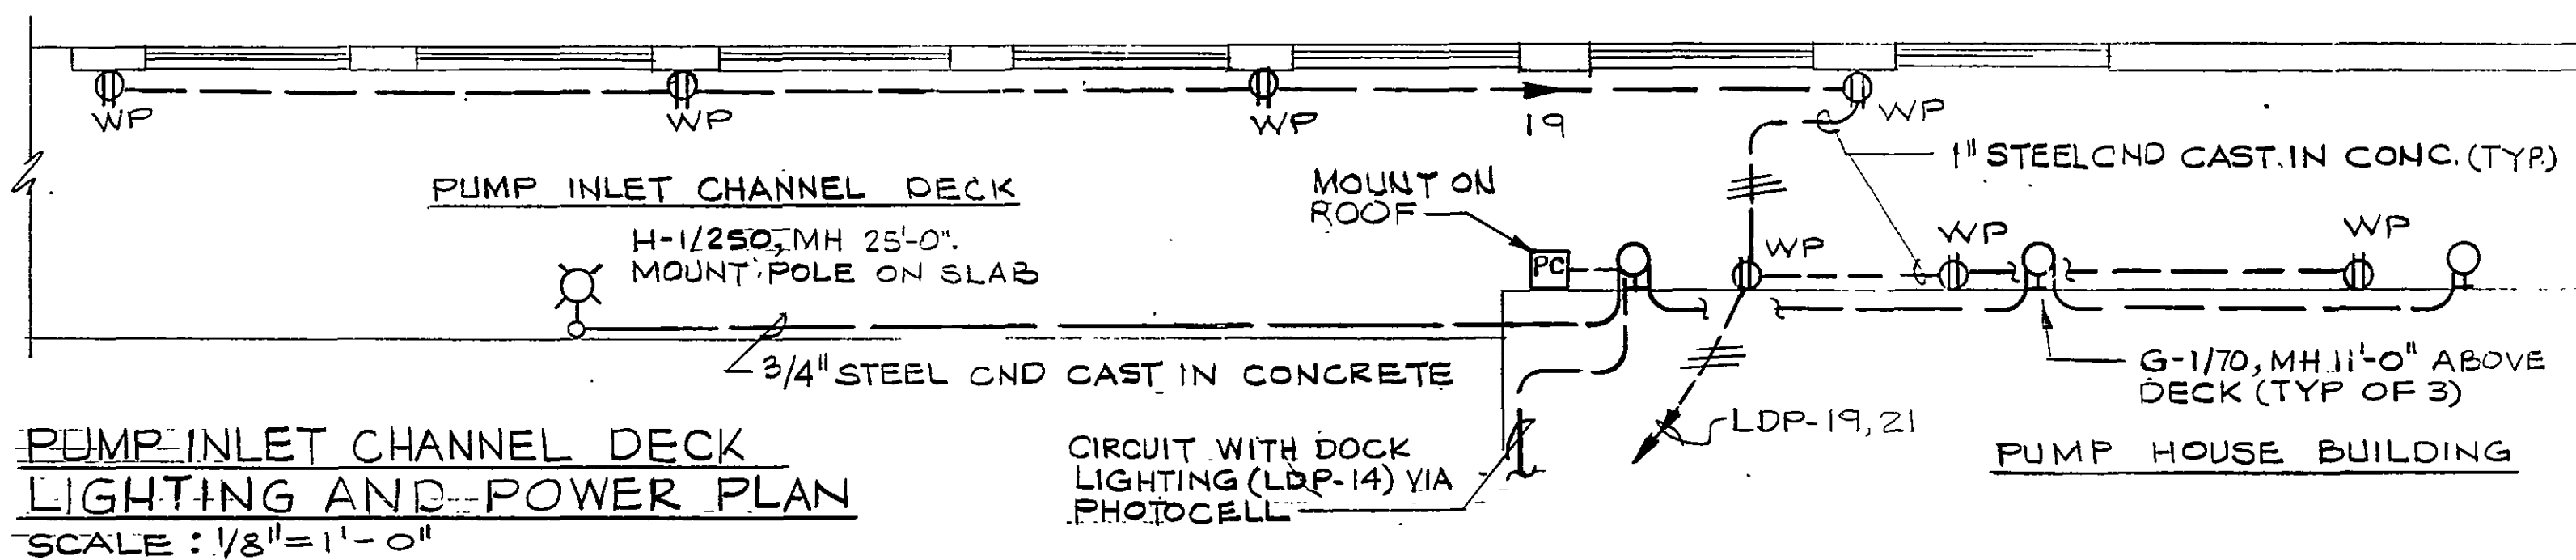


**PUMP INLET CHANNEL DECK
LIGHTING AND POWER PLAN**
SCALE: 1/8" = 1'-0"

DESIGNED: *SLG* DATE: 1/20/90
DRAWN: *SLG* DATE: 3/30/90
CHECKED: *SLG* DATE: 3/30/90
APPROVED: *SLG* DATE: 8/21/91
ISSUED: *SLG* DATE: 8/21/91

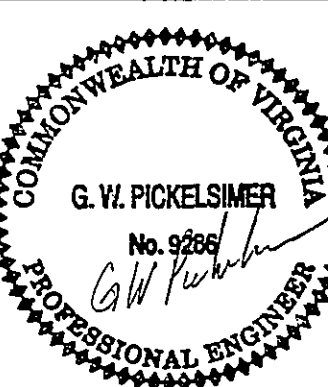

DATE	BY	DESCRIPTION	DATE	BY	DESCRIPTION
8-15-94	BA	PER CONTR RECORD DWG			
2-5-95	JBH	ISSUED TO VA. DAM SAFETY			
3-31-97	RWF	RECORD DRAWING			

RECORD DRAWINGS
THESE DRAWINGS RECORDED ON THE BASIS OF INFORMATION FURNISHED BY THE CONTRACTOR OR SPECIFICALLY KNOWN TO HSM. NO OTHER REPRESENTATIONS ARE MADE OR IMPLIED.
Date: 6-3-95

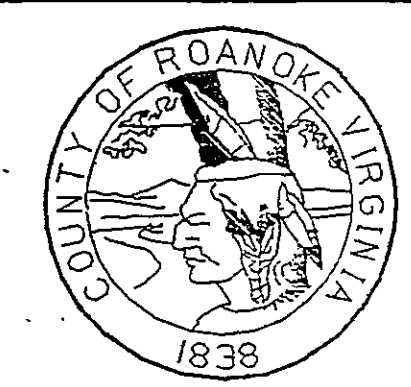

**SPRING HOLLOW RESERVOIR
ROANOKE COUNTY, VIRGINIA**
HAYES, SEAY, MATTERN & MATTERN, INC.
ARCHITECTS - ENGINEERS - PLANNERS
ROANOKE, VIRGINIA

ELECTRICAL INTAKE/PUMP STATION PIPING LEVEL				
SCALE	DATE	COMM	SHEET	DWG
AS NOTED	8/4/91	4194E	E-2	20