




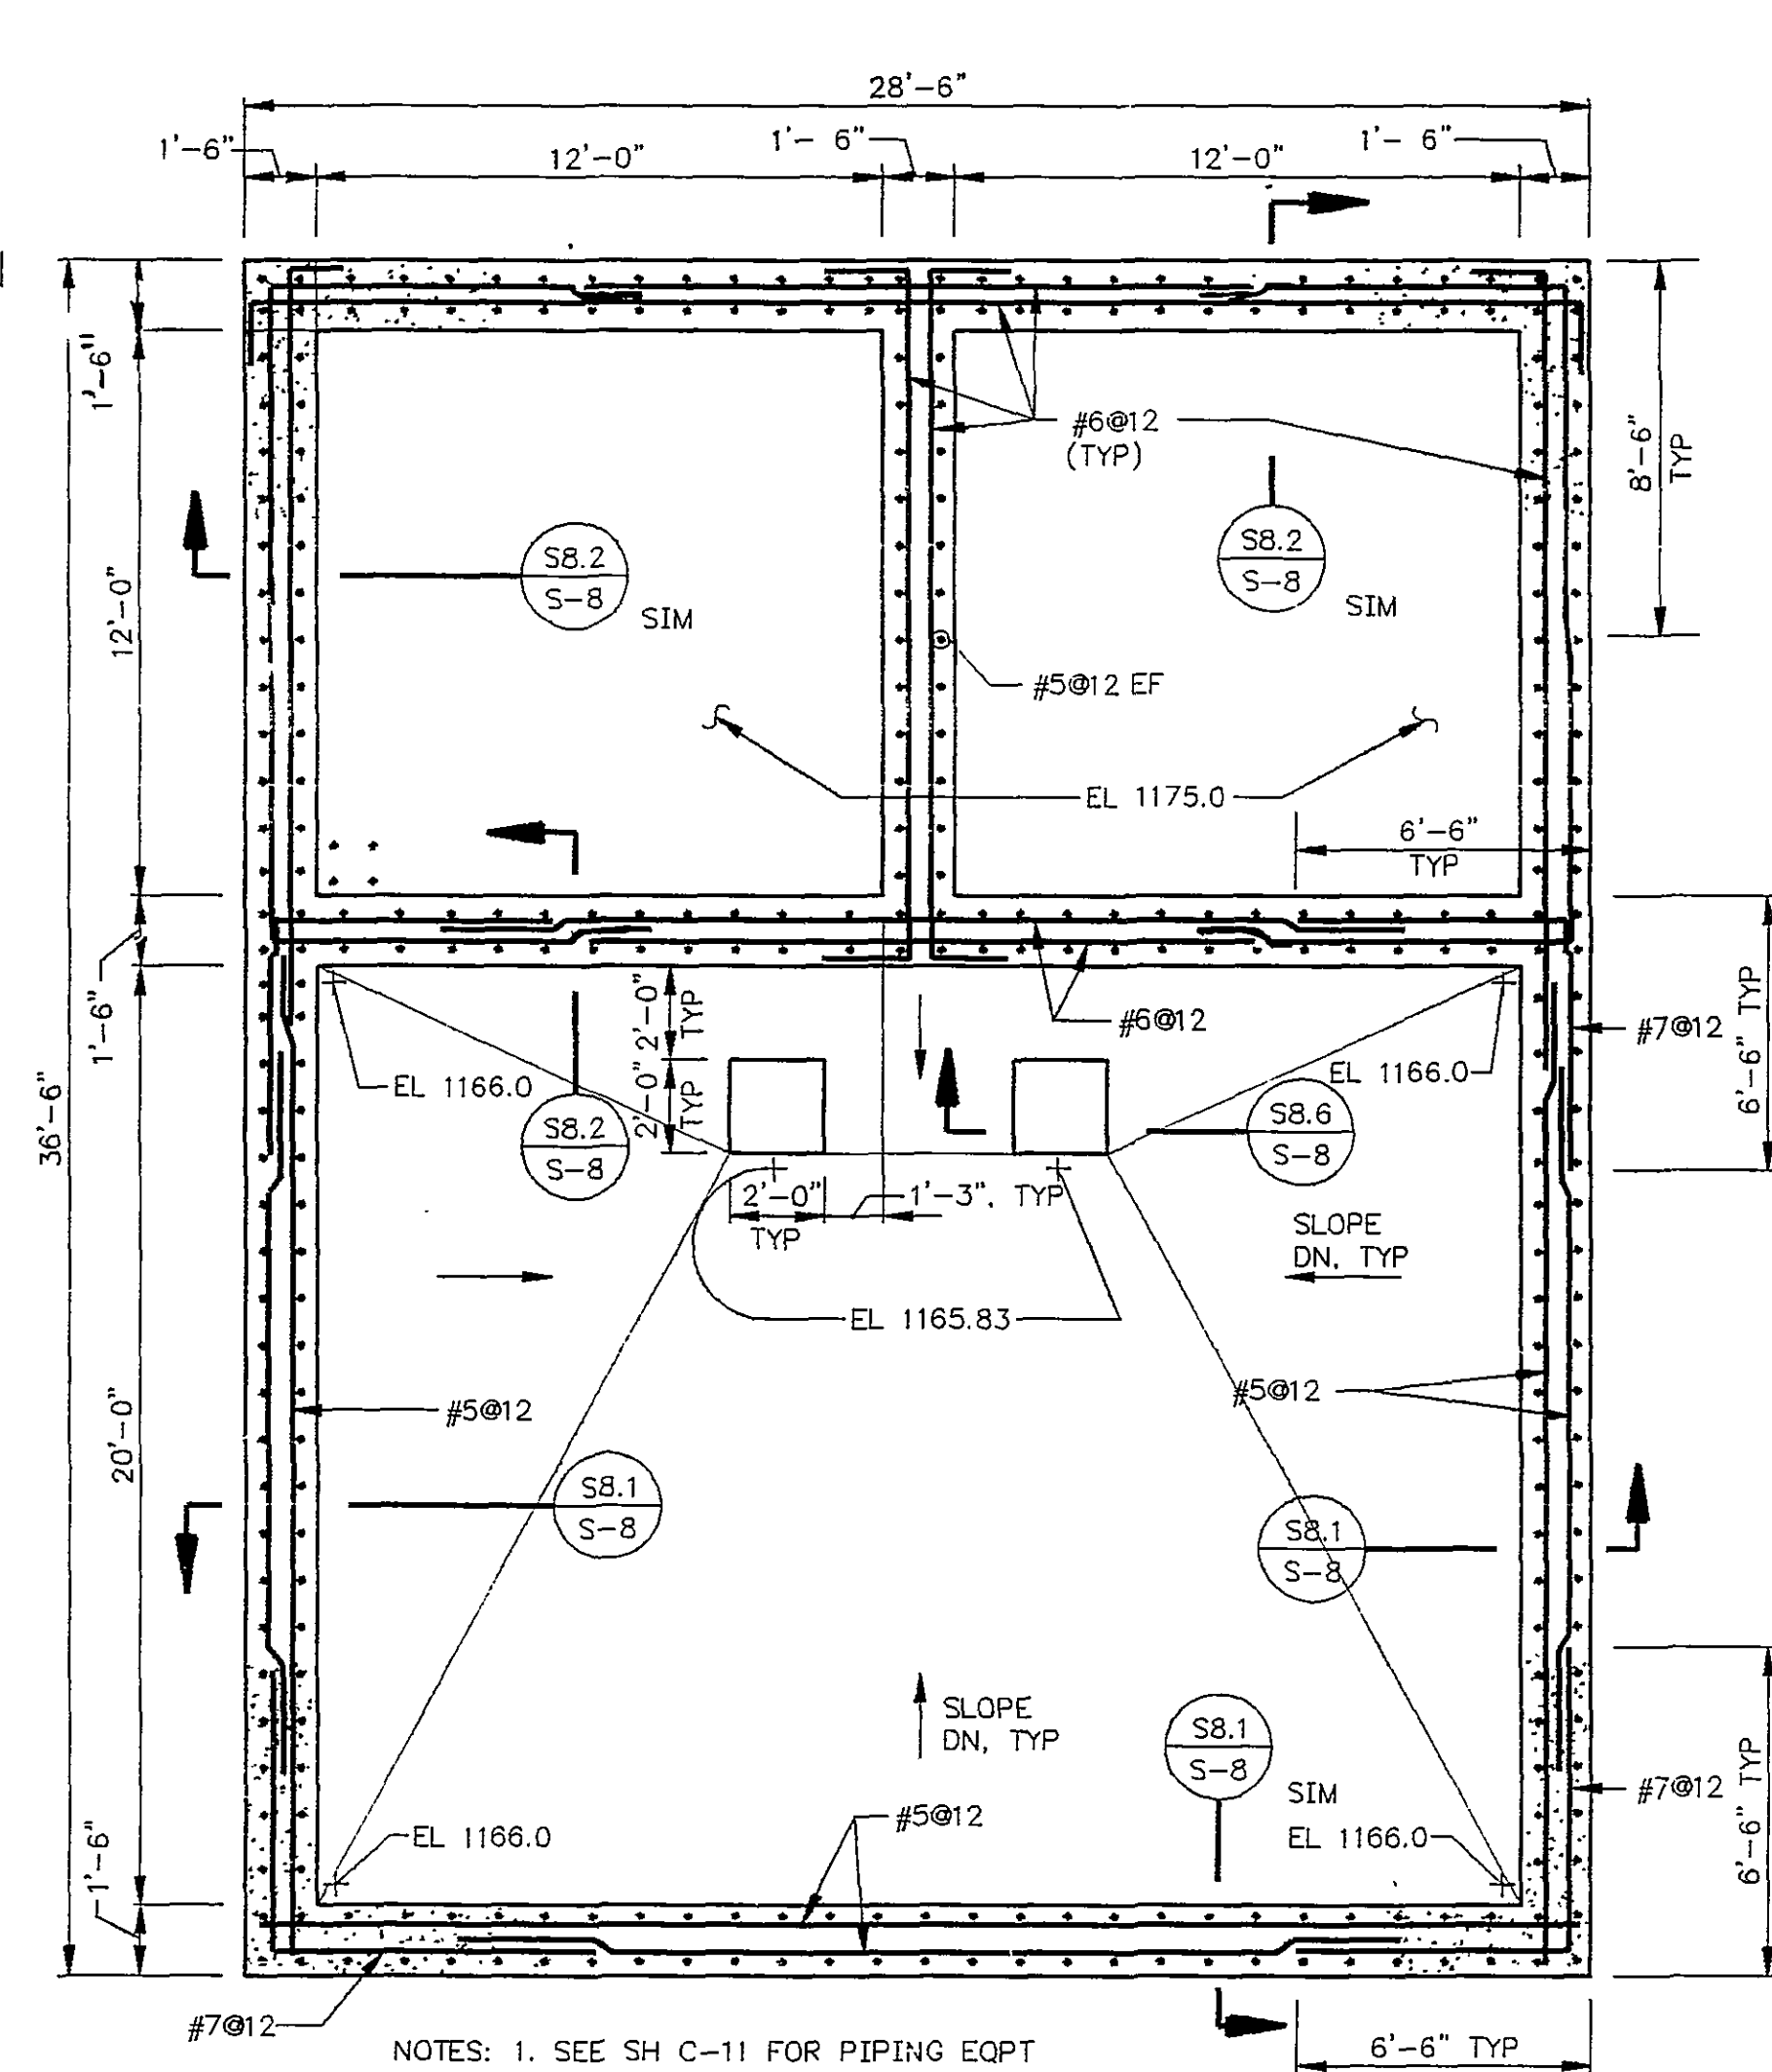


GATE HOUSE/ENERGY DISSIPATOR FDN PLAN
SCALE: 1/4"=1'-0"

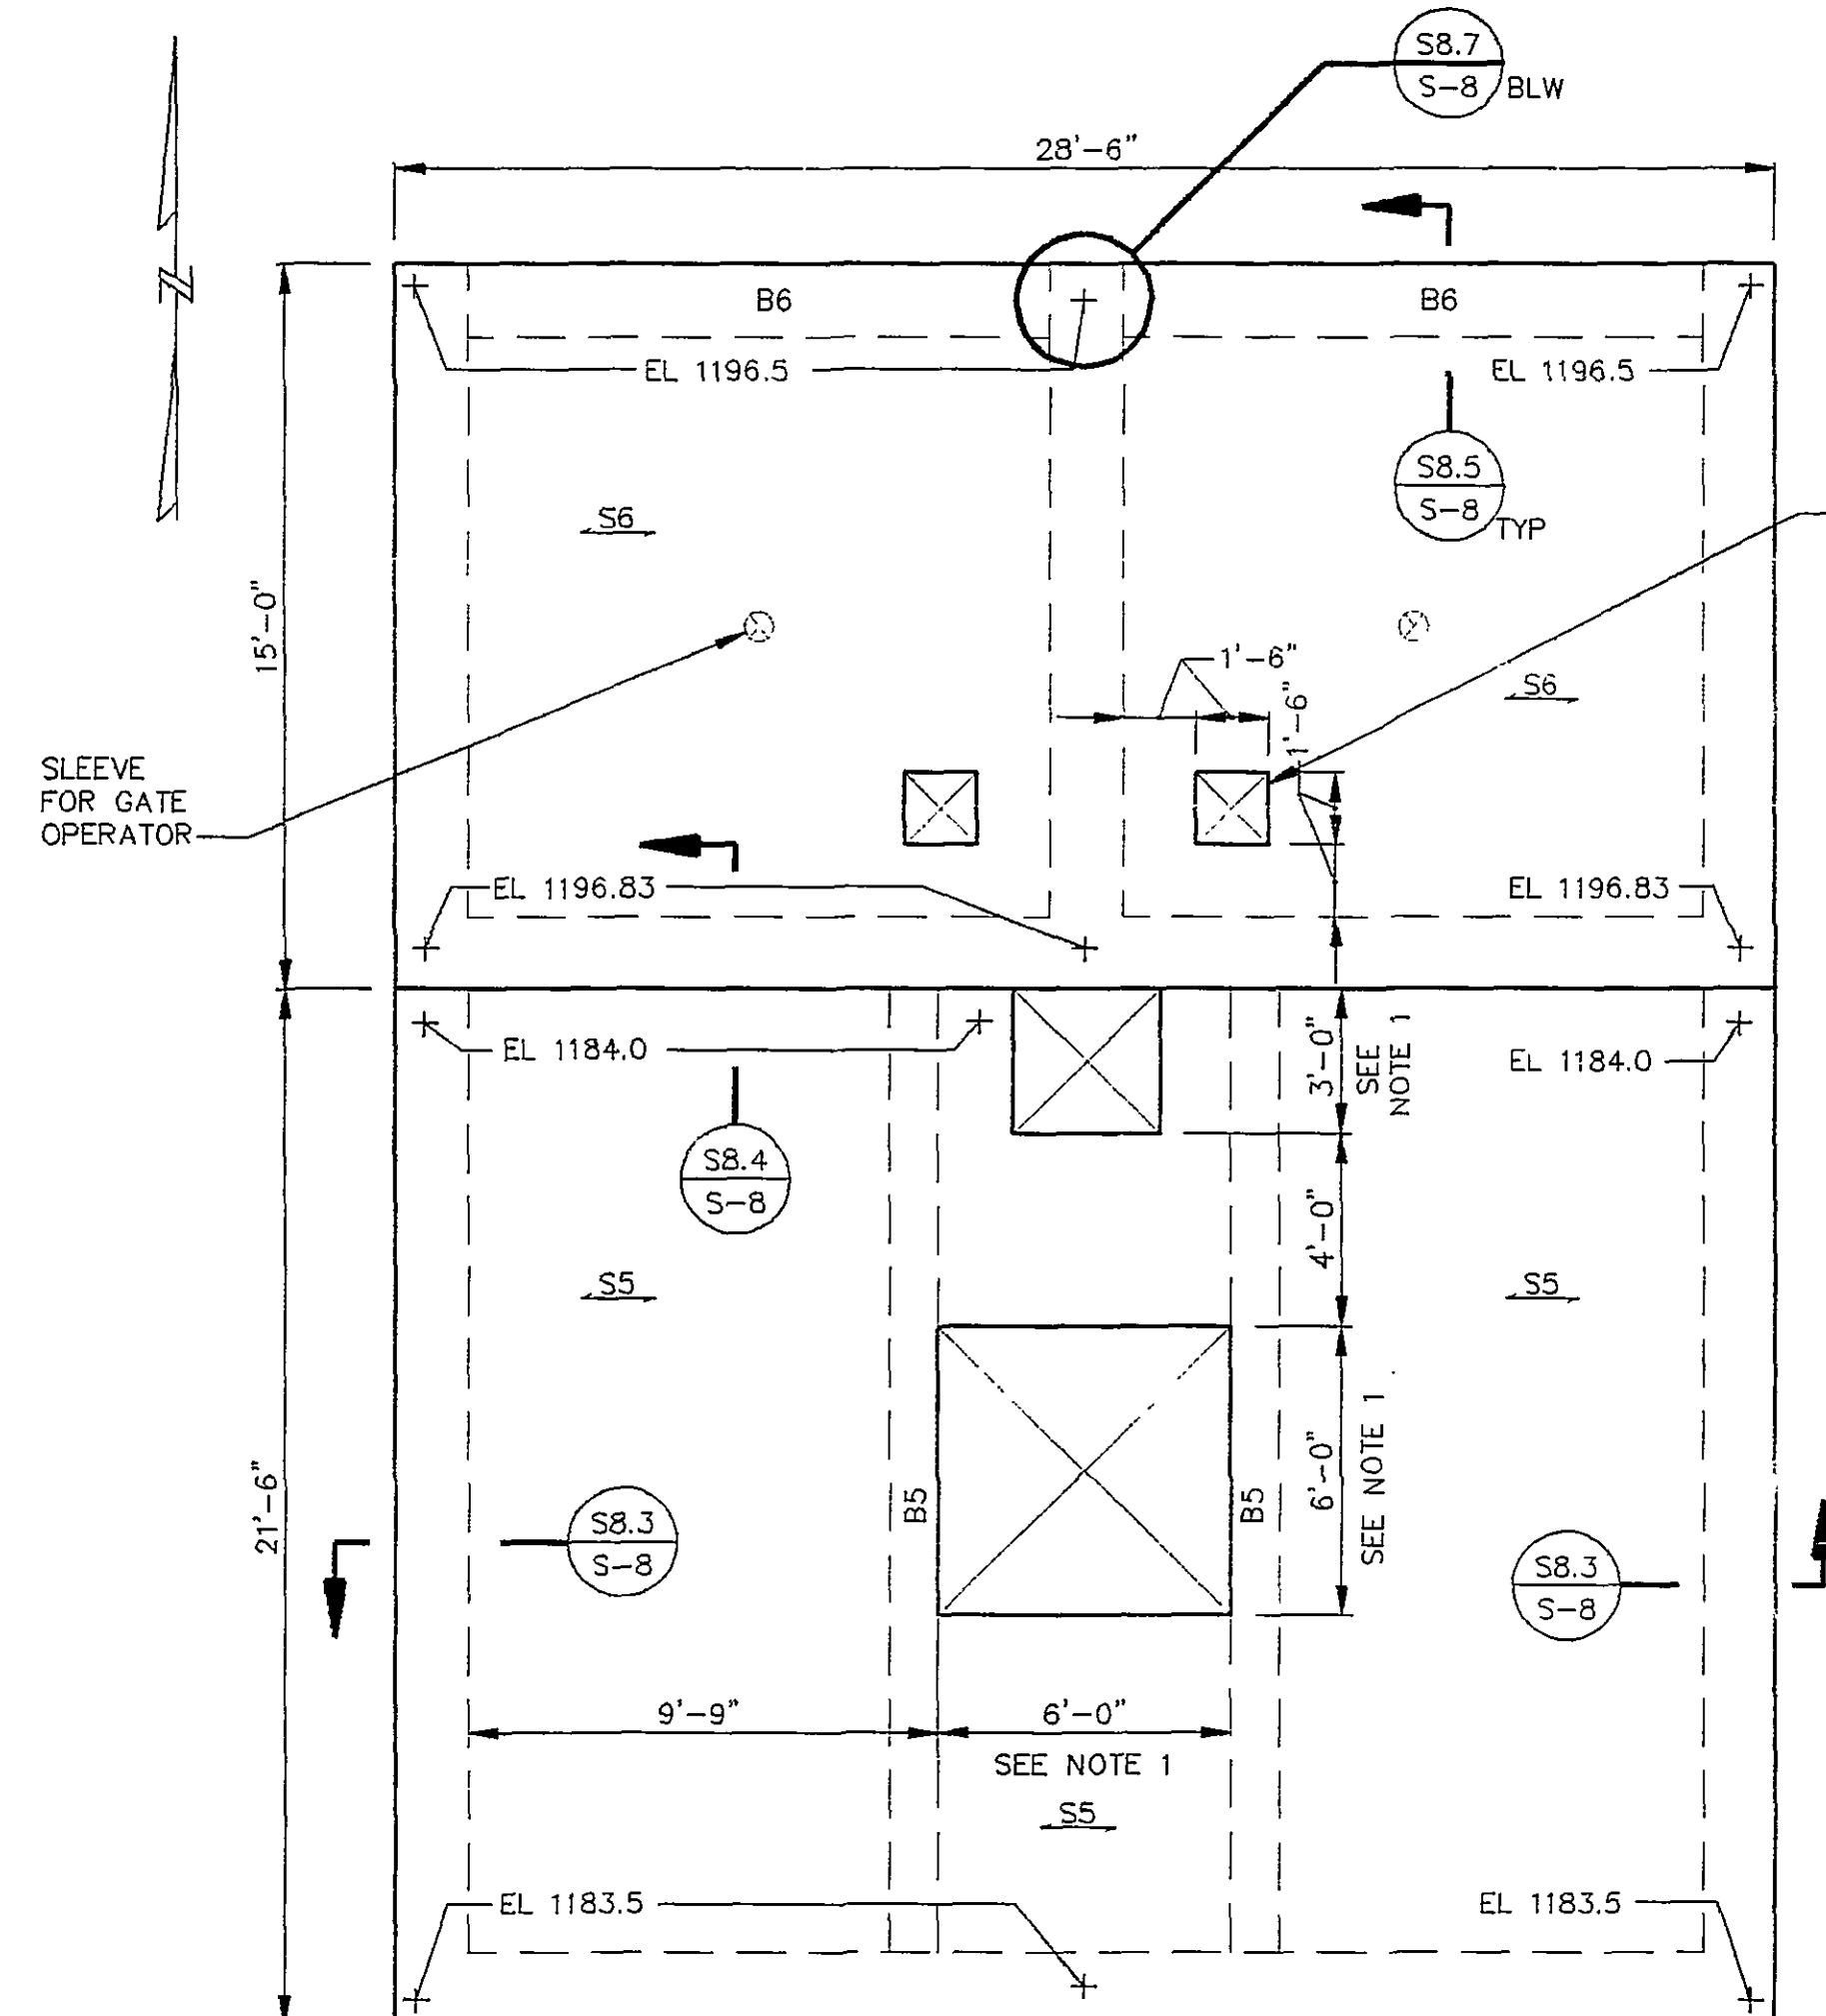


GATE HOUSE/ENERGY DISSIPATOR ROOF PLAN
SCALE: 1/4"=1'-0"

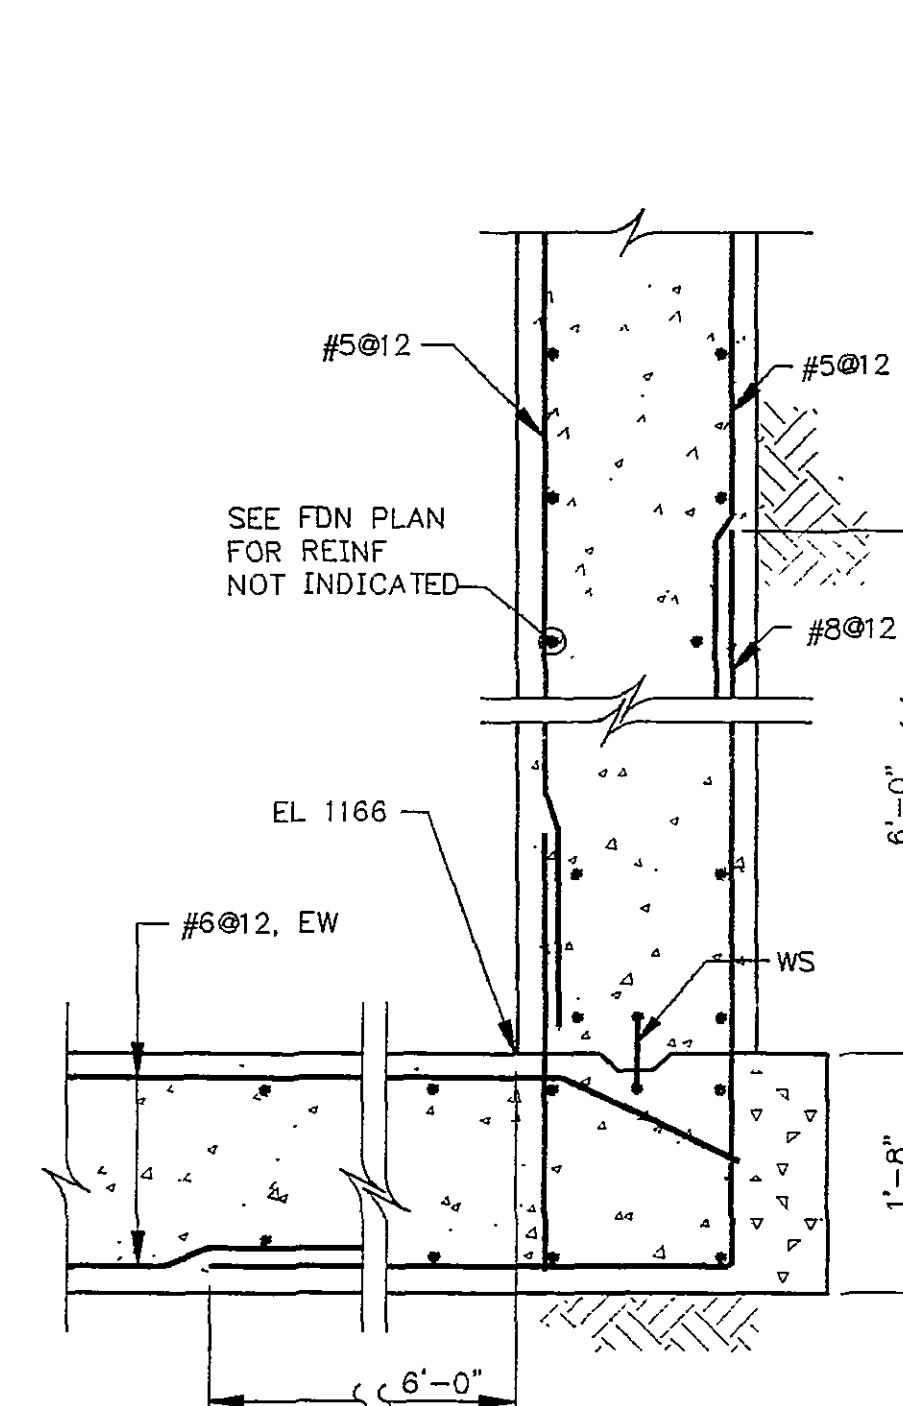


SECTION S8.1
SCALE: 3/4"=1'-0"

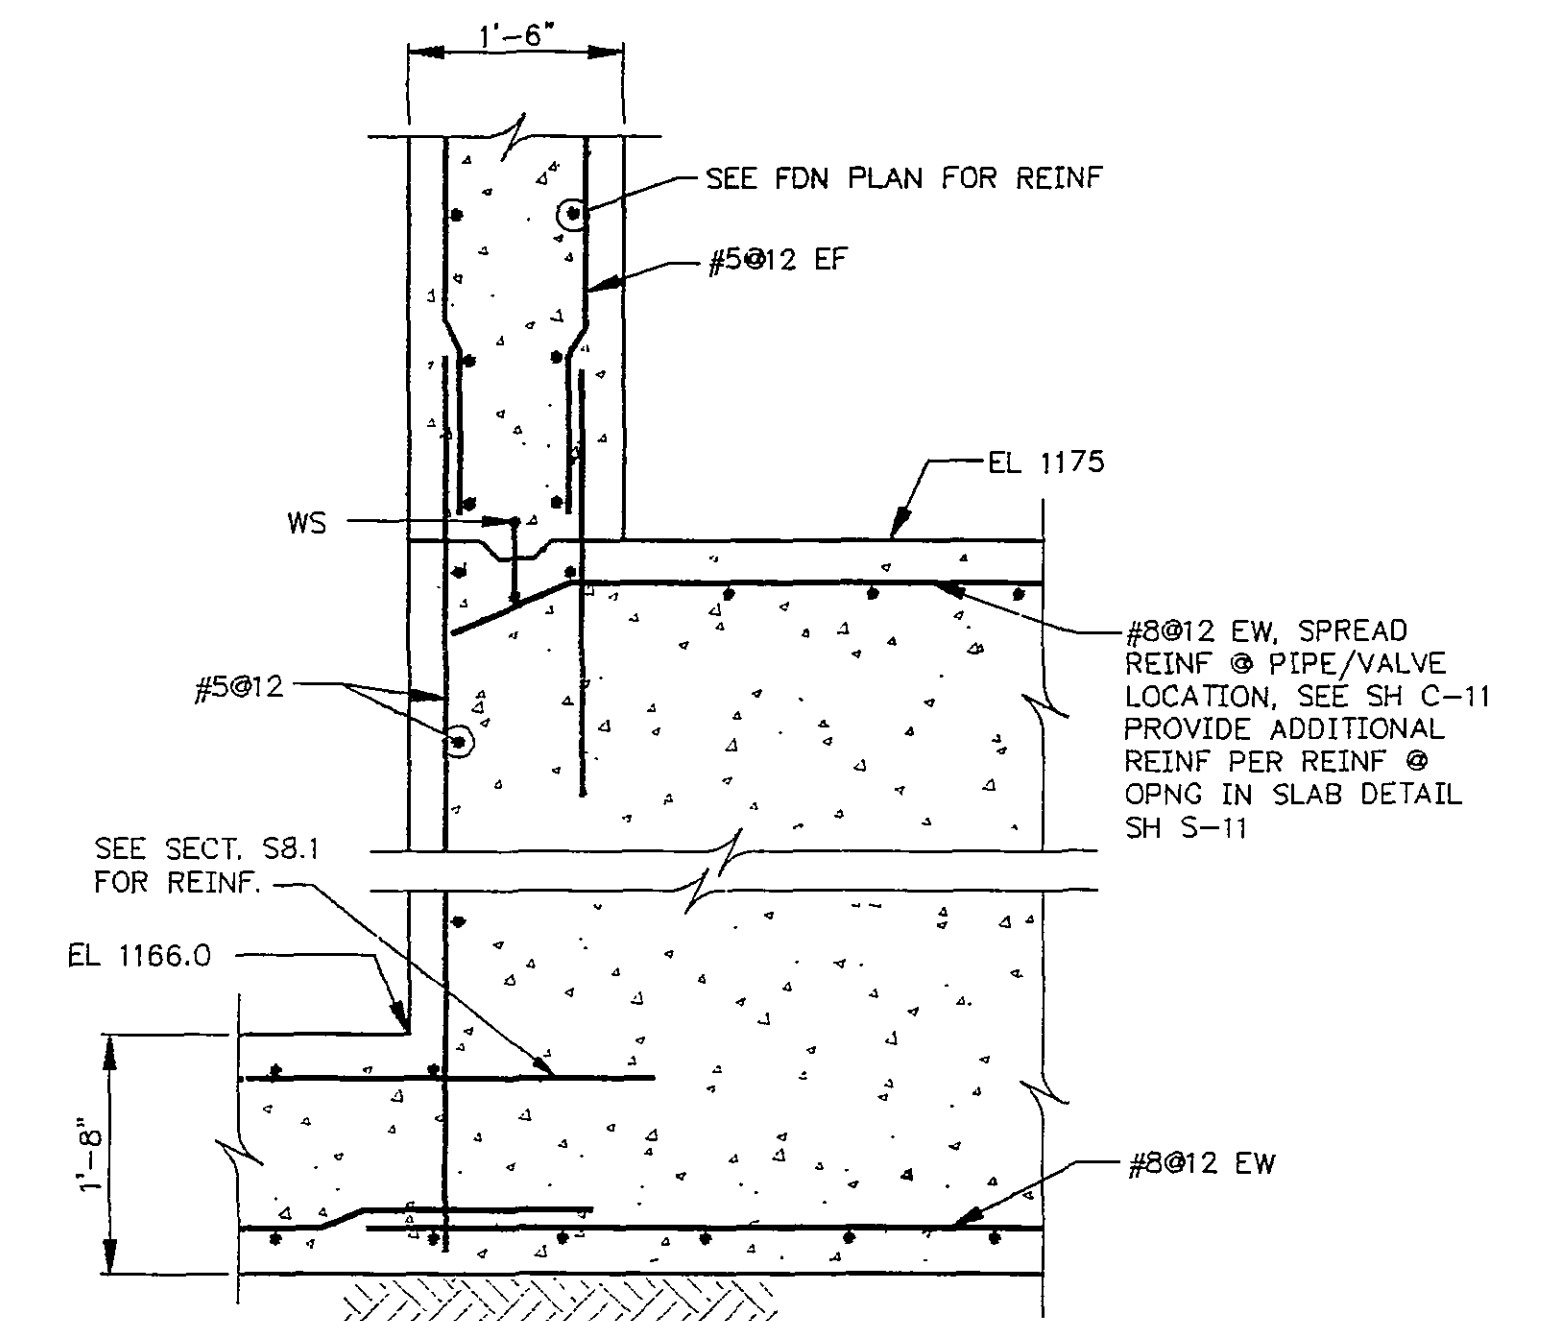


SECTION S8.2
SCALE: 3/4"=1'-0"

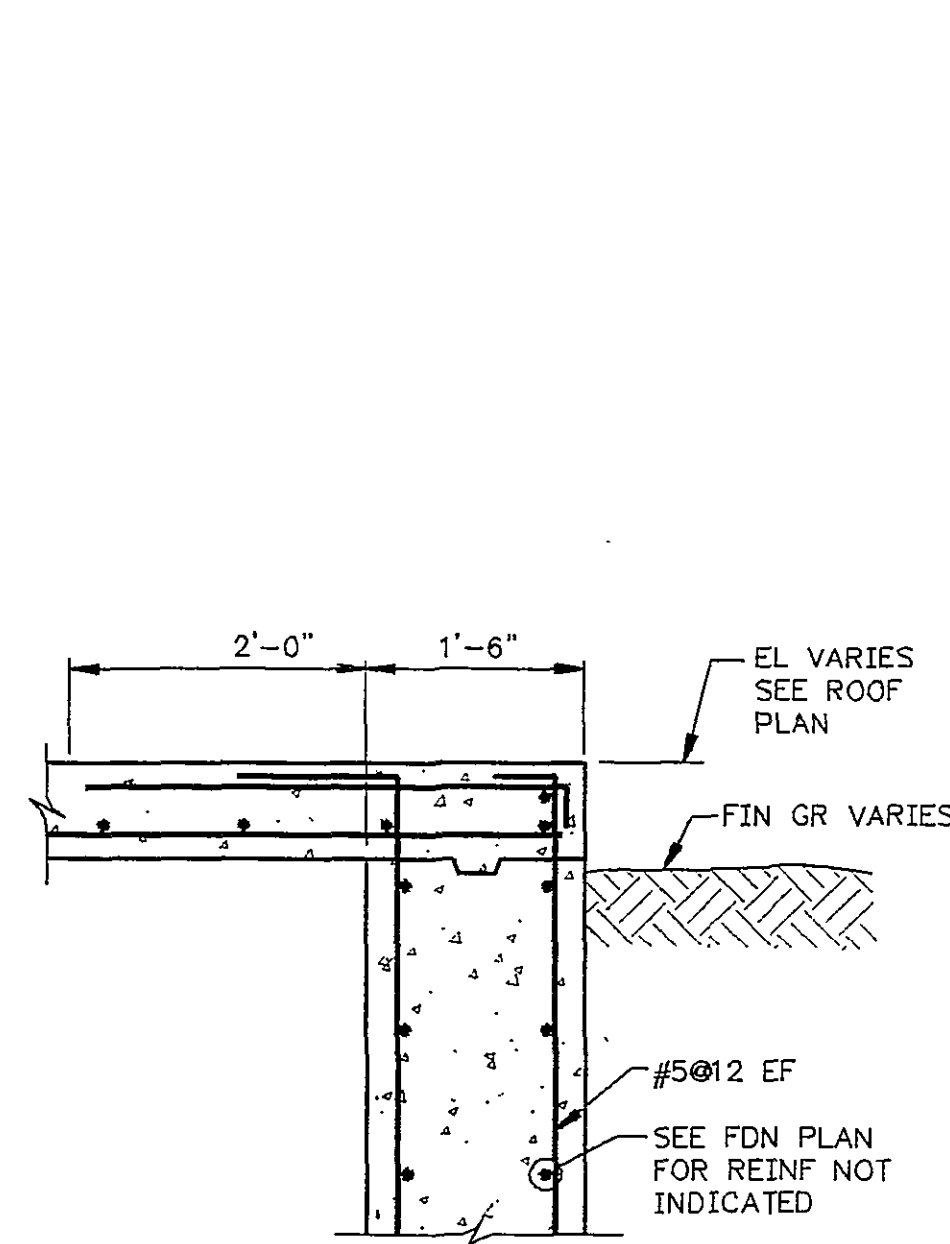


SECTION S8.3
SCALE: 3/4"=1'-0"

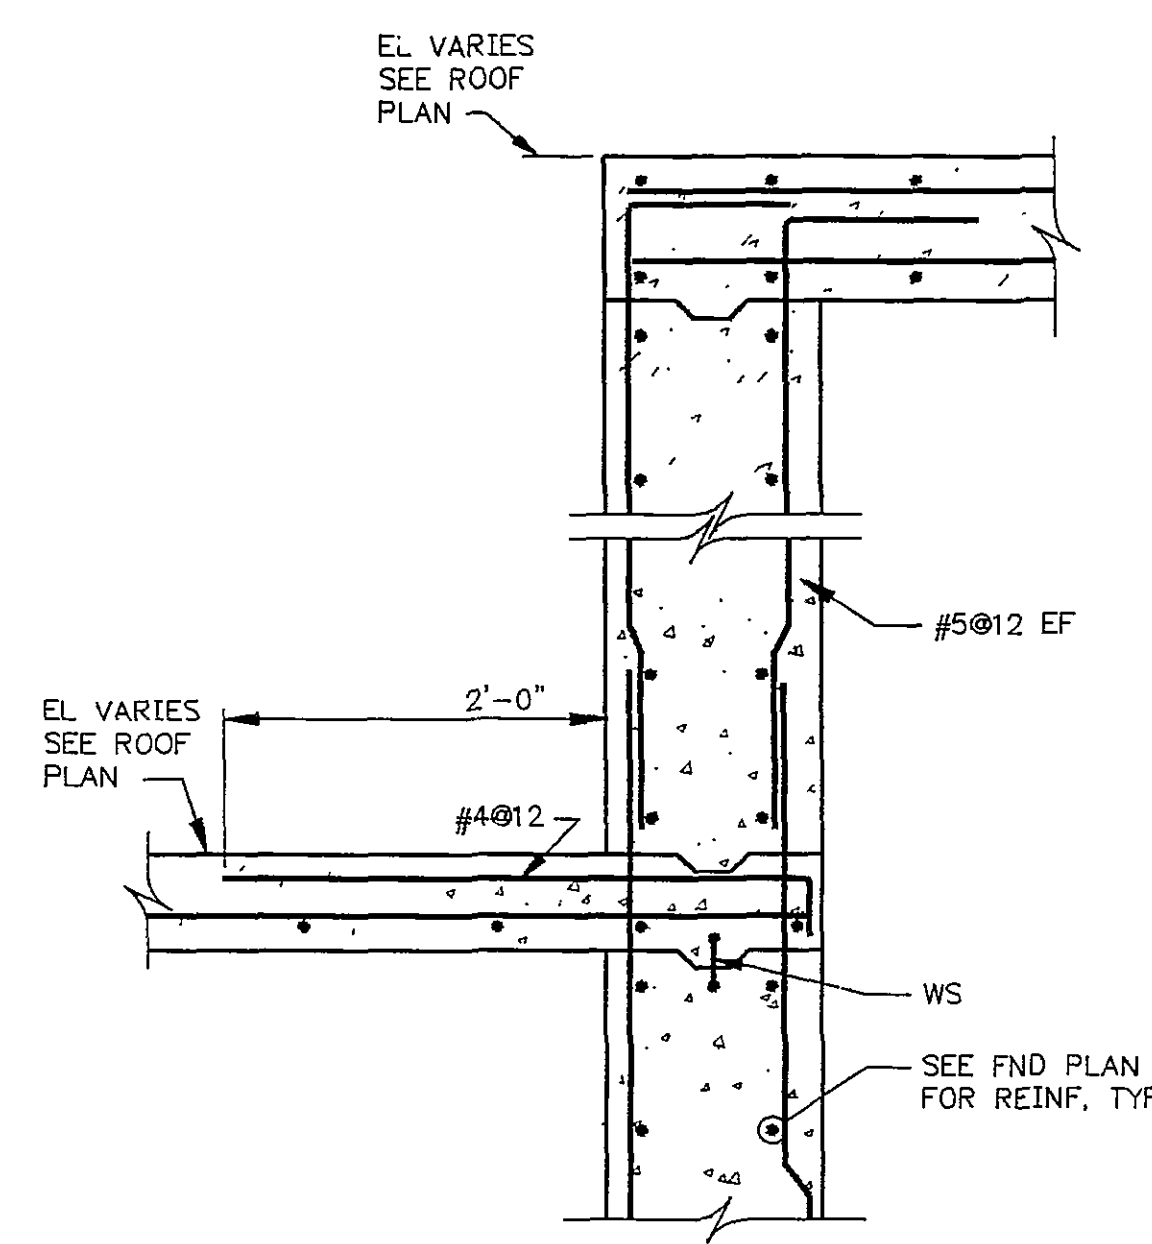


SECTION S8.4
SCALE: 3/4"=1'-0"

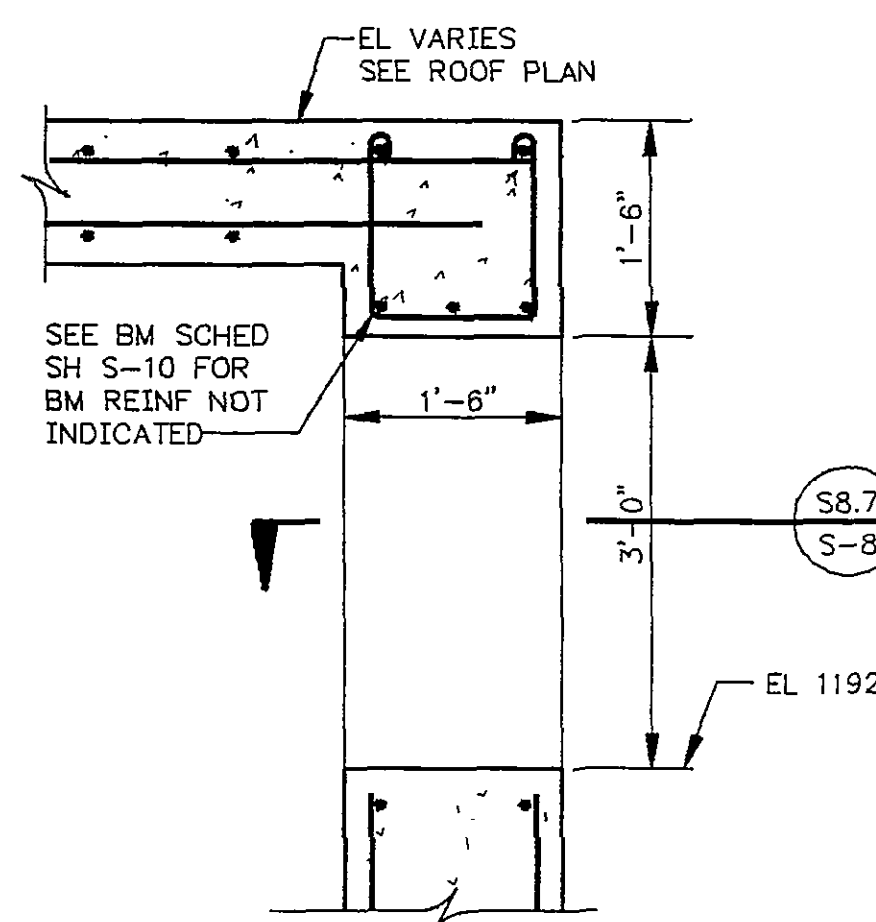

SECTION S8.5
SCALE: 3/4"=1'-0"

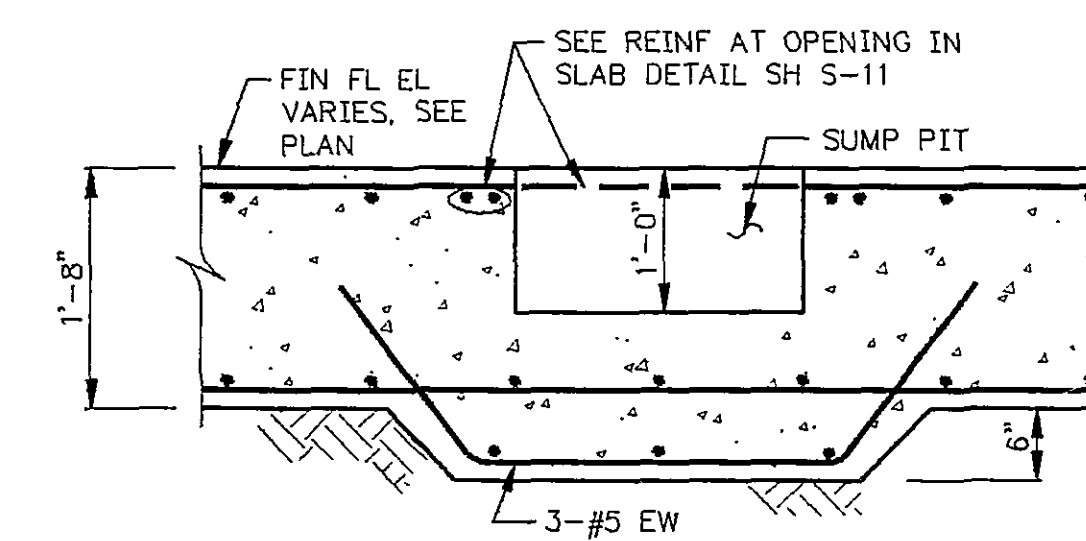


SECTION S8.6
SCALE: 3/4"=1'-0"

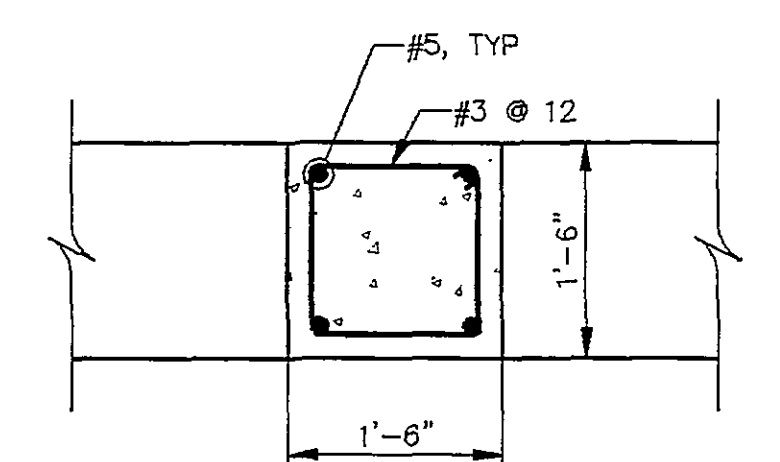


DETAIL S8.7
SCALE: 3/4"=1'-0"

RECORD DRAWINGS
THESE DRAWINGS RECORDED ON THE BASIS OF
INFORMATION FURNISHED BY THE CONTRACTOR
OR SPECIFICALLY KNOWN TO HSM. NO OTHER
REPRESENTATIONS ARE MADE OR IMPLIED
Date: 6-5-95

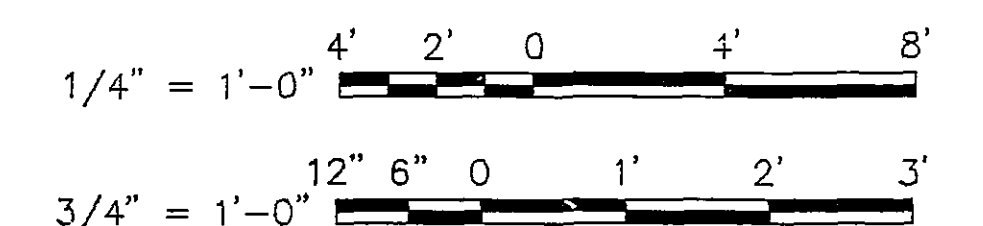


GRAPHIC SCALES

DESIGNED: AA, RWF DATE: 4 AUG 91
DRAWN: DA DATE: 4 AUG 91
CHECKED: HWP DATE: 4 AUG 91
APPROVED: AP DATE: 4 AUG 91
ISSUED: AP DATE: 6/21/91

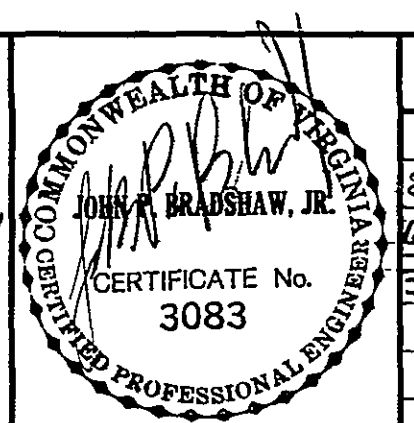

REVISIONS							
DATE	BY	DESCRIPTION	DATE	BY	DESCRIPTION	DATE	BY
8-15-94	BA	PER CONTR RECORD DWG					
6-5-95	JBH	ISSUED TO VA, DAM SAFETY					
6-31-97	RWF	RECORD DRAWING					

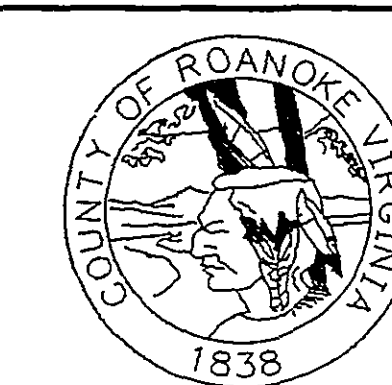

**SPRING HOLLOW RESERVOIR
ROANOKE COUNTY, VIRGINIA**

HAYES, SEAY, MATTERN & MATTERN, INC.
ARCHITECTS - ENGINEERS - PLANNERS
ROANOKE, VIRGINIA

**STRUCTURAL
GATE HOUSE/ENERGY DISSIPATOR
PLANS, SECTIONS AND DETAILS**

SCALE	DATE	COMM	SHEET	DWG
AS NOTED	8/4/91	4194E	S-8	39