



C4721A APR1692 REV. A ACAD JDB PLOT SCALE: 1"=100'

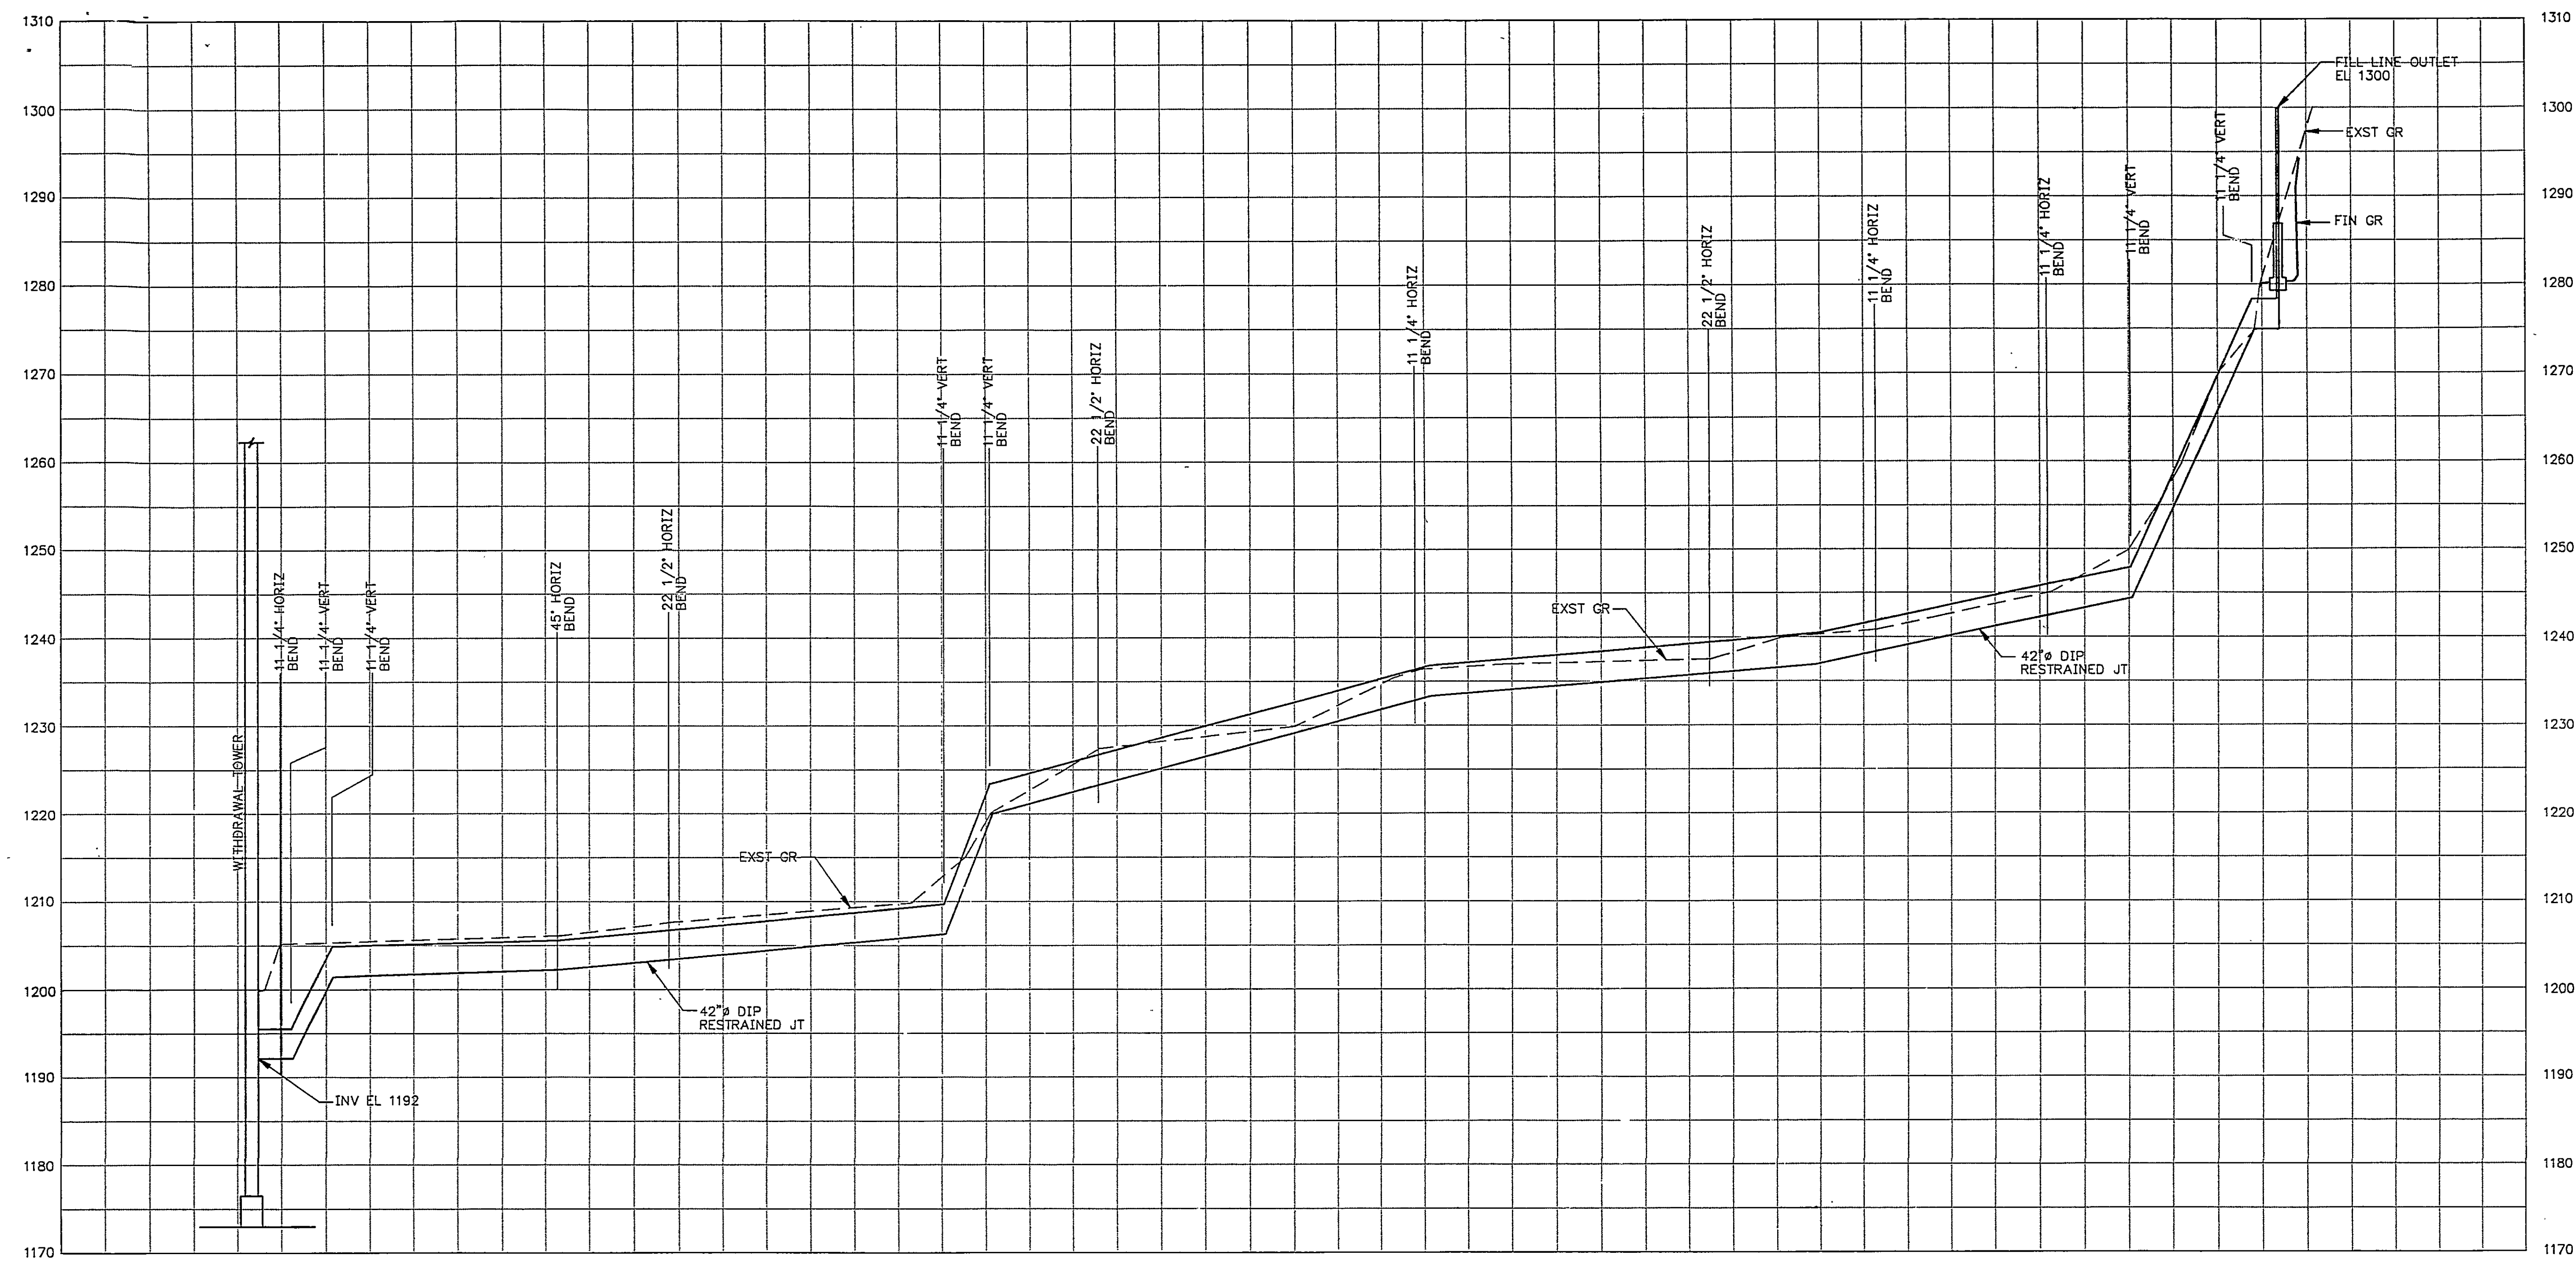


RESERVOIR FILL LINE
SCALE: 1"=100' HORIZ
1"=10' VERT

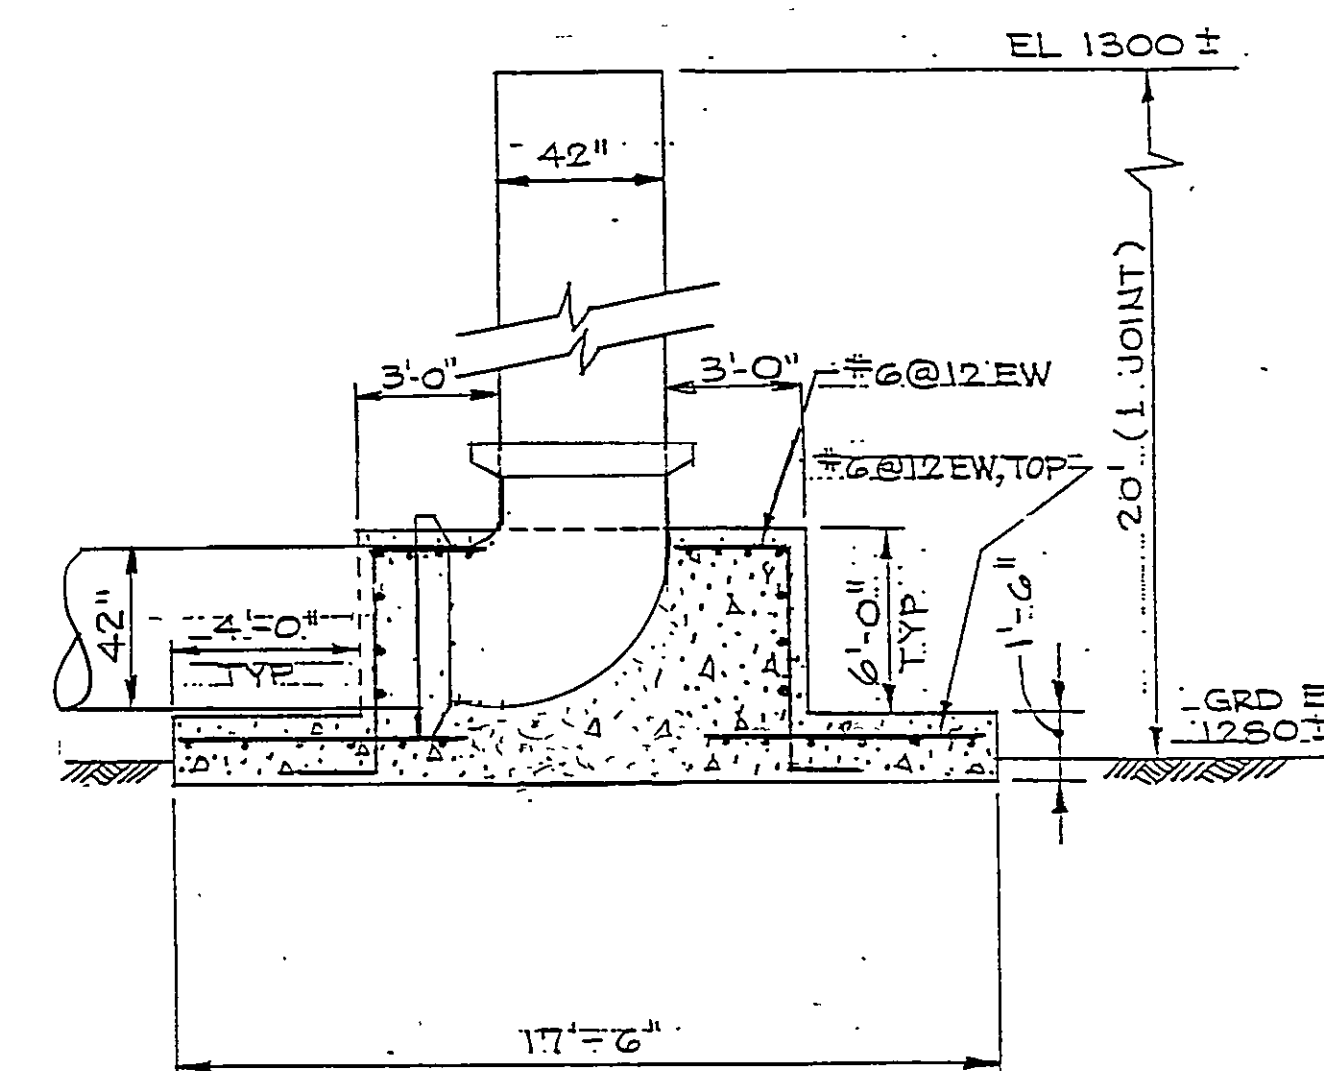

NOTE
ALL PIPE C153 DI RESTRAINED JOINT

FILL LINE OUTLET
NO SCALE

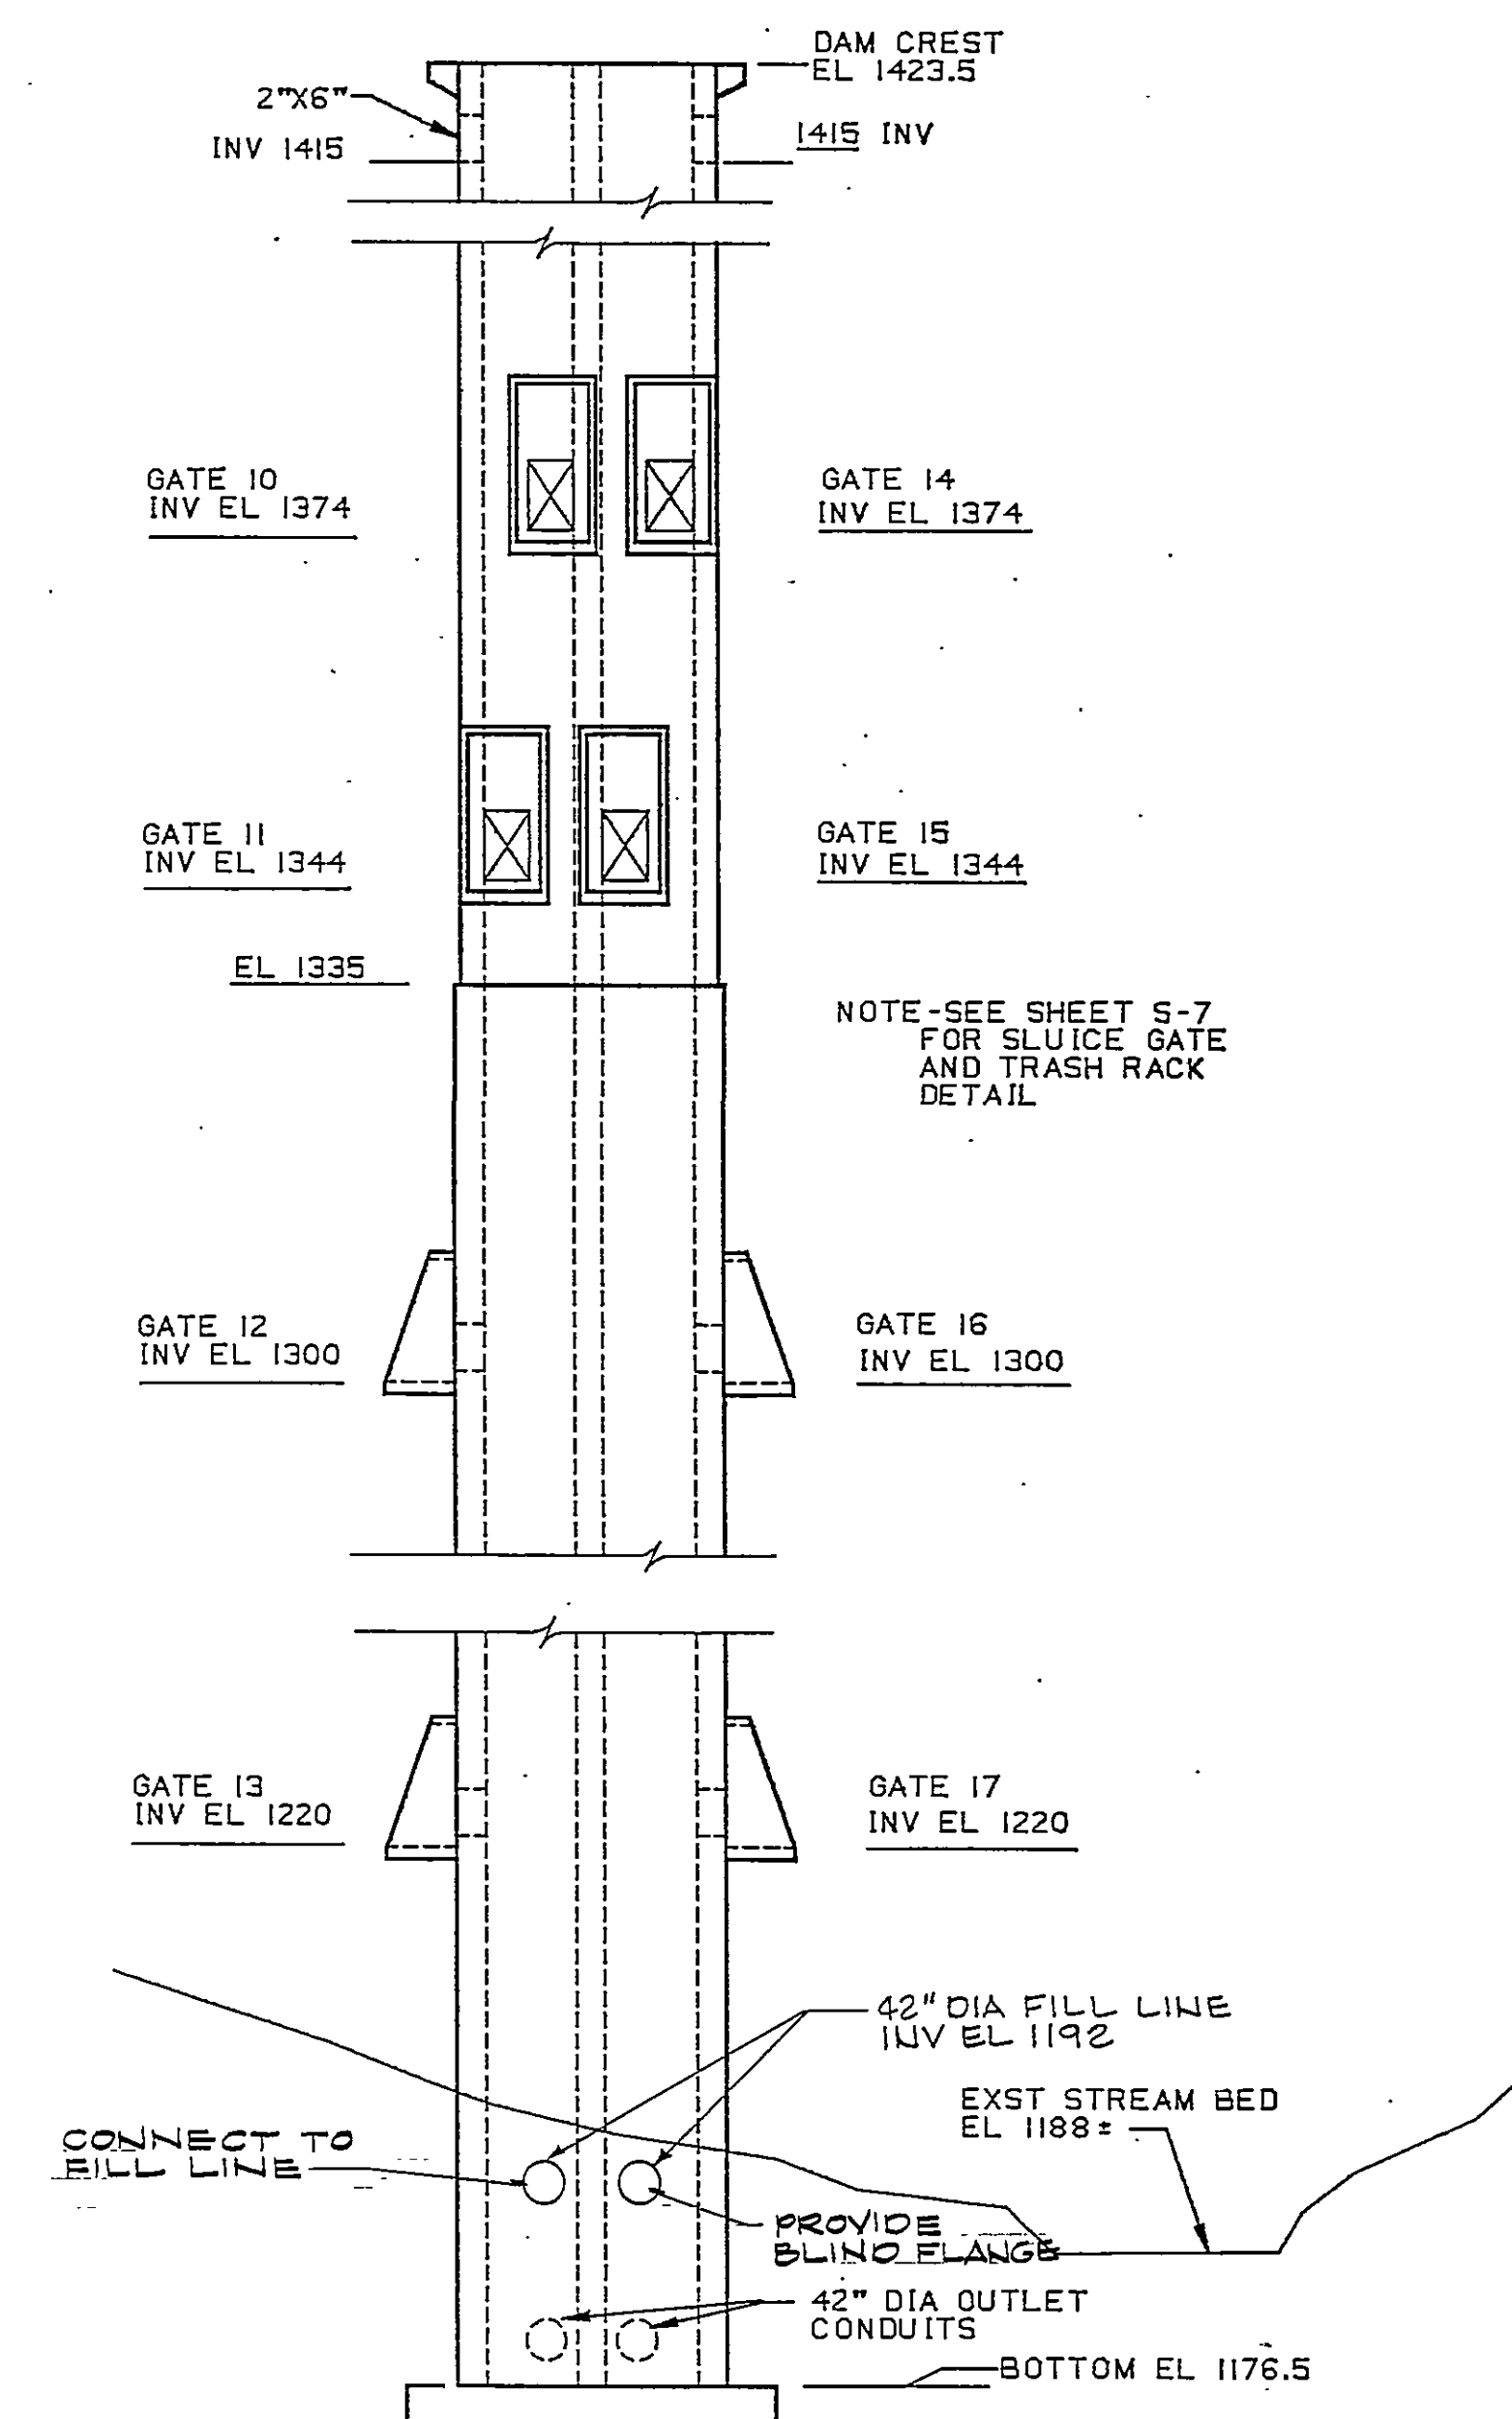


WITHDRAWAL TOWER SOUTH ELEVATION
SCALE: 1/16" = 1'-0"

RECORD DRAWINGS
THESE DRAWINGS RECORDED ON THE BASIS OF
INFORMATION FURNISHED BY THE CONTRACTOR
OR SPECIFICALLY KNOWN TO HSM. NO OTHER
REPRESENTATIONS ARE MADE OR IMPLIED
Date: 6-5-95

DESIGNED	DATE
DRAWN	DATE
CHECKED	DATE
APPROVED	DATE
ISSUED	DATE

REVISIONS					
DATE	BY	DESCRIPTION	DATE	BY	DESCRIPTION
3-15-94	BA	PER CONTR RECORD DWG			
6-5-95	JBH	ISSUED TO VA DAM SAFETY			
6-3-97	RWF	RECORD DRAWING			

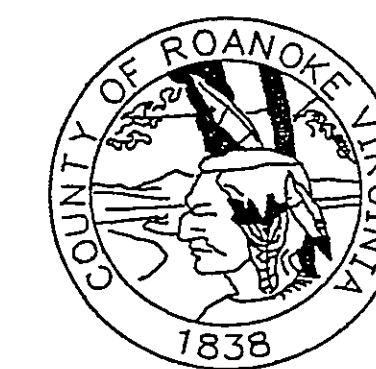

SPRING HOLLOW RESERVOIR
ROANOKE COUNTY, VIRGINIA

HAYES, SEAY, MATTERN & MATTERN, INC.
ARCHITECTS - ENGINEERS - PLANNERS
ROANOKE, VIRGINIA

CIVIL
RESERVOIR FILL LINE PROFILE
AND DETAILS

SCALE AS NOTED	DATE 20 APRIL 1992	COMM 4194 JC	SHEET 44
-------------------	-----------------------	-----------------	-------------