

DATE: 03-21-95

DRAWN: PJS

CHECKED: [Signature]

APPROVED: [Signature]

DESIGNED: JSW

TANK DESCRIPTION:

2.0-MG CLEAR WELL

TANK DIMENSIONS:

112'0" ID x 28'0" SWD

TANK BUILDER:

THE CROM CORPORATION  
GAINESVILLE, FLORIDA

OWNER:

COUNTY OF  
ROANOKE  
VIRGINIA

CONSULTING ENGINEER:

ROANOKE COUNTY  
UTILITY DEPARTMENT

| REV. | DESCRIPTION | DATE<br>CHK. BY |
|------|-------------|-----------------|
|      |             |                 |

WHERE STANDARD SPECIFICATIONS ARE IN CONFLICT WITH CROM CORPORATION SPECIFICATIONS OR WITH GOOD PRE-STRESSING OR SHOTCRETE PRACTICES THE STANDARD SPECIFICATIONS SHALL BE SUBORDINATED.  
THIS DESIGN AND DRAWING ORIGINATED BY AND THE EXCLUSIVE PROPERTY OF THE CROM CORPORATION.


BAR IS ONE INCH ON ORIGINAL  
DRAWINGS 0 1"

SCALE:

AS NOTED


FILE NO. **9449.2**

SHEET **18** OF **19**

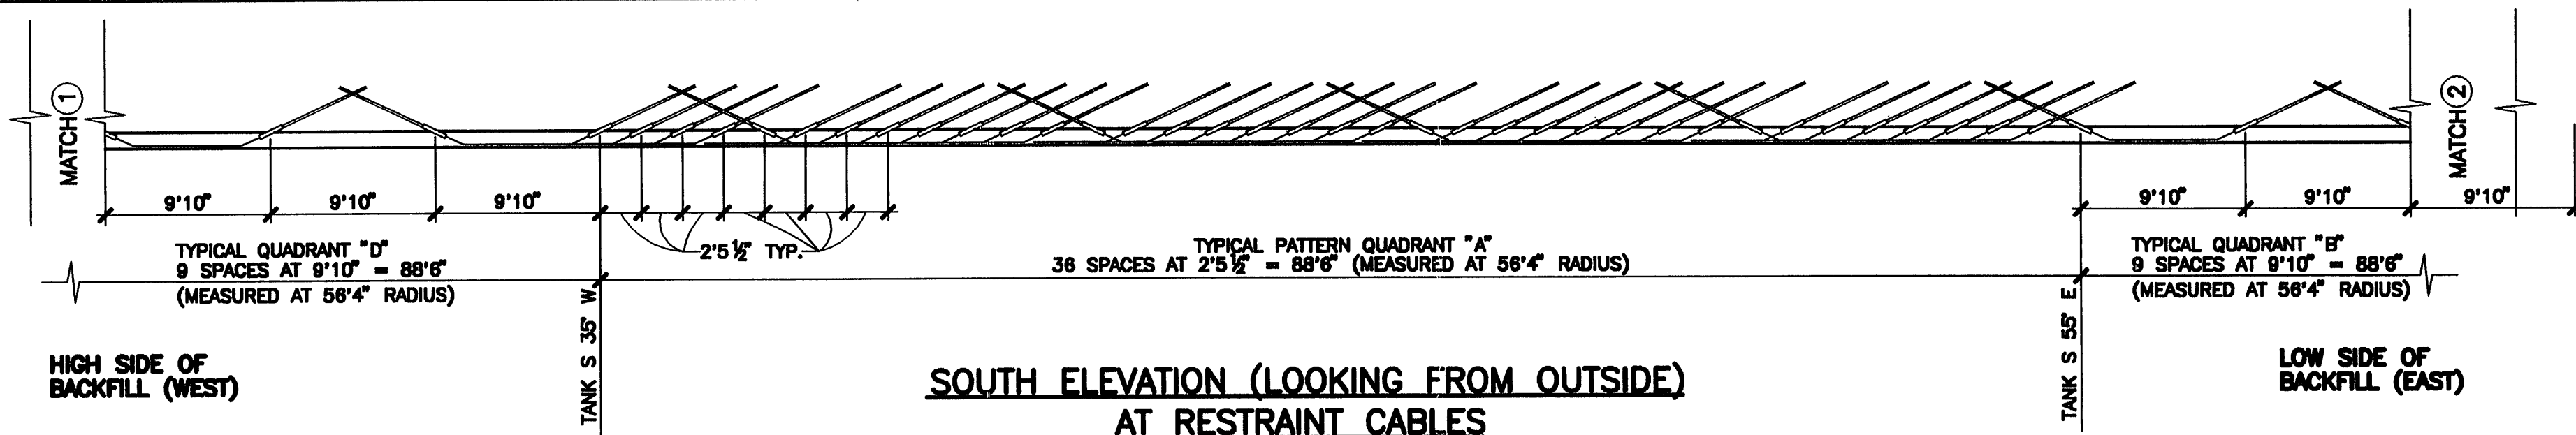

**SOUTH ELEVATION (LOOKING FROM OUTSIDE)  
AT RESTRAINT CABLES**


2' 0' 5' 10'  
SCALE 1/8"=1'0"

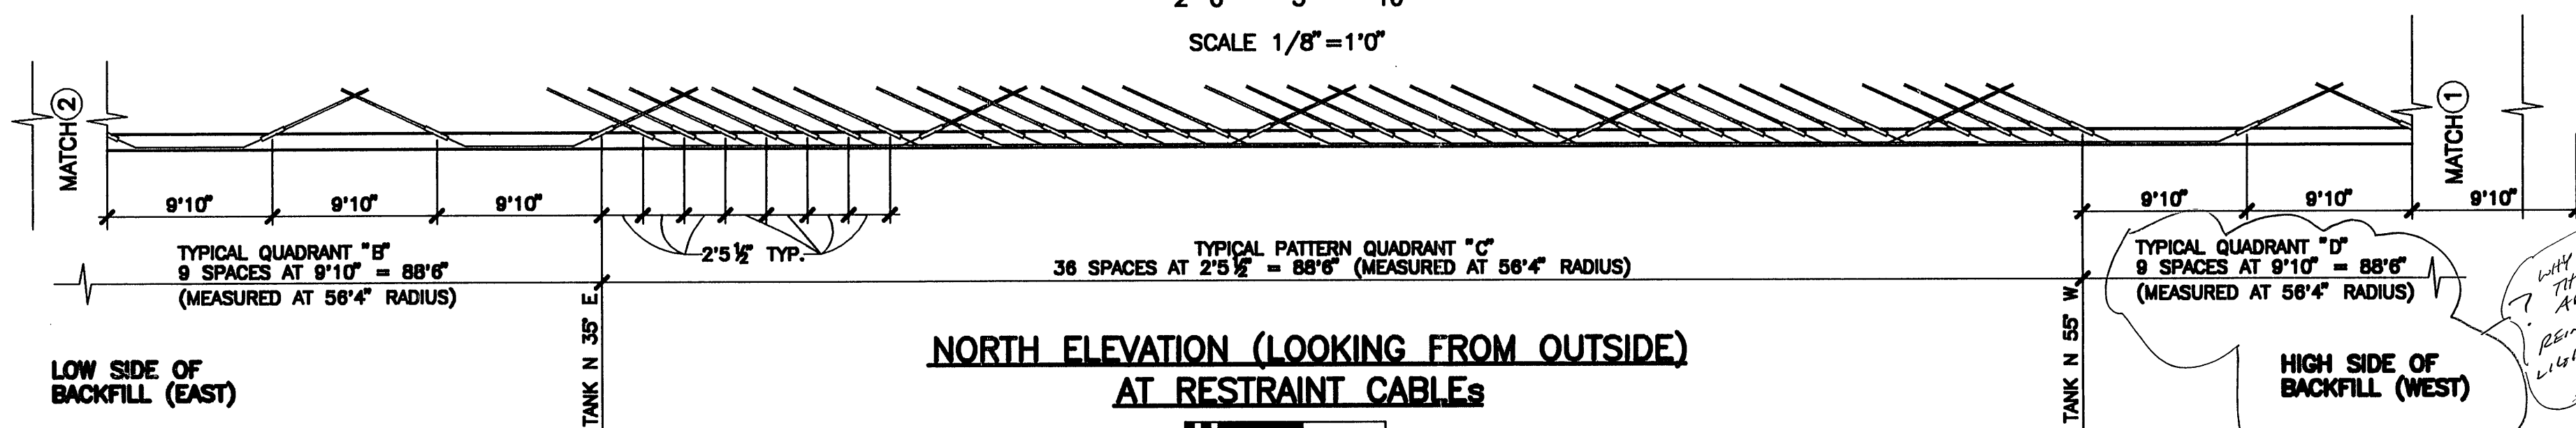

**NORTH ELEVATION (LOOKING FROM OUTSIDE)  
AT RESTRAINT CABLES**


2' 0' 5' 10'  
SCALE 1/8"=1'0"

NOTE: SPREAD CABLES 1 1/2" c/c  
ALONG FULL LENGTH ON WALL

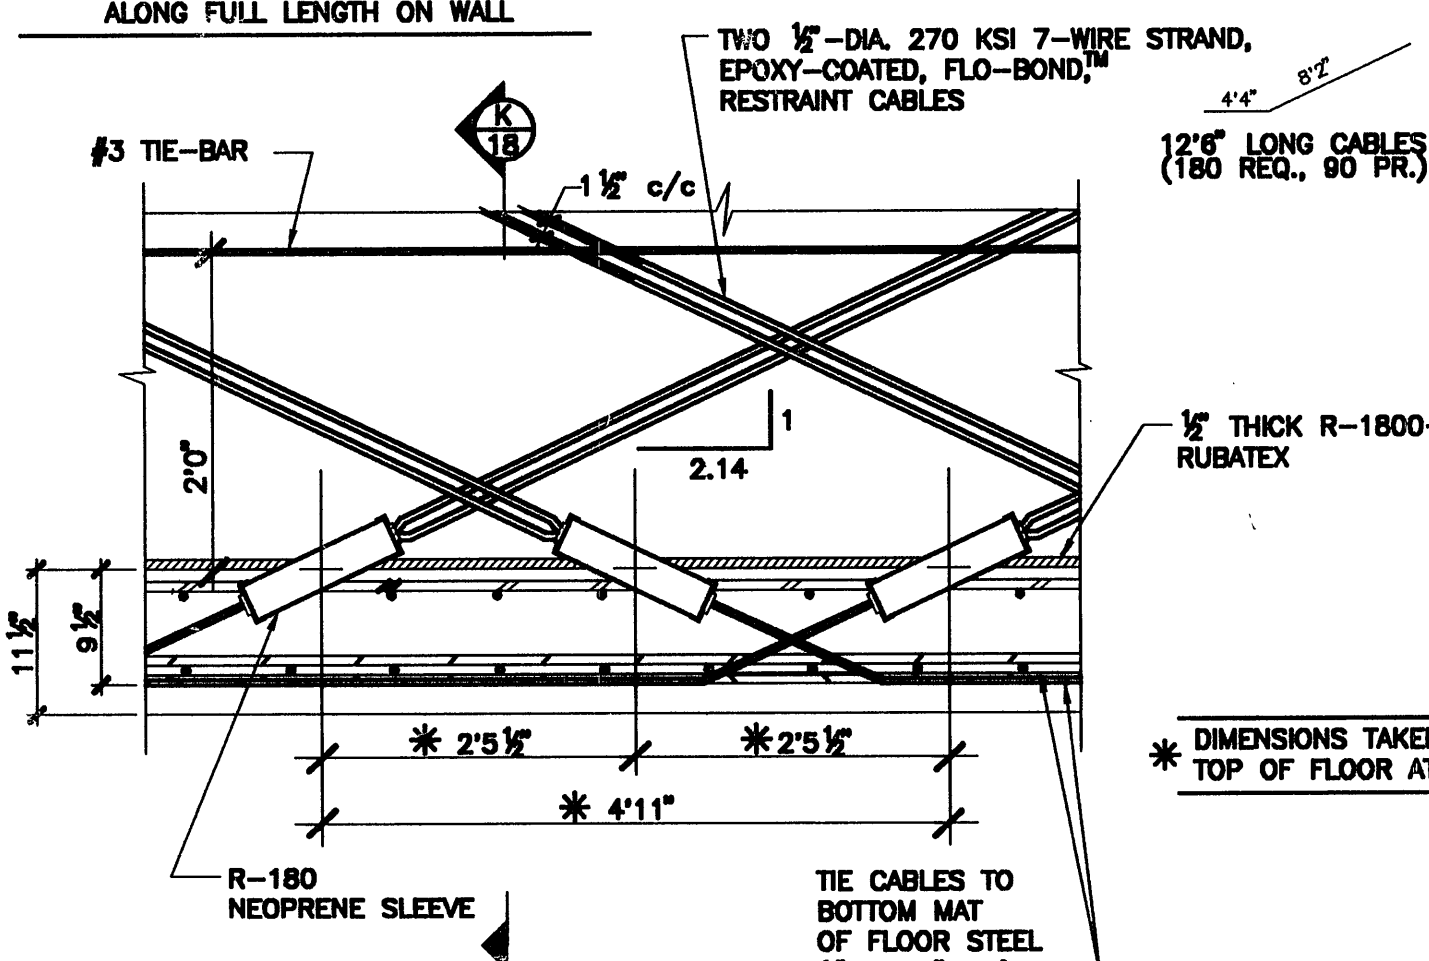


**DETAIL AT RESTRAINT CABLES**

NTS

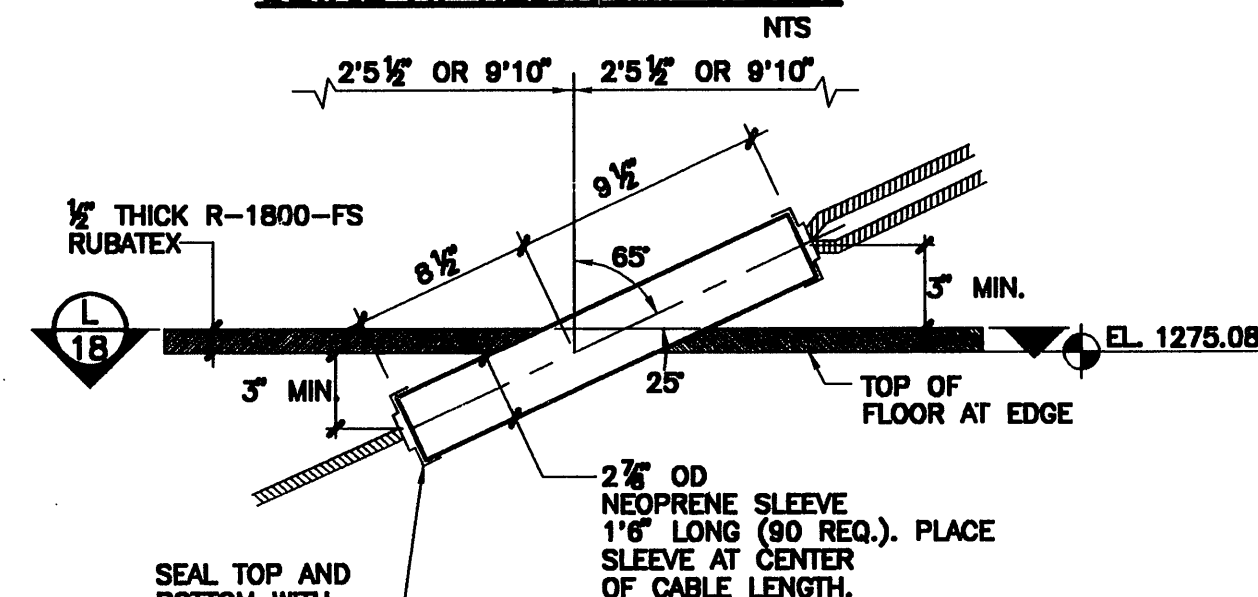


**R-180 NEOPRENE SLEEVE DETAIL**

NTS

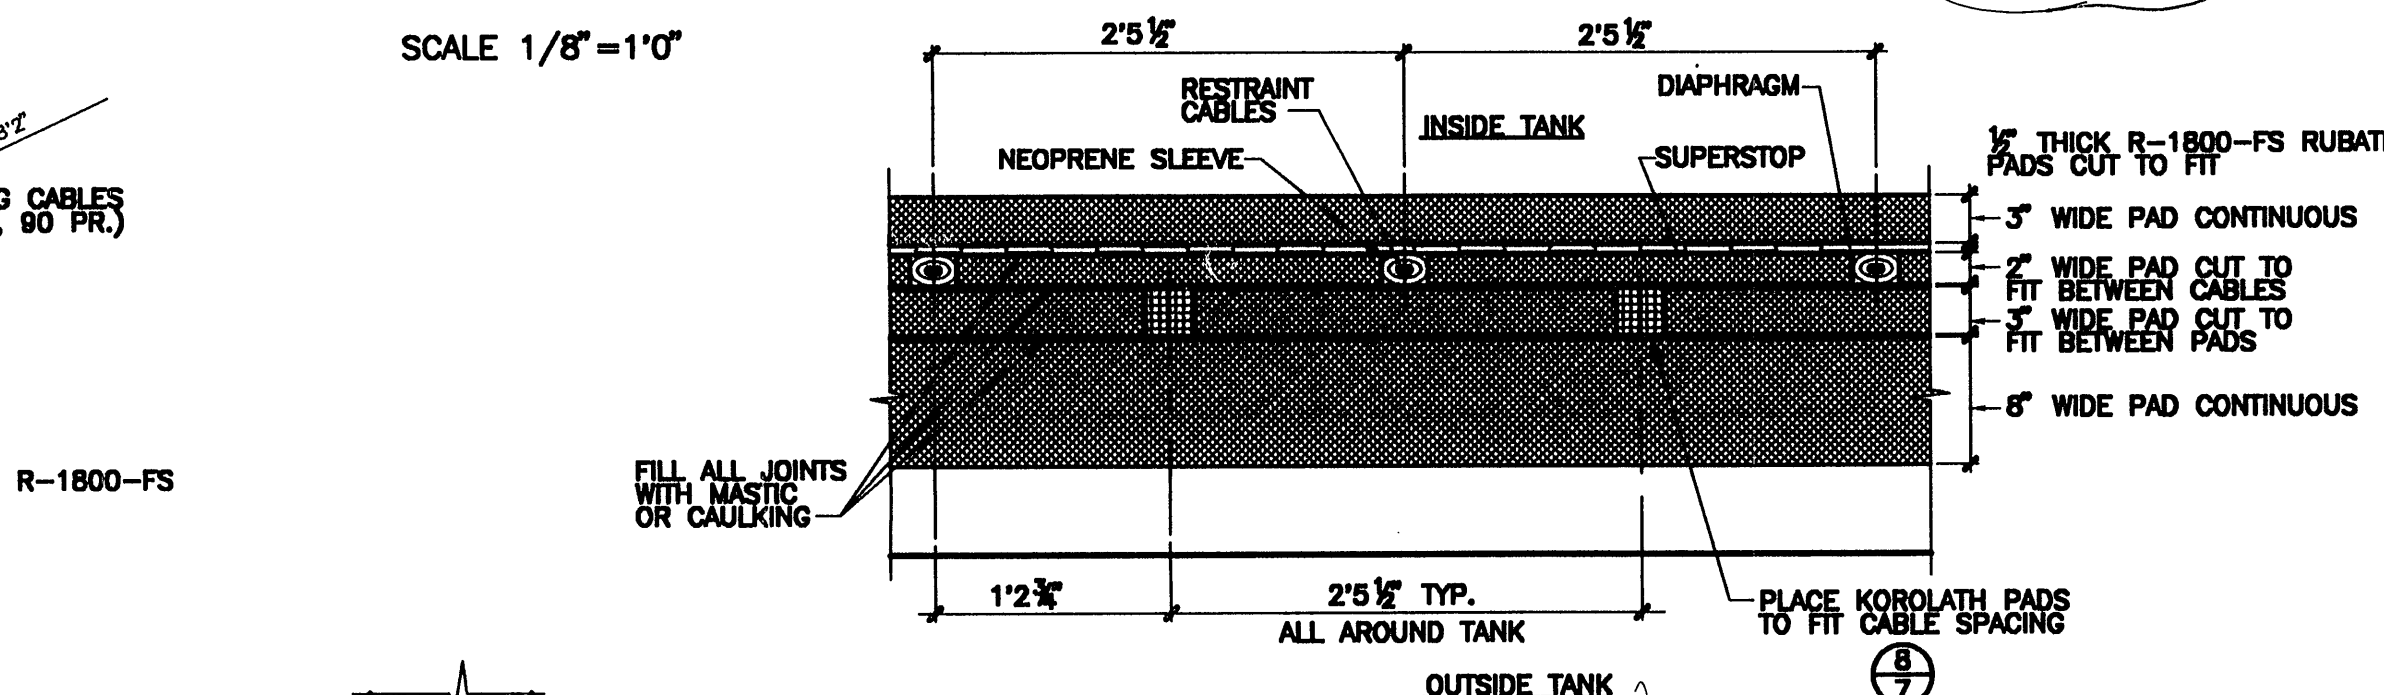


**SECTION L**

1' 0 1'  
SCALE 1"=1'0"

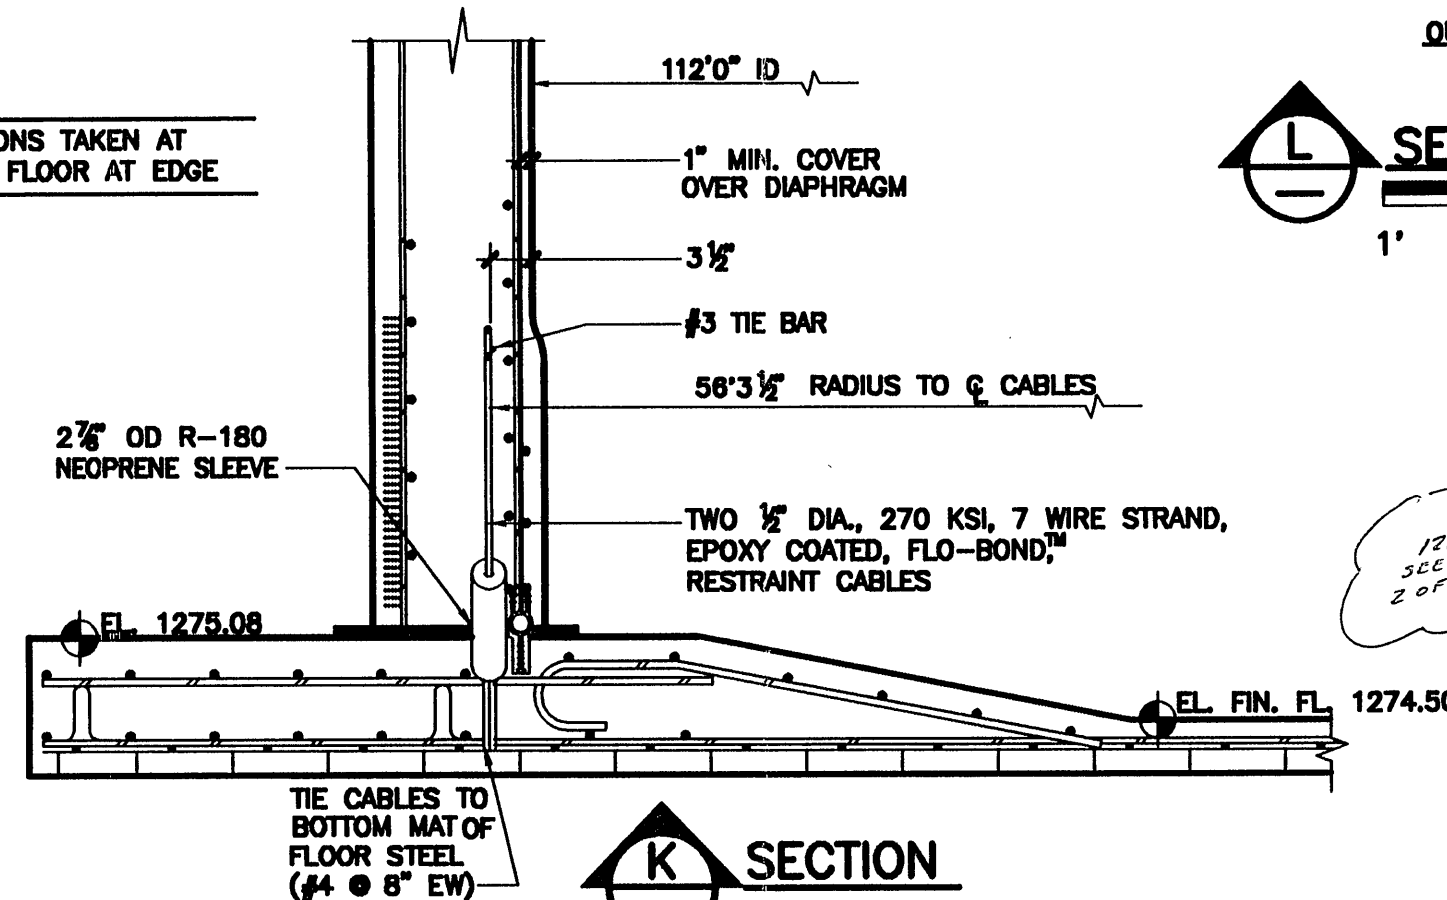

**SECTION K**

1' 0 1'  
SCALE 3/4"=1'0"

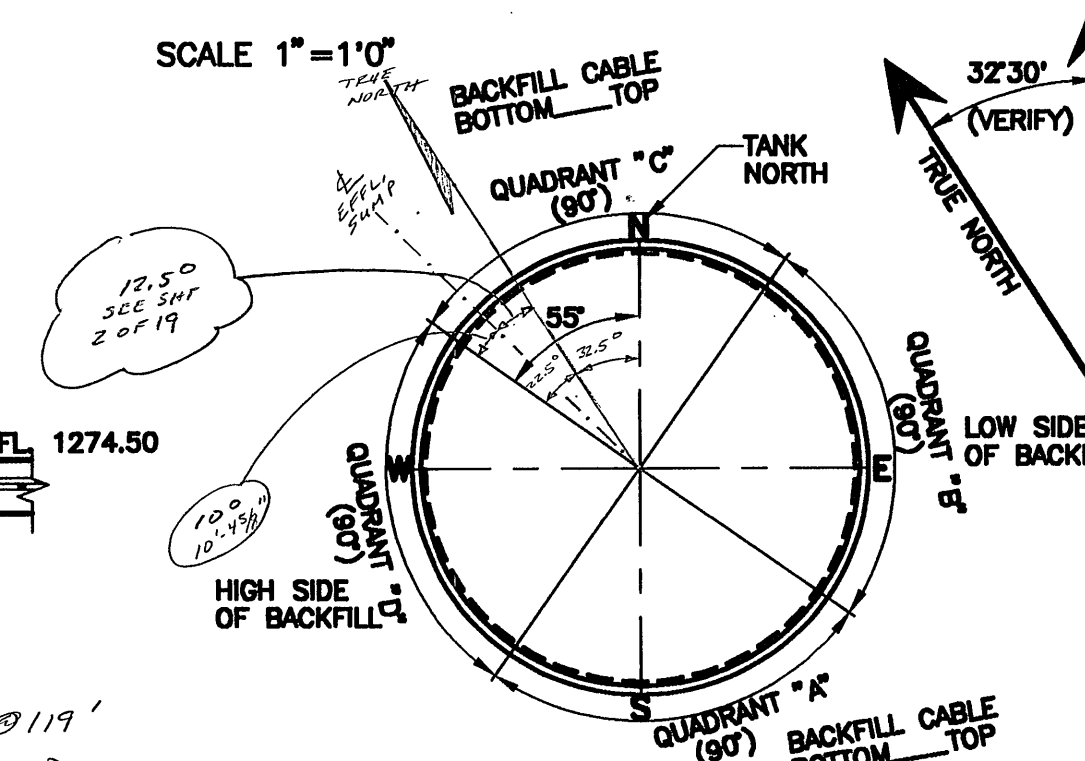

**RESTRAINT CABLE LOCATION PLAN**

NTS

COPYRIGHT © 1995 BY THE CROM CORPORATION-ALL RIGHTS RESERVED