




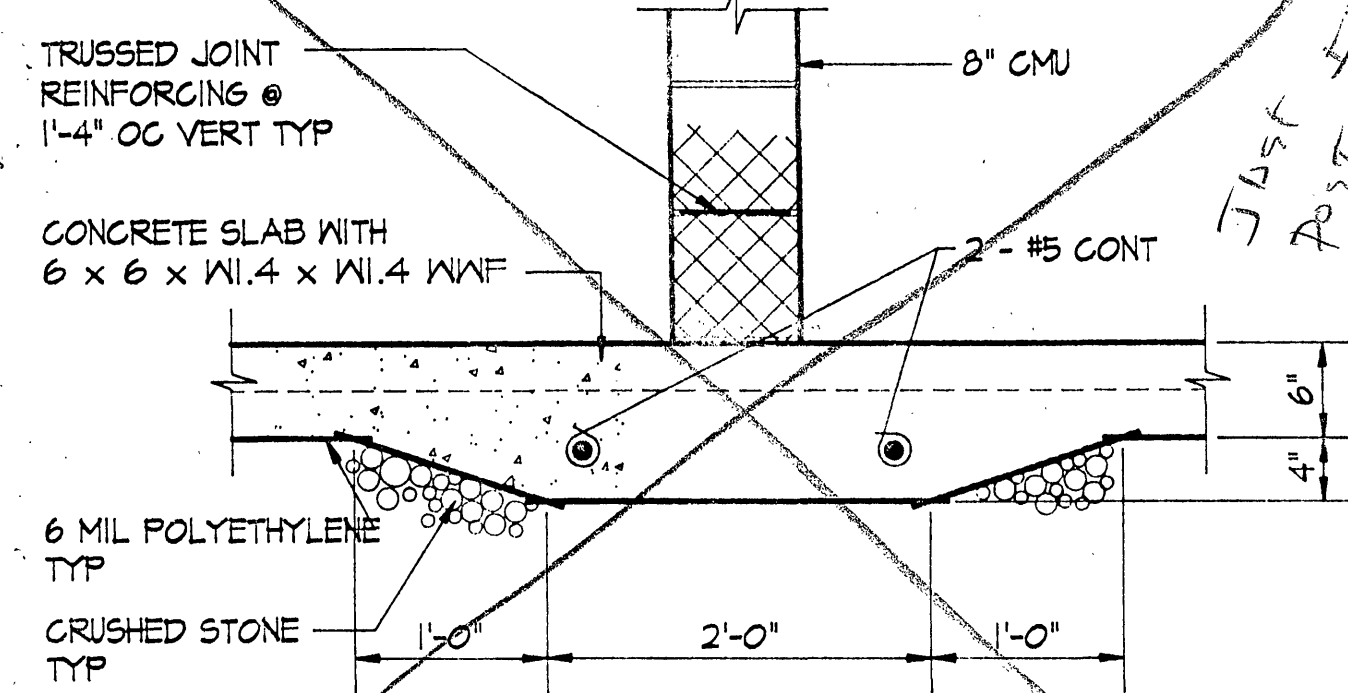


SECTION
SCALE 1" = 1'-0"

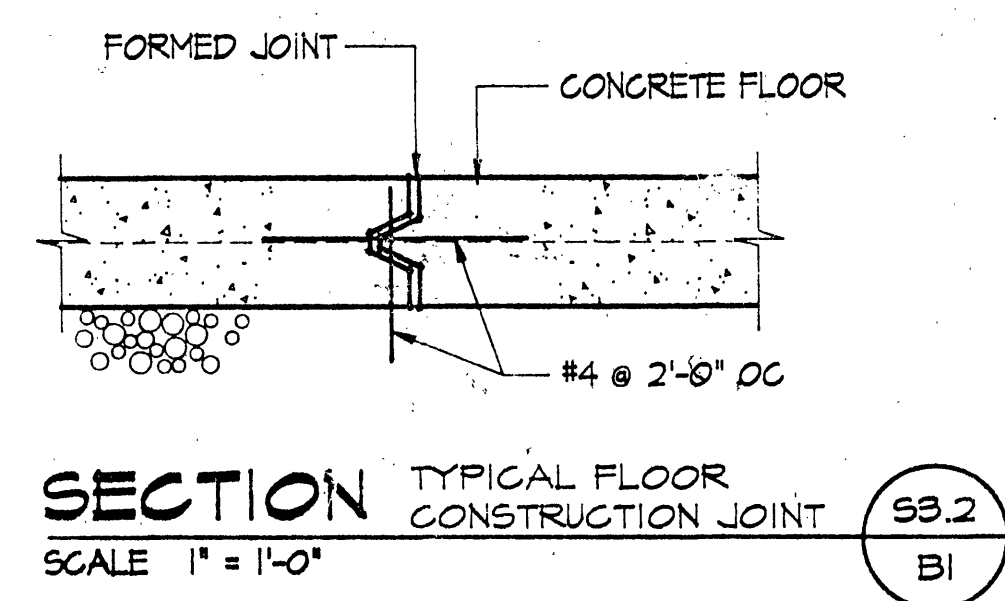


SECTION TYPICAL FLOOR CONSTRUCTION JOINT
SCALE 1" = 1'-0"

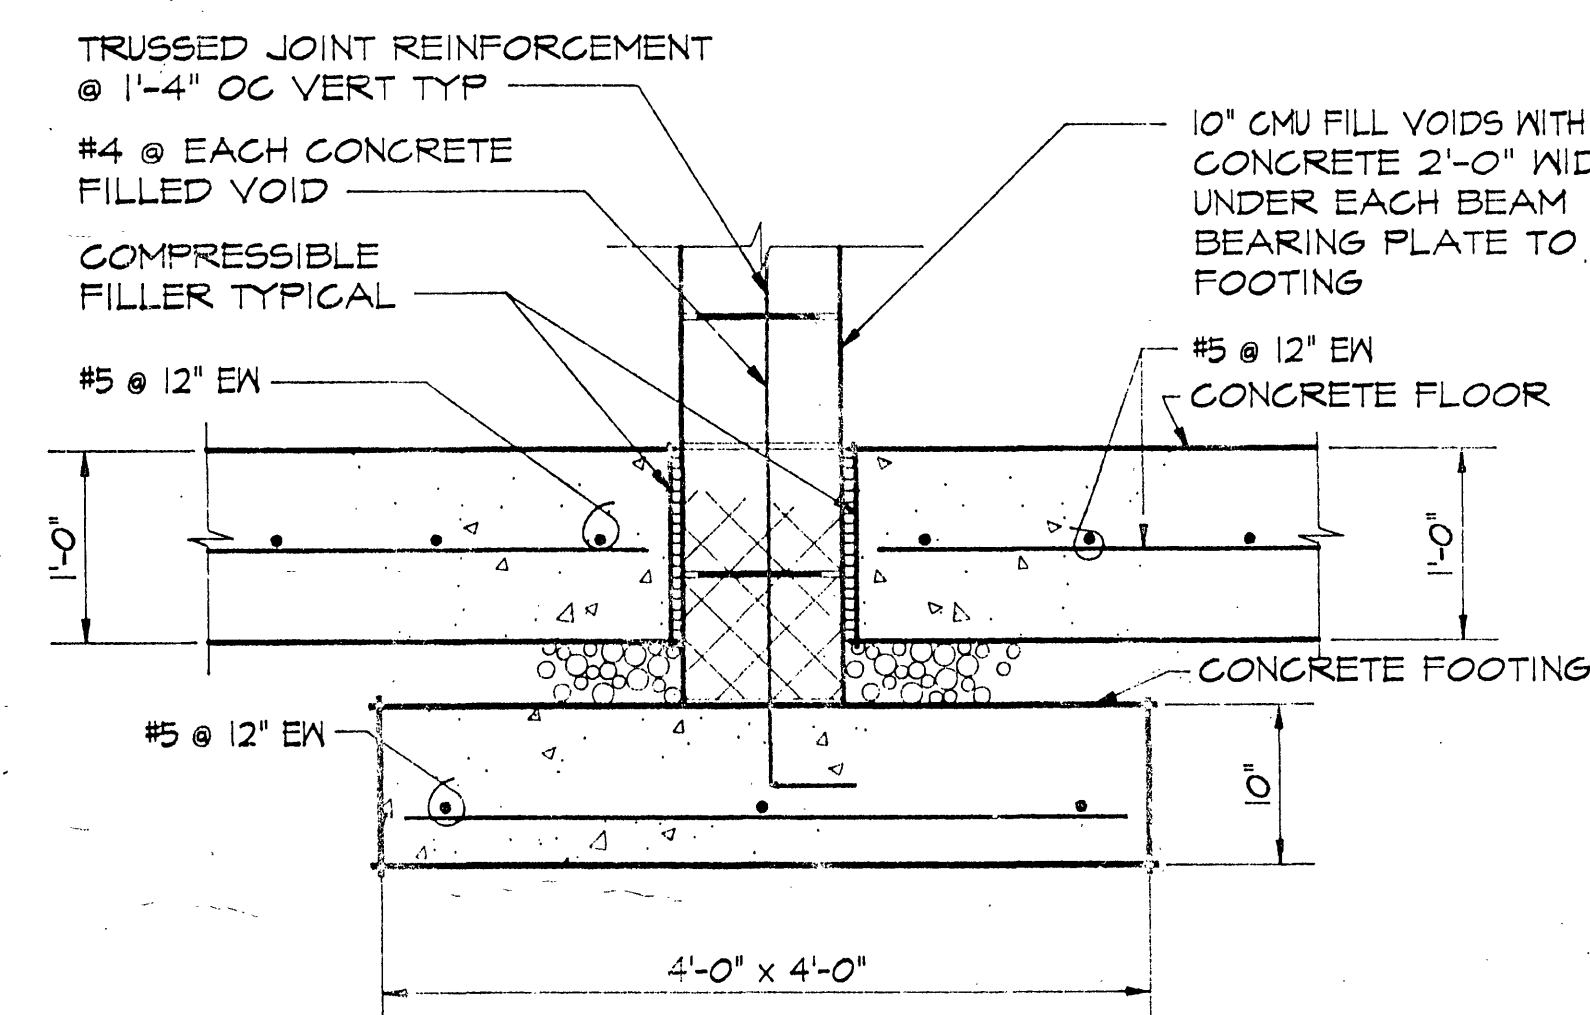


SECTION - FOOTING TYPE N
SCALE 1" = 1'-0"

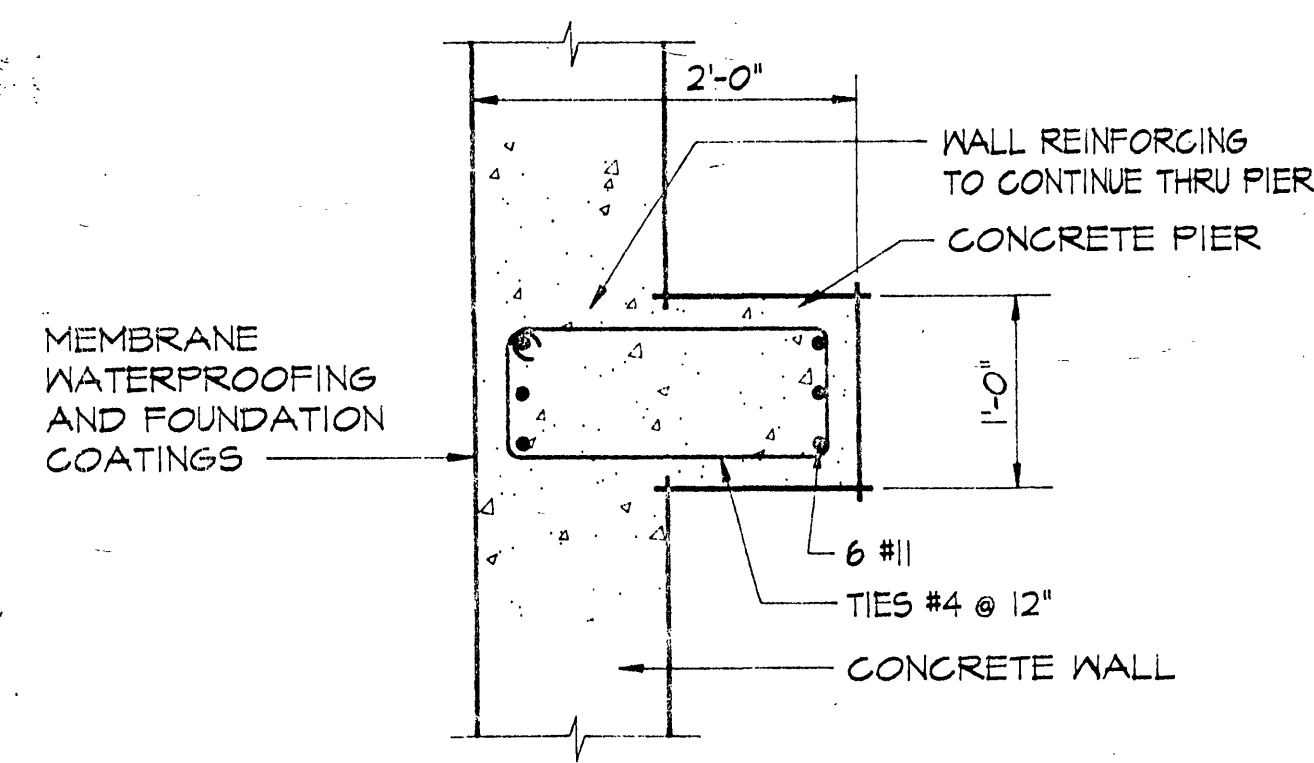


SECTION
SCALE 1" = 1'-0"

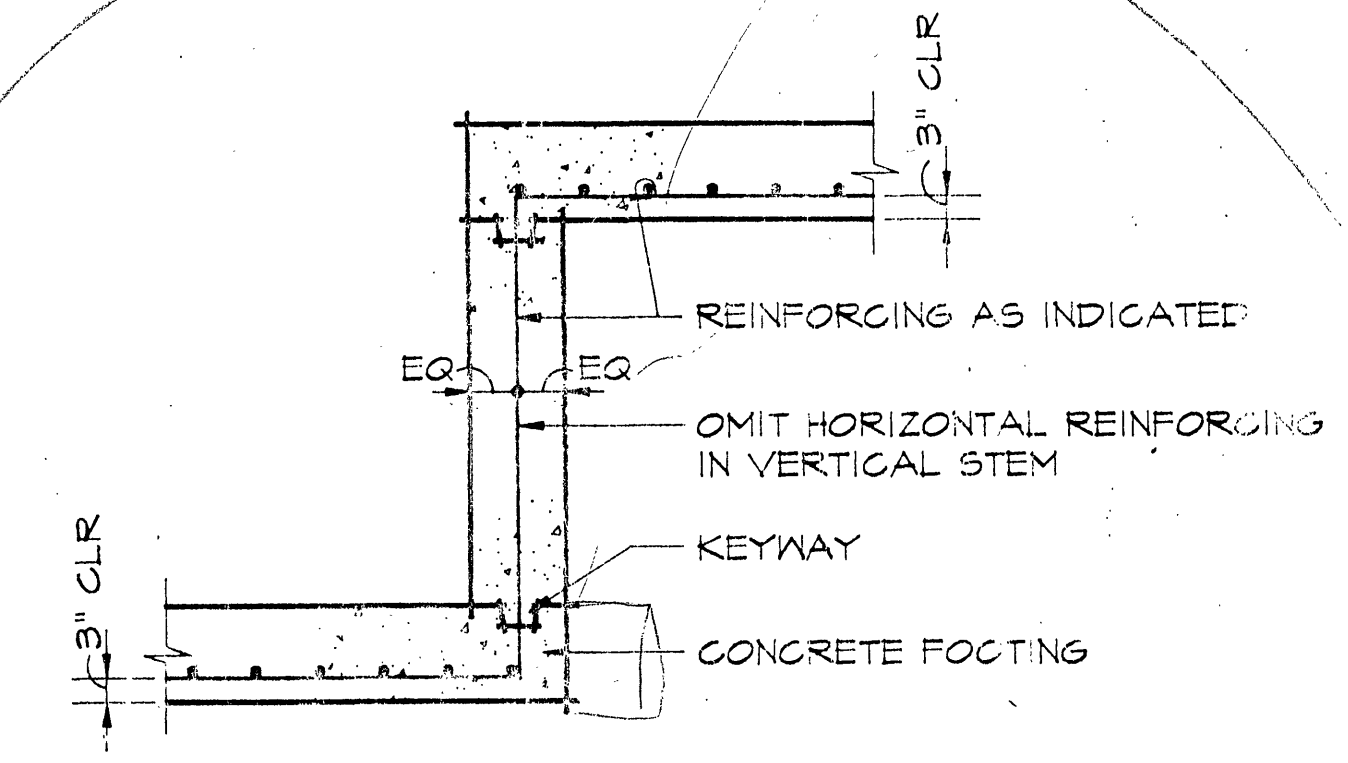

ELEVATION - TYPICAL STEP FOOTING
NOT TO SCALE

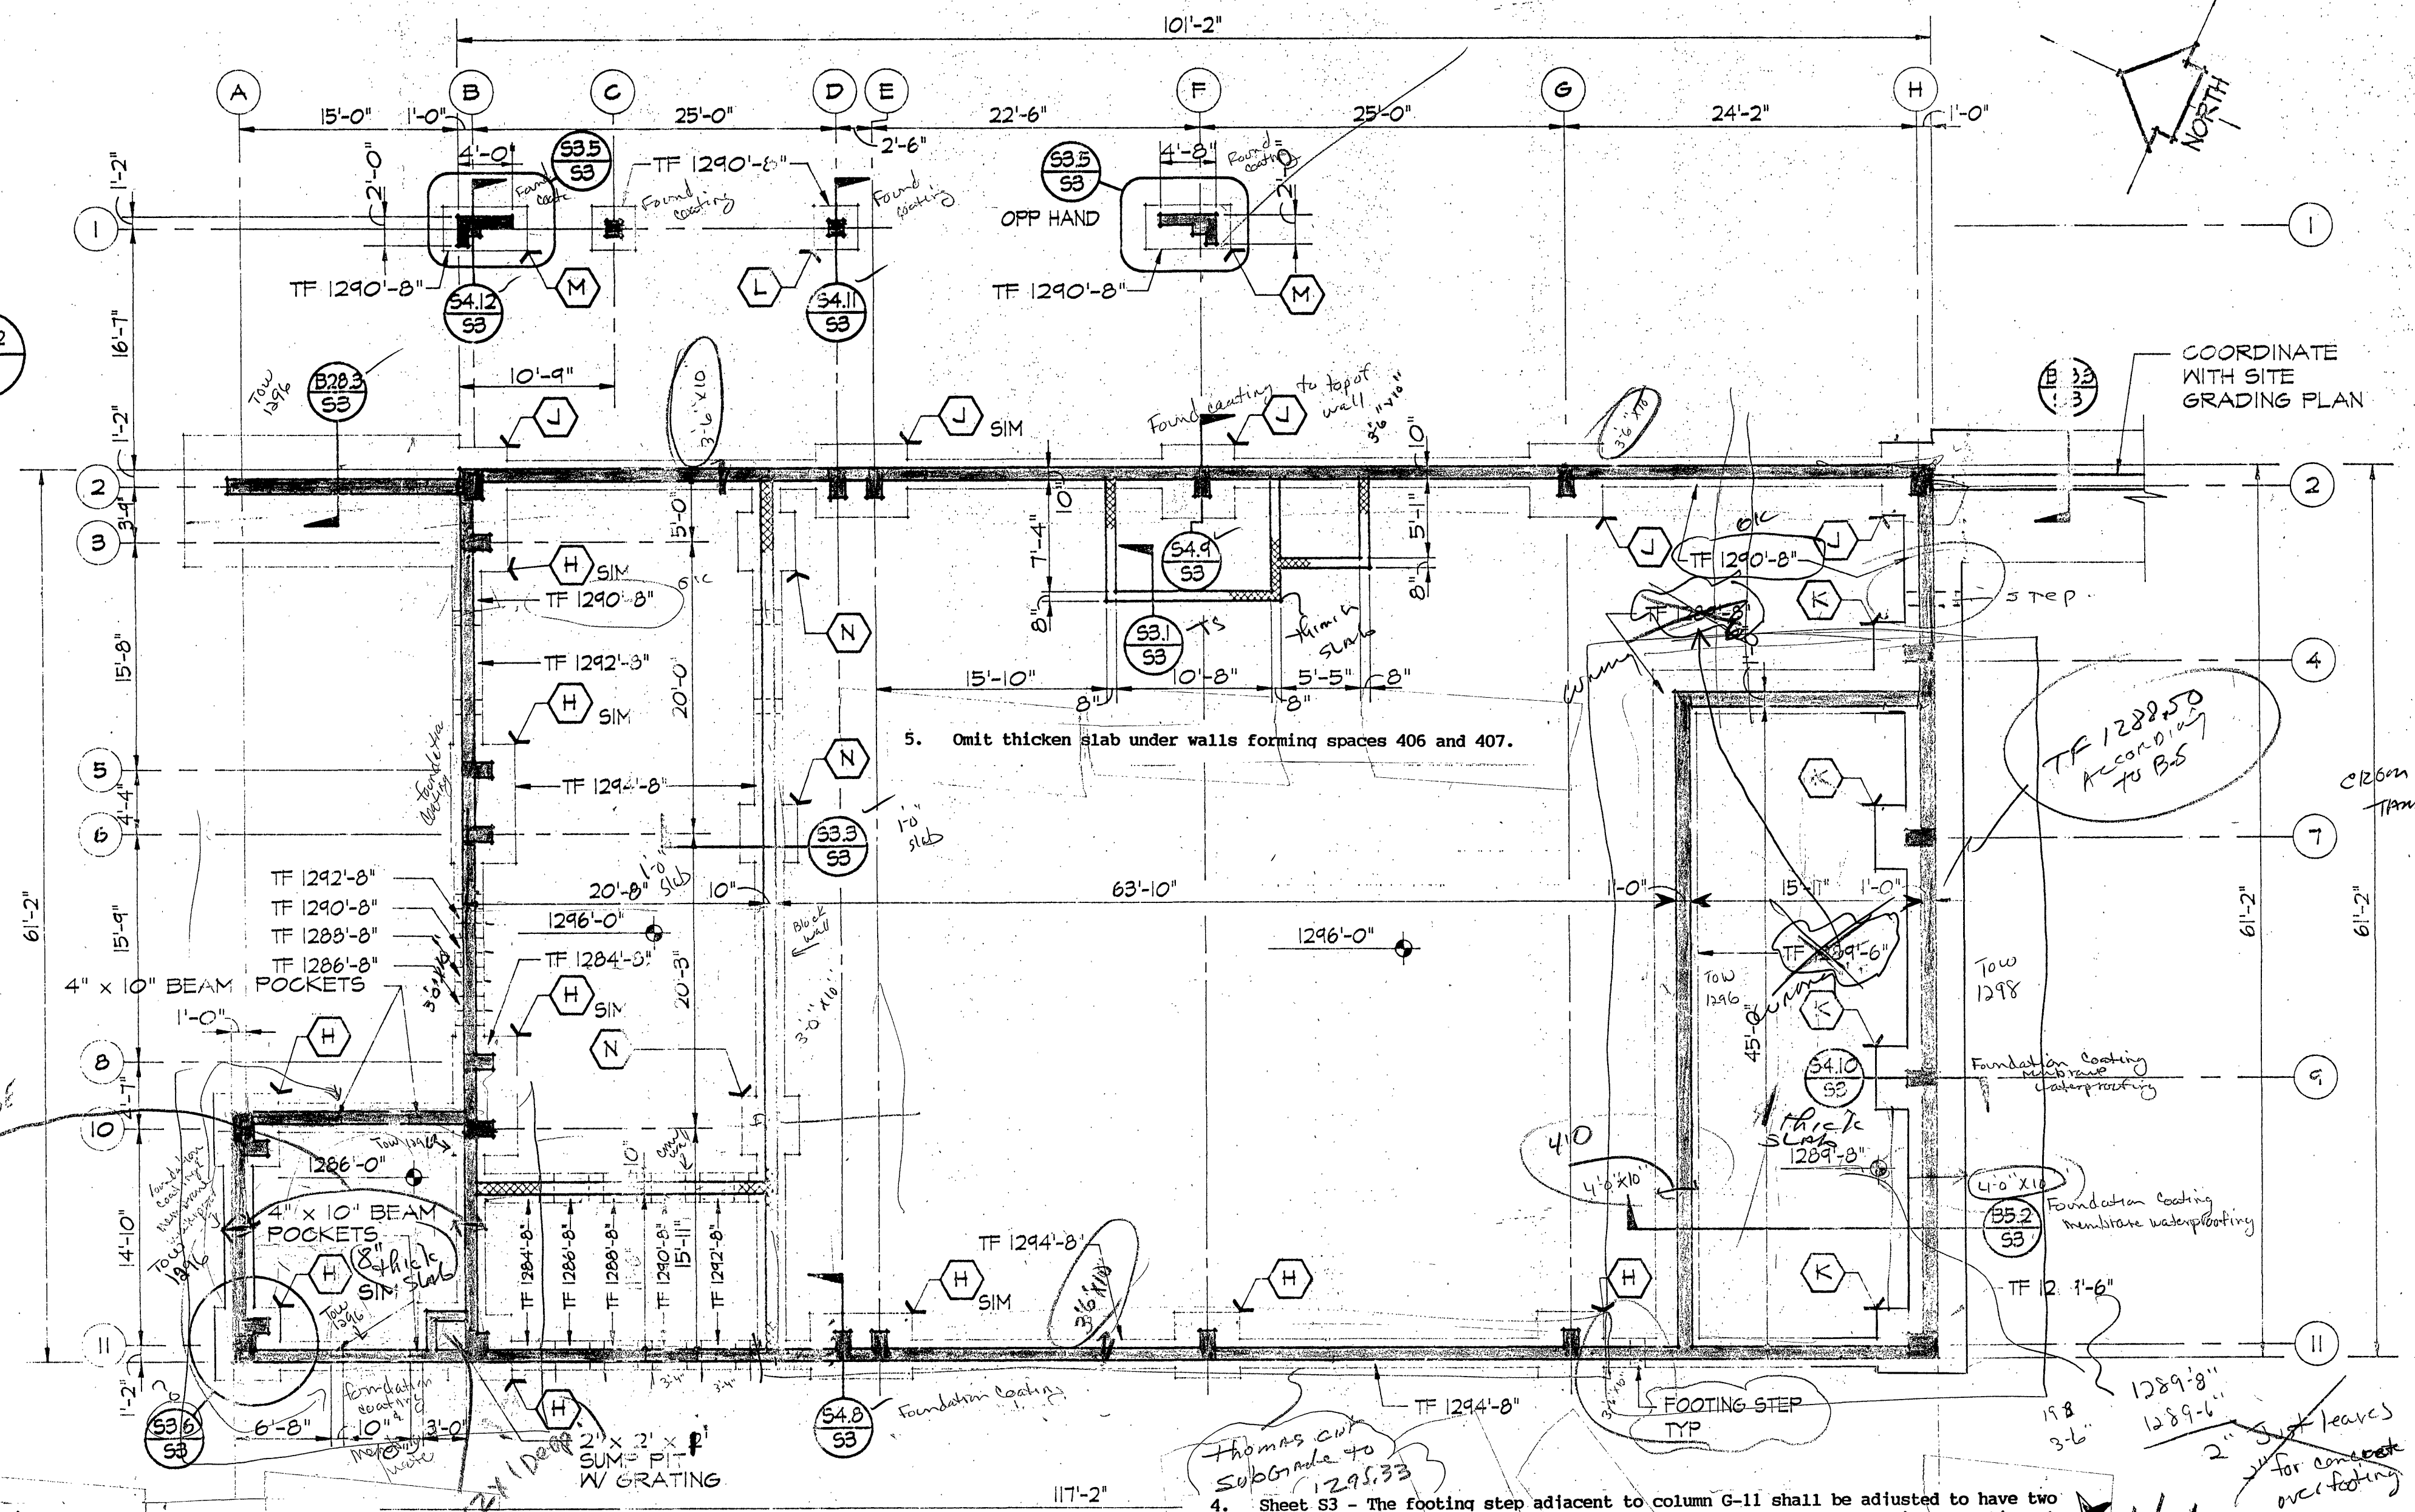


FOOTING AND FOUNDATION PLAN - POST TREATMENT BUILDING
SCALE 1/8" = 1'-0"

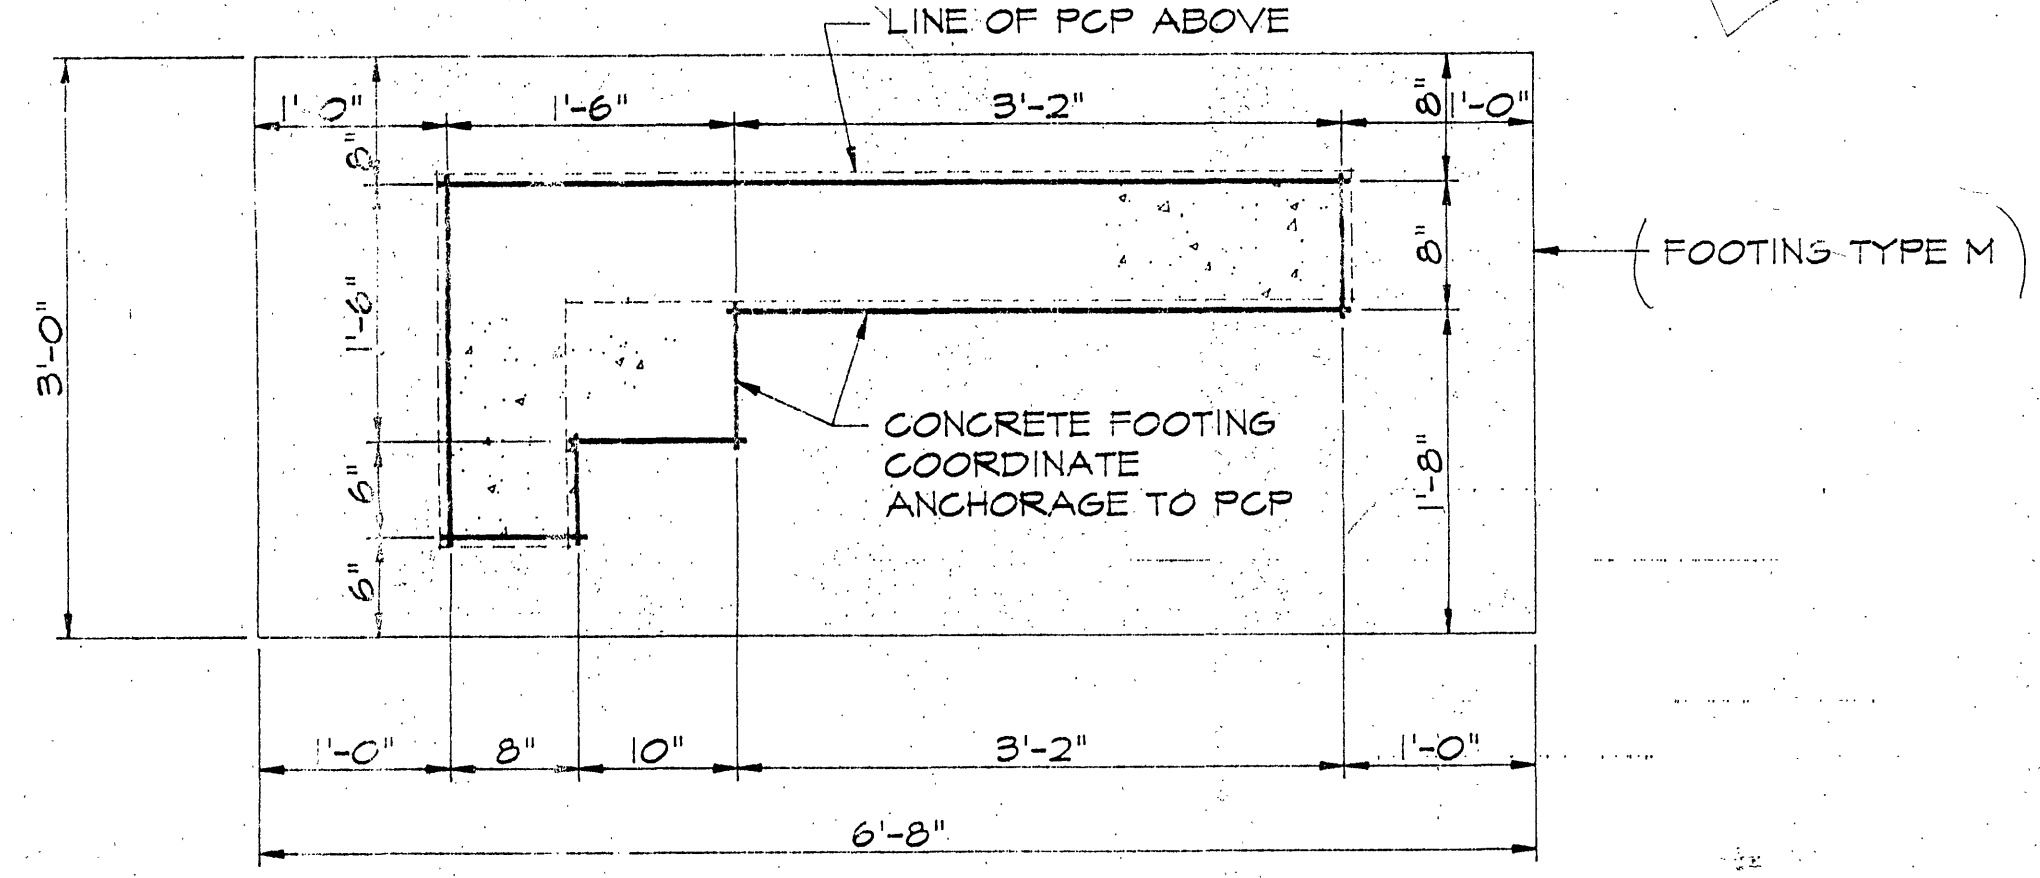


SECTION
SCALE 1" = 1'-0"

INSPECTOR'S AS-BUILTS 1995

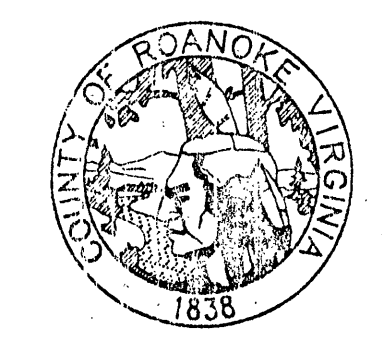

**ROANOKE COUNTY
WATER TREATMENT
FACILITY**

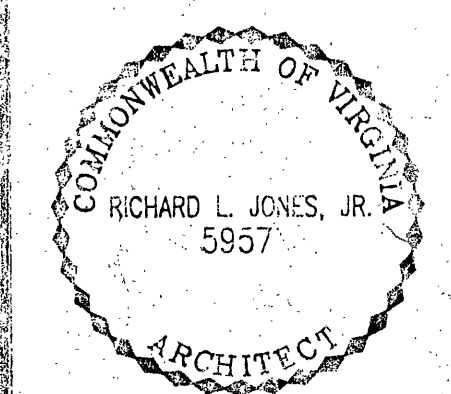

FOOTING AND FOUNDATION PLAN	
PROJECT ARCHITECT RLJ JR	COMMISSION NUMBER 1913
TECHNICIAN RWT	DATE 22 SEPT 1994

S3