


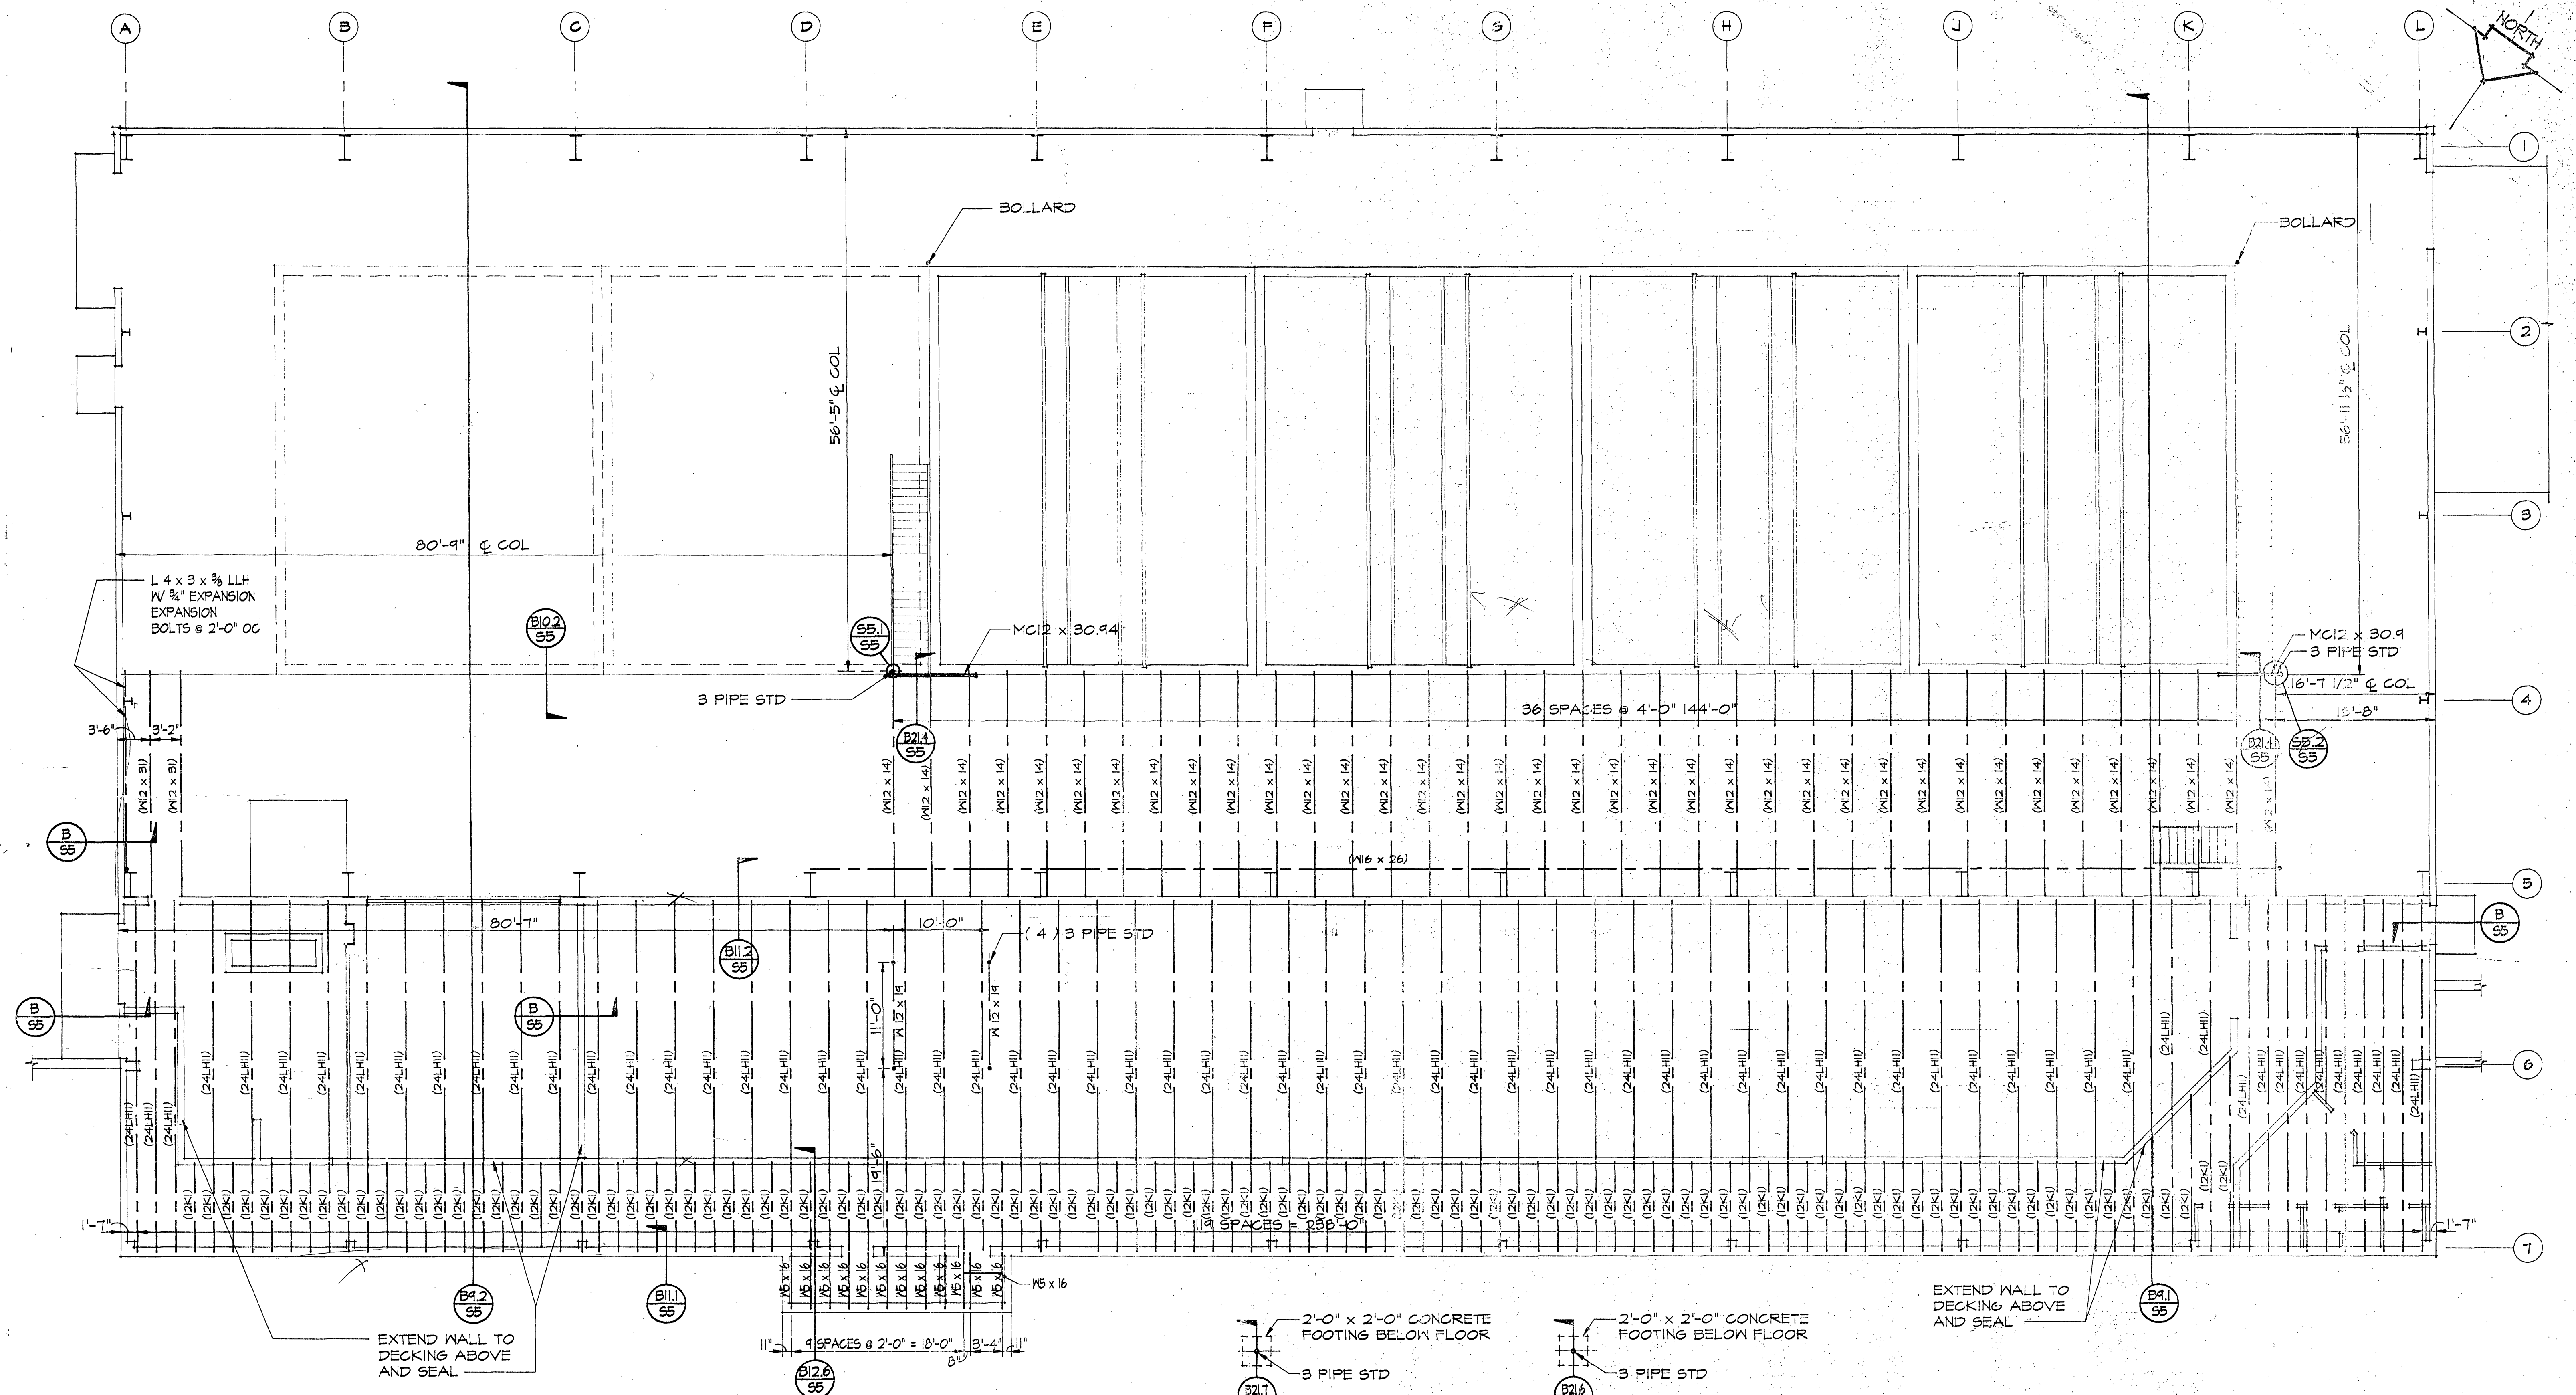

SECOND LEVEL FLOOR FRAMING PLAN - TREATMENT BUILDING
SCALE 1/8" = 1'-0"


2'-0" x 2'-0" CONCRETE
FOOTING BELOW FLOOR
3 PIPE STD
PLAN SECTION 35.1/55
SCALE 3/8" = 1'-0"

2'-0" x 2'-0" CONCRETE
FOOTING BELOW FLOOR
3 PIPE STD
PLAN SECTION 35.2/55
SCALE 3/8" = 1'-0"


EXTEND WALL TO
DECKING ABOVE
AND SEAL

INSPECTOR'S AS-BUILTS 1995

WWW.ID#6LDLWZ

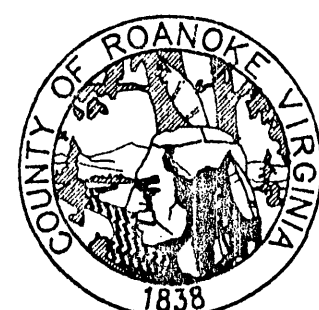

ROANOKE COUNTY WATER TREATMENT FACILITY

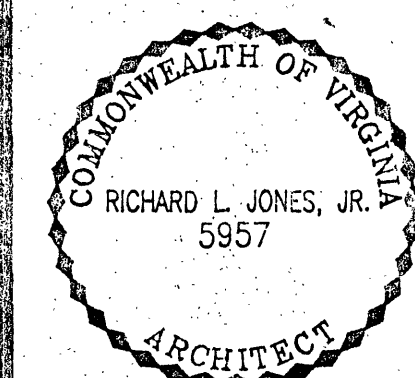

SECOND LEVEL FLOOR FRAMING

PROJECT ARCHITECT RLJ JR	COMMISSION NUMBER 1913
TECHNICIANS RAT	DATE 22 SEPT 1994

S5