



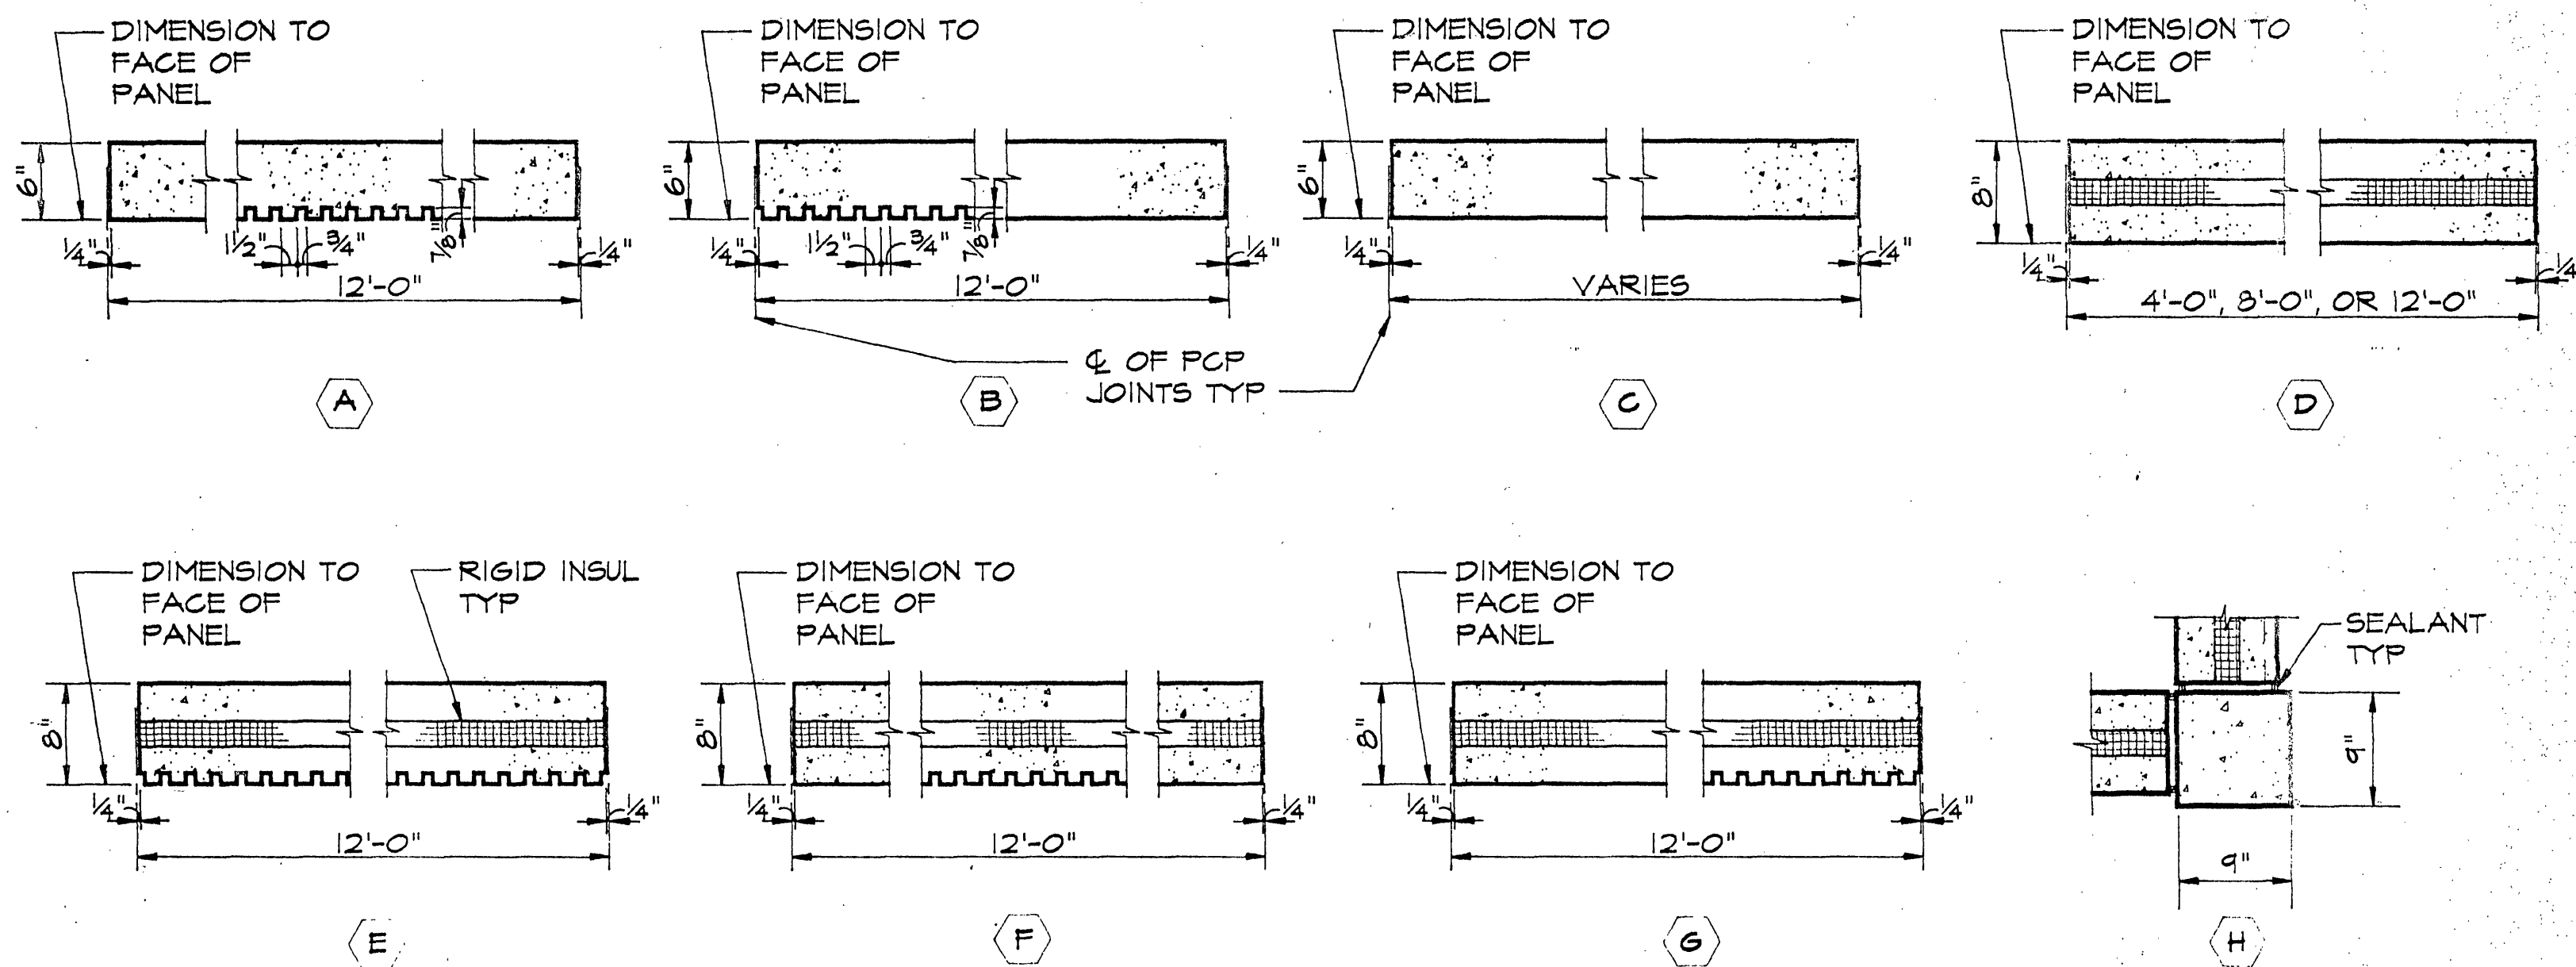


PRECAST CONCRETE PANEL TYPES

SCALE 1" = 1'-0"

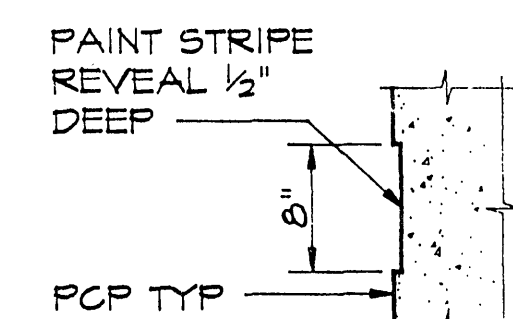

SECTION @ PAINT STRIPE


SCALE 1" = 1'-0"

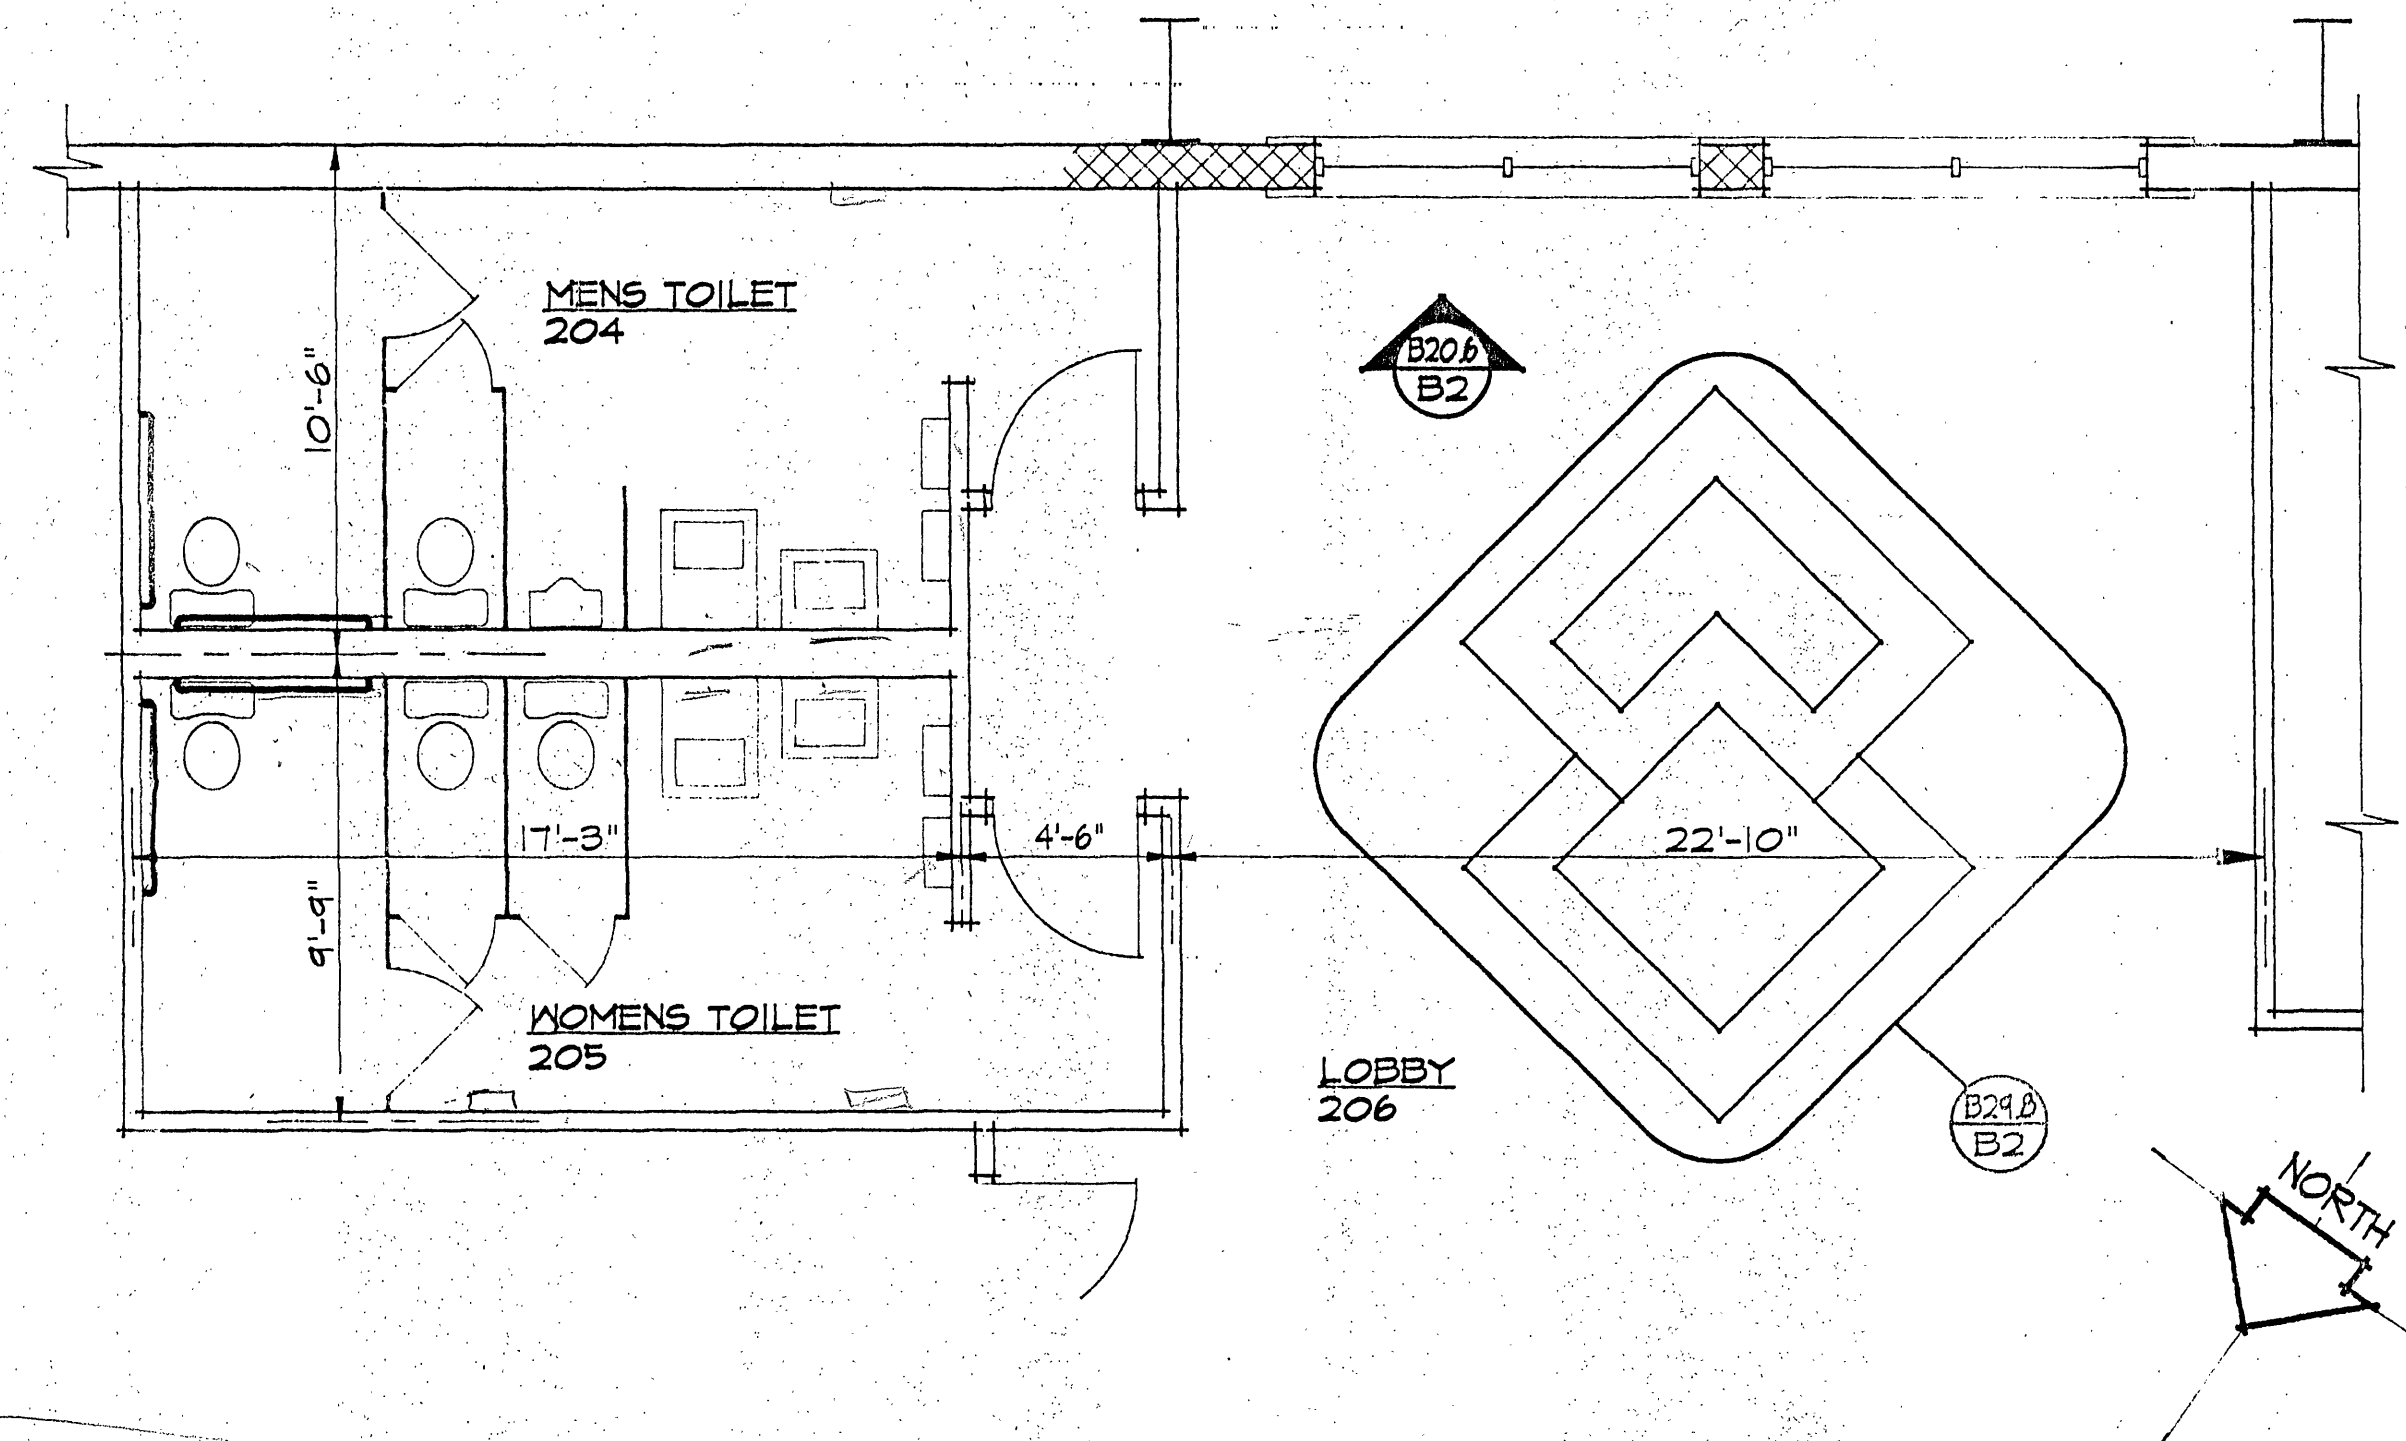

FLOOR PLAN OF TOILETS - TREATMENT BUILDING

SCALE 1/4" = 1'-0"

B3.1
B2

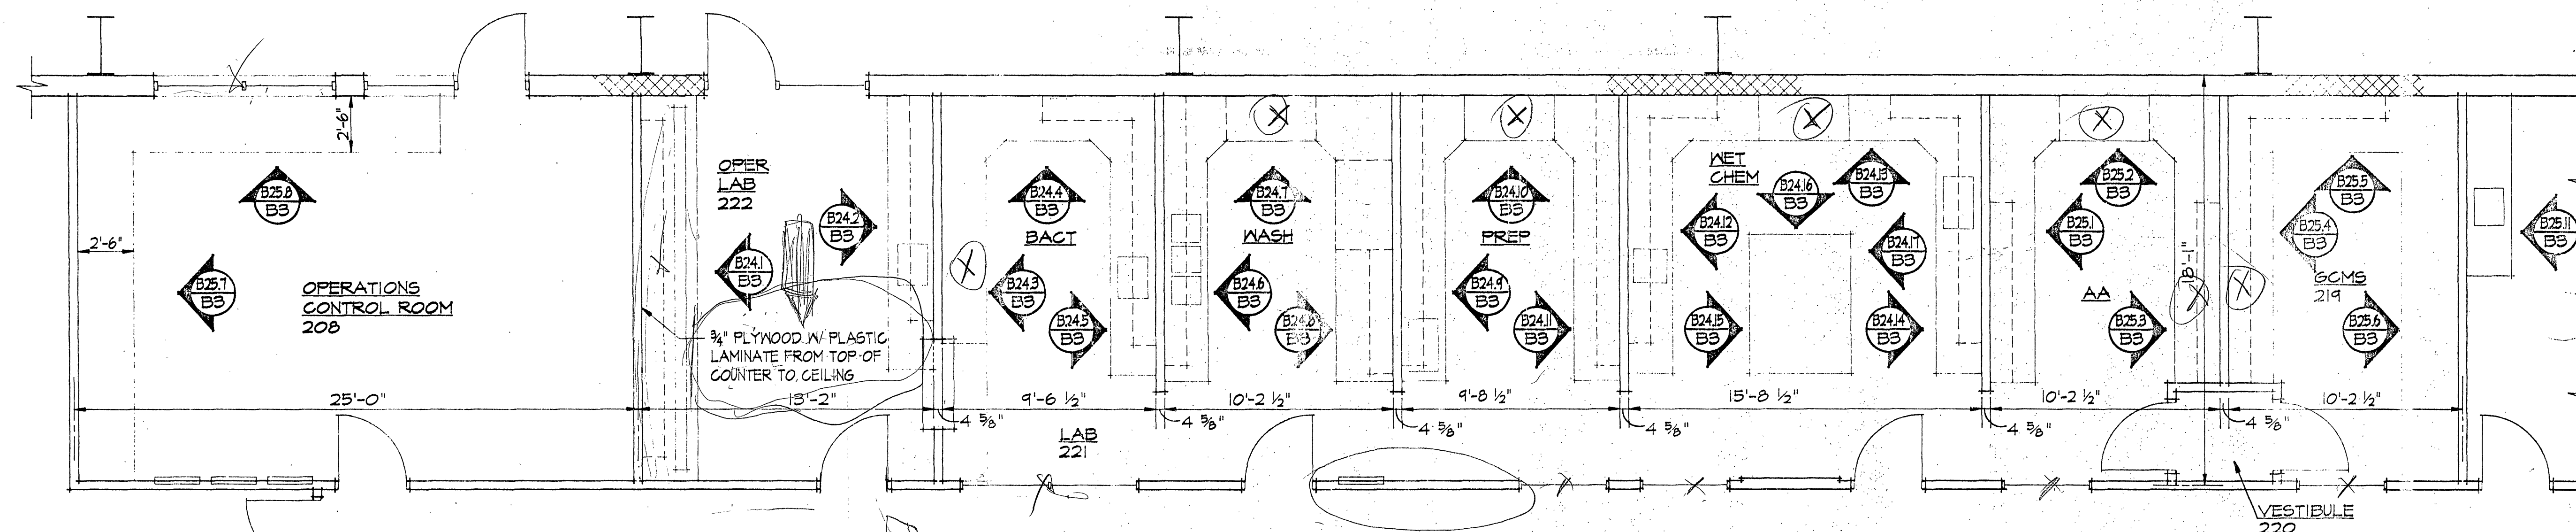


FLOOR PLAN OF LABS - TREATMENT BUILDING

SCALE 1/4" = 1'-0"


B3.1
B2

INSPECTOR'S AS-BUILTS 1995

WWW.ID# 6LDLIZ

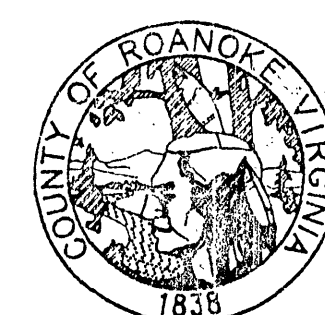

ROANOKE COUNTY WATER TREATMENT FACILITY

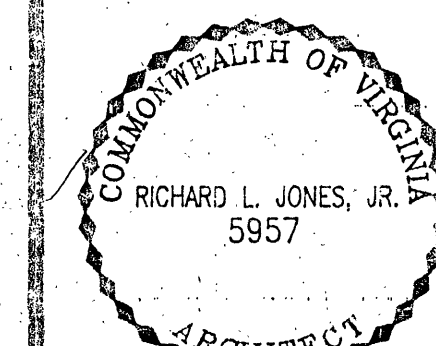

FLOOR PLAN OF LABS AND TOILETS

PROJECT ARCHITECT
RLJ JR

COMMISSION NUMBER
913

TECHNICIAN
RAT

DATE
22 SEPT 1994

B3

JONES & JONES ASSOCIATES / ARCHITECTS, PC