



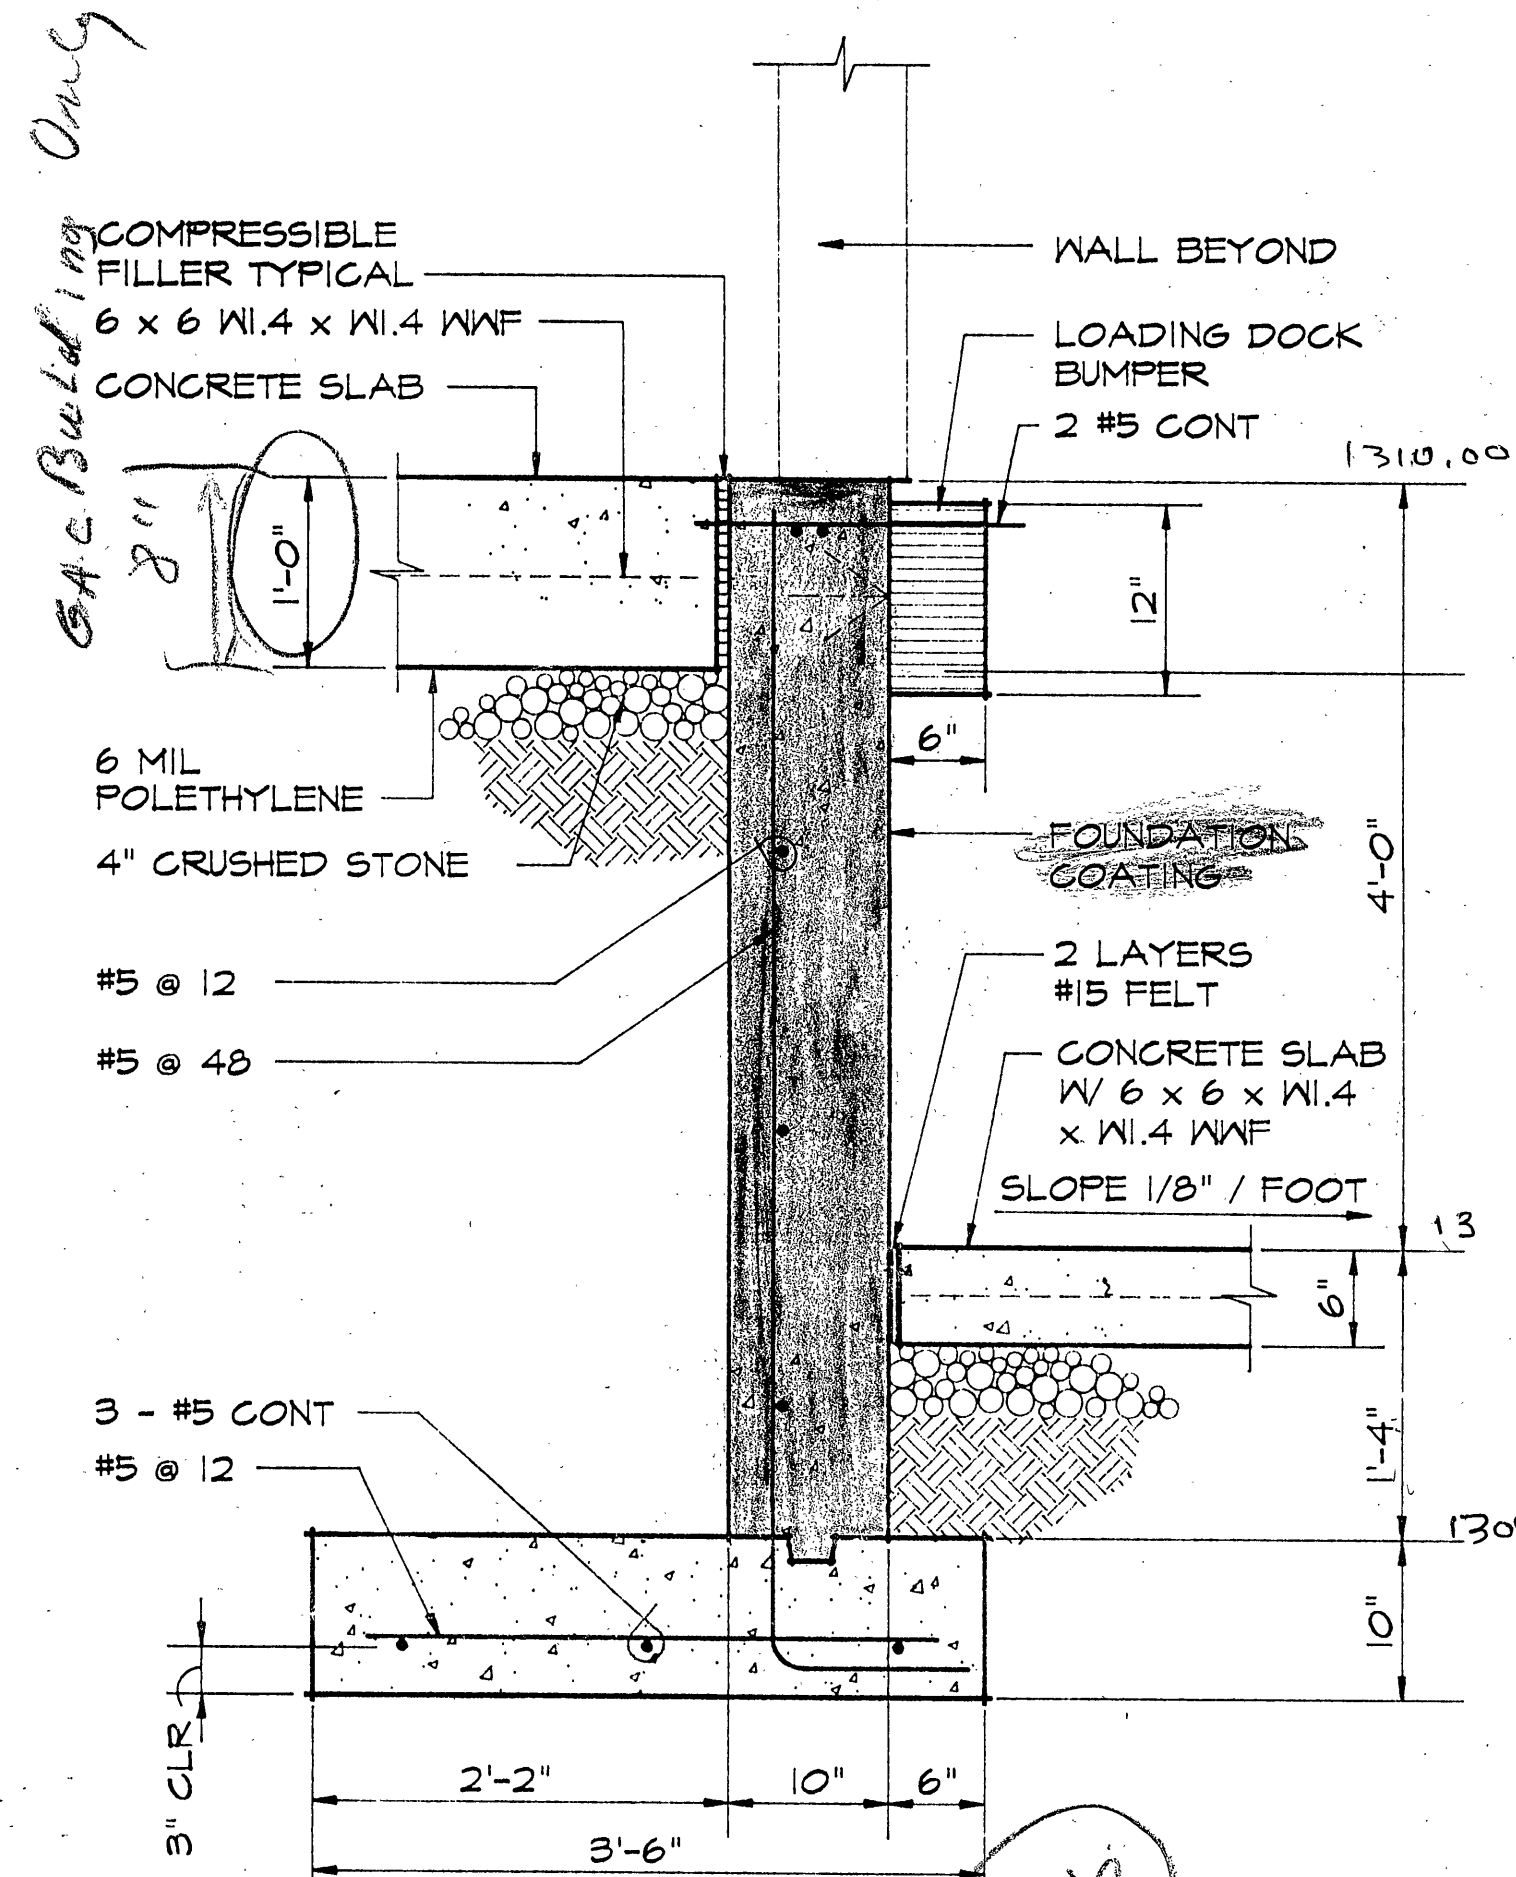


SECTION
SCALE 1" = 1'-0"

**BASEMENT PLAN -
PUMP ROOM**
SCALE 1/8" = 1'-0"

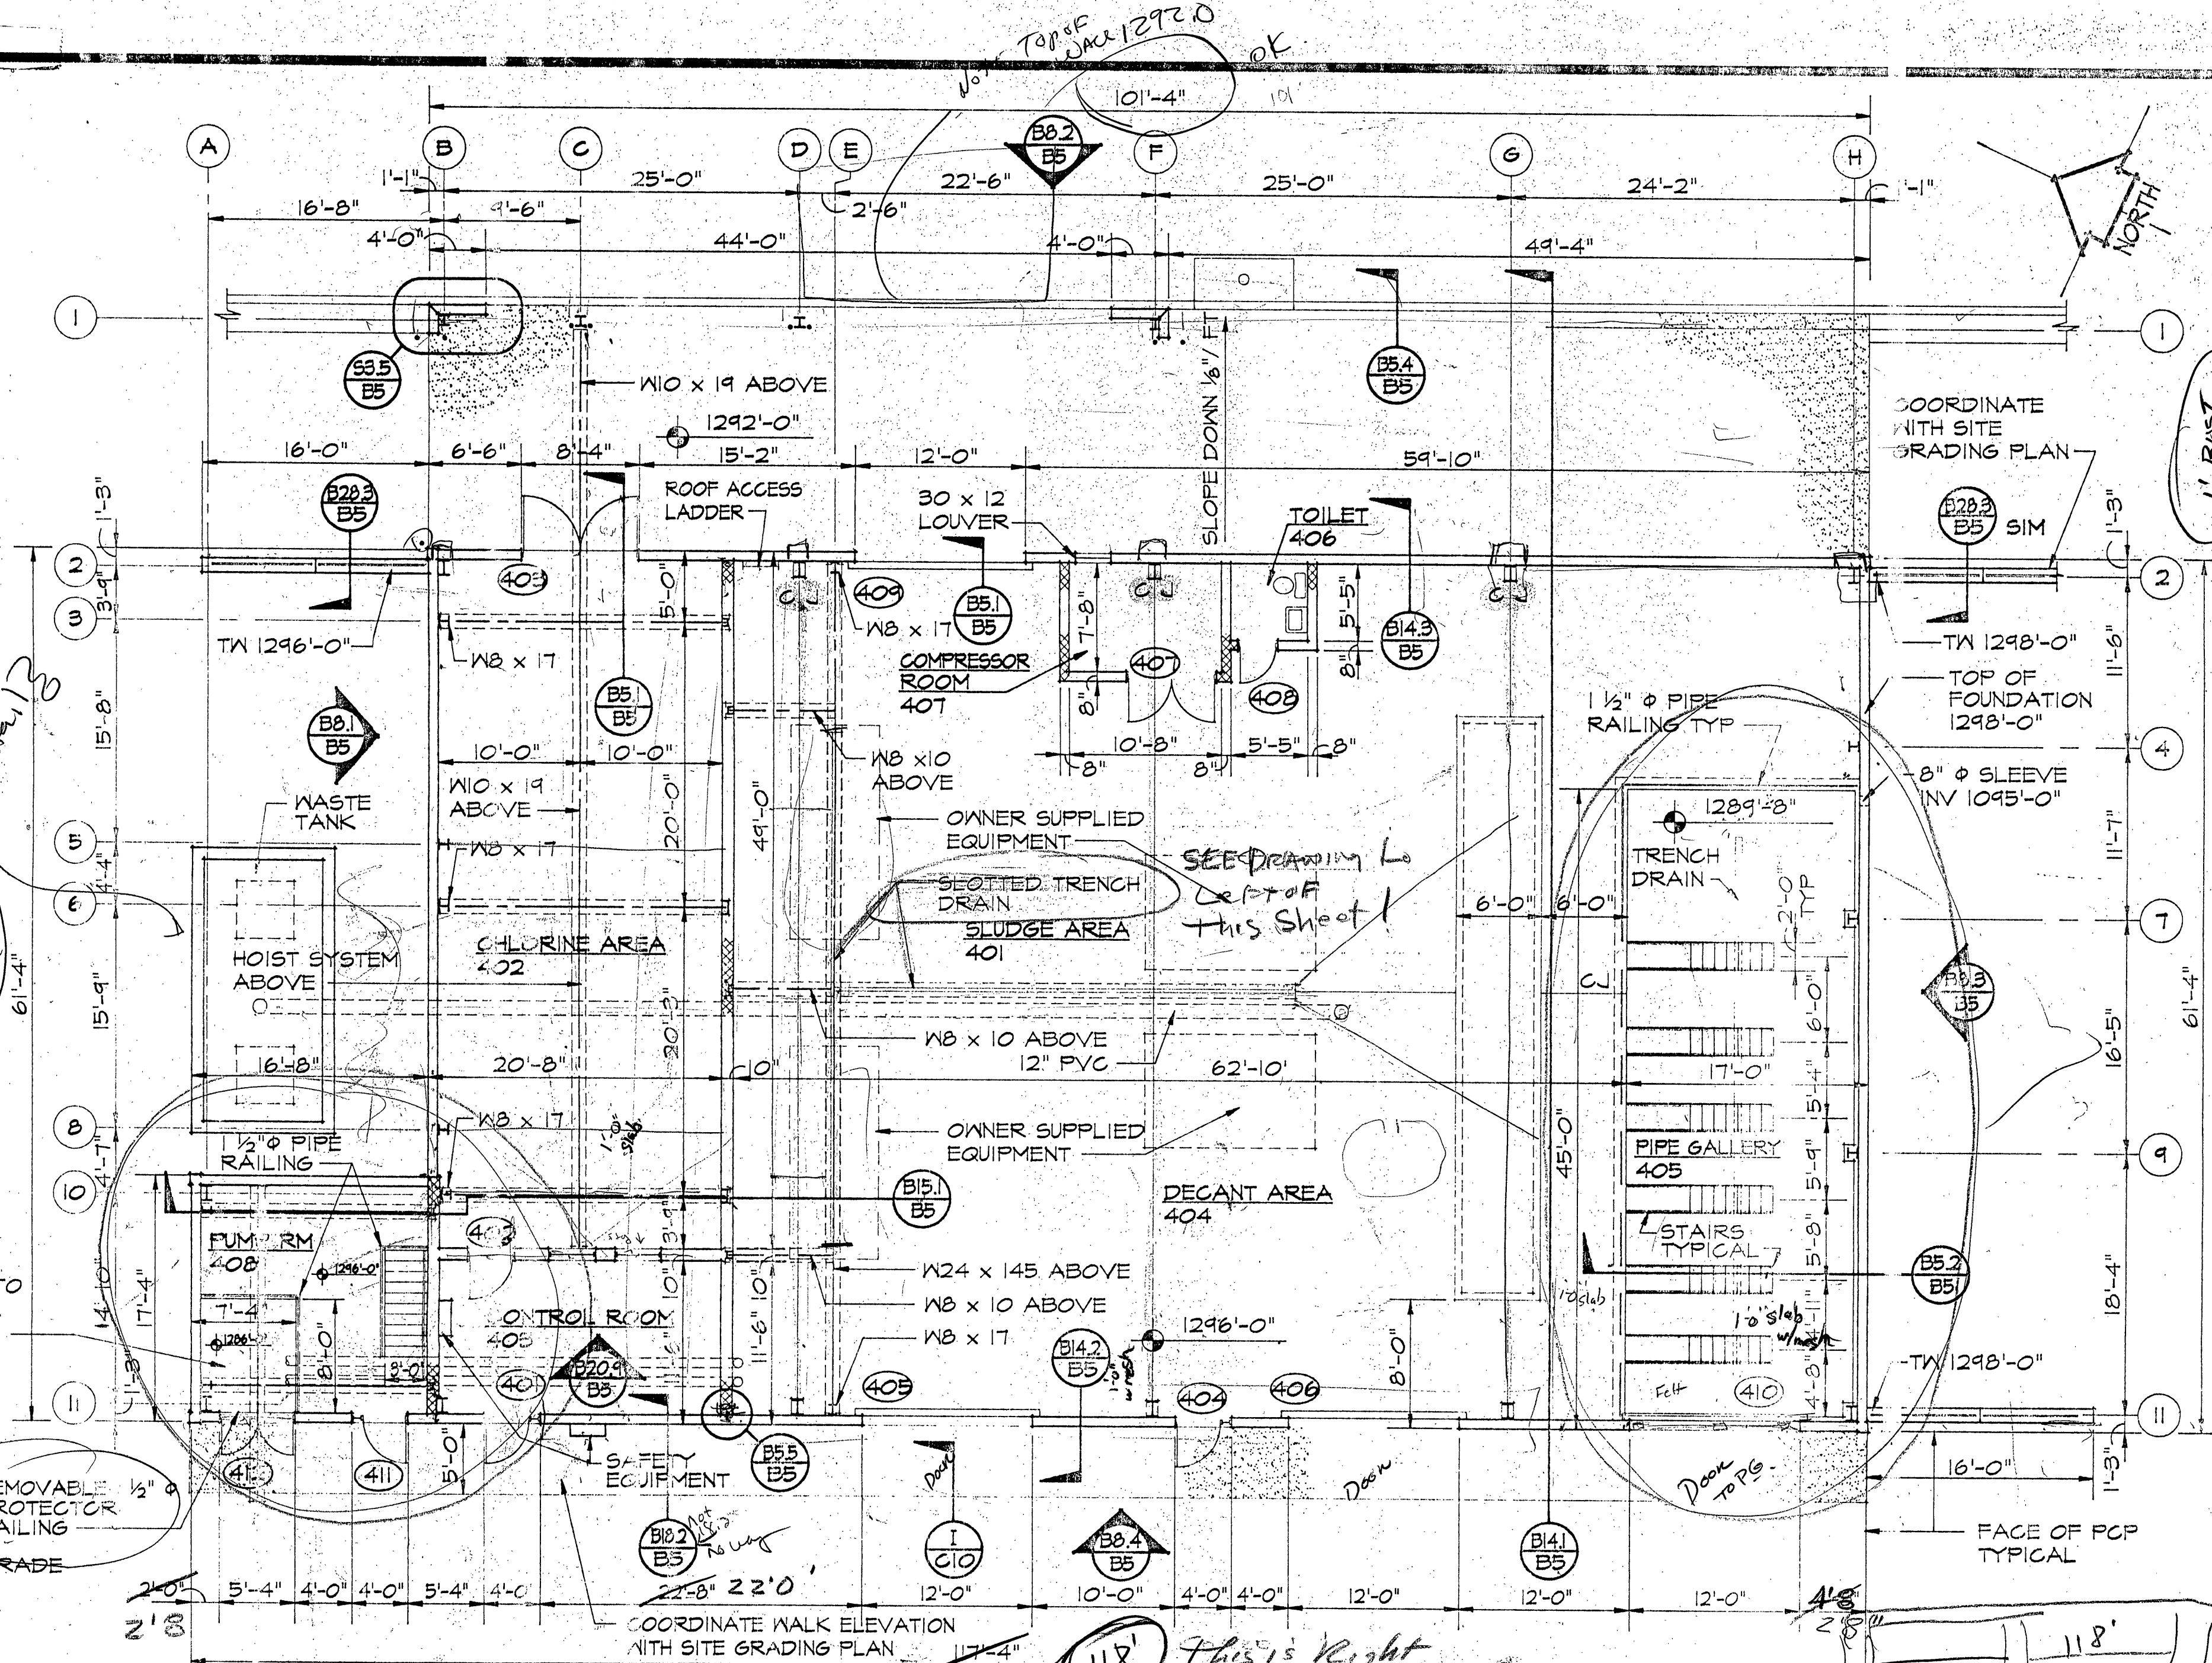


FLOOR PLAN - POST TREATMENT BUILDING
SCALE 1/8" = 1'-0"

- NOTES
1. INSTALL PVC CONDUITS, TANKS, TANK CONNECTIONS, EQUIPMENT AND FILL CONNECTIONS AS INDICATED BY TREATMENT SYSTEM DETAILS CO-ORDINATE THE LOCATION OF ALL WALL PENETRATIONS WITH THE TREATMENT SYSTEM DETAILS
 2. This section does not match other sections

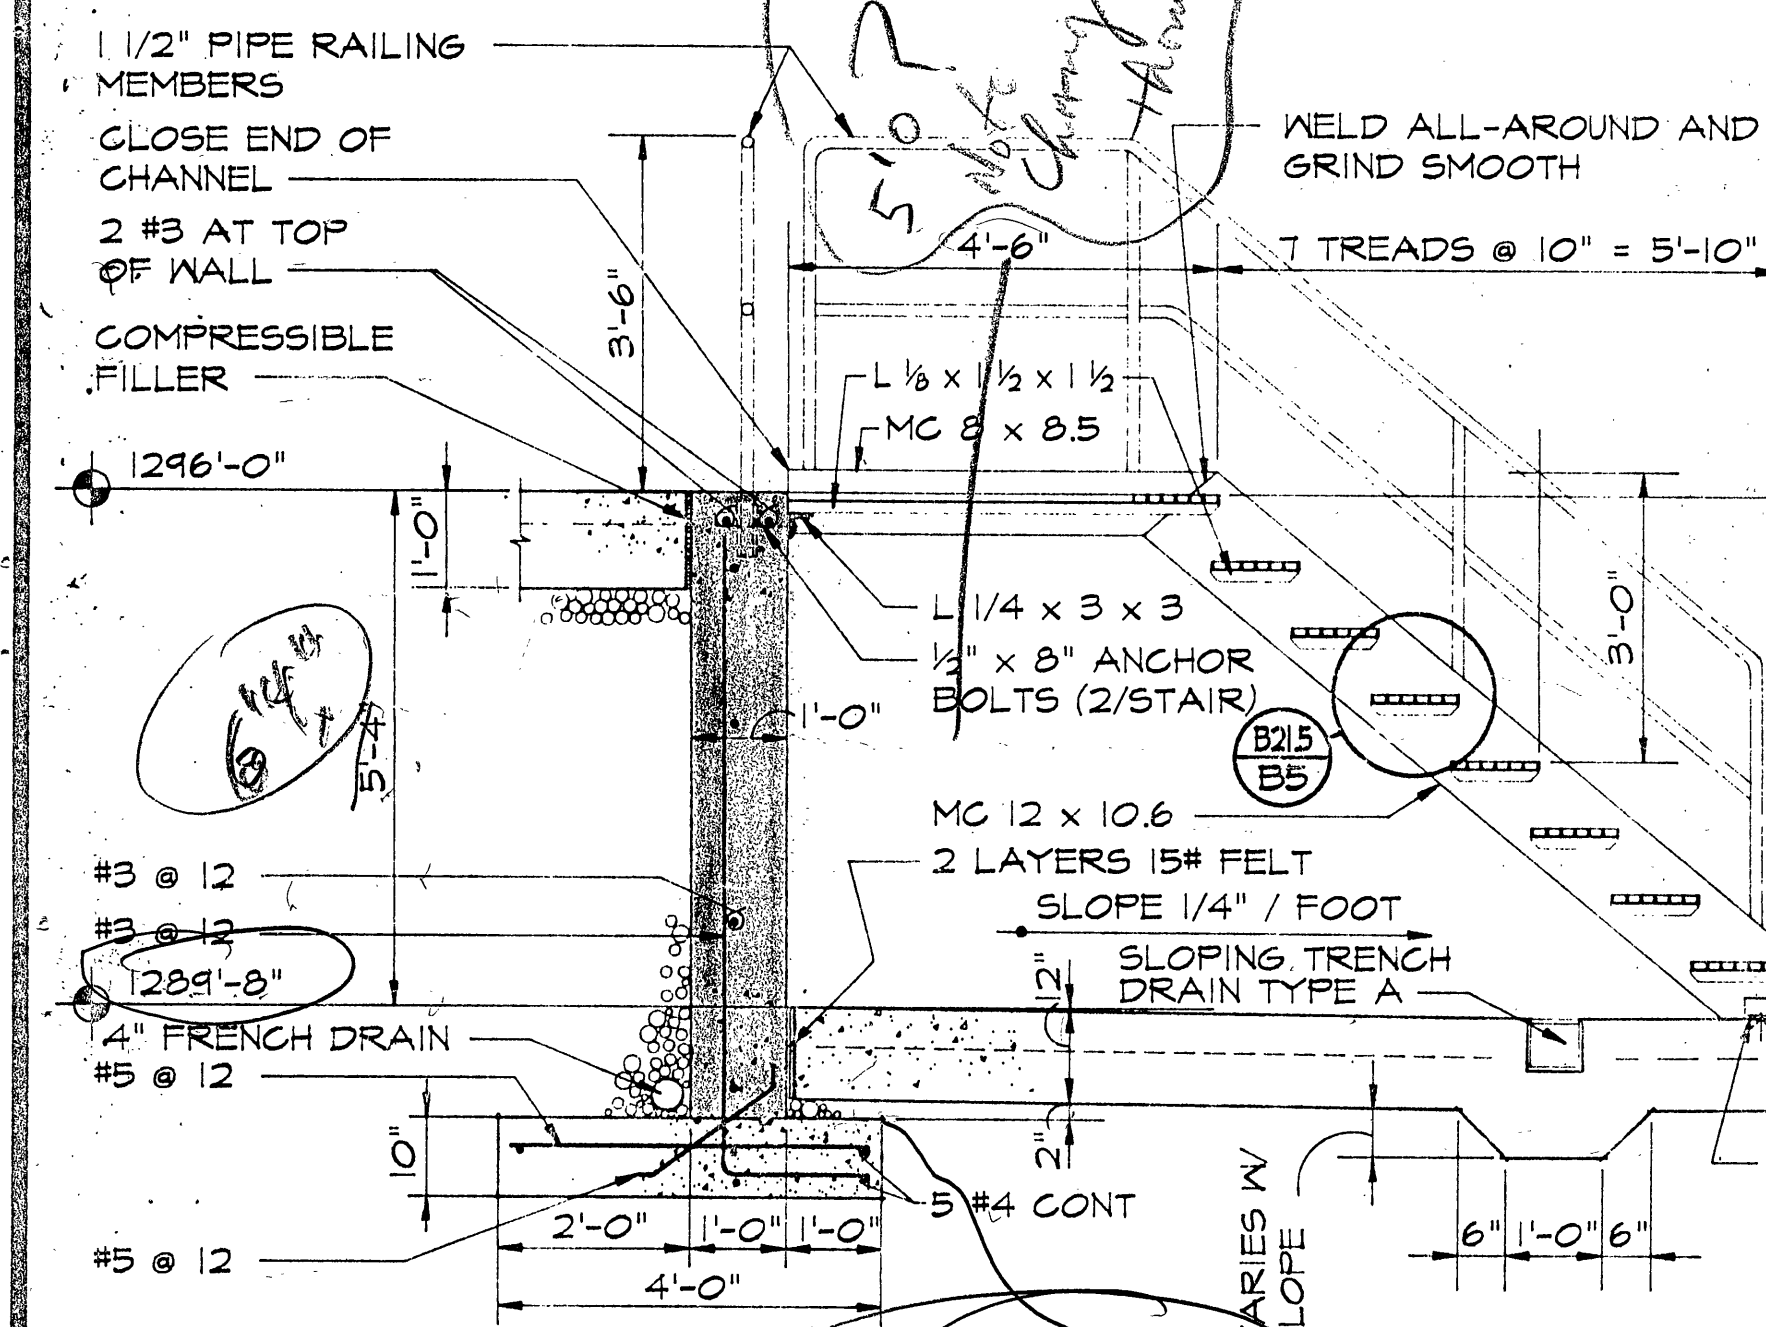


SECTION
SCALE 1/2" = 1'-0"


2. Section B5.2 - The vertical dimension between the floors shall be 6'-4". The horizontal landing dimension shall be 5'-0"

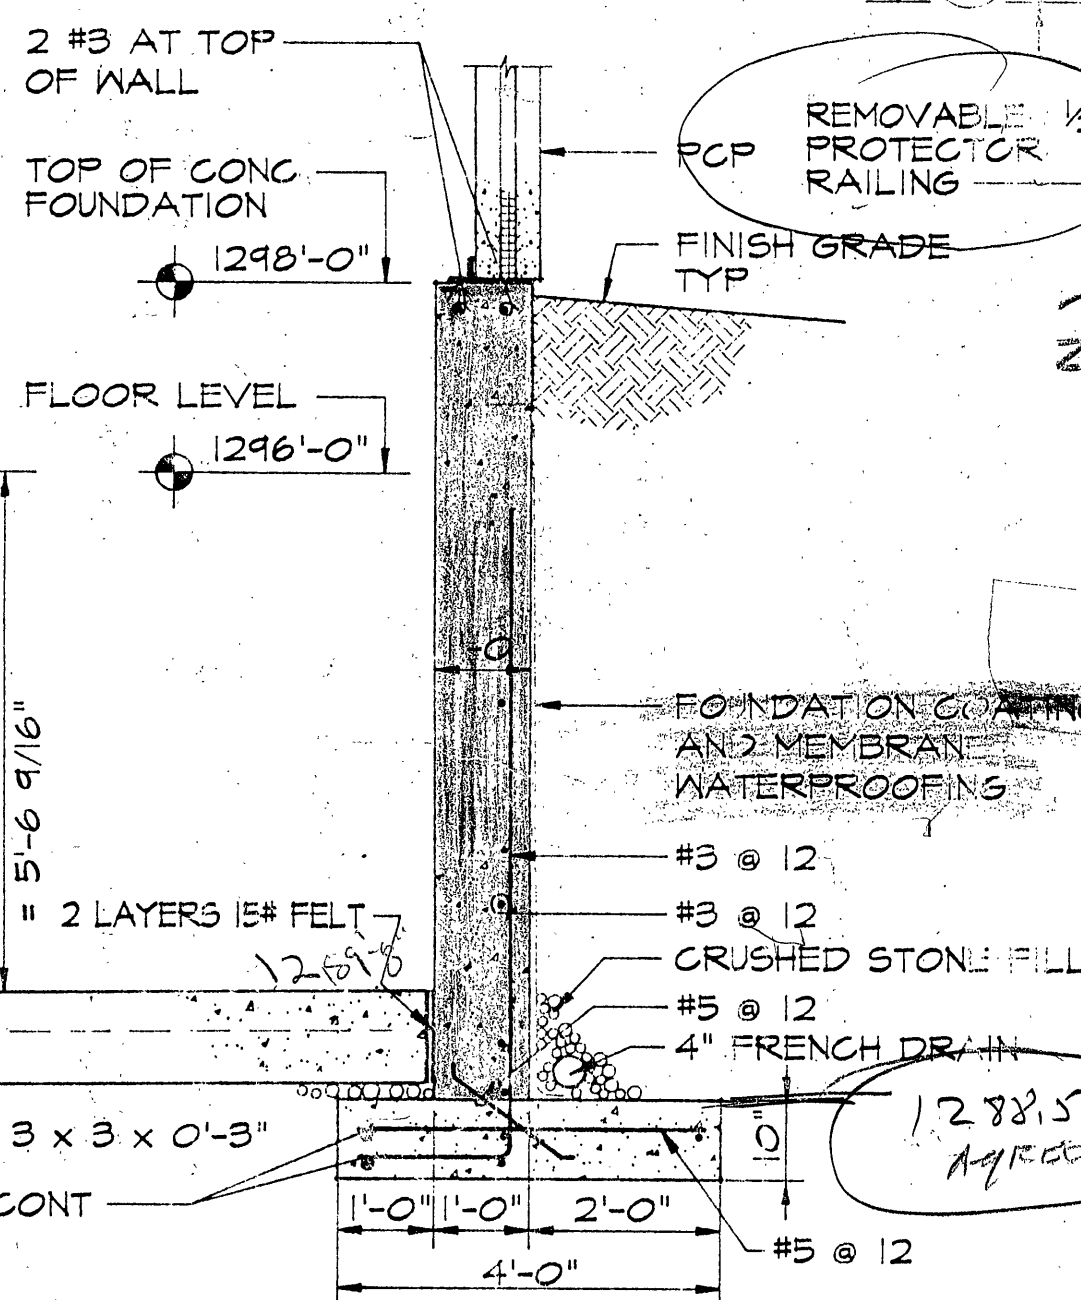

SECTION
SCALE 1" = 1'-0"

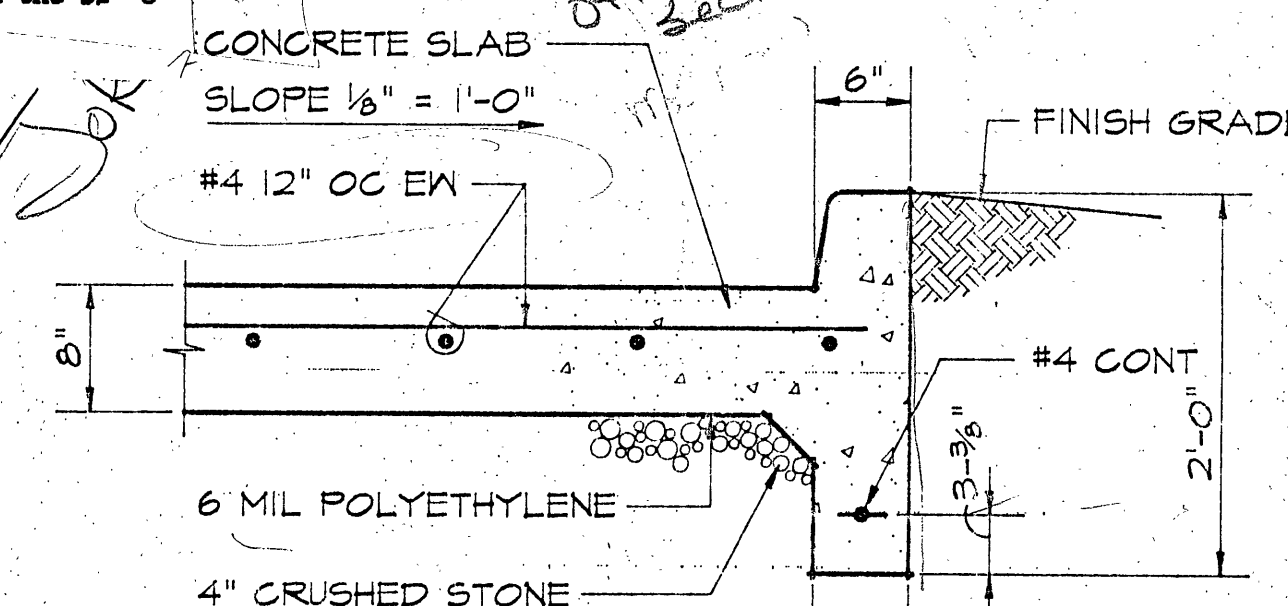


SECTION
SCALE 1" = 1'-0"

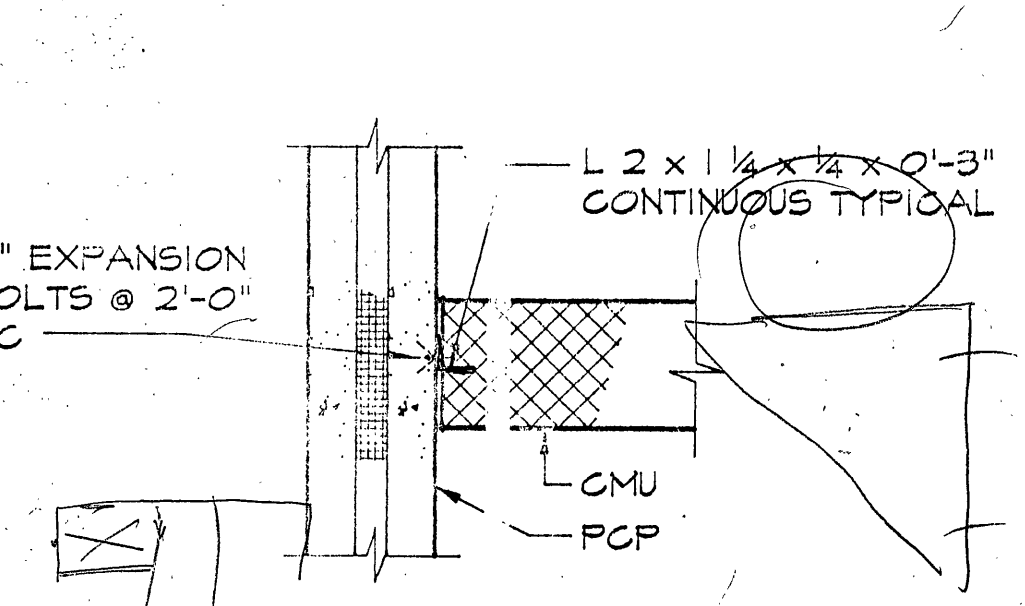

SECTION TYPIC - CMU - PCP JOINT
SCALE 1" = 1'-0"

INSPECTOR'S AS-BUILTS 1995

WWW.ID# 8LDL2

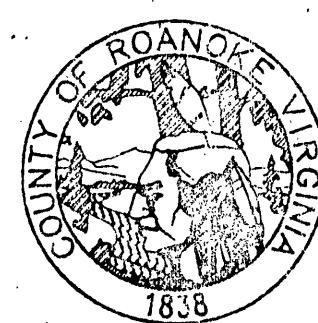

**ROANOKE COUNTY
WATER TREATMENT
FACILITY**

FLOOR PLAN - POST TREATMENT

PROJECT ARCHITECT RJR	COMMISSION NUMBER 913
TECHNICIAN RAT	DATE 12 SEPT 1994

B5