



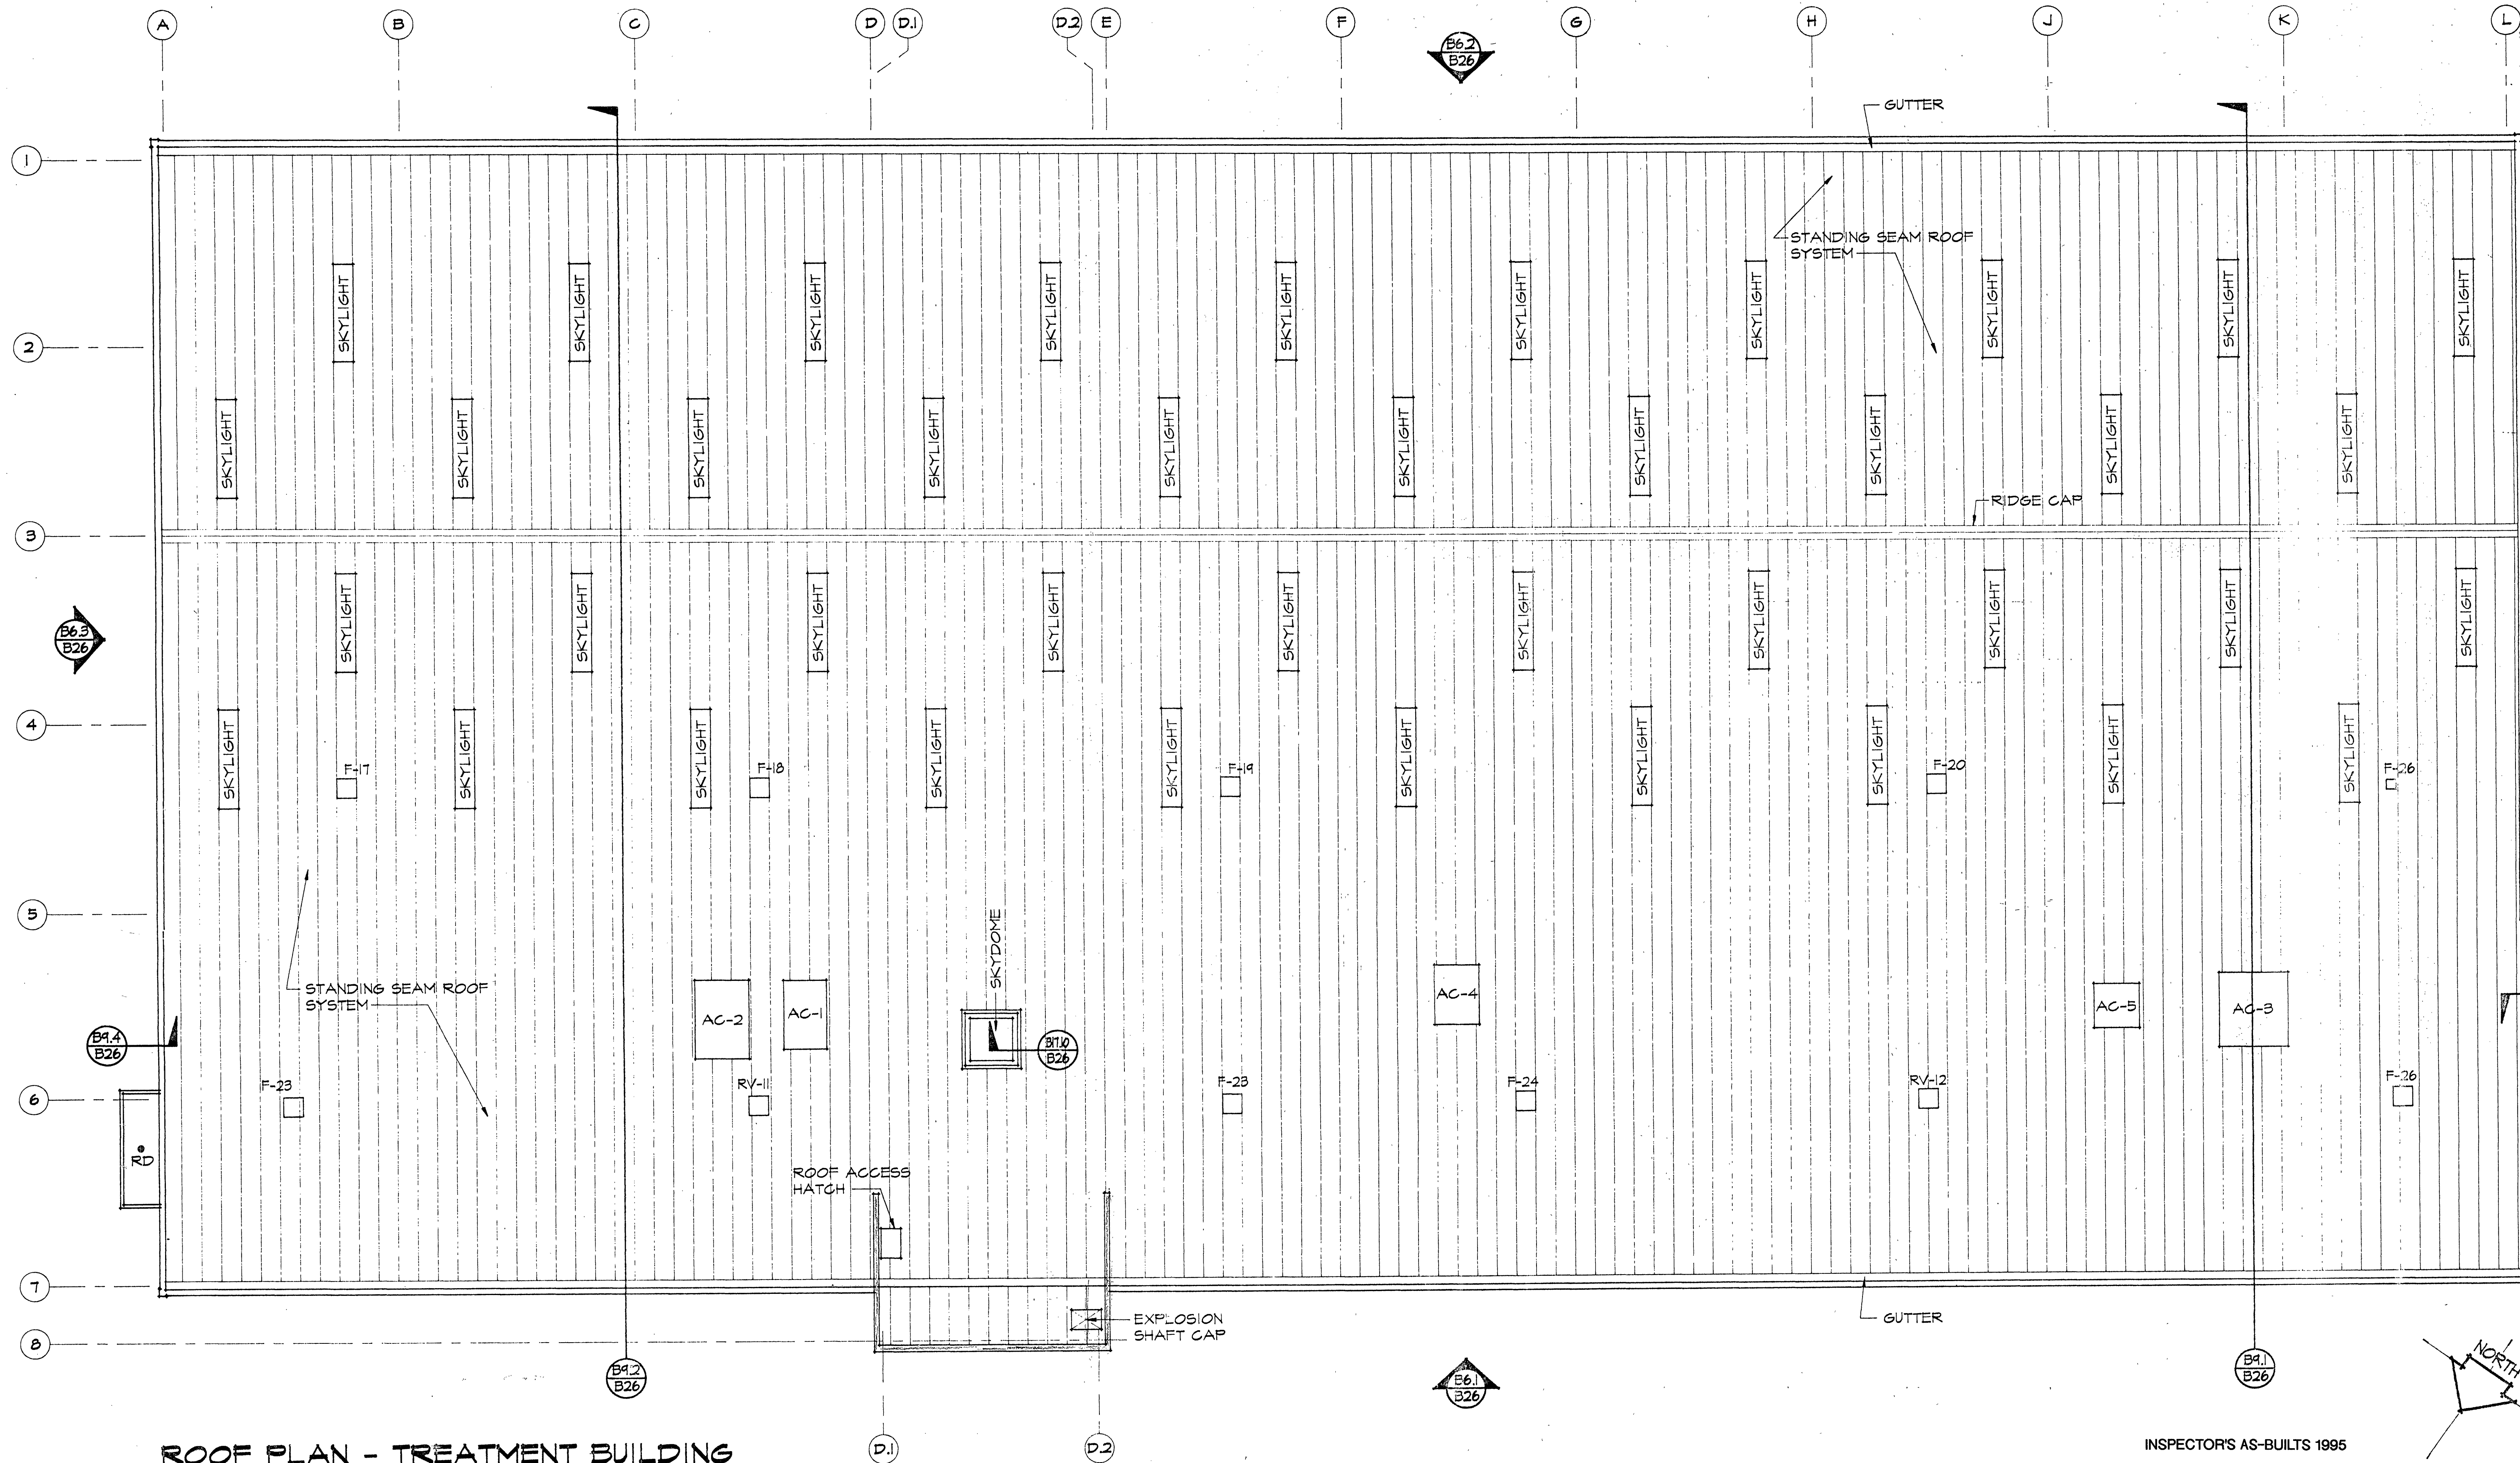


ROOF PLAN - TREATMENT BUILDING
 SCALE 1/8" = 1'-0"

INSPECTOR'S AS-BUILTS 1995

WWW.ID# 6LDLIZ

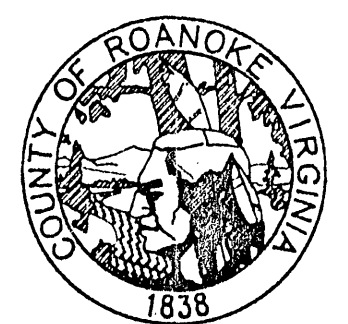

ROANOKE COUNTY WATER TREATMENT FACILITY

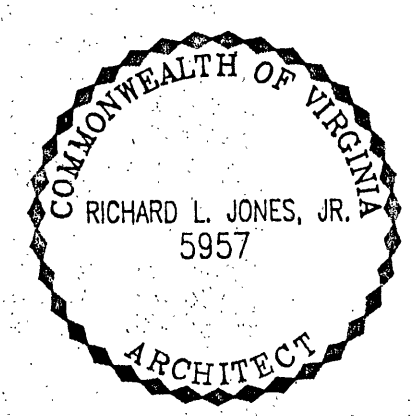

ROOF PLAN - TREATMENT BLDG

PROJECT ARCHITECT
 RLJ JR

COMMISSION NUMBER
 1913

TECHNICIAN
 RAT

DATE
 22 SEPT 1994

B26