




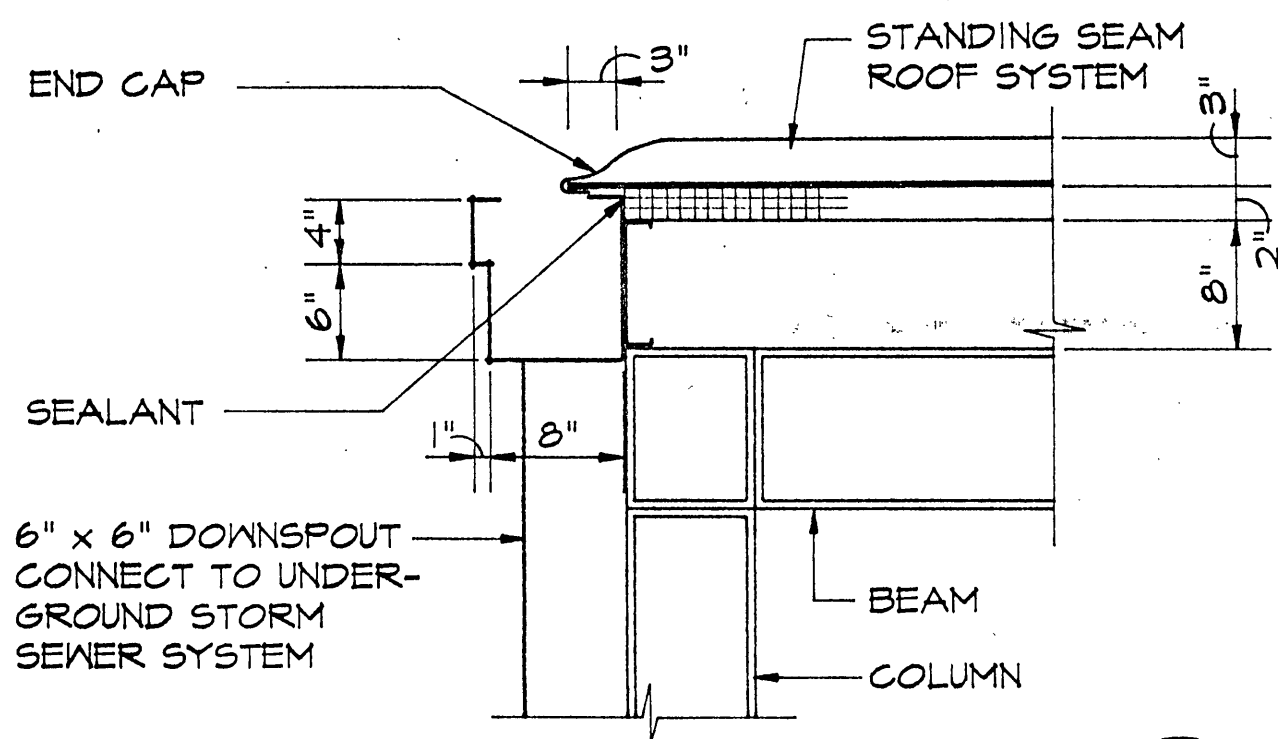


SECTION
SCALE 1" = 1'-0"


B27.1
B27

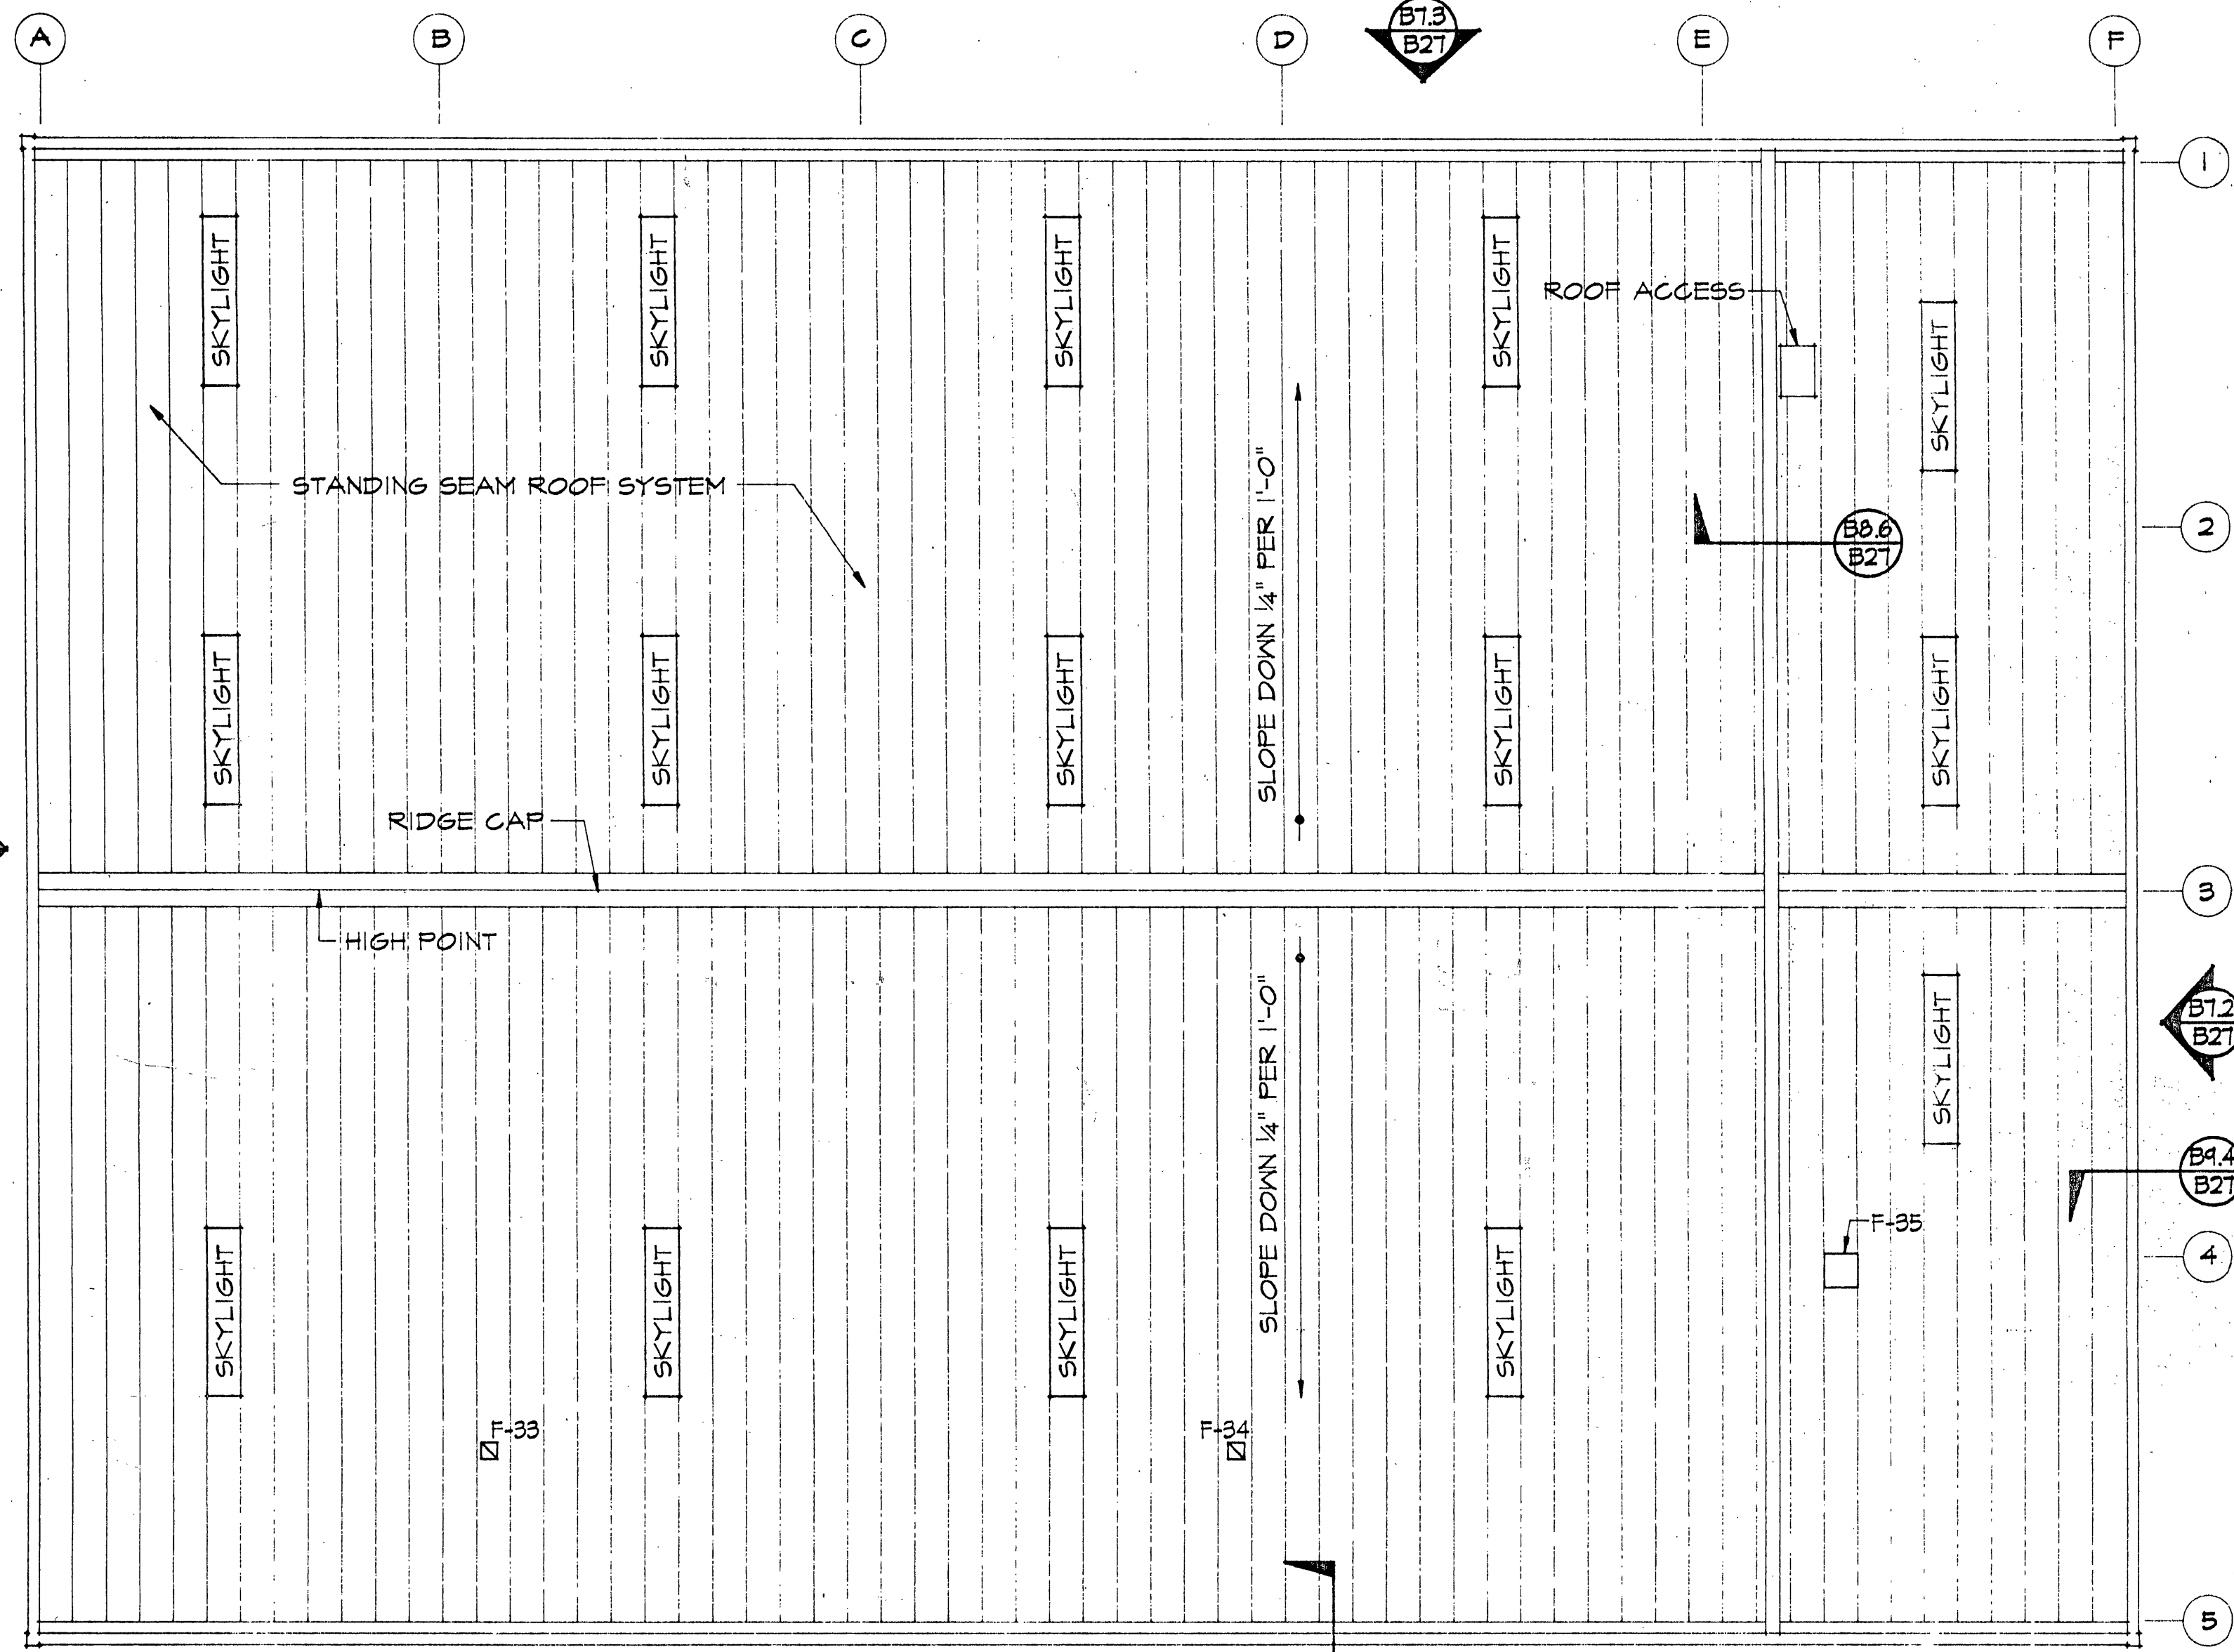

ROOF PLAN - GAC BUILDING
SCALE 1/8" = 1'-0"

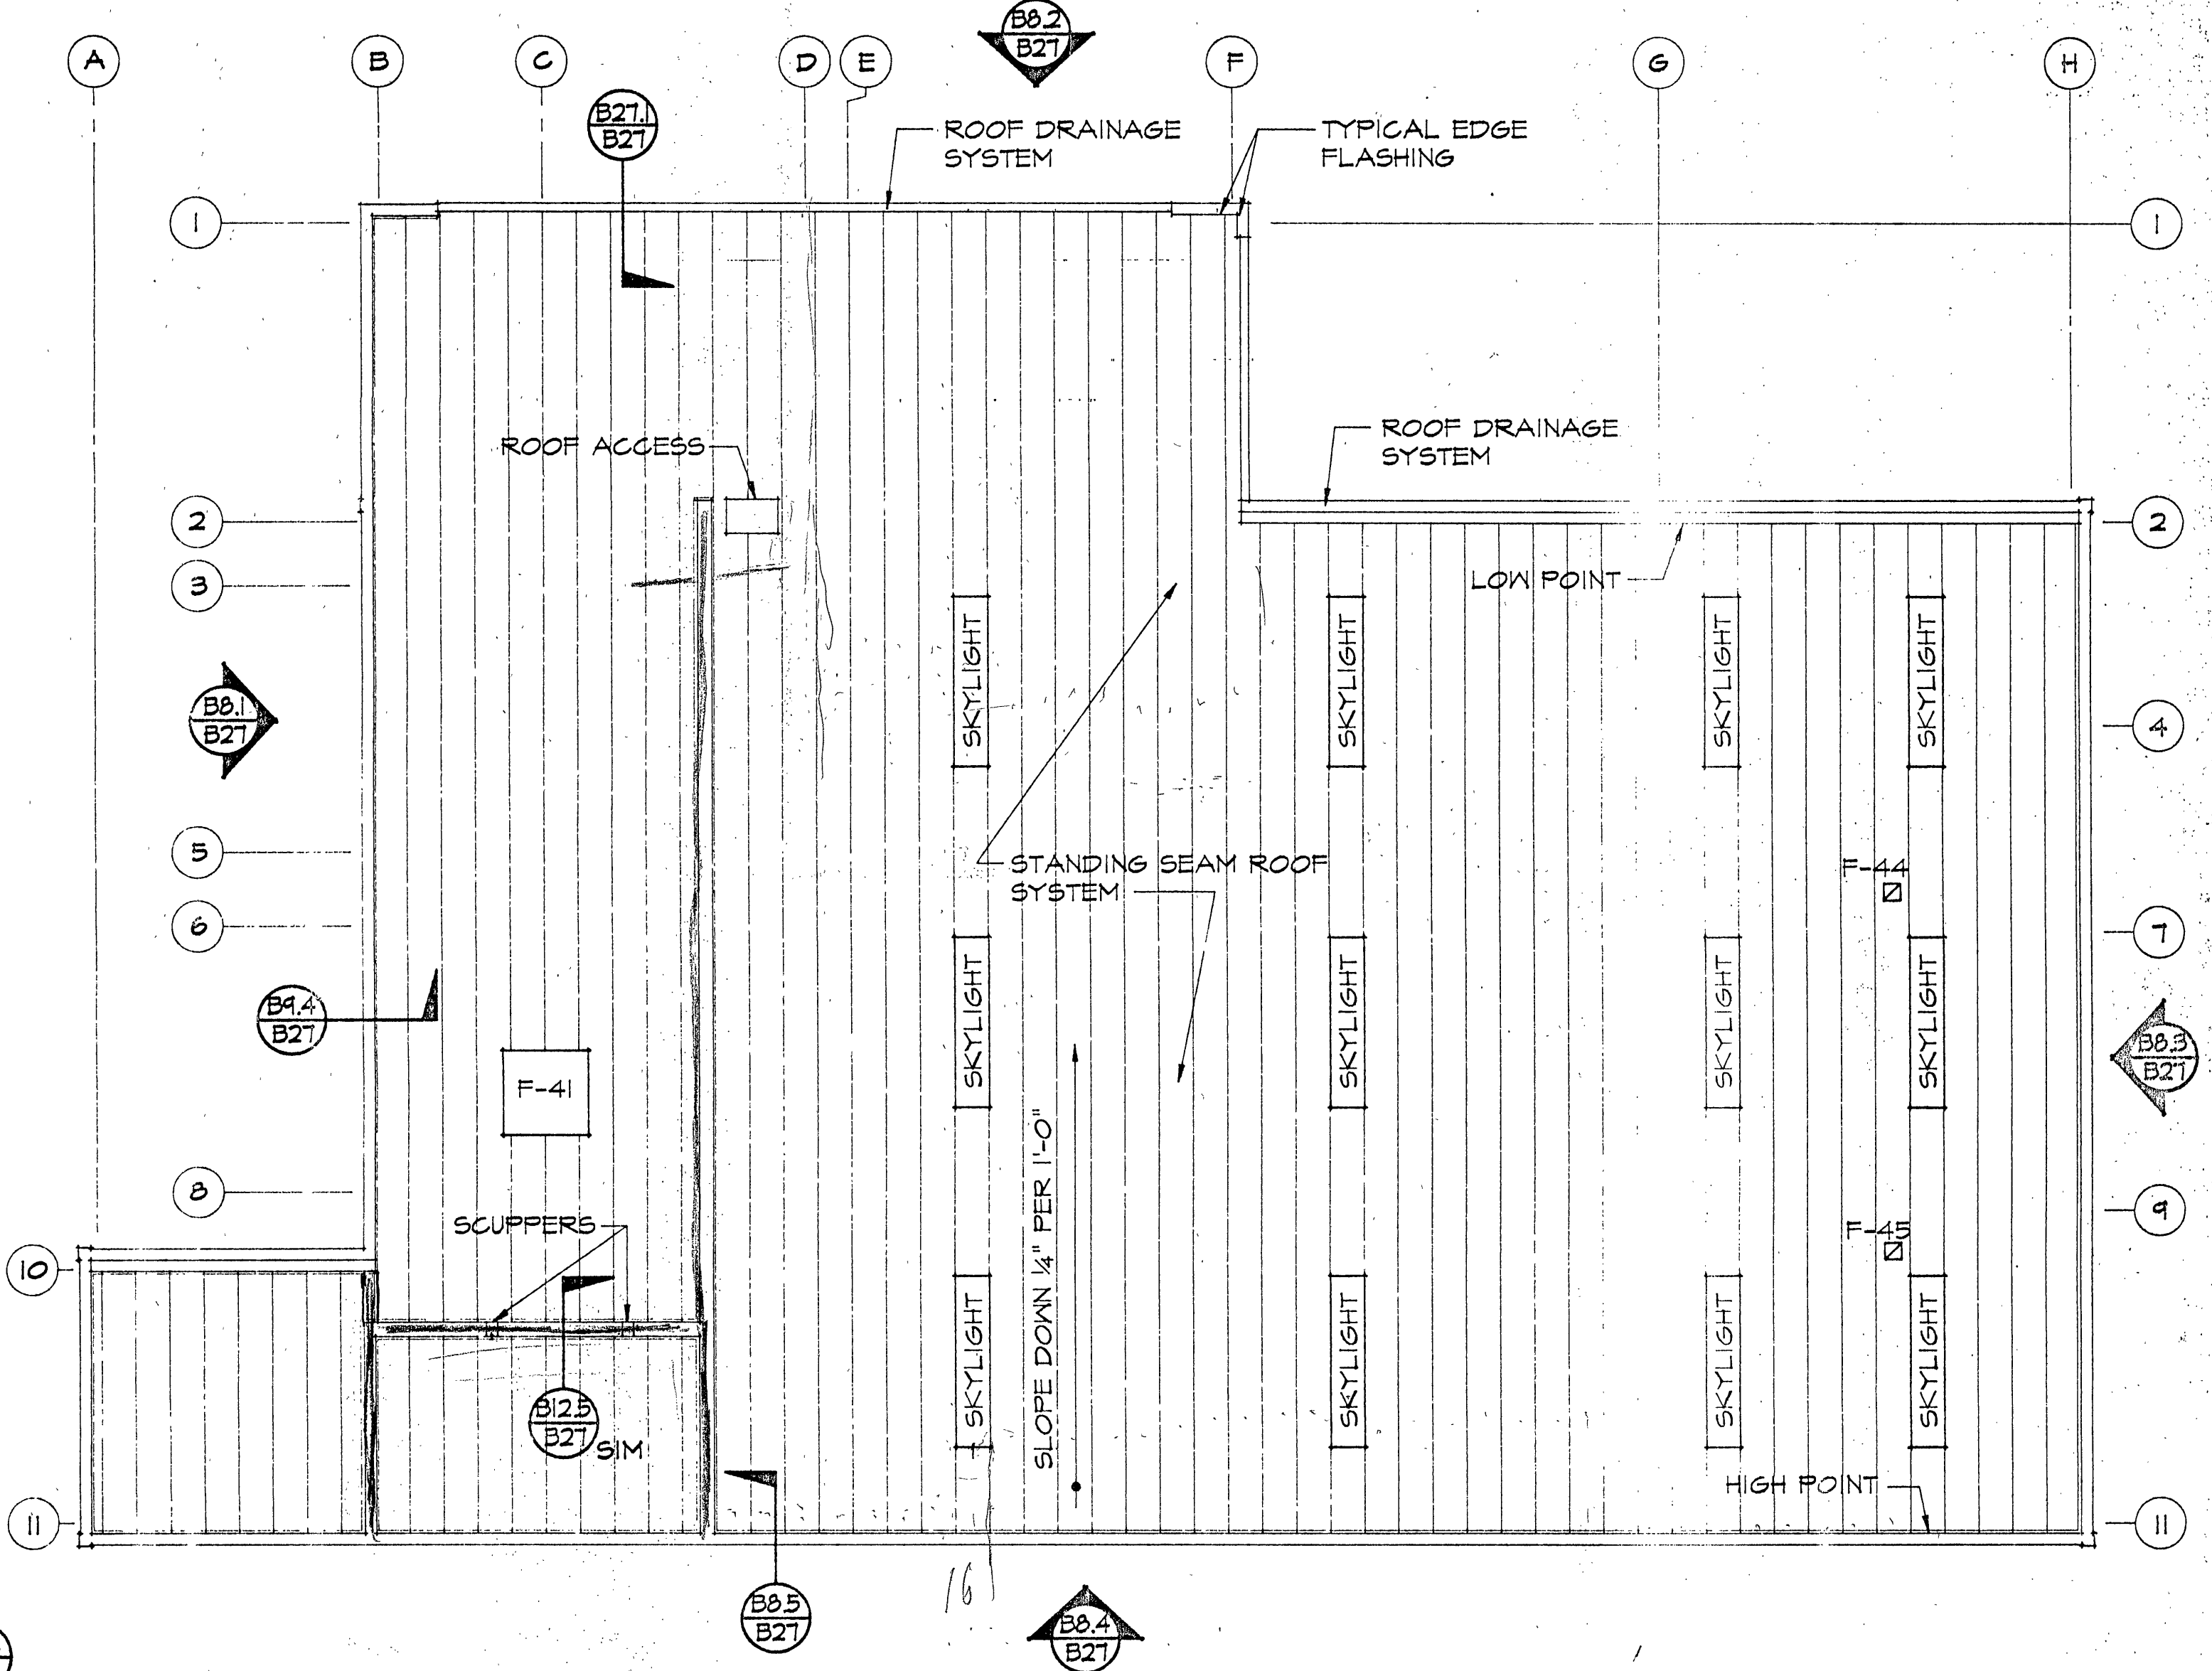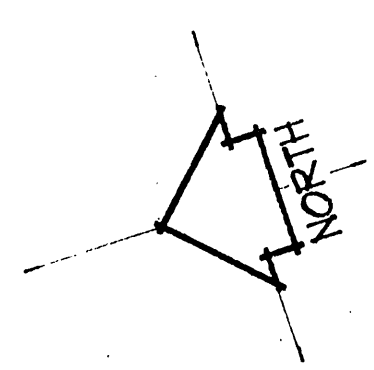


ROOF PLAN - POST TREATMENT BUILDING
SCALE 1/8" = 1'-0"

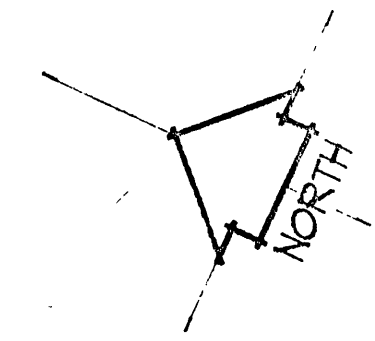


- NOTES**
1. ALL ELEMENTS INDICATED ON THIS SHEET ARE FOR ROOF SYSTEMS ONLY. OTHER BUILDING ELEMENTS SHALL BE AS INDICATED ELSEWHERE
 2. THE CONTRACTOR SHALL CO-ORDINATE THE INSTALLATION OF THE INDICATED SYSTEMS WITH THE OWNER FURNISHED ELEMENTS.

INSPECTOR'S AS-BUILTS 1995

WWW.ID# 8DLUZ

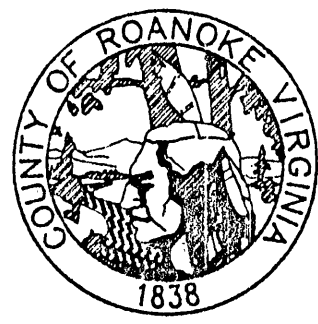

**ROANOKE COUNTY
WATER TREATMENT
FACILITY**

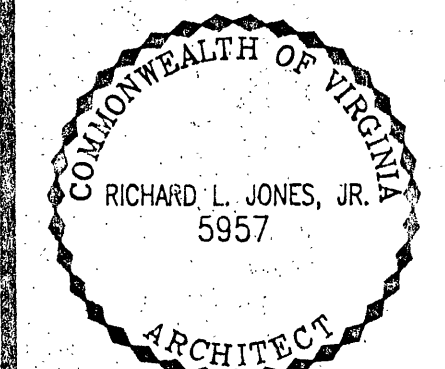

ROOF PLANS

PROJECT ARCHITECT RLJ JR	COMMISSION NUMBER 1913
TECHNICIANS RAT	DATE 22 SEPT 1994

B27

JONES & JONES ASSOCIATES / ARCHITECTS P.C.