




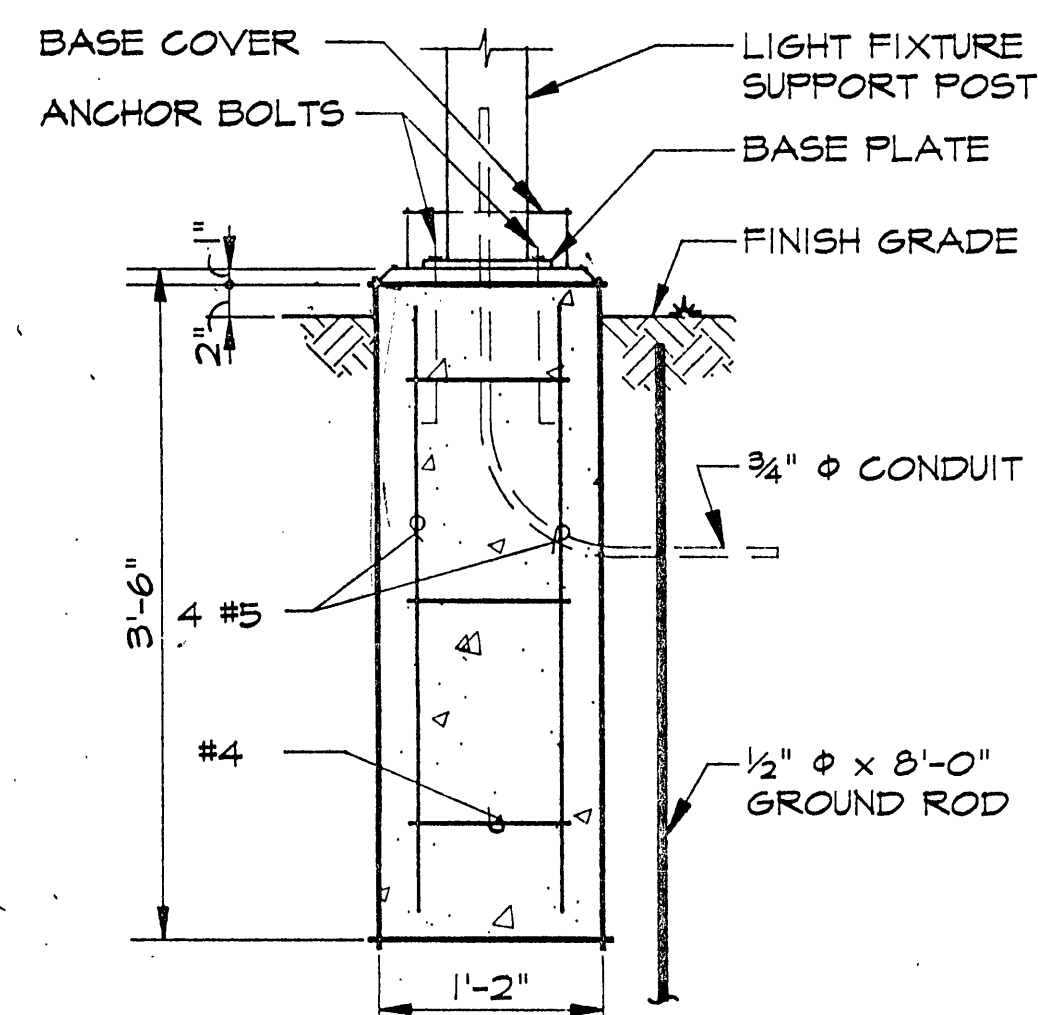


SECTION - LIGHT POLE BASE
SCALE 1" = 1'-0"

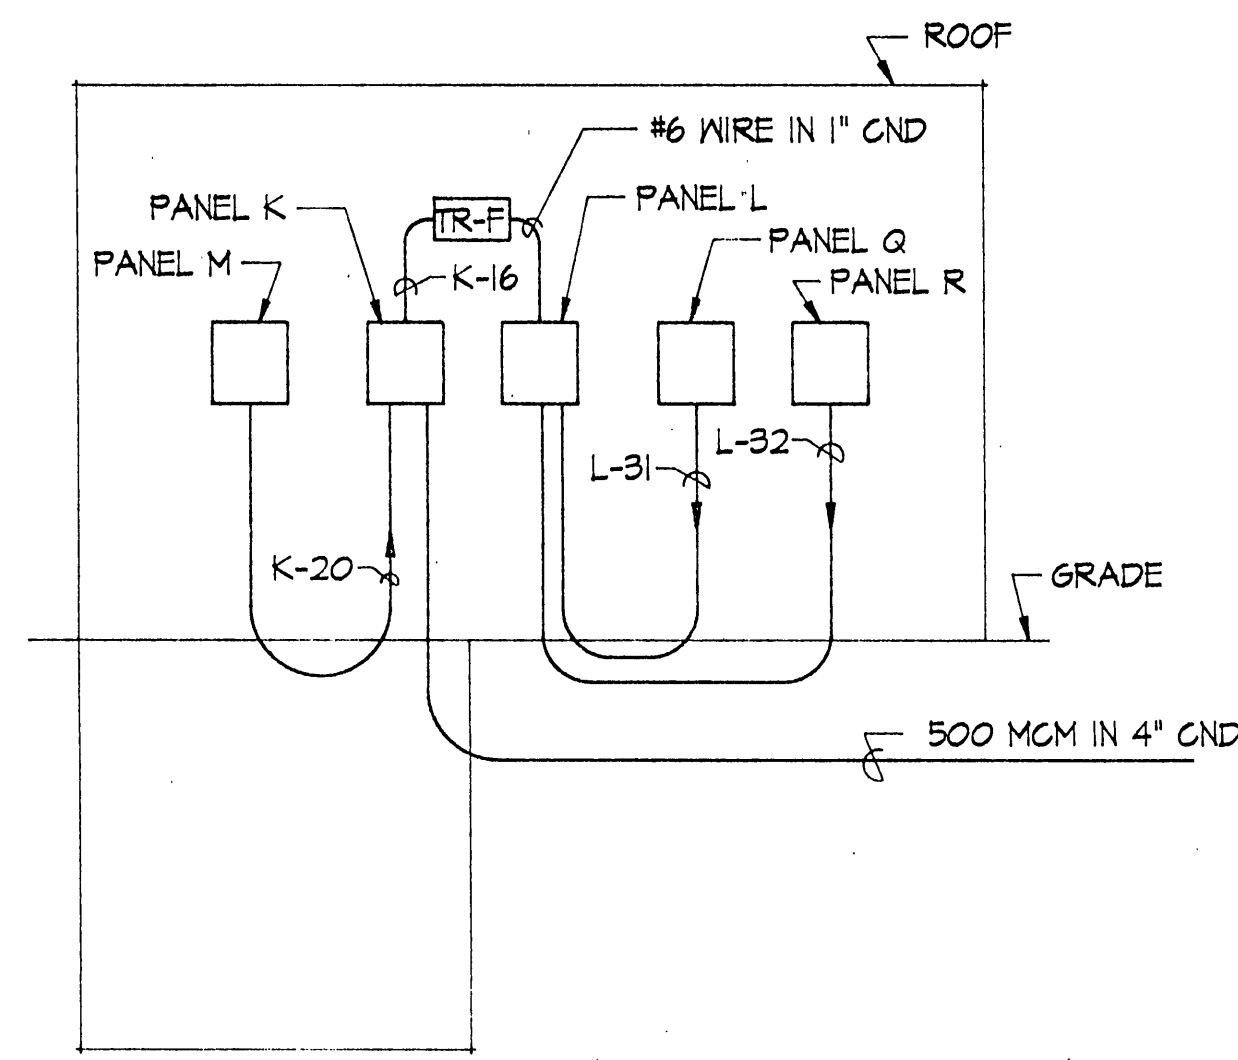

POST TREATMENT BUILDING

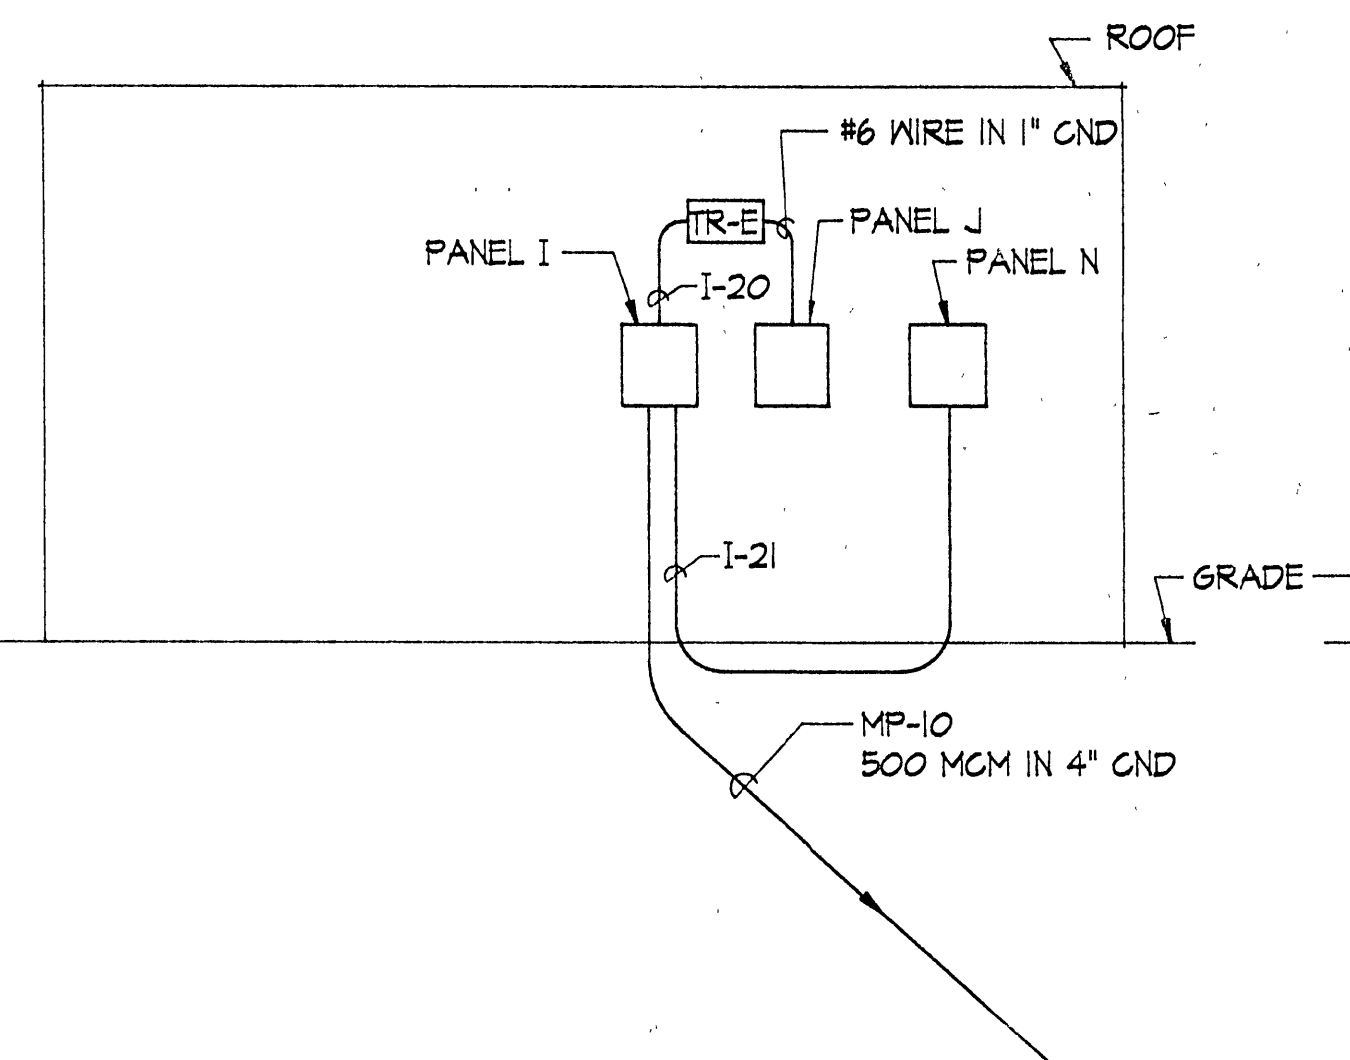


GAC BUILDING

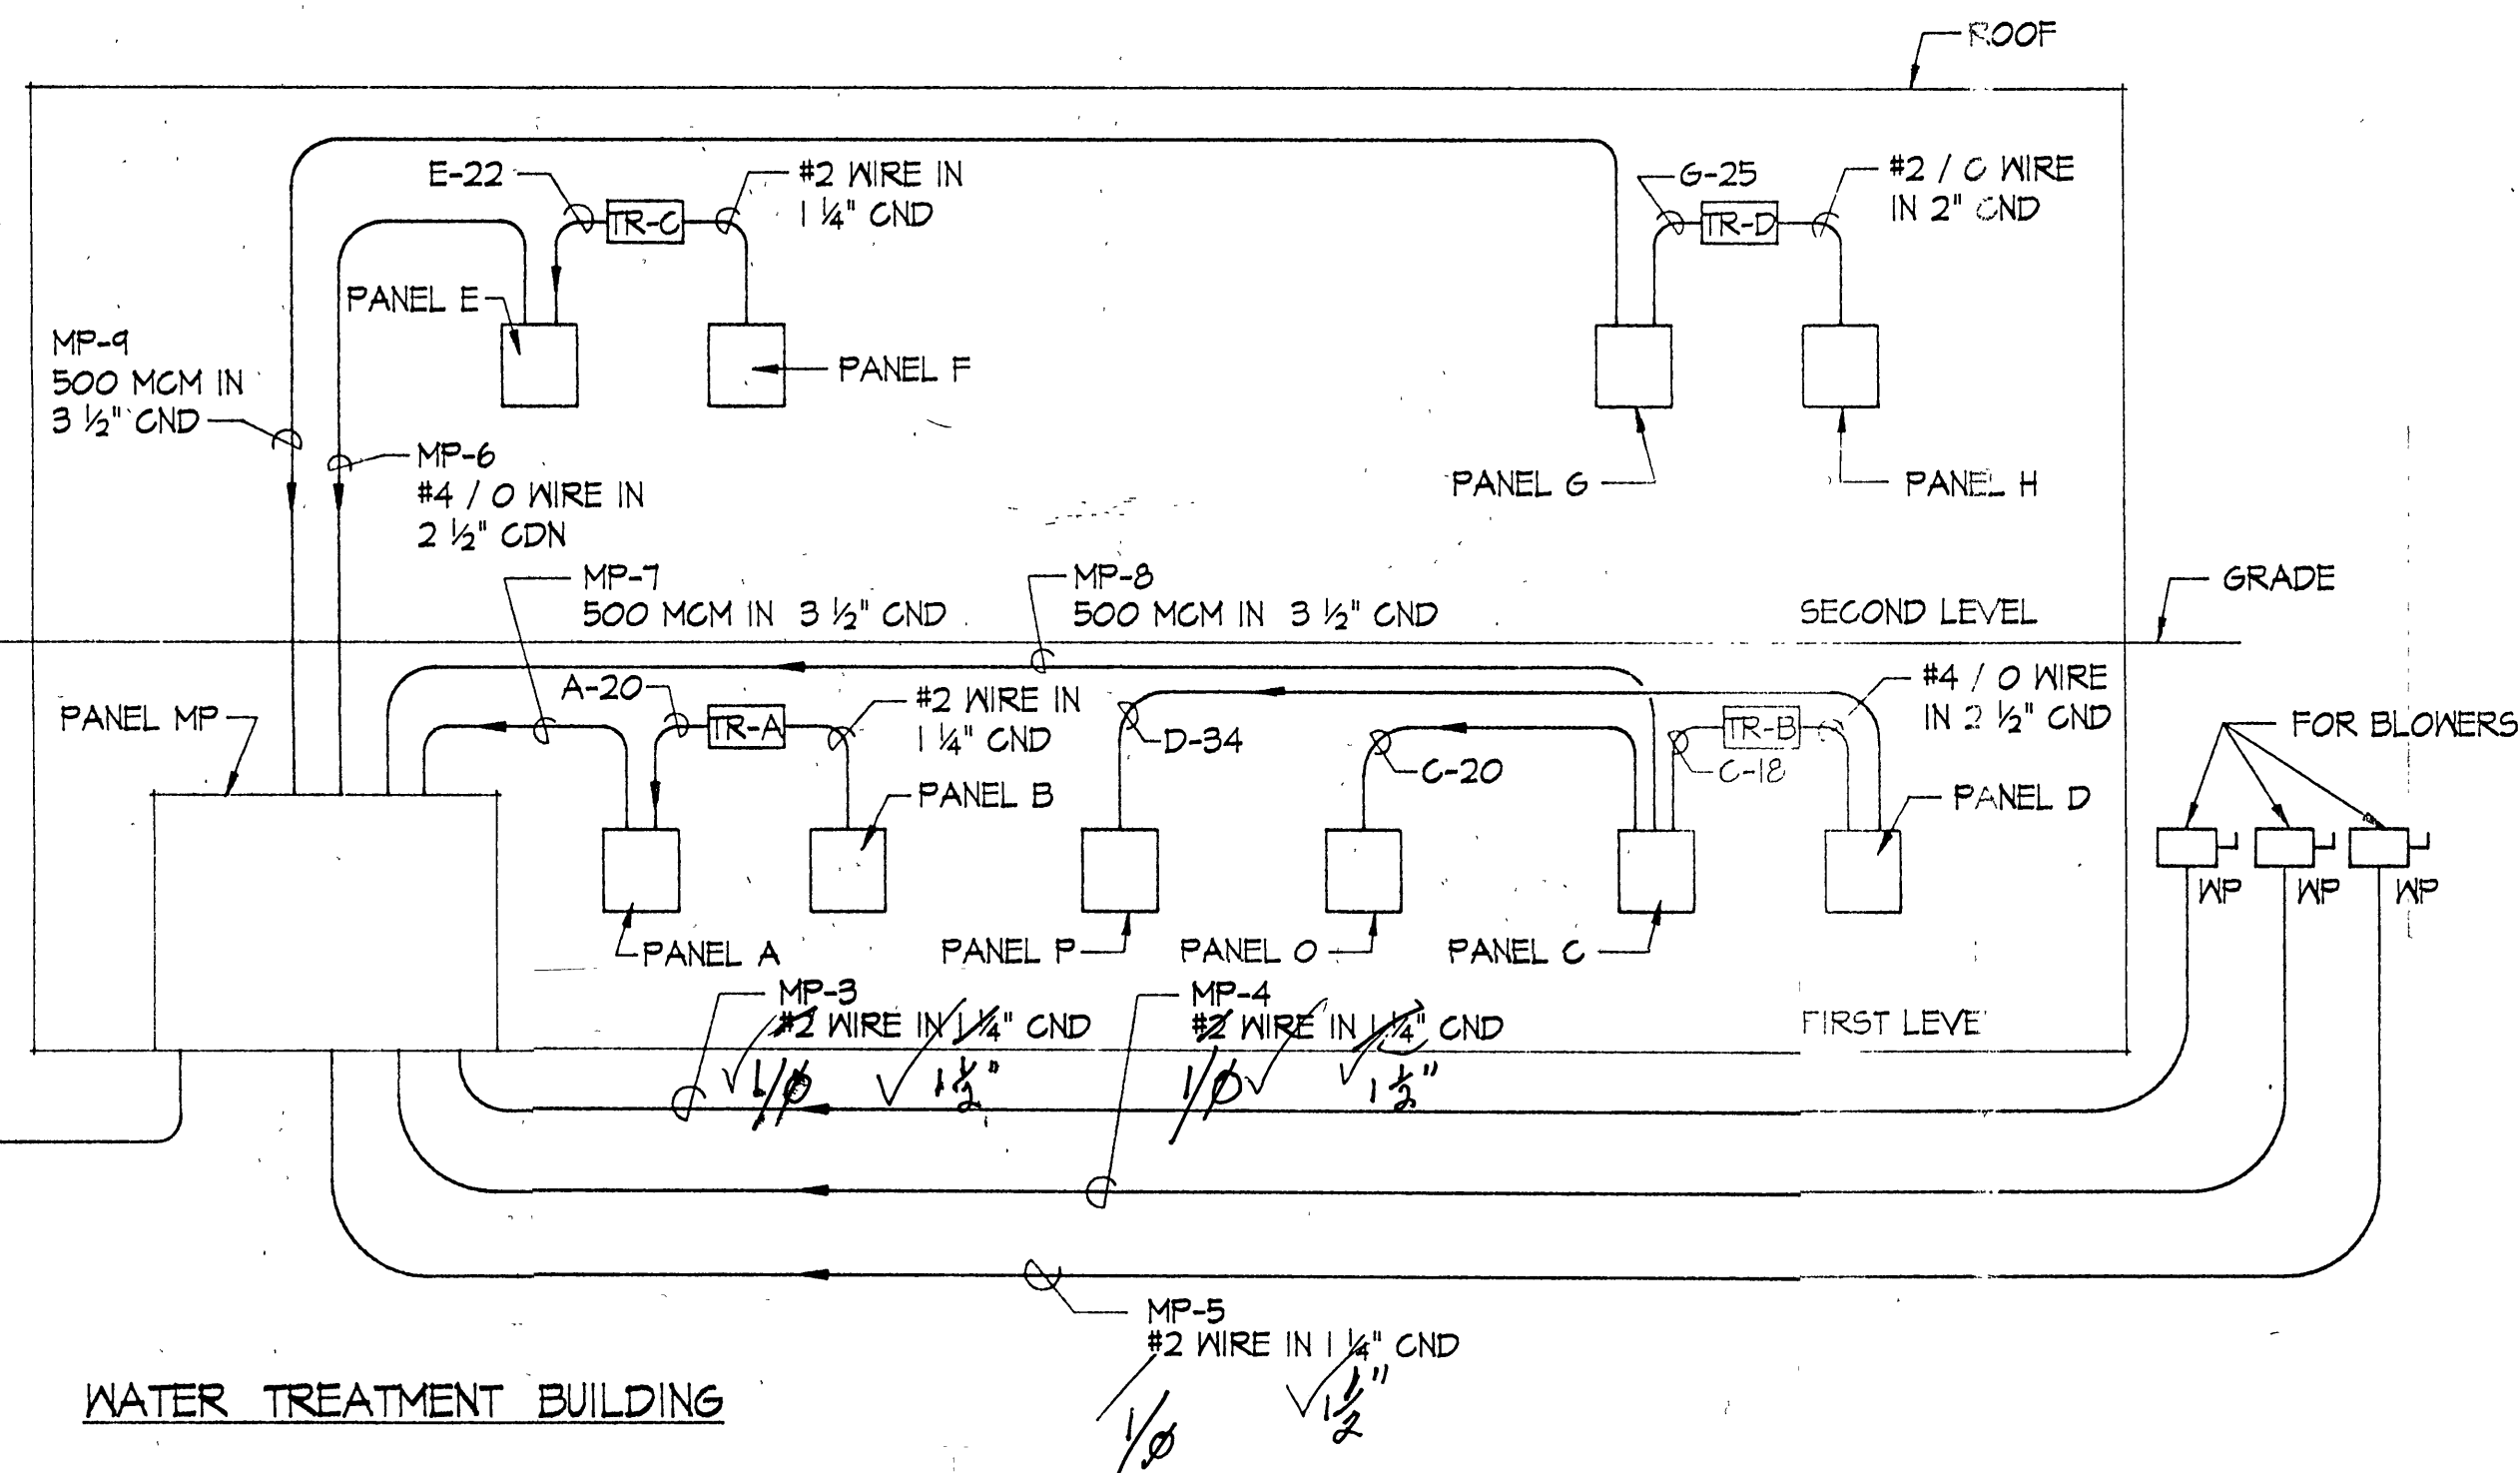

WATER TREATMENT BUILDING


POWER RISER DIAGRAM
NO SCALE

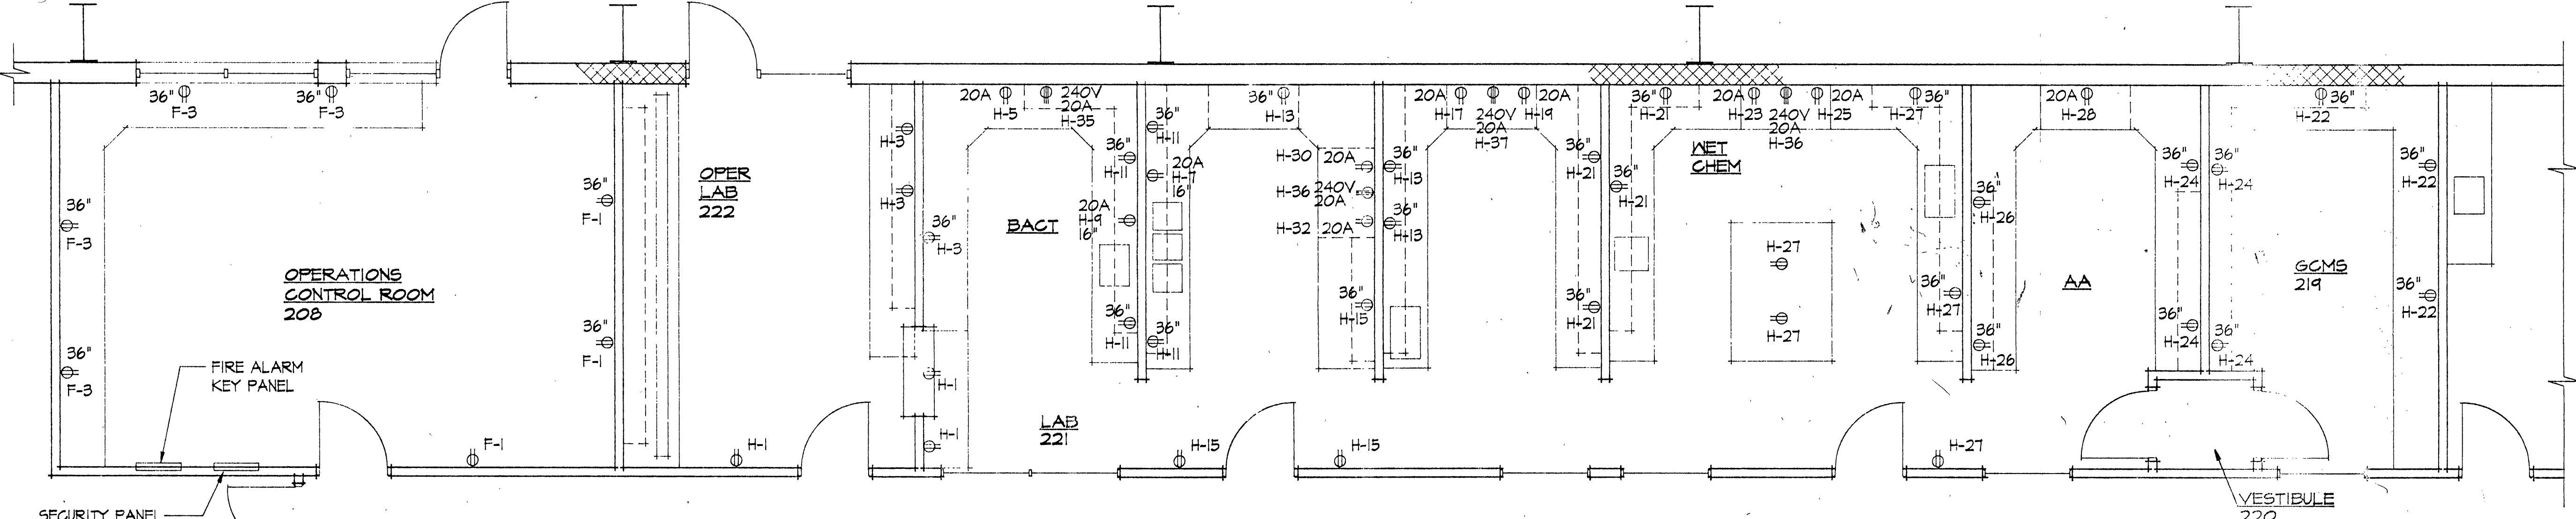


ELECTRICAL DIAGRAM OF LABS - TREATMENT BUILDING
SCALE 1/4" = 1'-0"

INSPECTOR'S AS-BUILTS 1995

WWW ID# 8DLU2

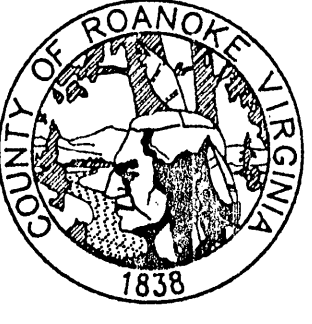

**ROANOKE COUNTY
WATER TREATMENT
FACILITY**

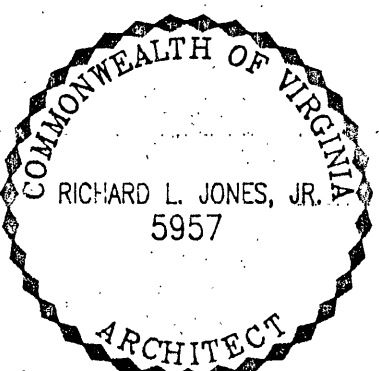

FLOOR PLAN OF LABS

PROJECT ARCHITECT
RLJ JR

COMMISSION NUMBER
1913

TECHNICIANS
RWT

DATE
22 SEPT 1994

E4

JONES & JONES ASSOCIATES / ARCHITECTS, PC