



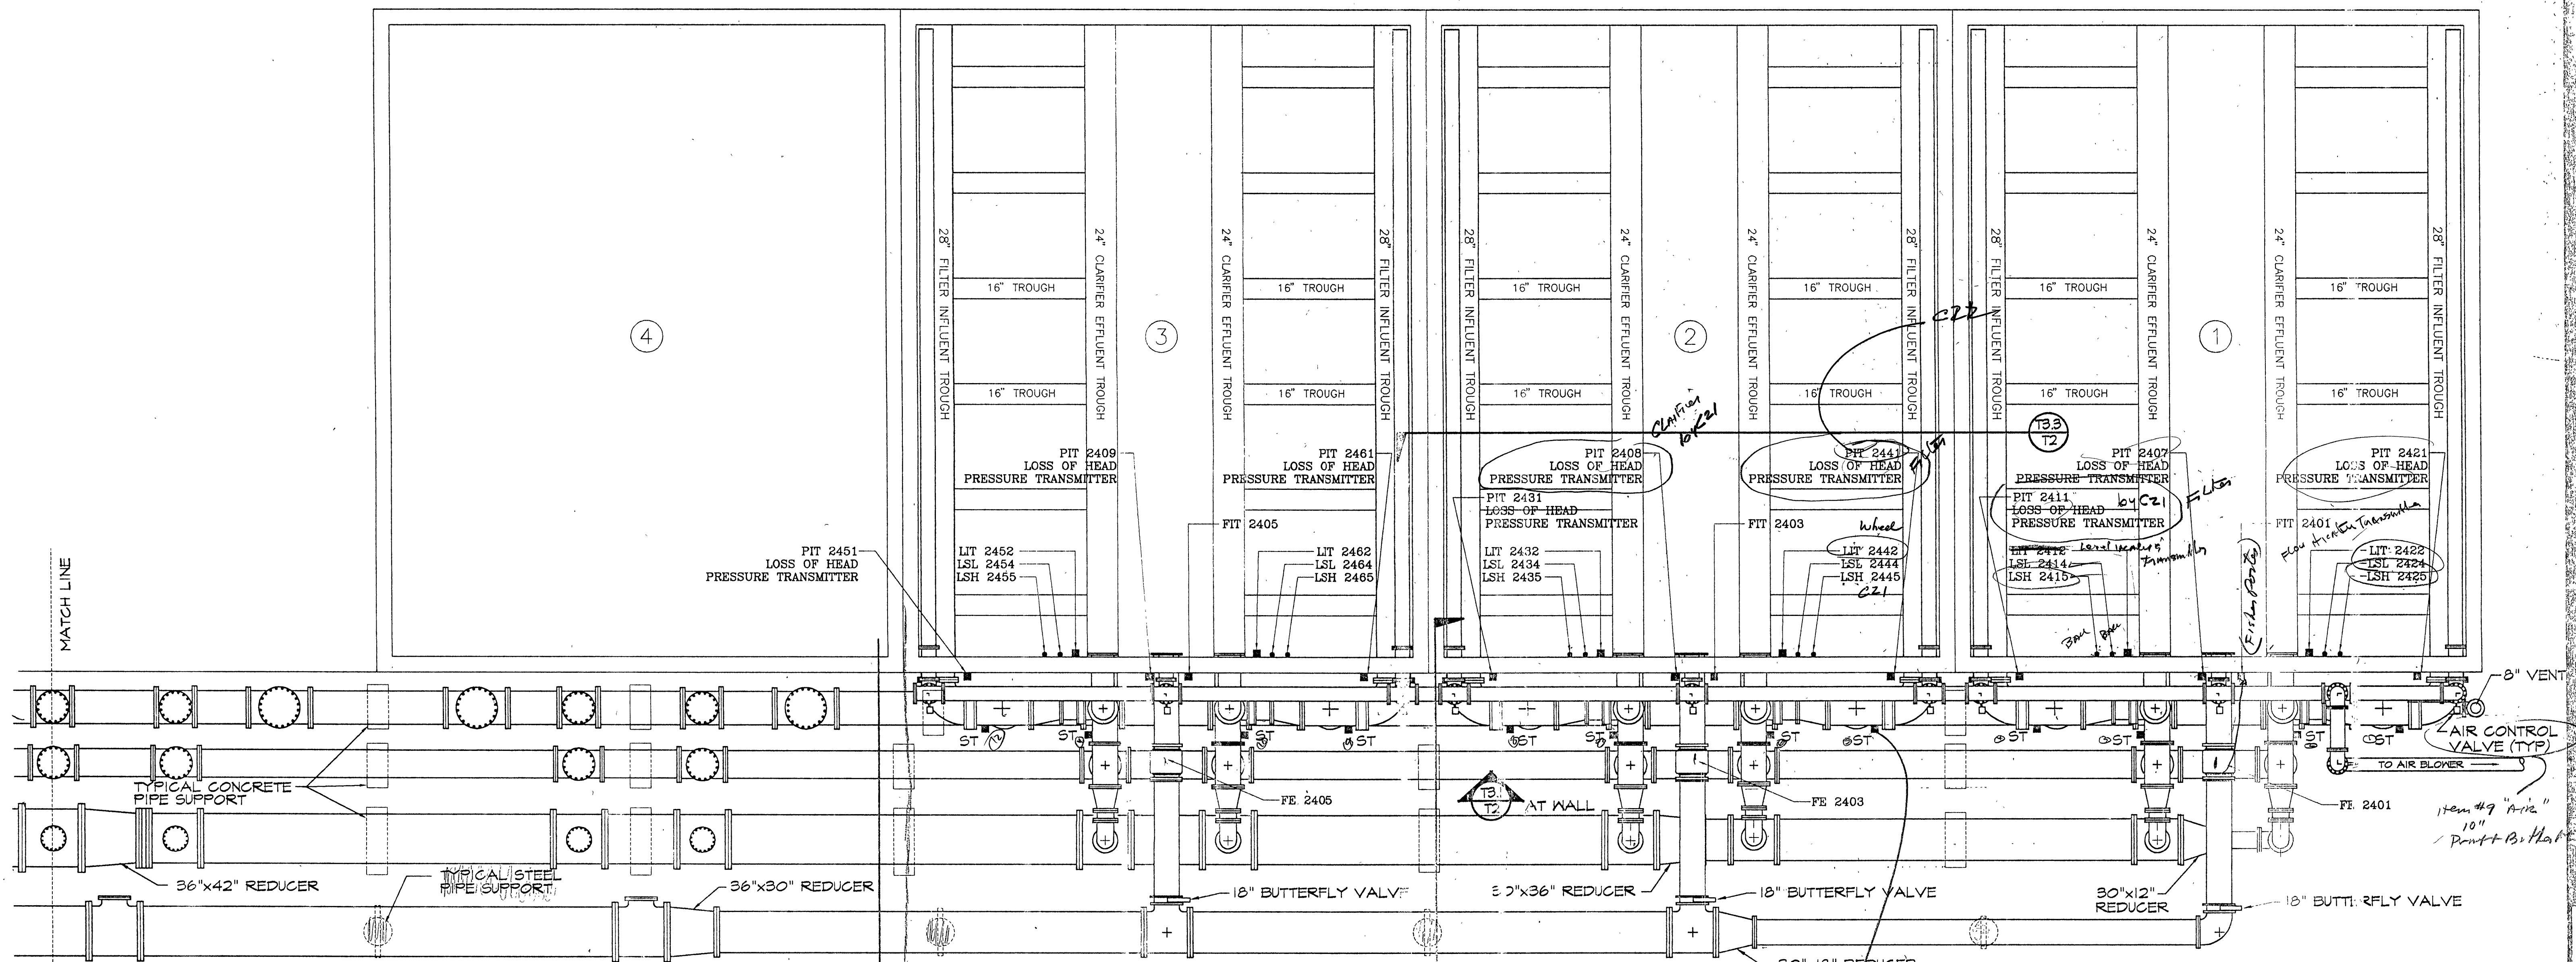

15 MG PIPING PLAN
SCALE 1" = 5'-0"

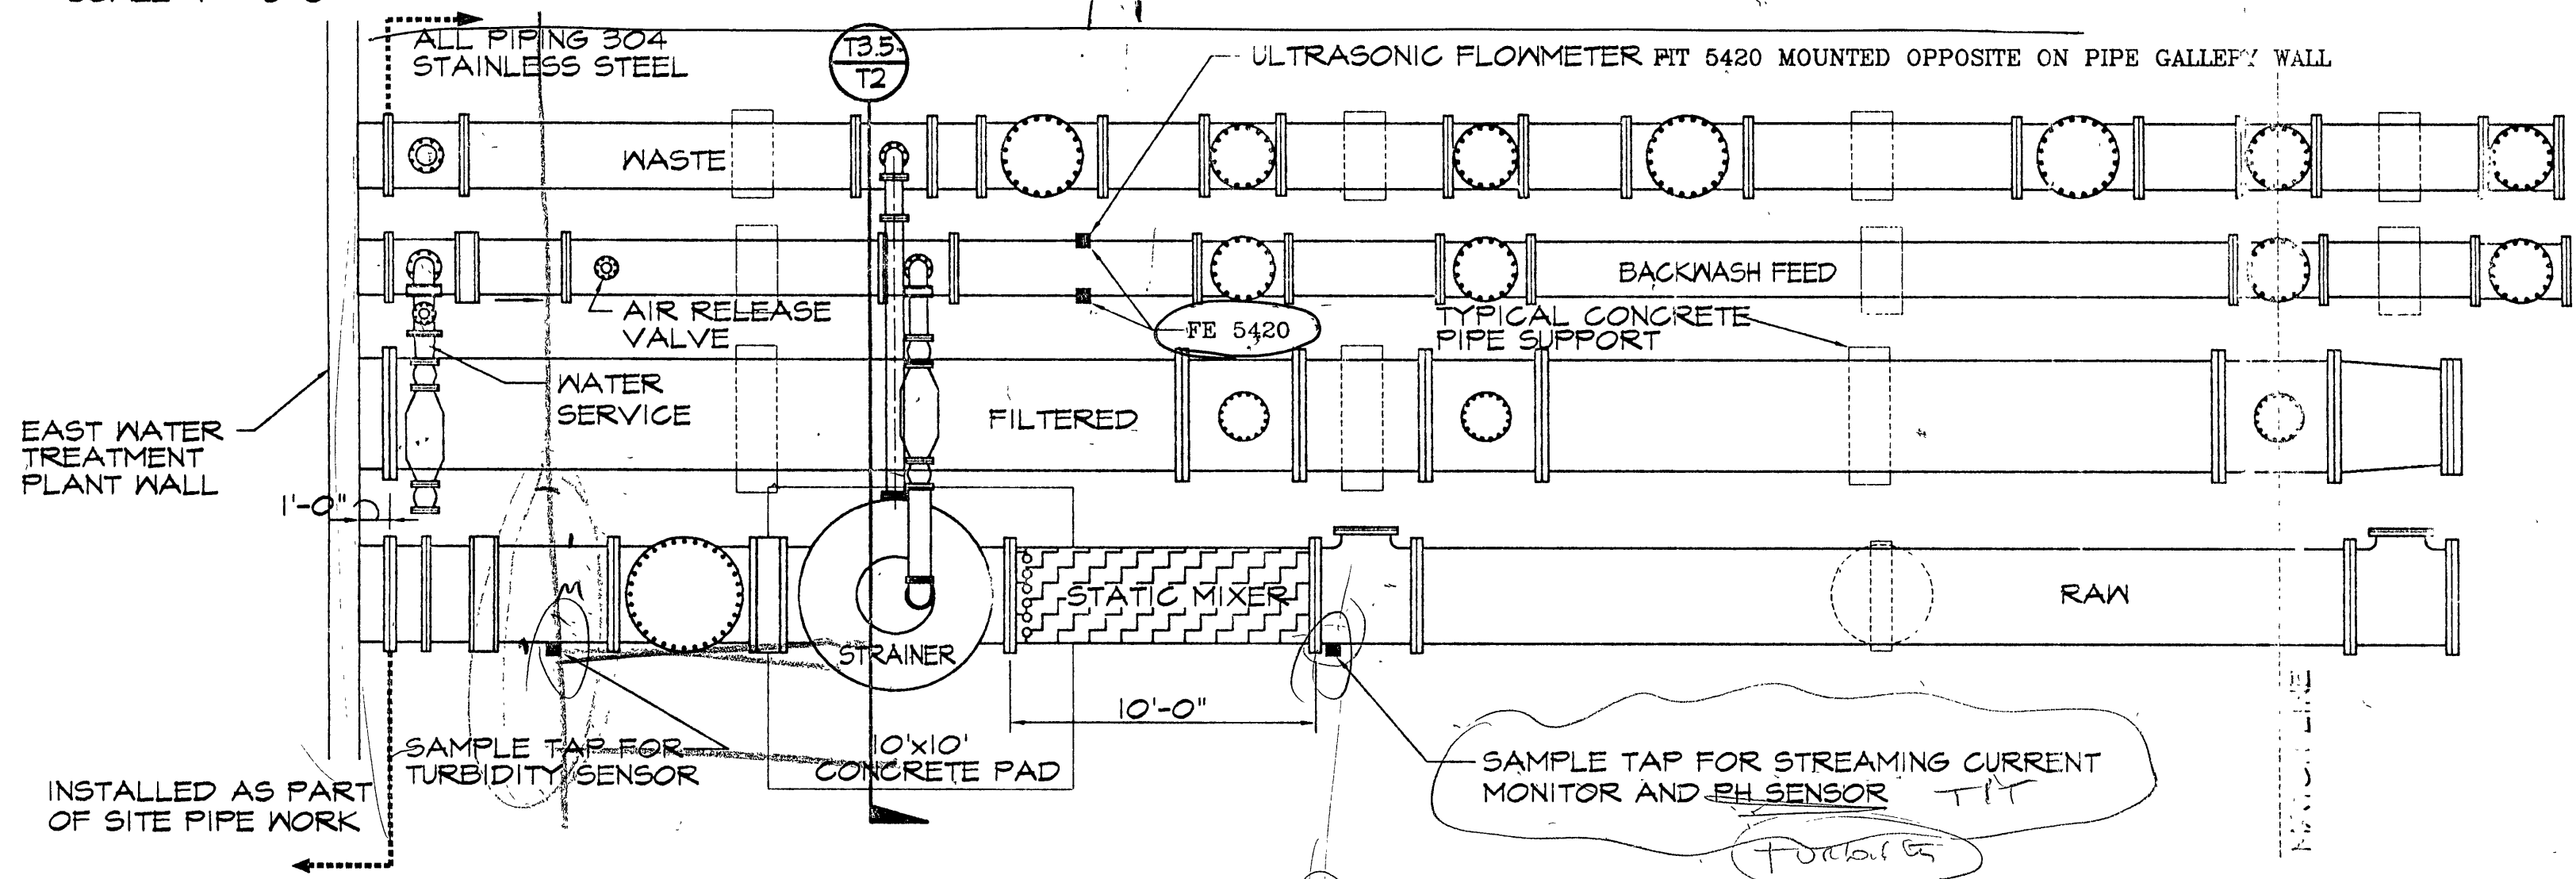


15 MG PIPING PLAN
SCALE 1" = 5'-0"



- NOTES**
1. ALL PIPING AND FITTINGS INSTALLED IN THE PIPE GALLERY SHALL BE 304 STAINLESS STEEL
 2. SEE SHEETS T5 THROUGH T11 FOR SEPARATE PIPING DETAILS
 3. ALL TREATMENT BASIN EQUIPMENT AND MATERIALS TO BE SUPPLIED BY OTHERS
 4. SEE WHEELABRATOR PROPOSAL IN SPECS FOR INTERIOR BASIN ARRANGEMENT
 5. ST INDICATES SAMPLE TAP FOR TURBIDITY SENSOR

INSPECTOR'S AS-BUILTS 1995

WWW.ID# 8LDLIZ

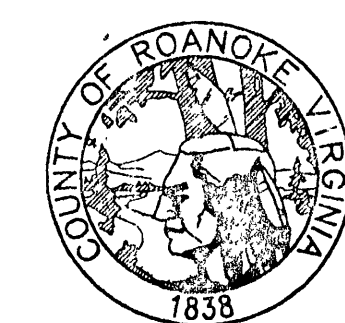

ROANOKE COUNTY WATER TREATMENT FACILITY

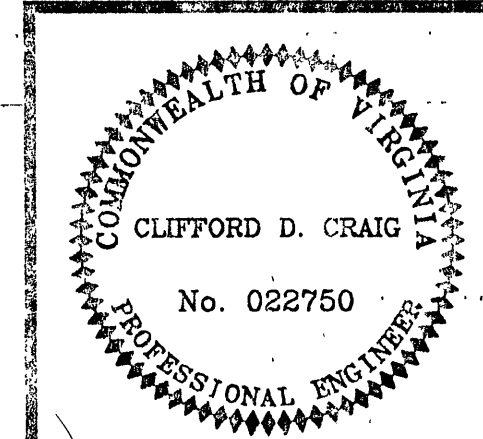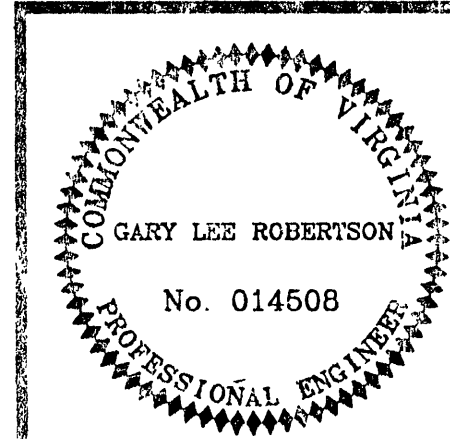

TREATMENT BUILDING TREATMENT SYSTEM PLAN	
DESIGN ENGINEER CLIFFORD D. CRAIG	COMMISSION NUMBER 1913
RCUD NUMBER WTF-1	DATE 9 SEPT. 1994

T2