




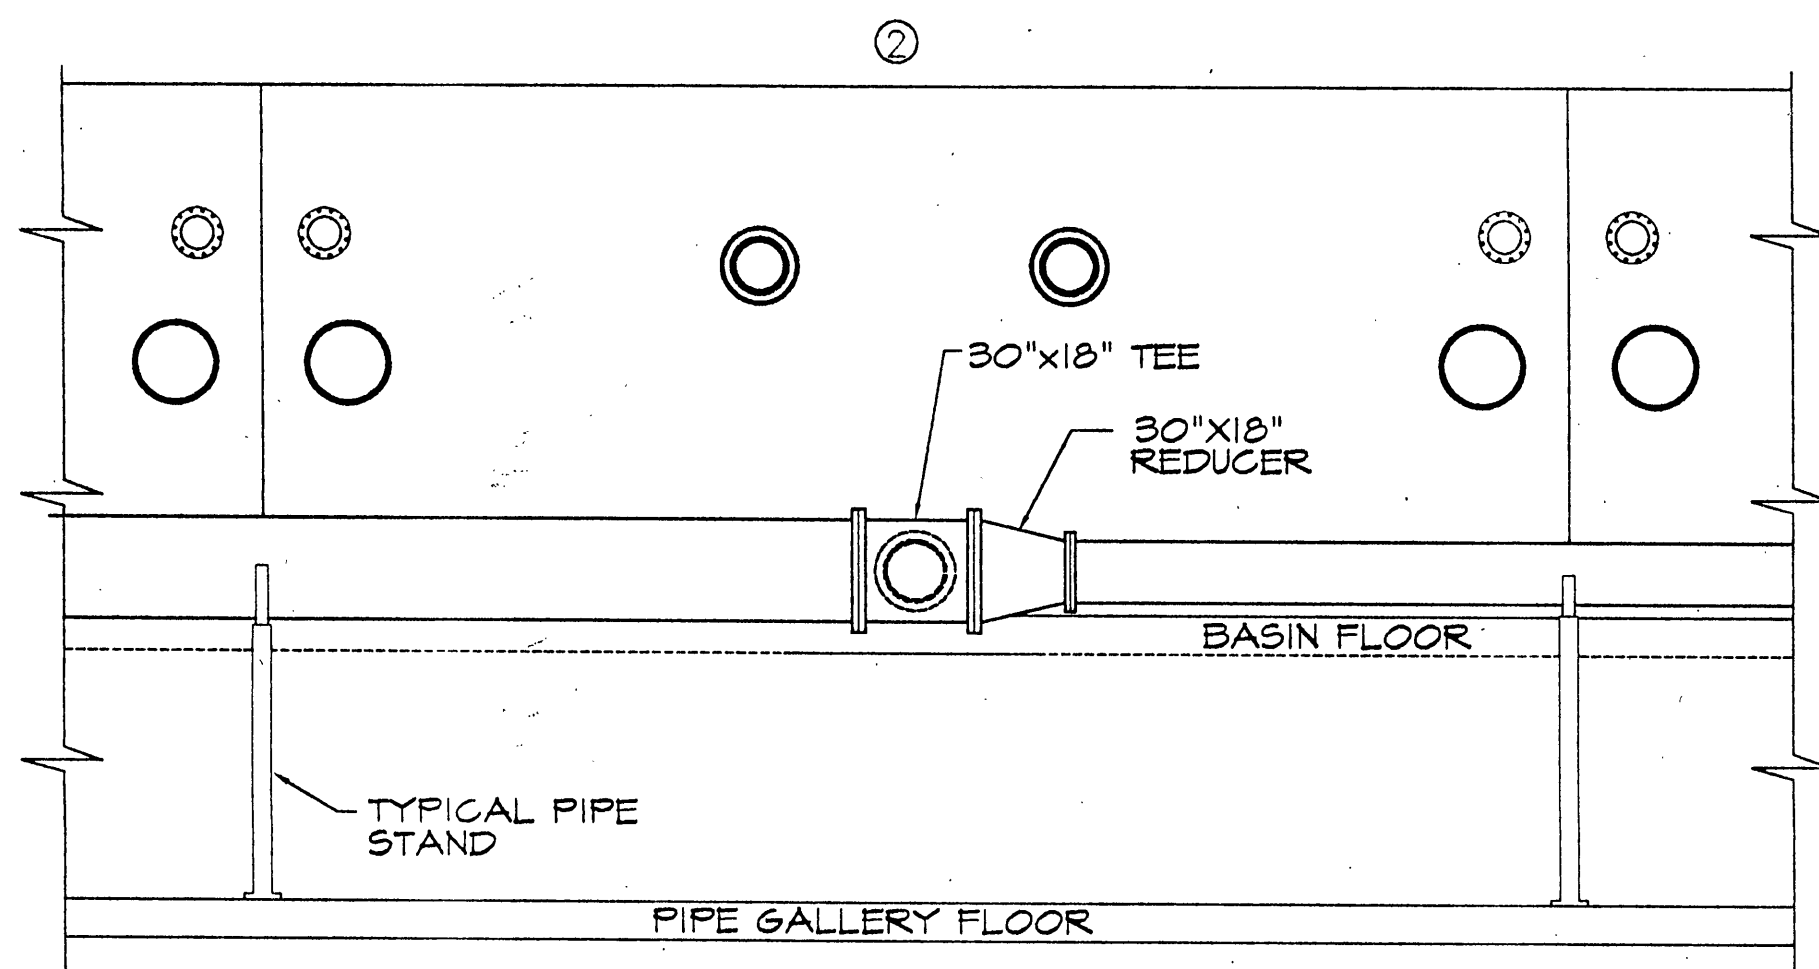


BASIN #2 - RAW WATER PIPING ELEVATION (T4.1)
SCALE 1" = 5'-0"

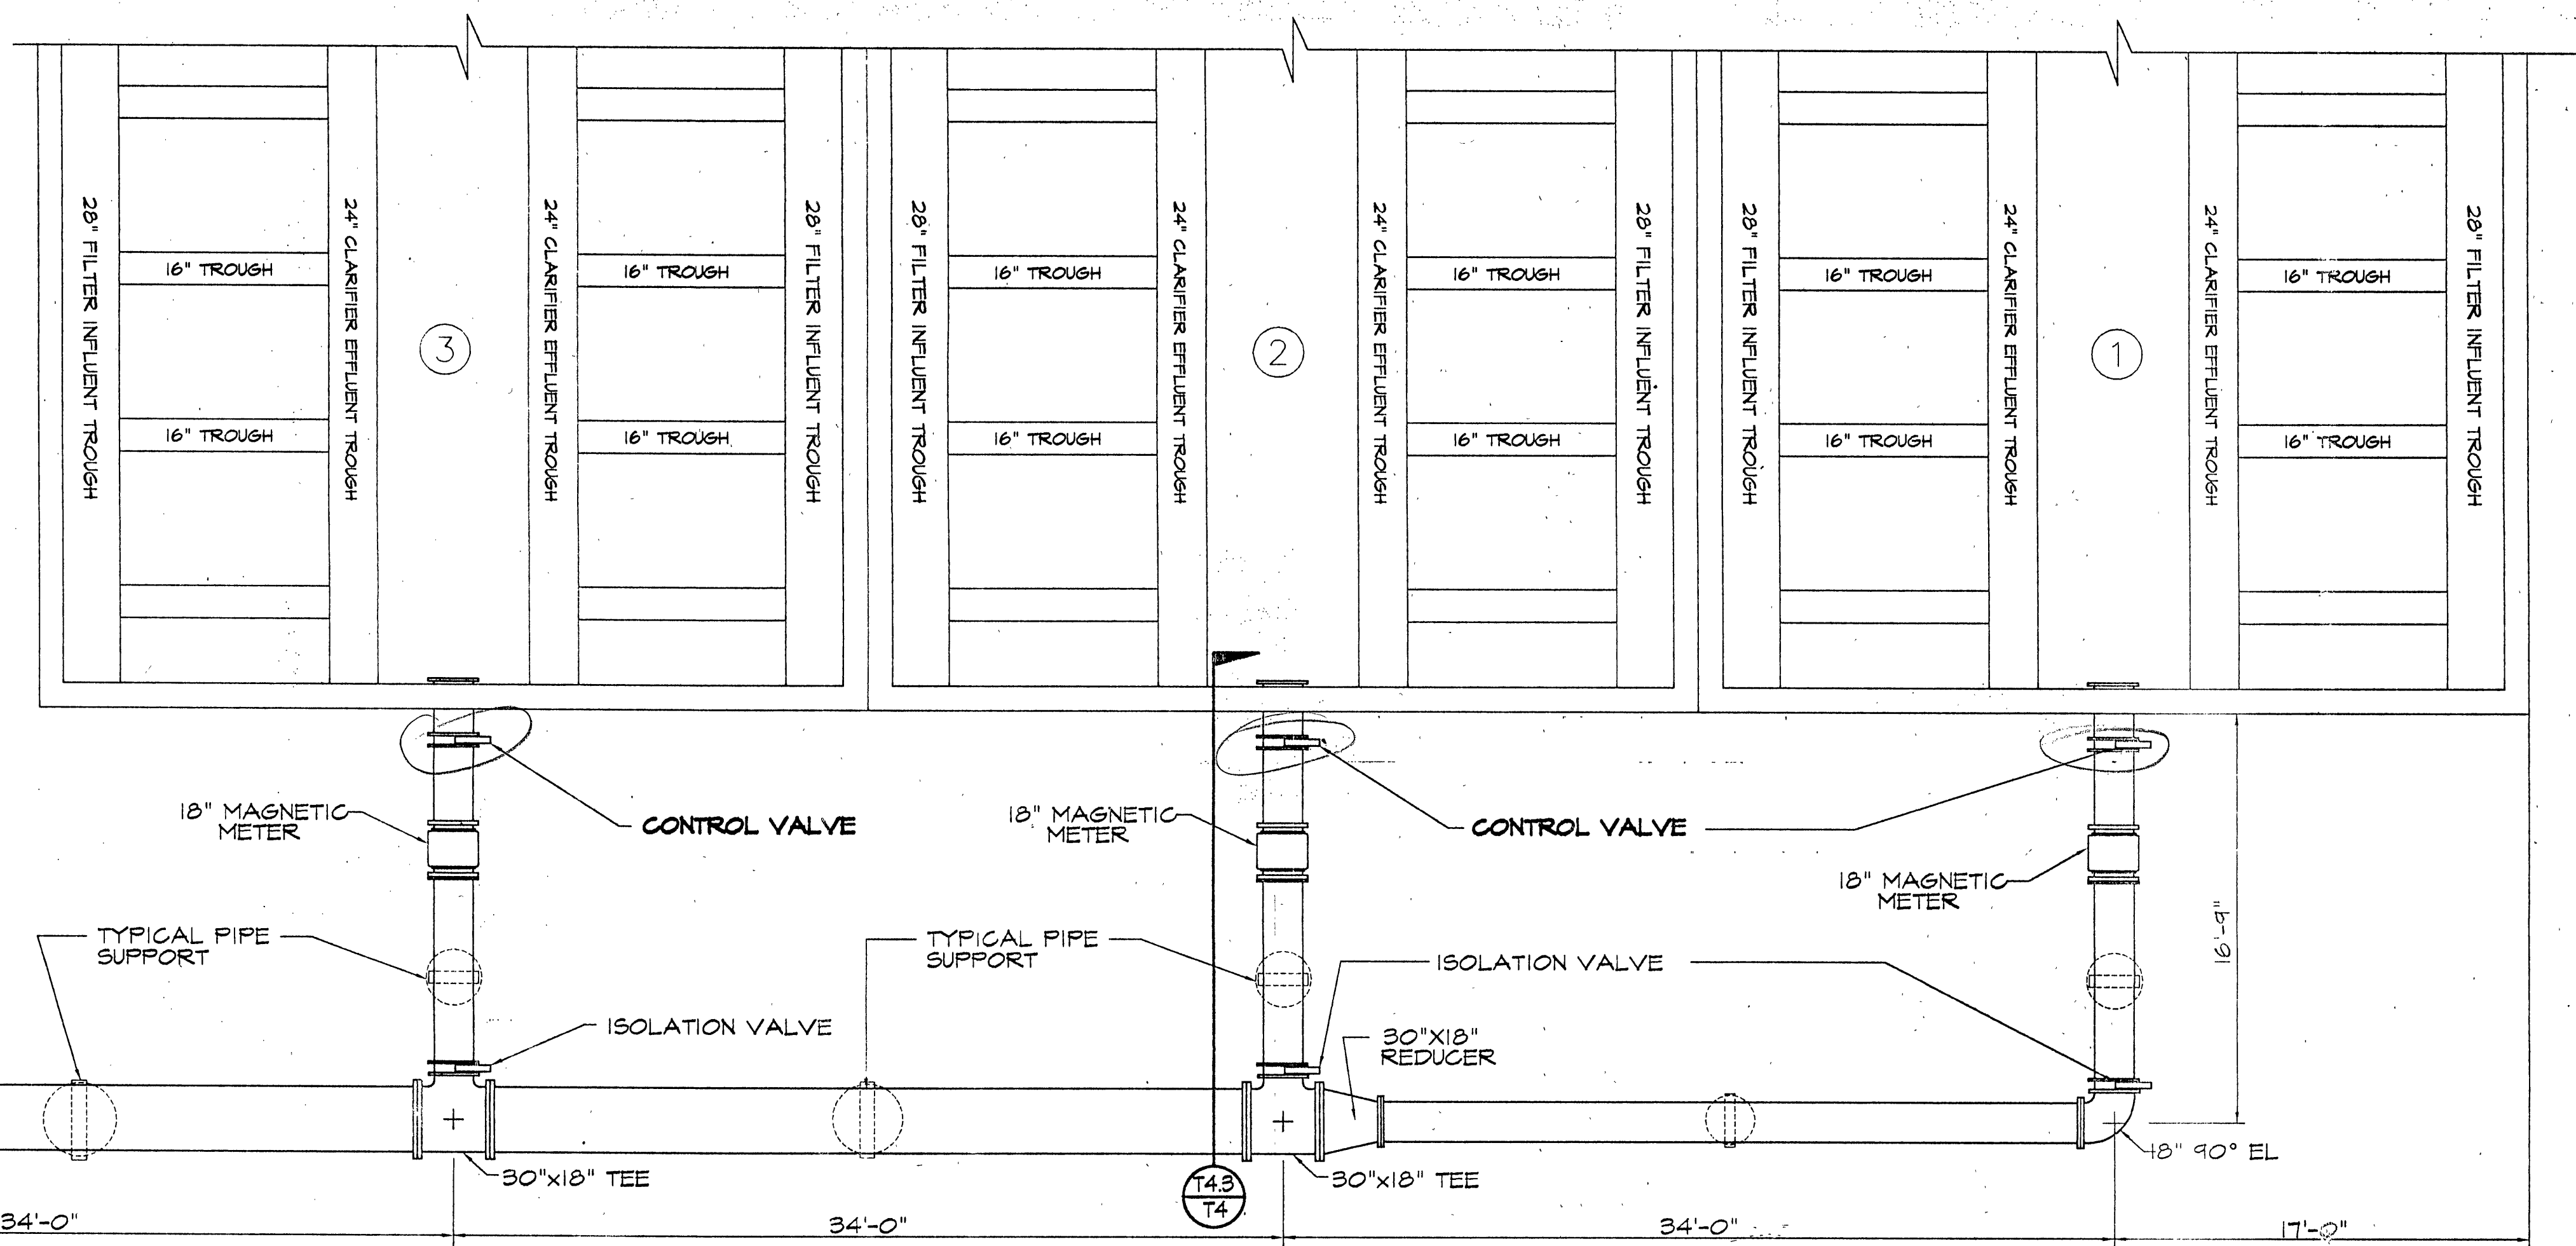


RAW WATER PIPING PLAN
SCALE 1" = 5'-0"

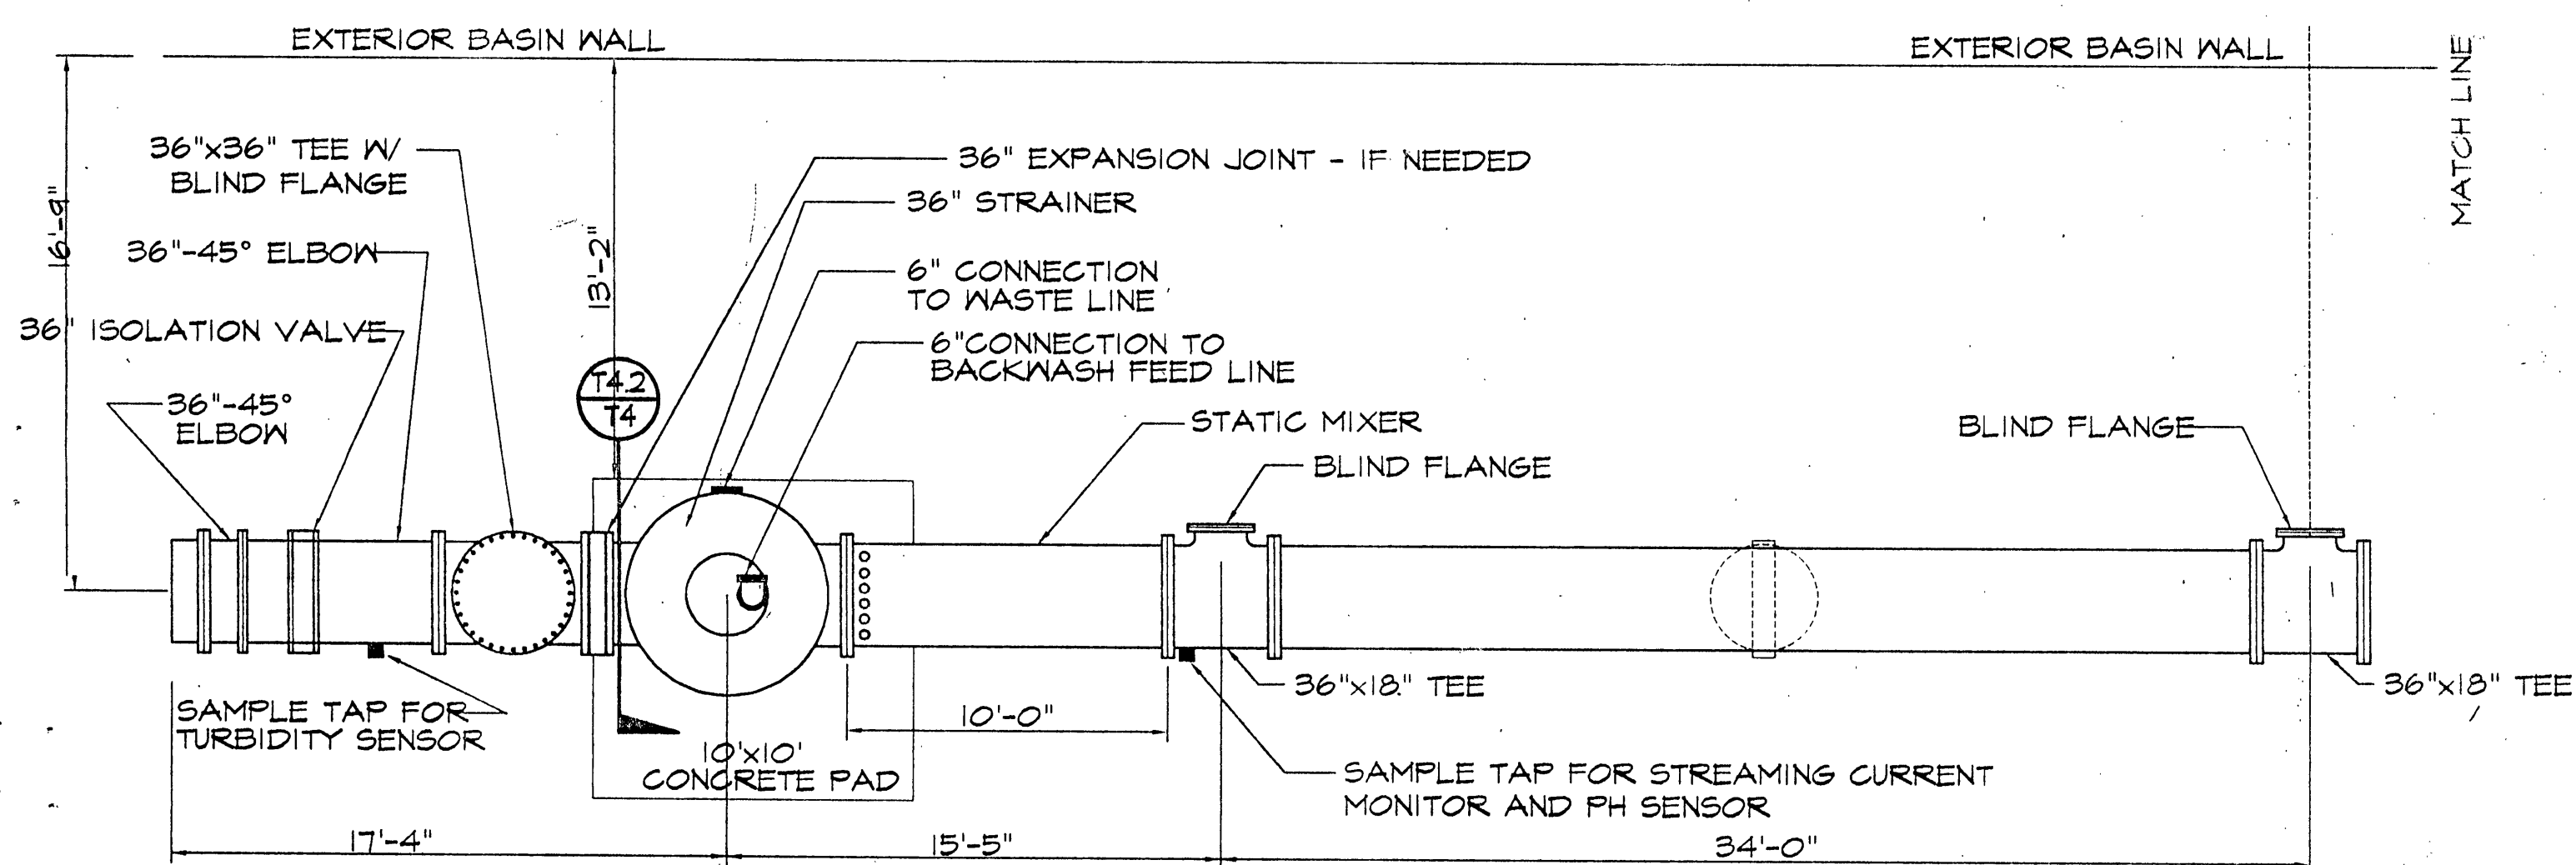

RAW WATER PIPING PLAN
SCALE 1" = 5'-0"

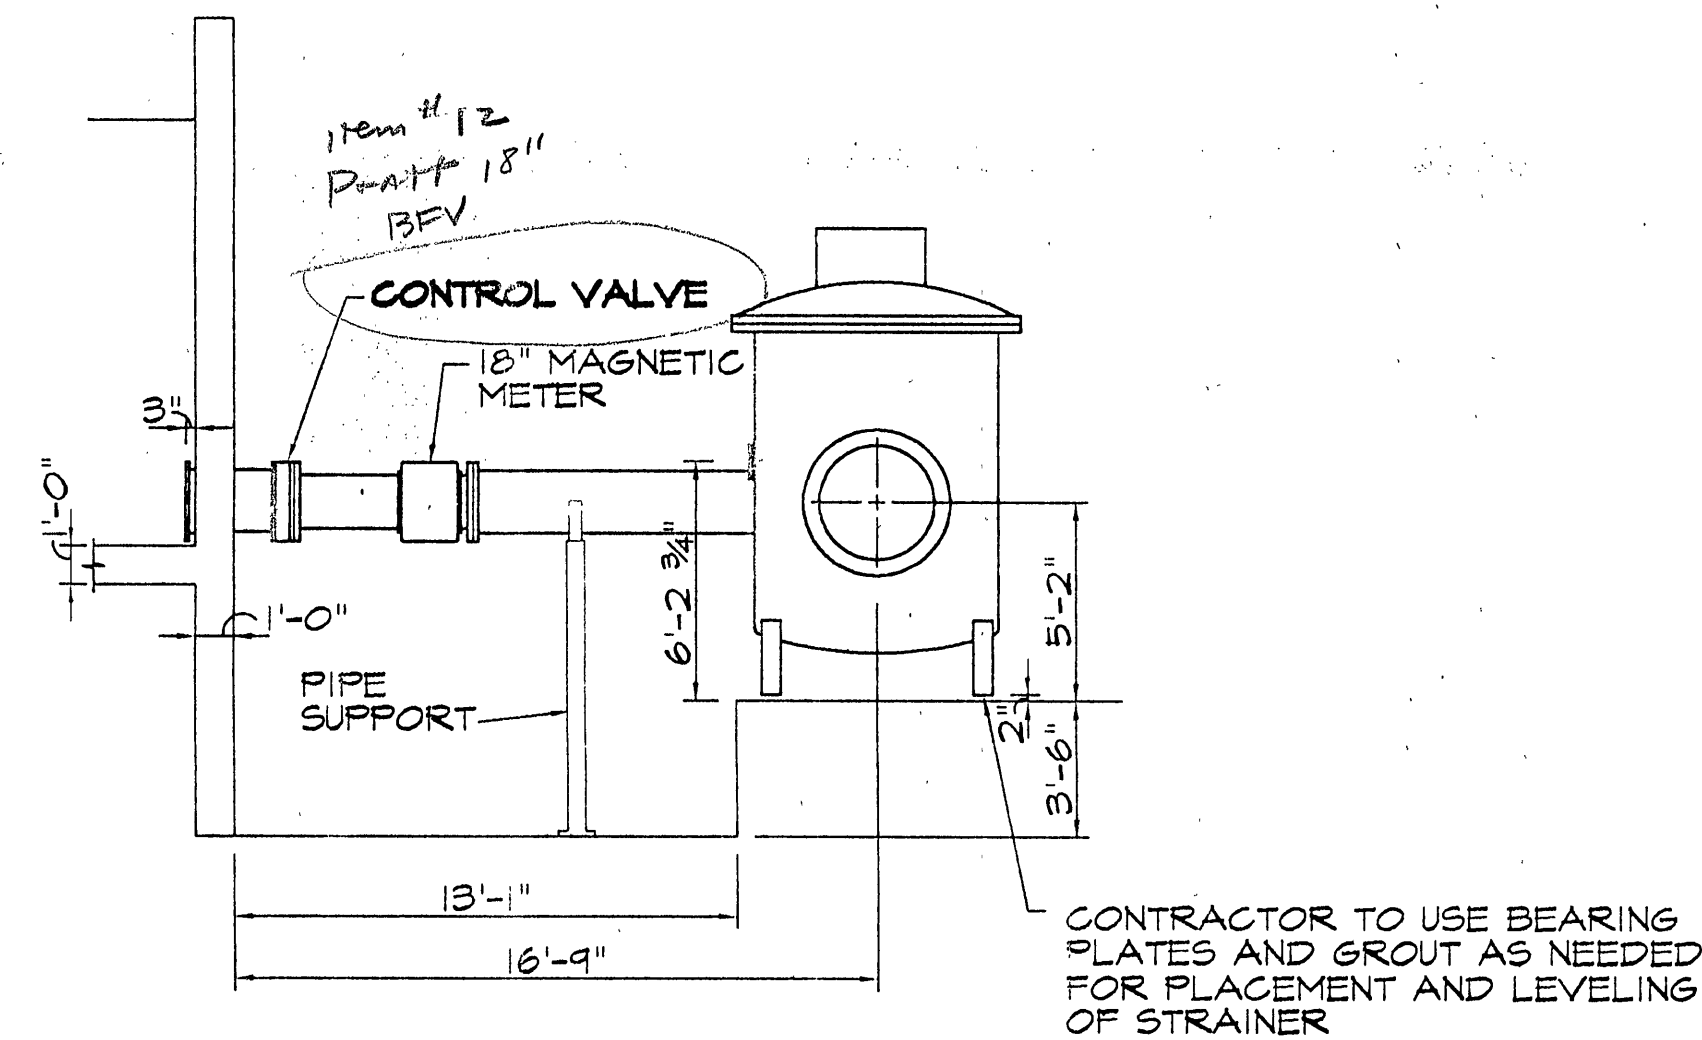

SECTION DETAIL - RAW / STRAINER (T4.2)
SCALE 1" = 5'-0"

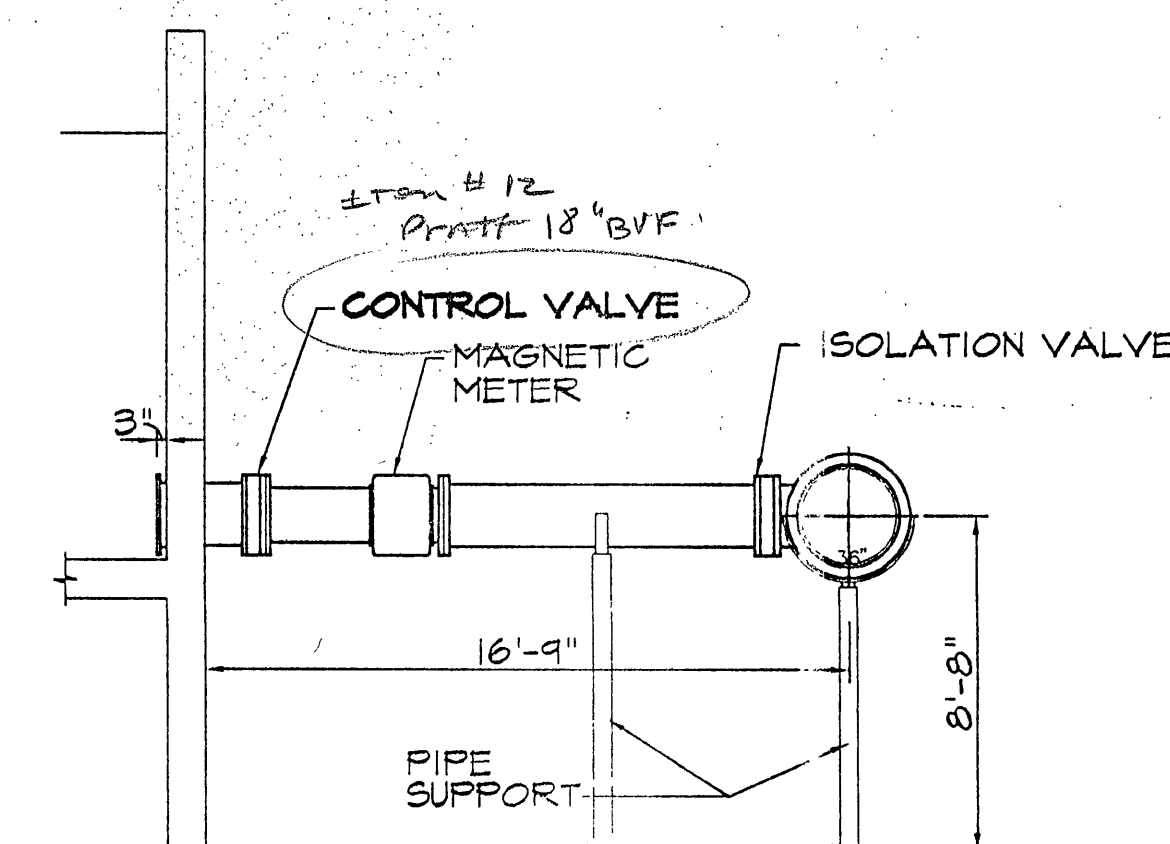


SECTION DETAIL - RAW (T4.3)
SCALE 1" = 5'-0"

NOTES



1. ALL RAW PIPING AND FITTINGS TO BE 304 STAINLESS STEEL RATED AT 25 PSI
2. ALL CONTROL VALVES TO BE SUPPLIED BY OTHERS
3. CONTROL VALVE: MOTORIZED MODULATING BUTTERFLY VALVE WITH HAND OPERATOR

INSPECTOR'S AS-BUILTS 1995

WWW.IDP.6LDLIZ

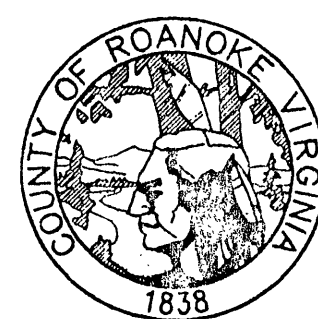

**ROANOKE COUNTY
WATER TREATMENT
FACILITY**

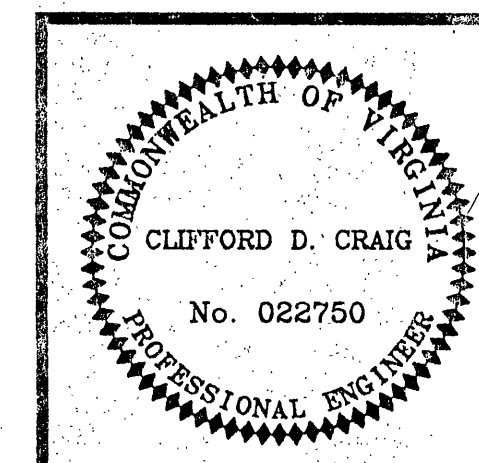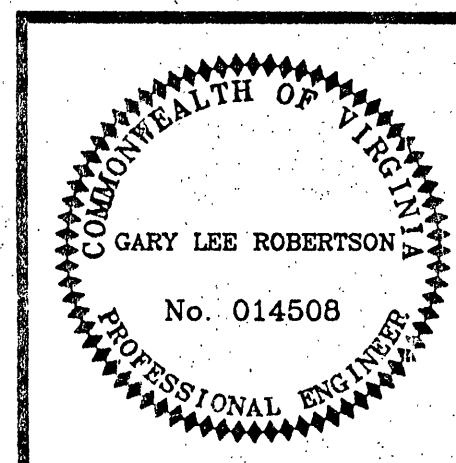

RAW WATER PIPING DIAGRAM	
DESIGN ENGINEER CLIFFORD D. CRAIG	COMMISSION NUMBER 1913
ACID NUMBER WTF-1	DATE 9 SEPT. 1994

T4

ROANOKE COUNTY UTILITY DEPARTMENT