



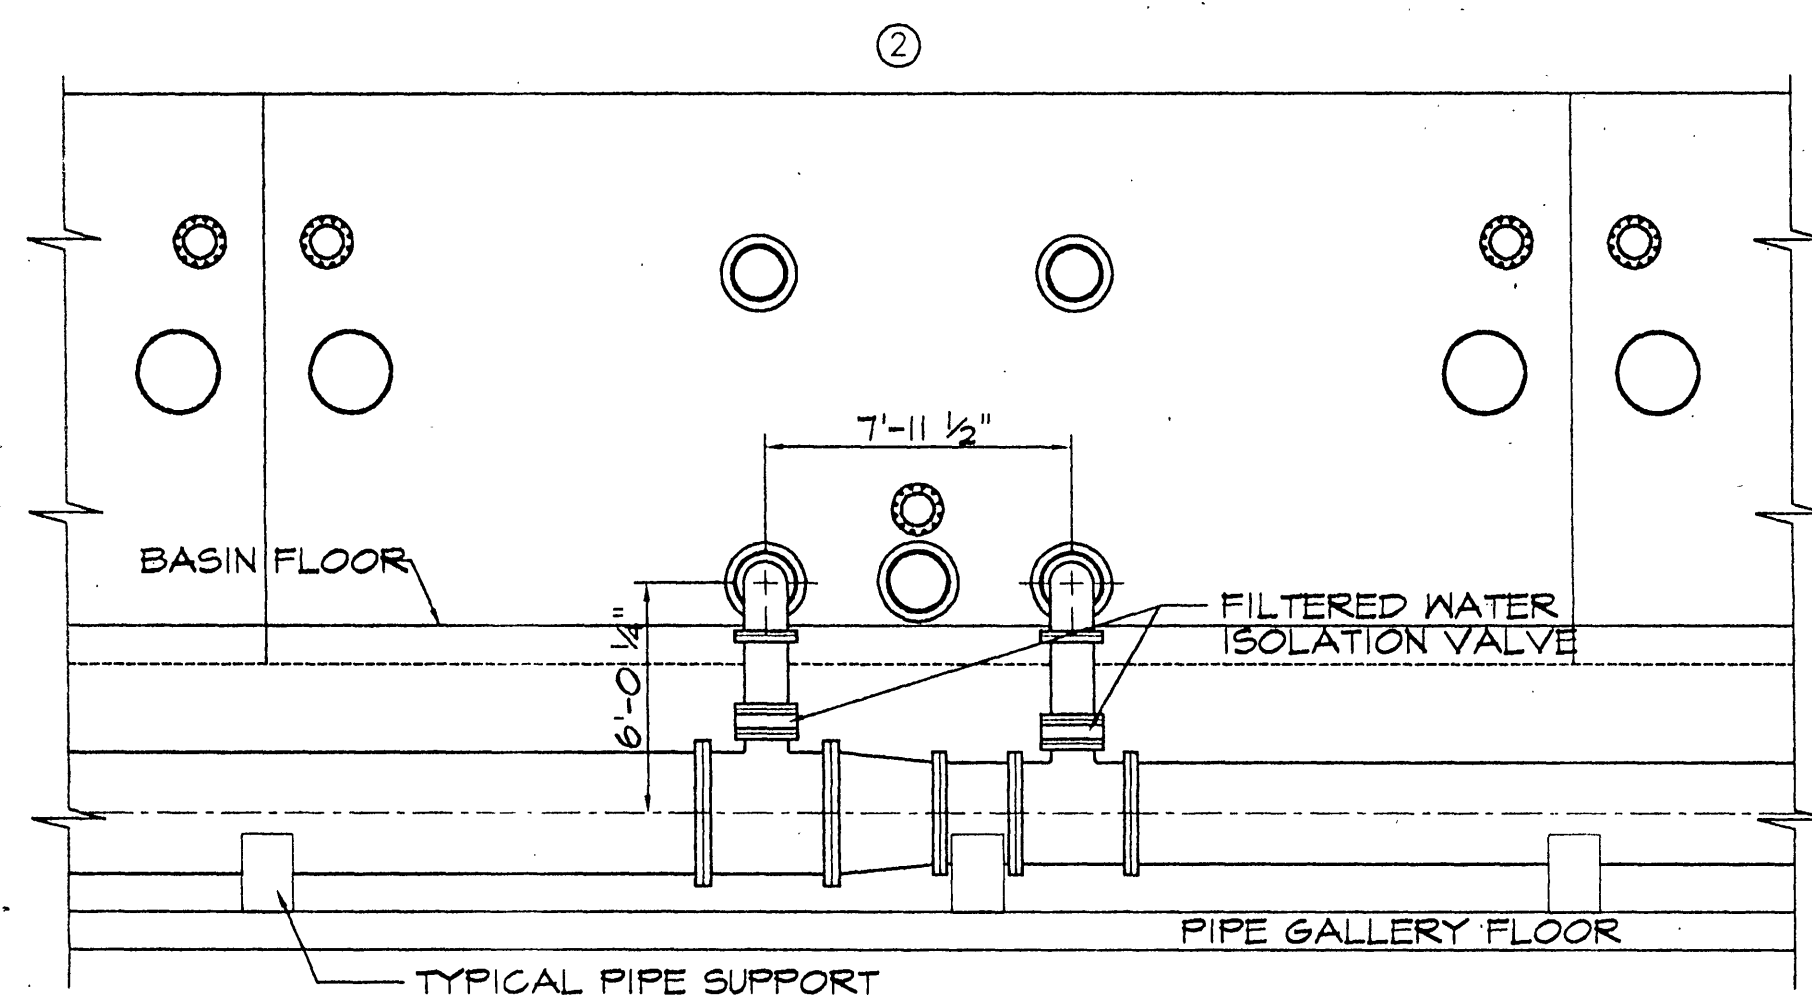


BASIN #2 - FILTERED PIPING ELEVATION
SCALE 1" = 5'-0"

T6.1
T6

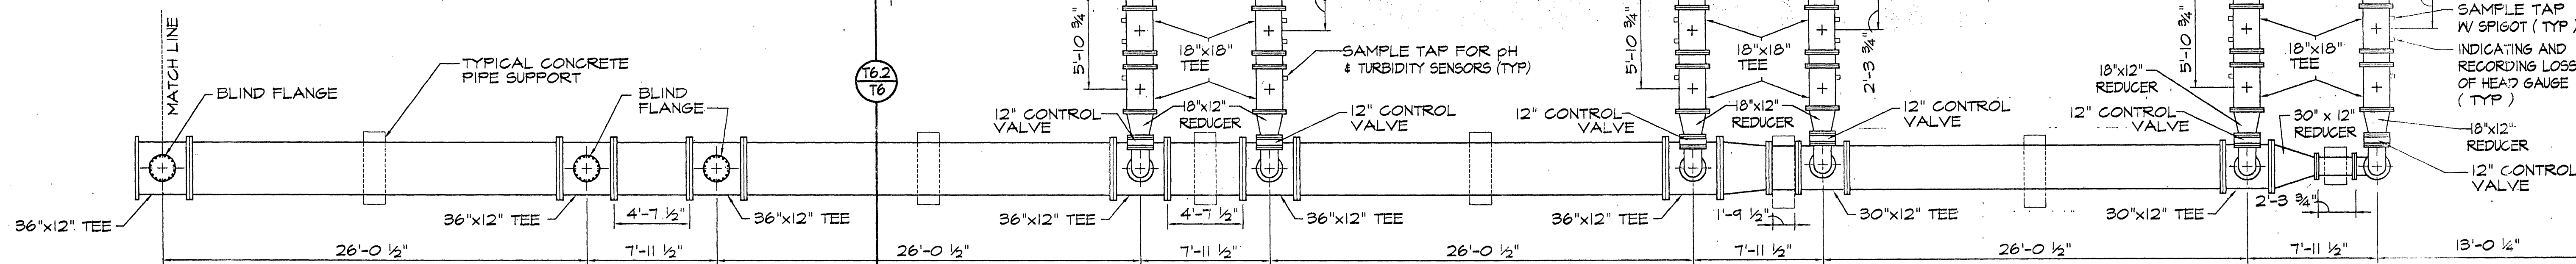

FILTERED PIPING PLAN
SCALE 1" = 5'-0"

T6.2
T6

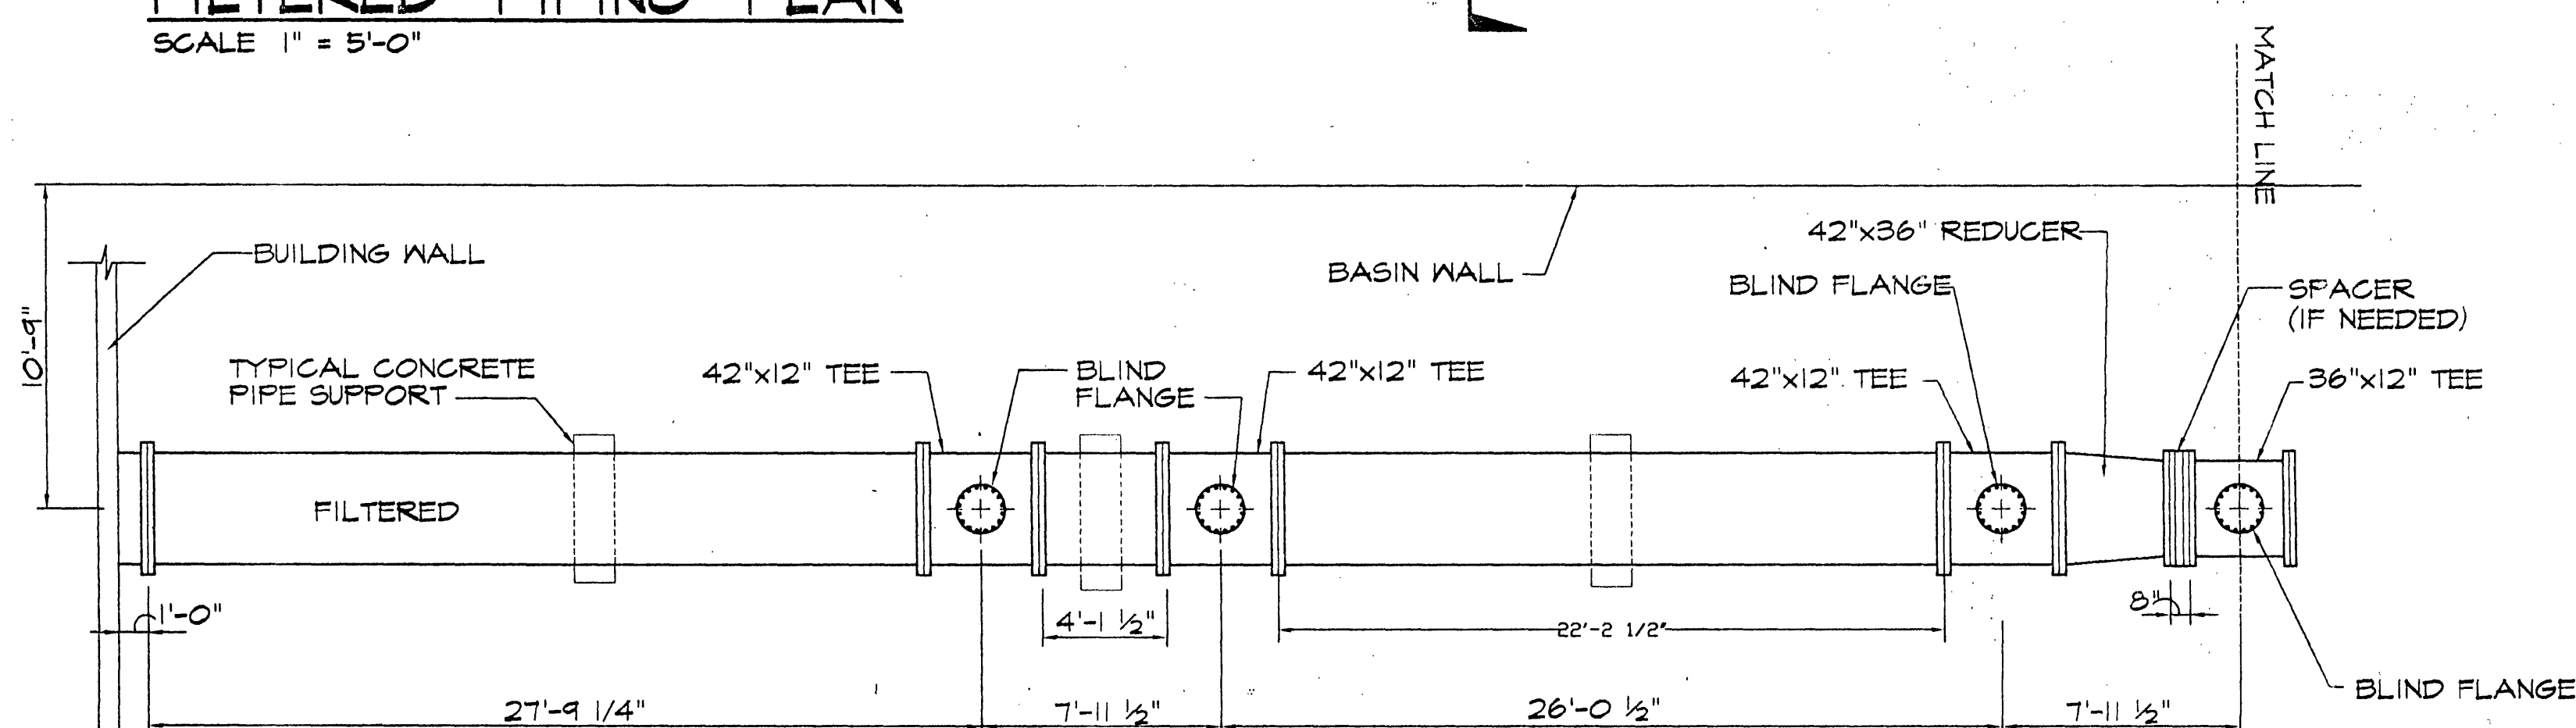


FILTERED PIPING PLAN
SCALE 1" = 5'-0"

- NOTES:
1. ALL FILTERED PIPING AND FITTINGS TO BE 304 STAINLESS STEEL RATED AT 125 PSI
 2. ALL CONTROL VALVES TO BE SUPPLIED BY OTHERS
 3. CONTROL VALVE: MOTORIZED MODULATING BUTTERFLY VALVE WITH HAND OPERATOR
 4. CONTROL VALVE (ON/OFF): MOTORIZED ON/OFF BUTTERFLY VALVE WITH HAND OPERATOR

INSPECTOR'S AS-BUILTS 1995


WWW.ID#8DLUZ

T6.1
T6


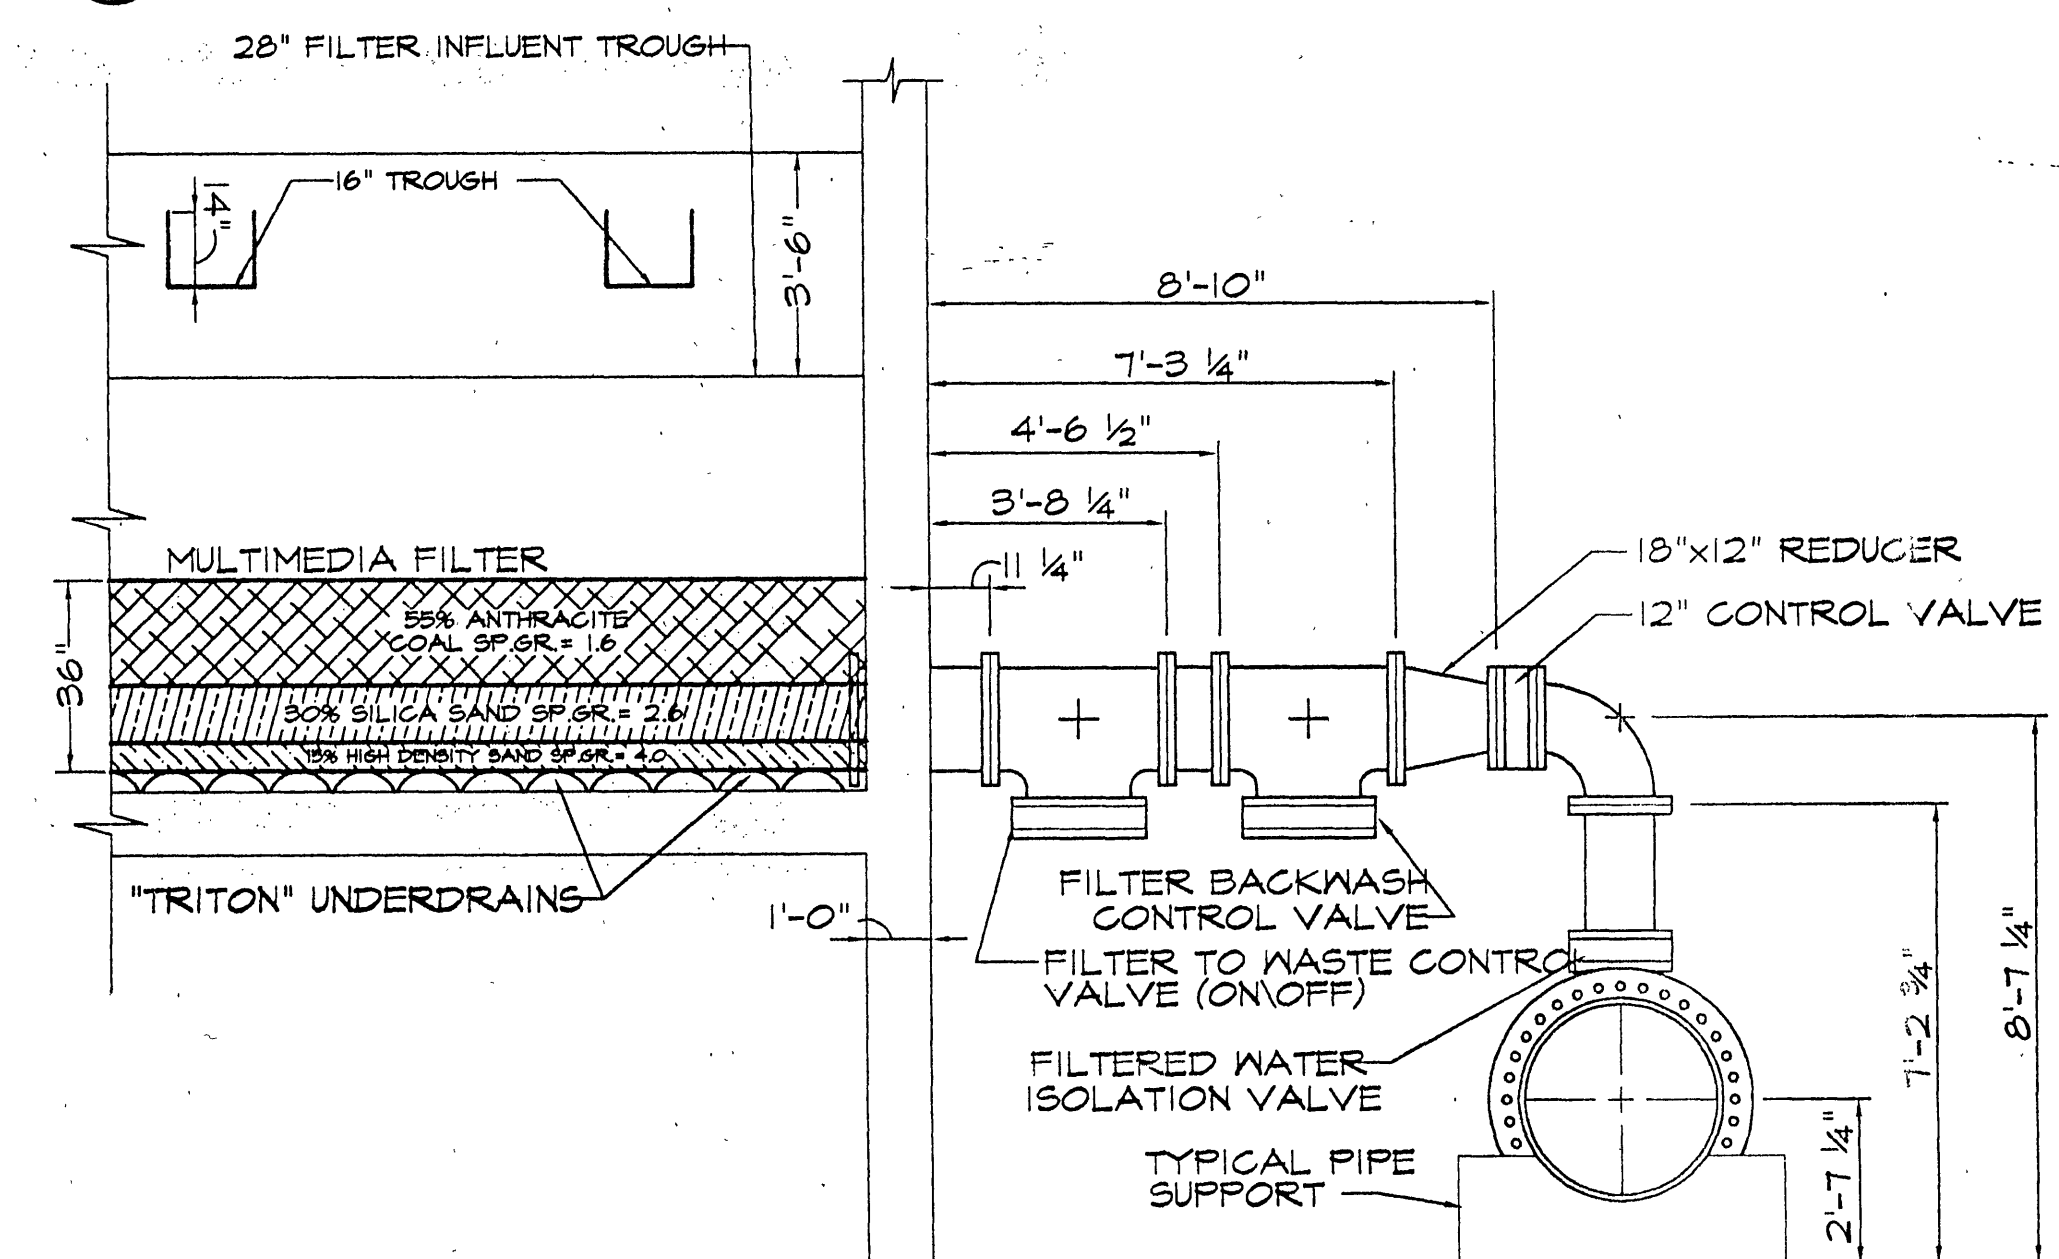


SECTION - FILTERED
SCALE 1" = 3'-0"

T6.2
T6

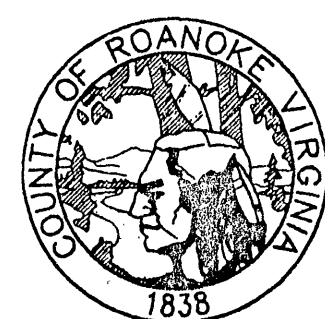

**ROANOKE COUNTY
WATER TREATMENT
FACILITY**

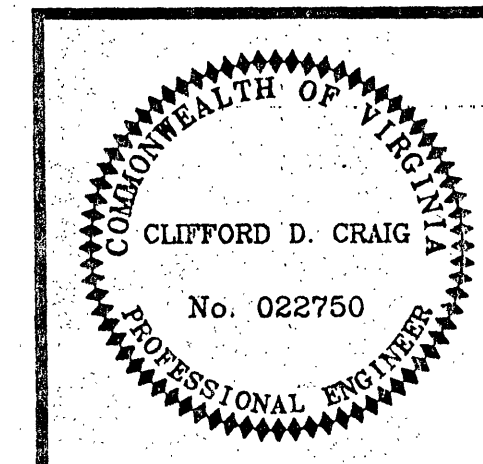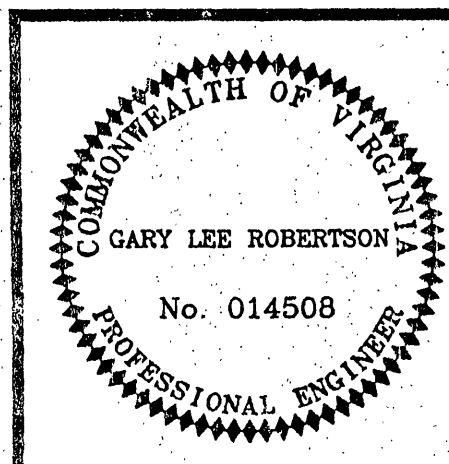

FILTERED PIPING DIAGRAM	
DESIGN ENGINEER CLIFFORD D. CRAIG	COMMISSION NUMBER 1913
RCUD NUMBER WTF-1	DATE 9 SEPT. 1994

T6

ROANOKE COUNTY UTILITY DEPARTMENT