




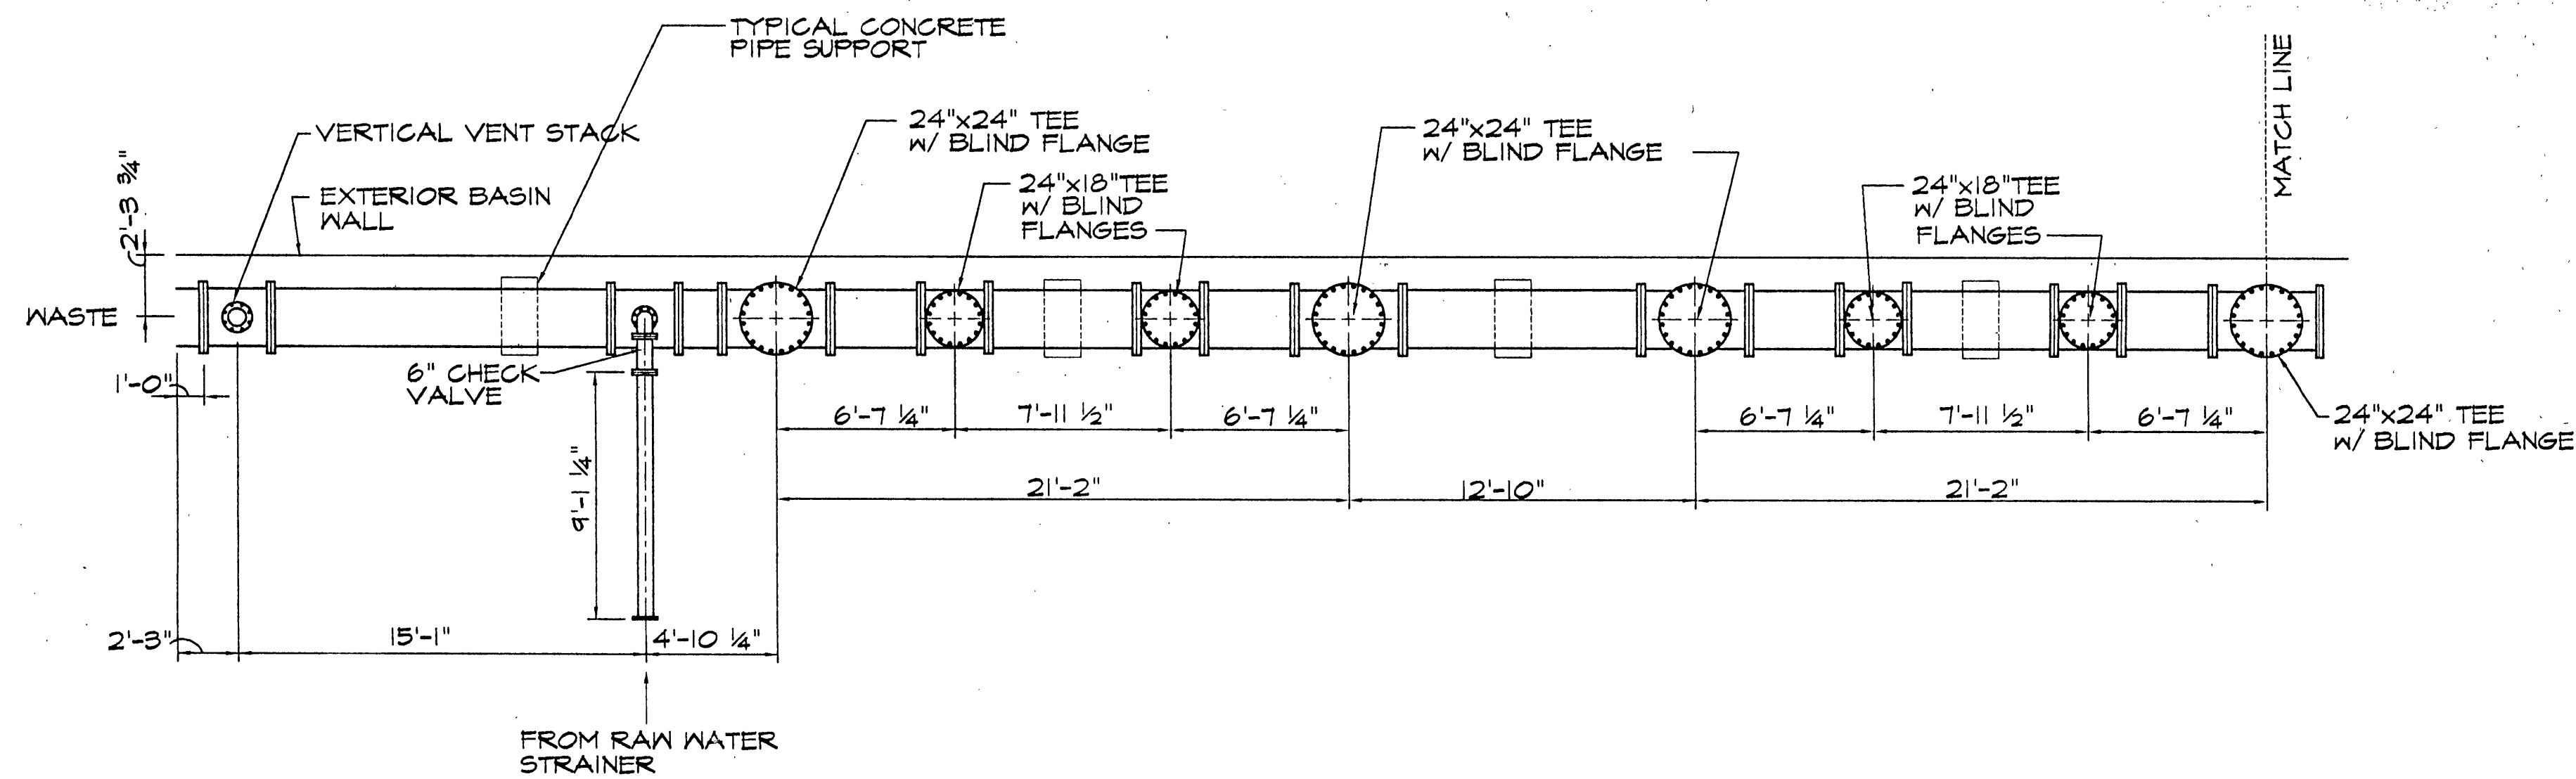


WASTE PIPING PLAN
SCALE 1" = 5'-0"

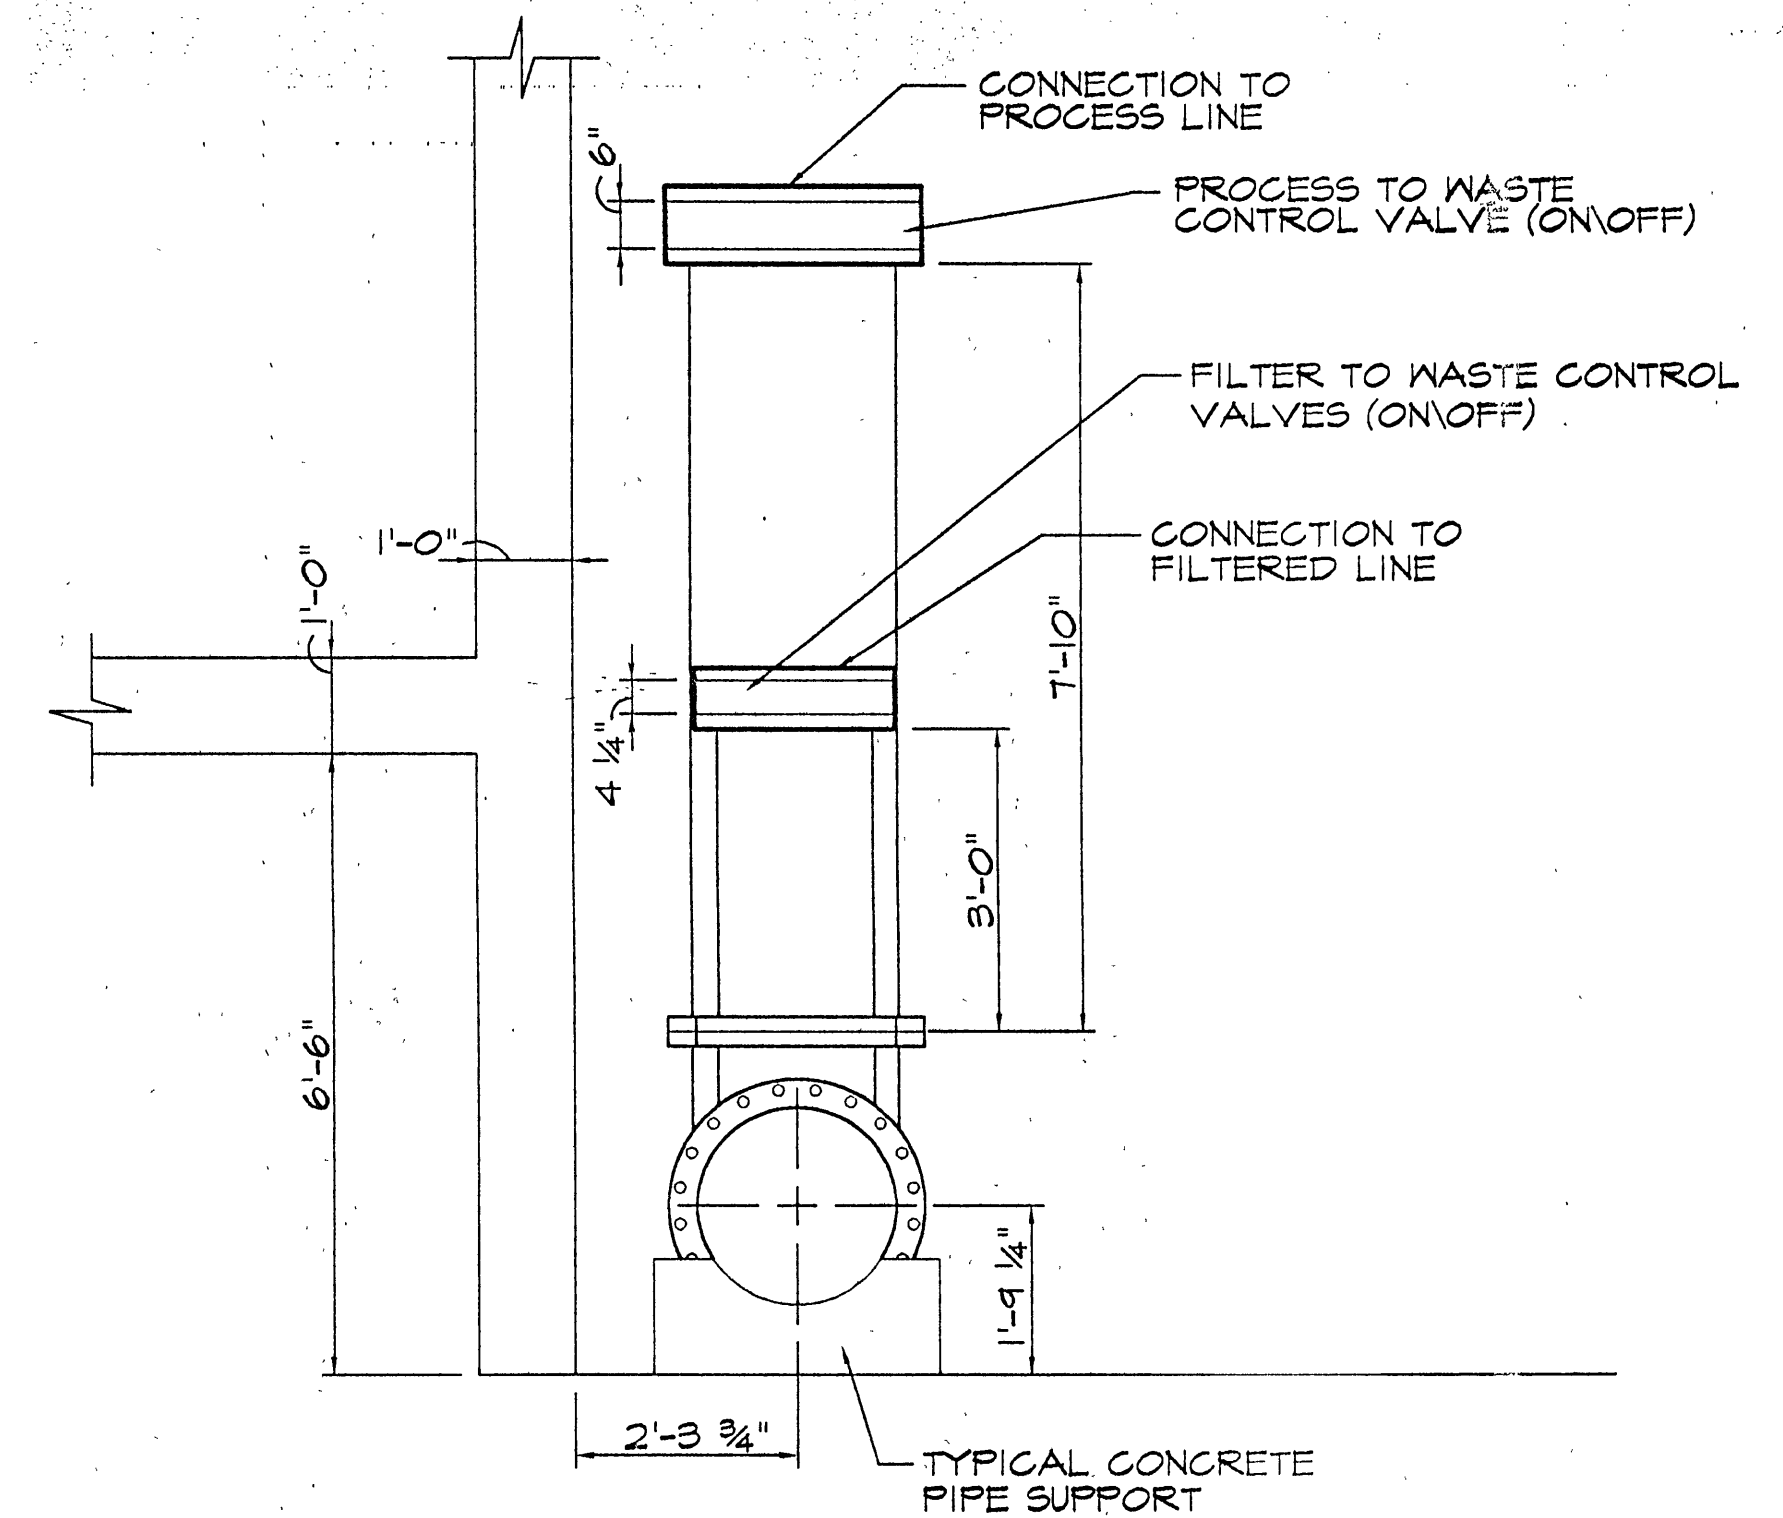


WASTE PIPING SECTION T8.2
SCALE 1" = 2'-0" • OUTSIDE BUILDING WALL T8

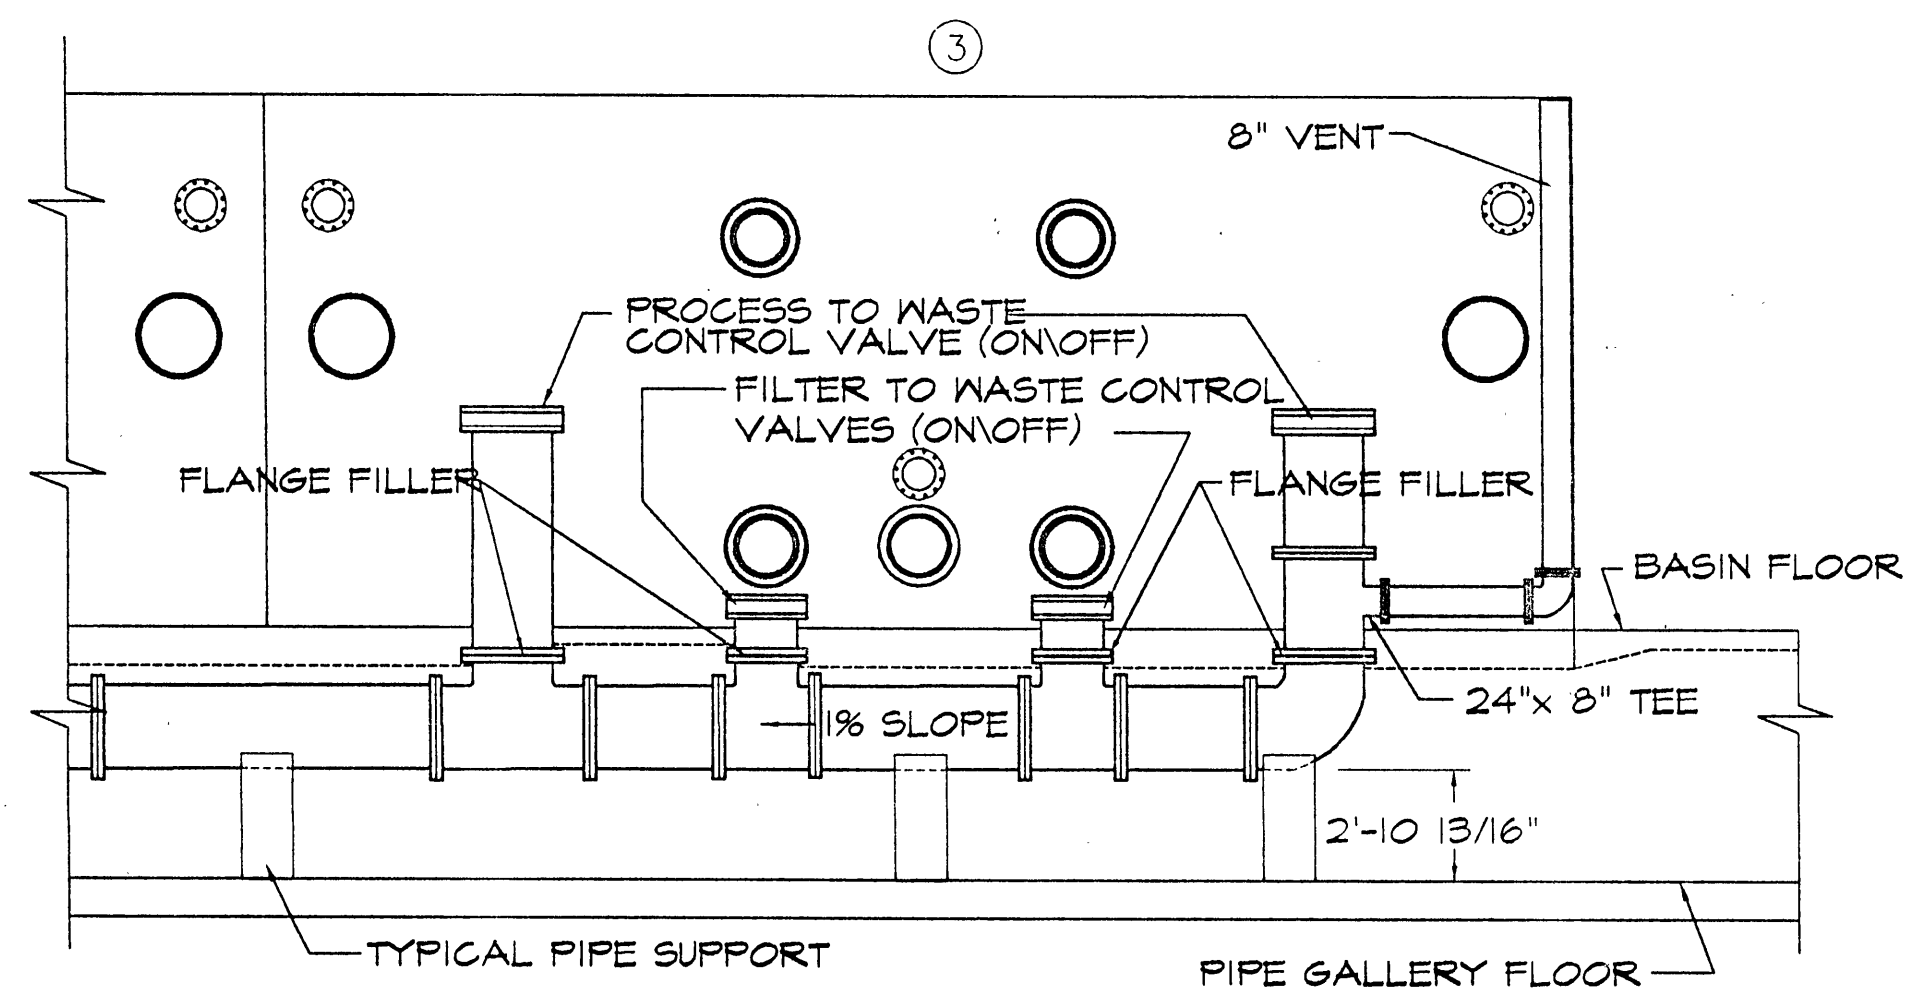

BASIN #3 - WASTE PIPING ELEVATION T8.1
SCALE 1" = 5'-0" T8

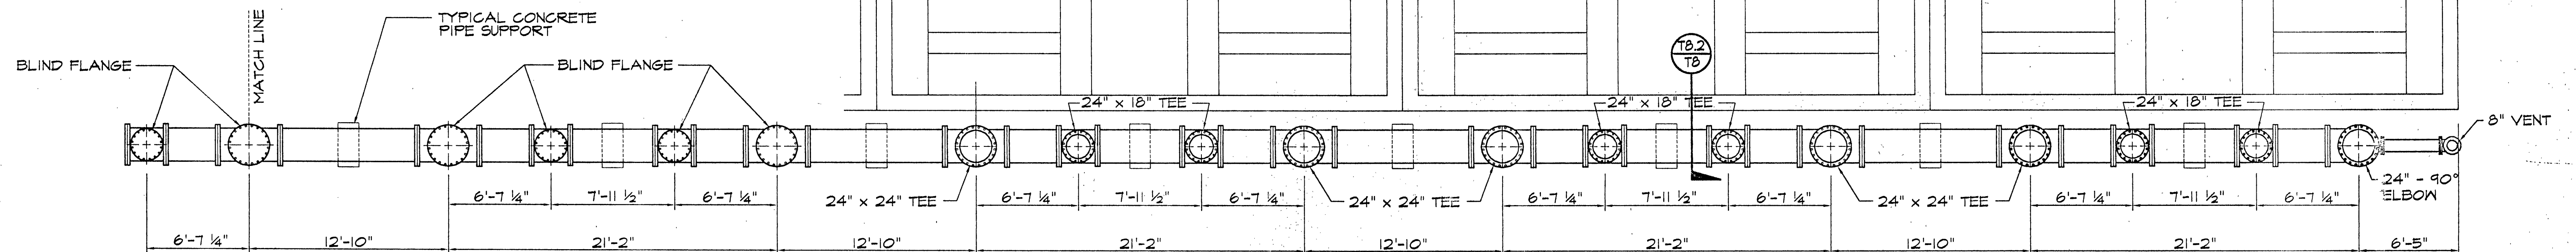

WASTE PIPING PLAN
SCALE 1" = 5'-0"

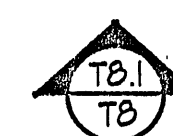


INSPECTOR'S AS-BUILTS 1995



WWW.ID# 6DLUZ

NOTES

1. ALL WASTE PIPING TO BE 304 STAINLESS STEEL RATED AT 125 PSI
2. ALL CONTROL VALVES TO BE SUPPLIED BY OTHERS
3. CONTROL VALVE (ON/OFF): MOTORIZED ON/OFF BUTTERFLY VALVE WITH HAND OPERATOR

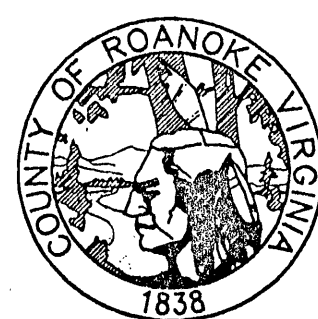

**ROANOKE COUNTY
WATER TREATMENT
FACILITY**

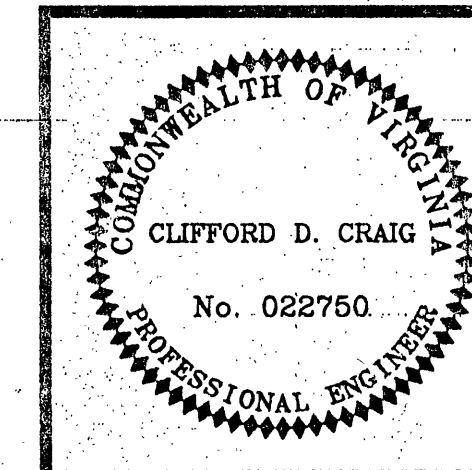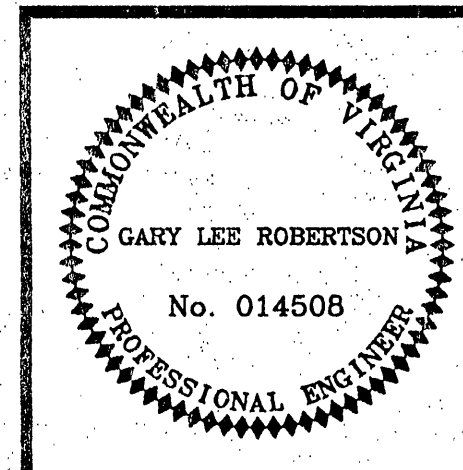

WASTE PIPING DIAGRAM

DESIGN ENGINEER
CLIFFORD D. CRAIG

COMMISSION NUMBER
1913

RCUD NUMBER
WTF-1

DATE
12 SEPT. 1994

T8