


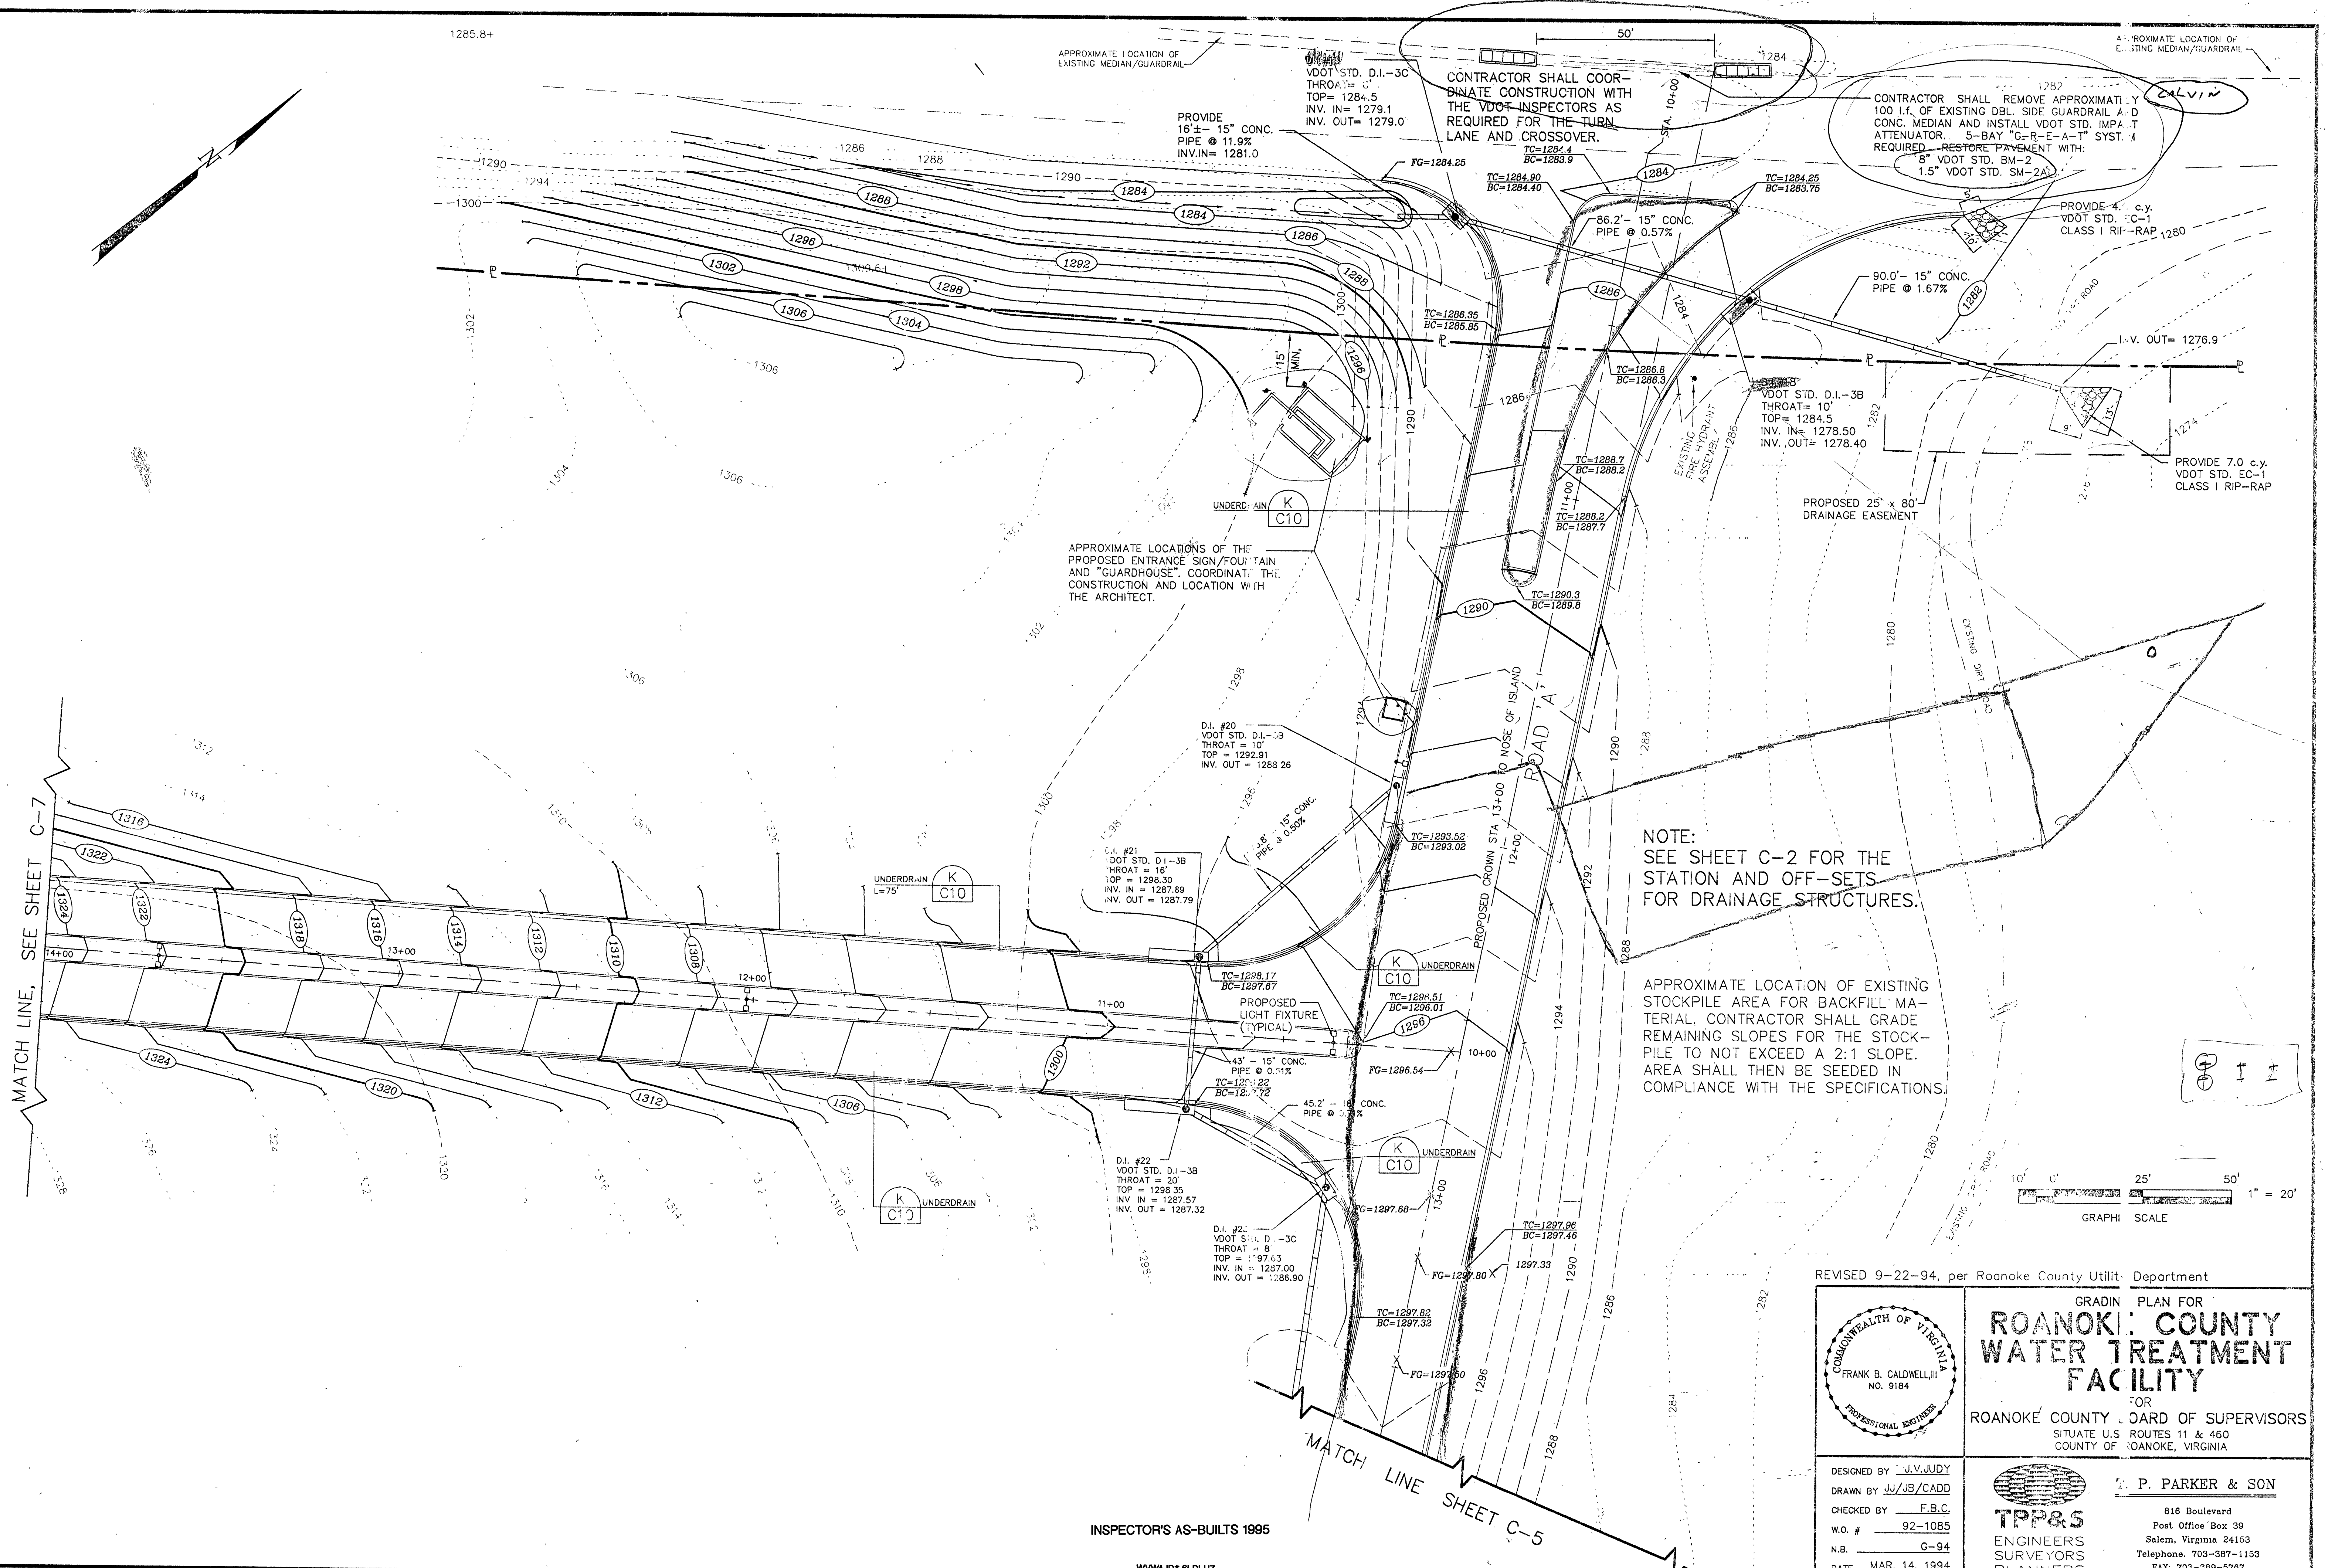

MATCH LINE, SEE SHEET C-7


MATCH LINE SHEET C-5

INSPECTOR'S AS-BUILTS 1995


WVWA ID# 6LDLIZ

NOTE:
SEE SHEET C-2 FOR THE
STATION AND OFF-SETS
FOR DRAINAGE STRUCTURES.

APPROXIMATE LOCATION OF EXISTING
STOCKPILE AREA FOR BACKFILL MA-
TERIAL. CONTRACTOR SHALL GRADE
REMAINING SLOPES FOR THE STOCK-
PILE TO NOT EXCEED A 2:1 SLOPE.
AREA SHALL THEN BE SEED IN
COMPLIANCE WITH THE SPECIFICATIONS.

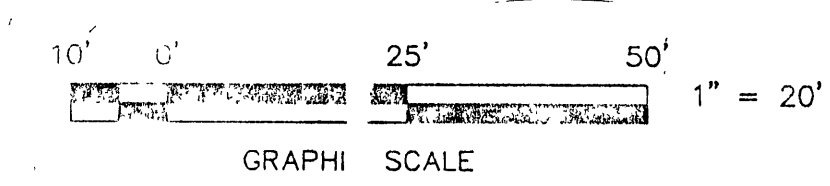

REVISED 9-22-94, per Roanoke County Utility Department

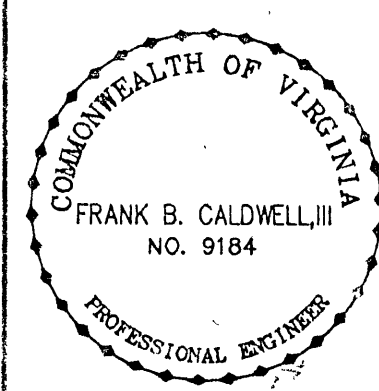	GRADING PLAN FOR ROANOKE COUNTY WATER TREATMENT FACILITY	
	FOR ROANOKE COUNTY BOARD OF SUPERVISORS	
	SITUATE U.S. ROUTES 11 & 460 COUNTY OF ROANOKE, VIRGINIA	
	 TPP&S ENGINEERS SURVEYORS PLANNERS	
	DESIGNED BY <u>J.V. JUDY</u> DRAWN BY <u>JJ/JS/CADD</u> CHECKED BY <u>F.B.C.</u> W.O. # <u>92-1085</u> N.B. <u>G-94</u> DATE <u>MAR. 14, 1994</u>	P. PARKER & SON 816 Boulevard Post Office Box 39 Salem, Virginia 24163 Telephone: 703-387-1153 FAX: 703-389-5767