


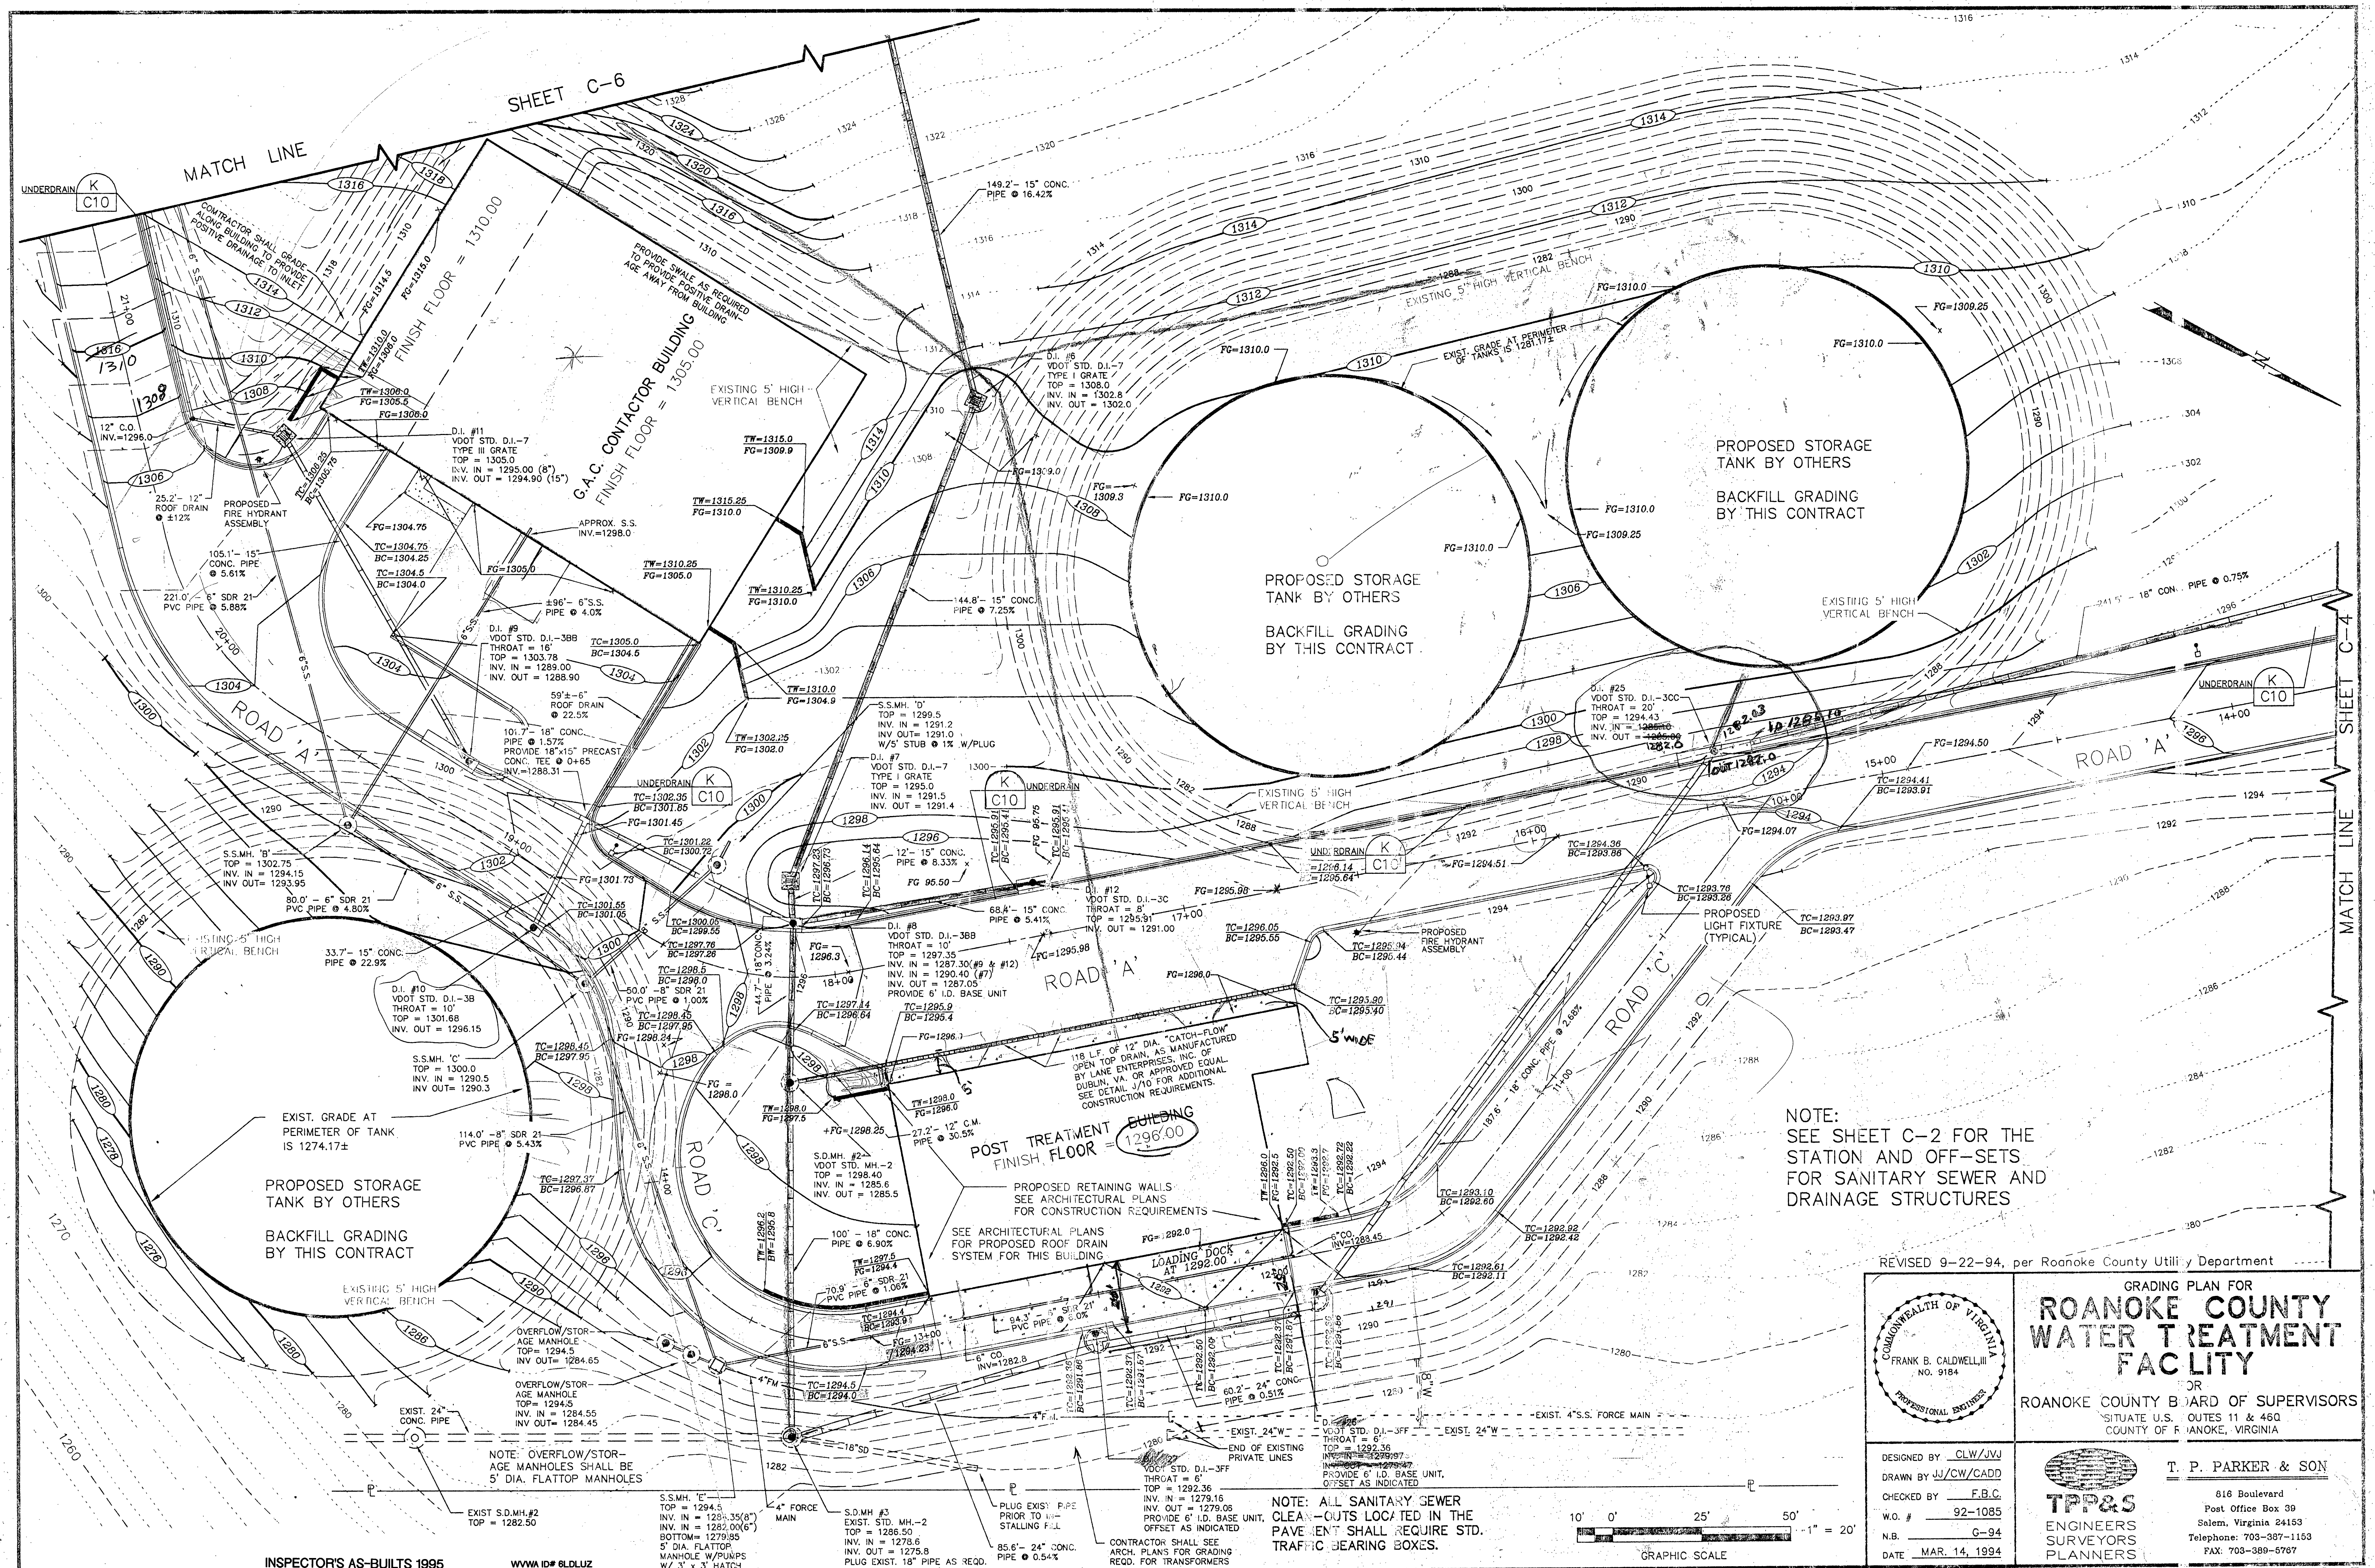

NOTE:  
SEE SHEET C-2 FOR THE  
STATION AND OFF-SETS  
FOR SANITARY SEWER AND  
DRAINAGE STRUCTURES

REVISED 9-22-94, per Roanoke County Utility Department

|                                                                                                                                        |  |                                                                                                                                                                                                        |  |
|----------------------------------------------------------------------------------------------------------------------------------------|--|--------------------------------------------------------------------------------------------------------------------------------------------------------------------------------------------------------|--|
| <p>DESIGNED BY: CLW/JVJ<br/>DRAWN BY: JJ/CW/CADD<br/>CHECKED BY: F.B.C.<br/>W.O. #: 92-1085<br/>N.B.: G-94<br/>DATE: MAR. 14, 1994</p> |  | <p>GRADING PLAN FOR<br/><b>ROANOKE COUNTY<br/>WATER TREATMENT<br/>FACILITY</b><br/>FOR<br/>ROANOKE COUNTY BOARD OF SUPERVISORS<br/>SITUATE U.S. OUTS 11 &amp; 450<br/>COUNTY OF F. ANOKE, VIRGINIA</p> |  |
| <p>COMMONWEALTH OF VIRGINIA<br/>FRANK B. CALDWELL, III<br/>NO. 9184<br/>PROFESSIONAL ENGINEER</p>                                      |  | <p><b>T. P. PARKER &amp; SON</b><br/>616 Boulevard<br/>Post Office Box 39<br/>Salem, Virginia 24153<br/>Telephone: 703-387-1153<br/>FAX: 703-389-6787</p>                                              |  |