



SEE SHEET C-7 FOR GRADING PLAN FOR PARKING LOT

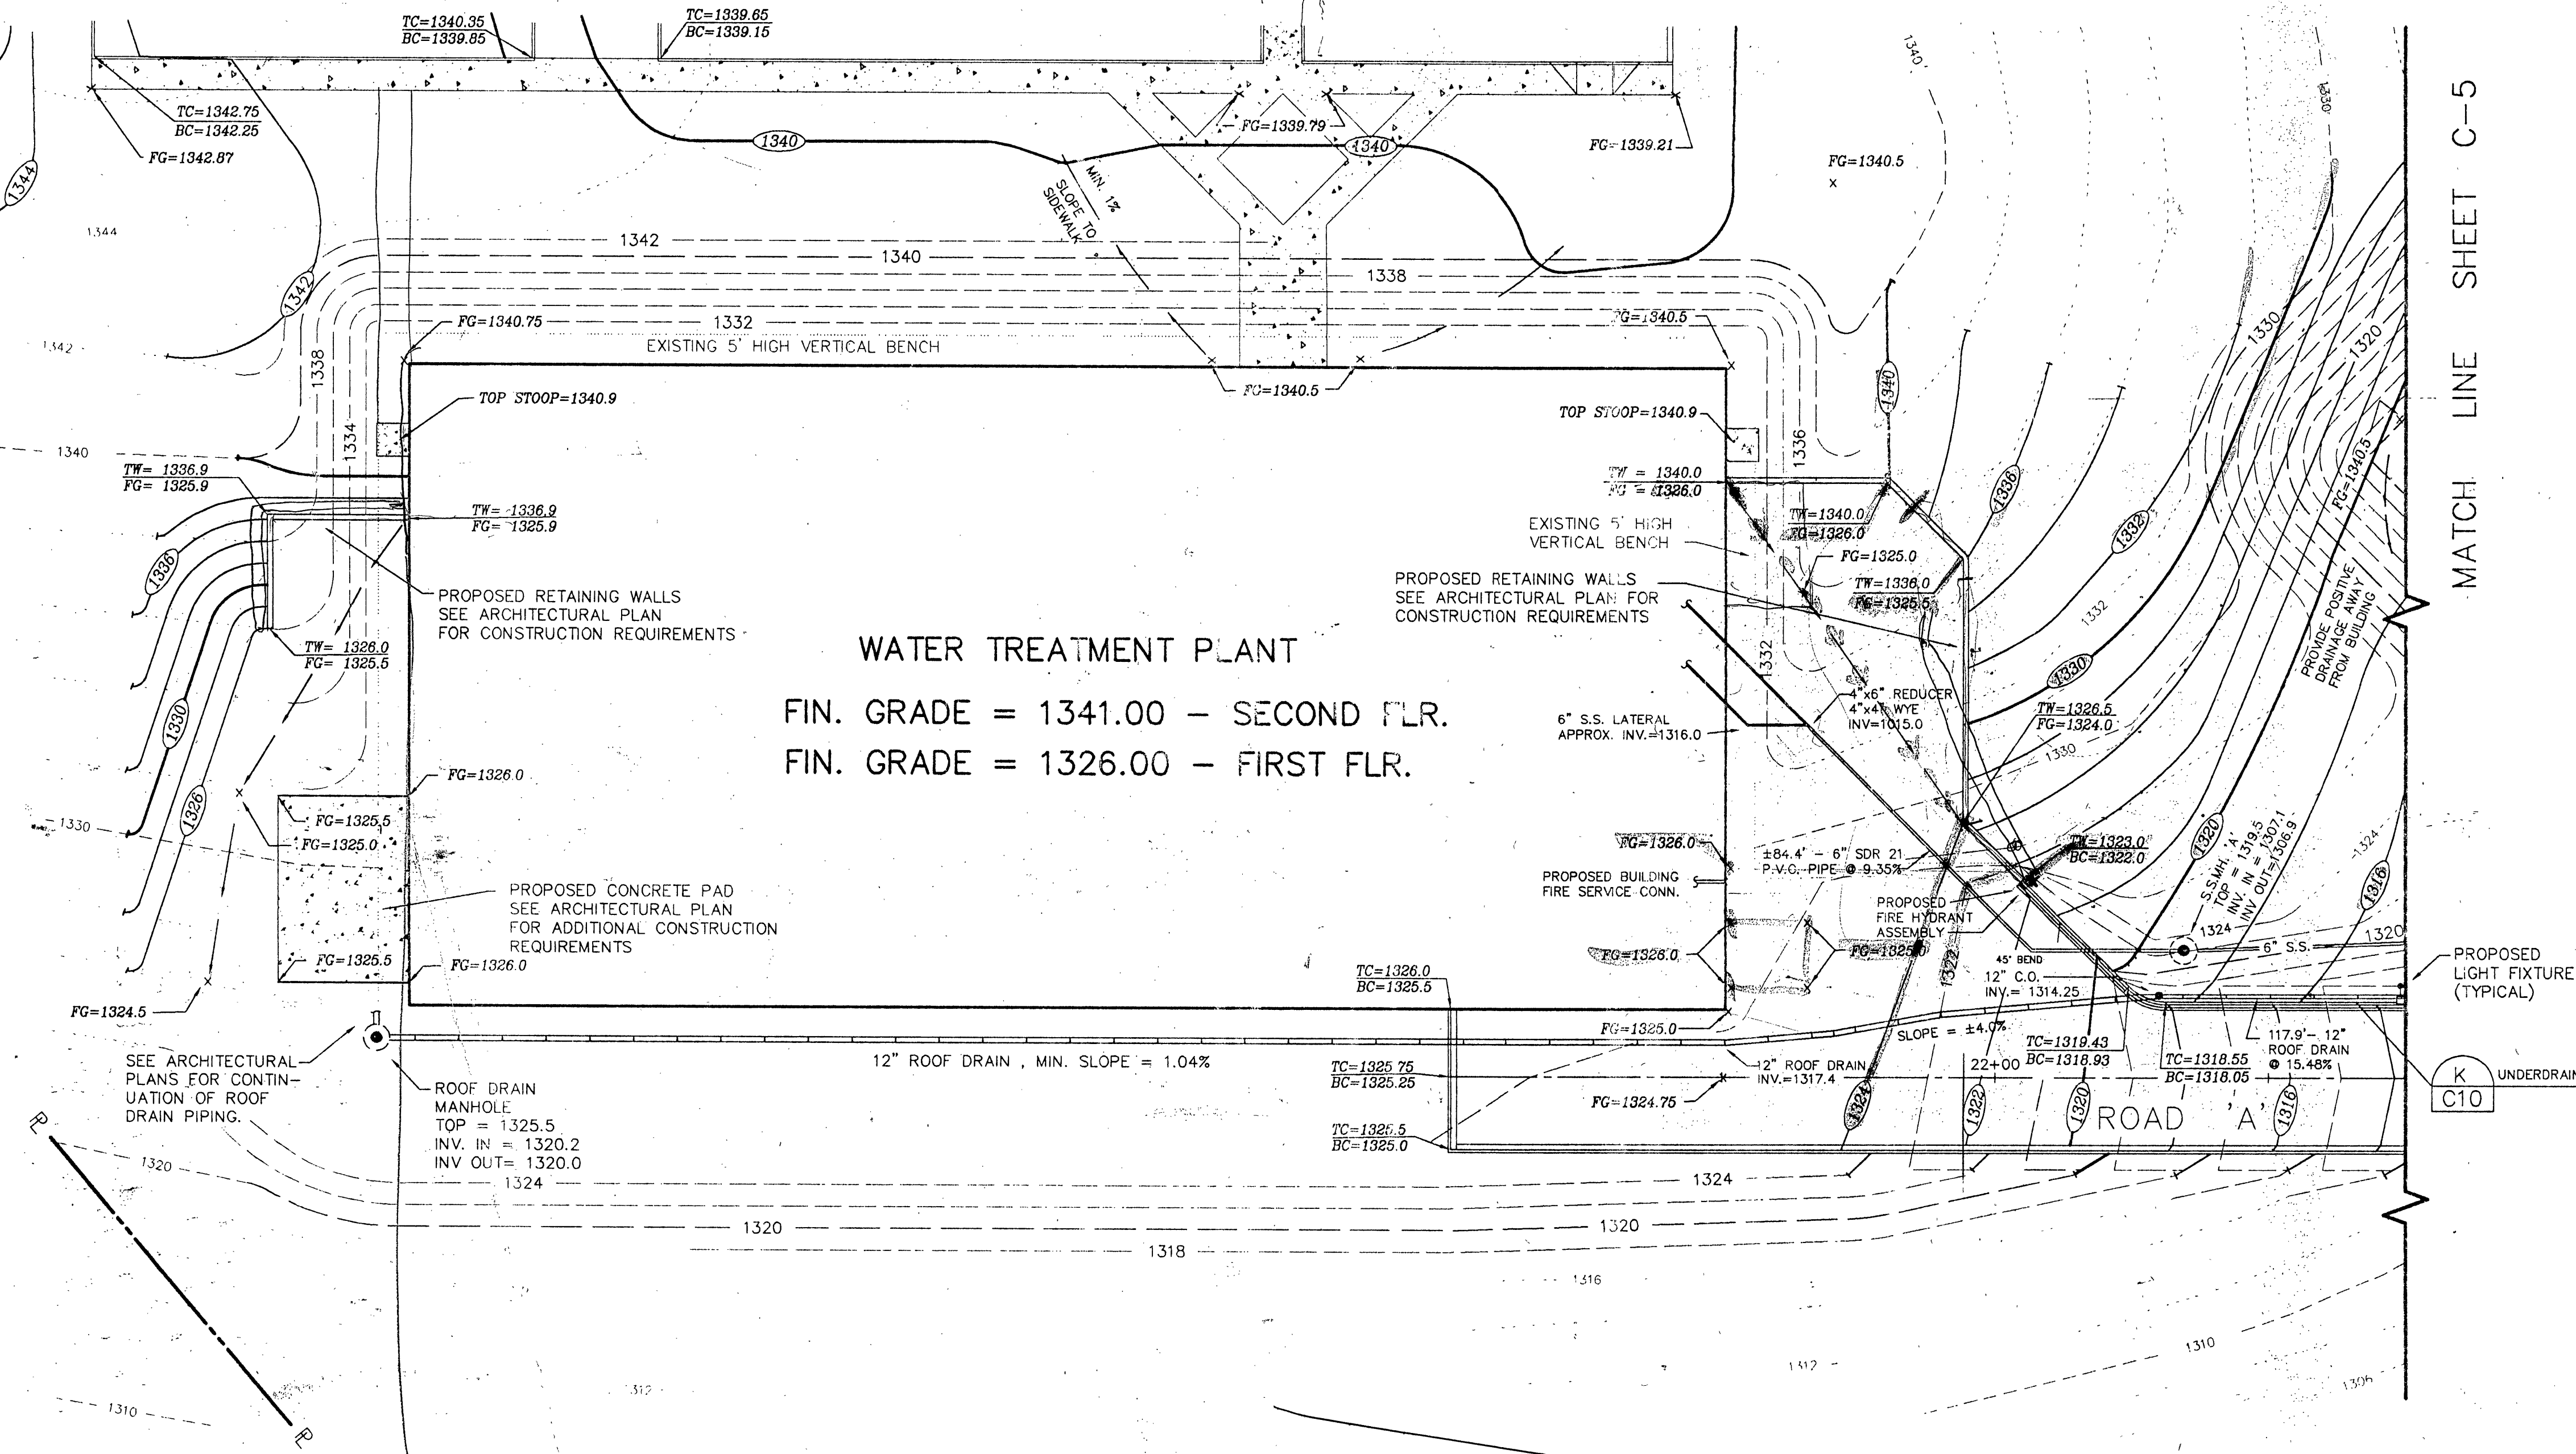

MATCH LINE SHEET C-5


1.3"

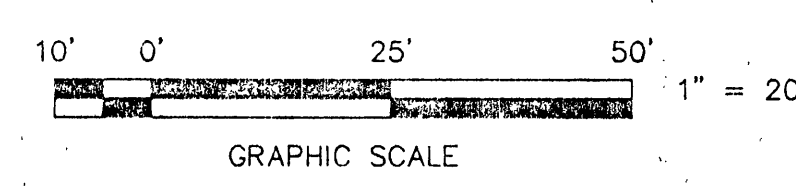

INSPECTOR'S AS-BUILTS 1995


WVWA ID# 8LDLZ

REVISED 9-22-94, per Roanoke County Utility Department

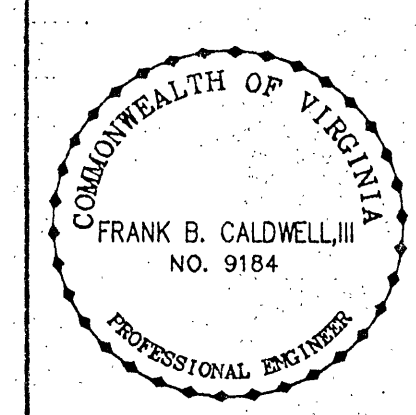

GRADING PLAN FOR
**ROANOKE COUNTY
 WATER TREATMENT
 FACILITY**
 FOR
 ROANOKE COUNTY BOARD OF SUPERVISORS
 SITUATE U.S. ROUTES 11 & 460
 COUNTY OF ROANOKE, VIRGINIA

DESIGNED BY J.V. JUDY
 DRAWN BY JJ/JB/CADD
 CHECKED BY F.B.C.
 W.O. # 92-1085
 N.B. G-94
 DATE MAR. 14, 1994

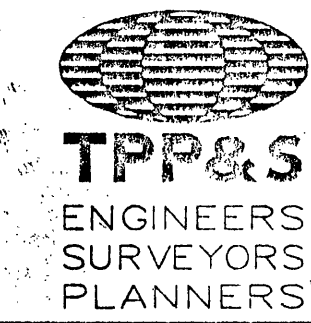

T. P. PARKER & SON
 816 Boulevard
 Post Office Box 39
 Salem, Virginia 24153
 Telephone: 703-987-1153
 FAX: 703-389-5767