


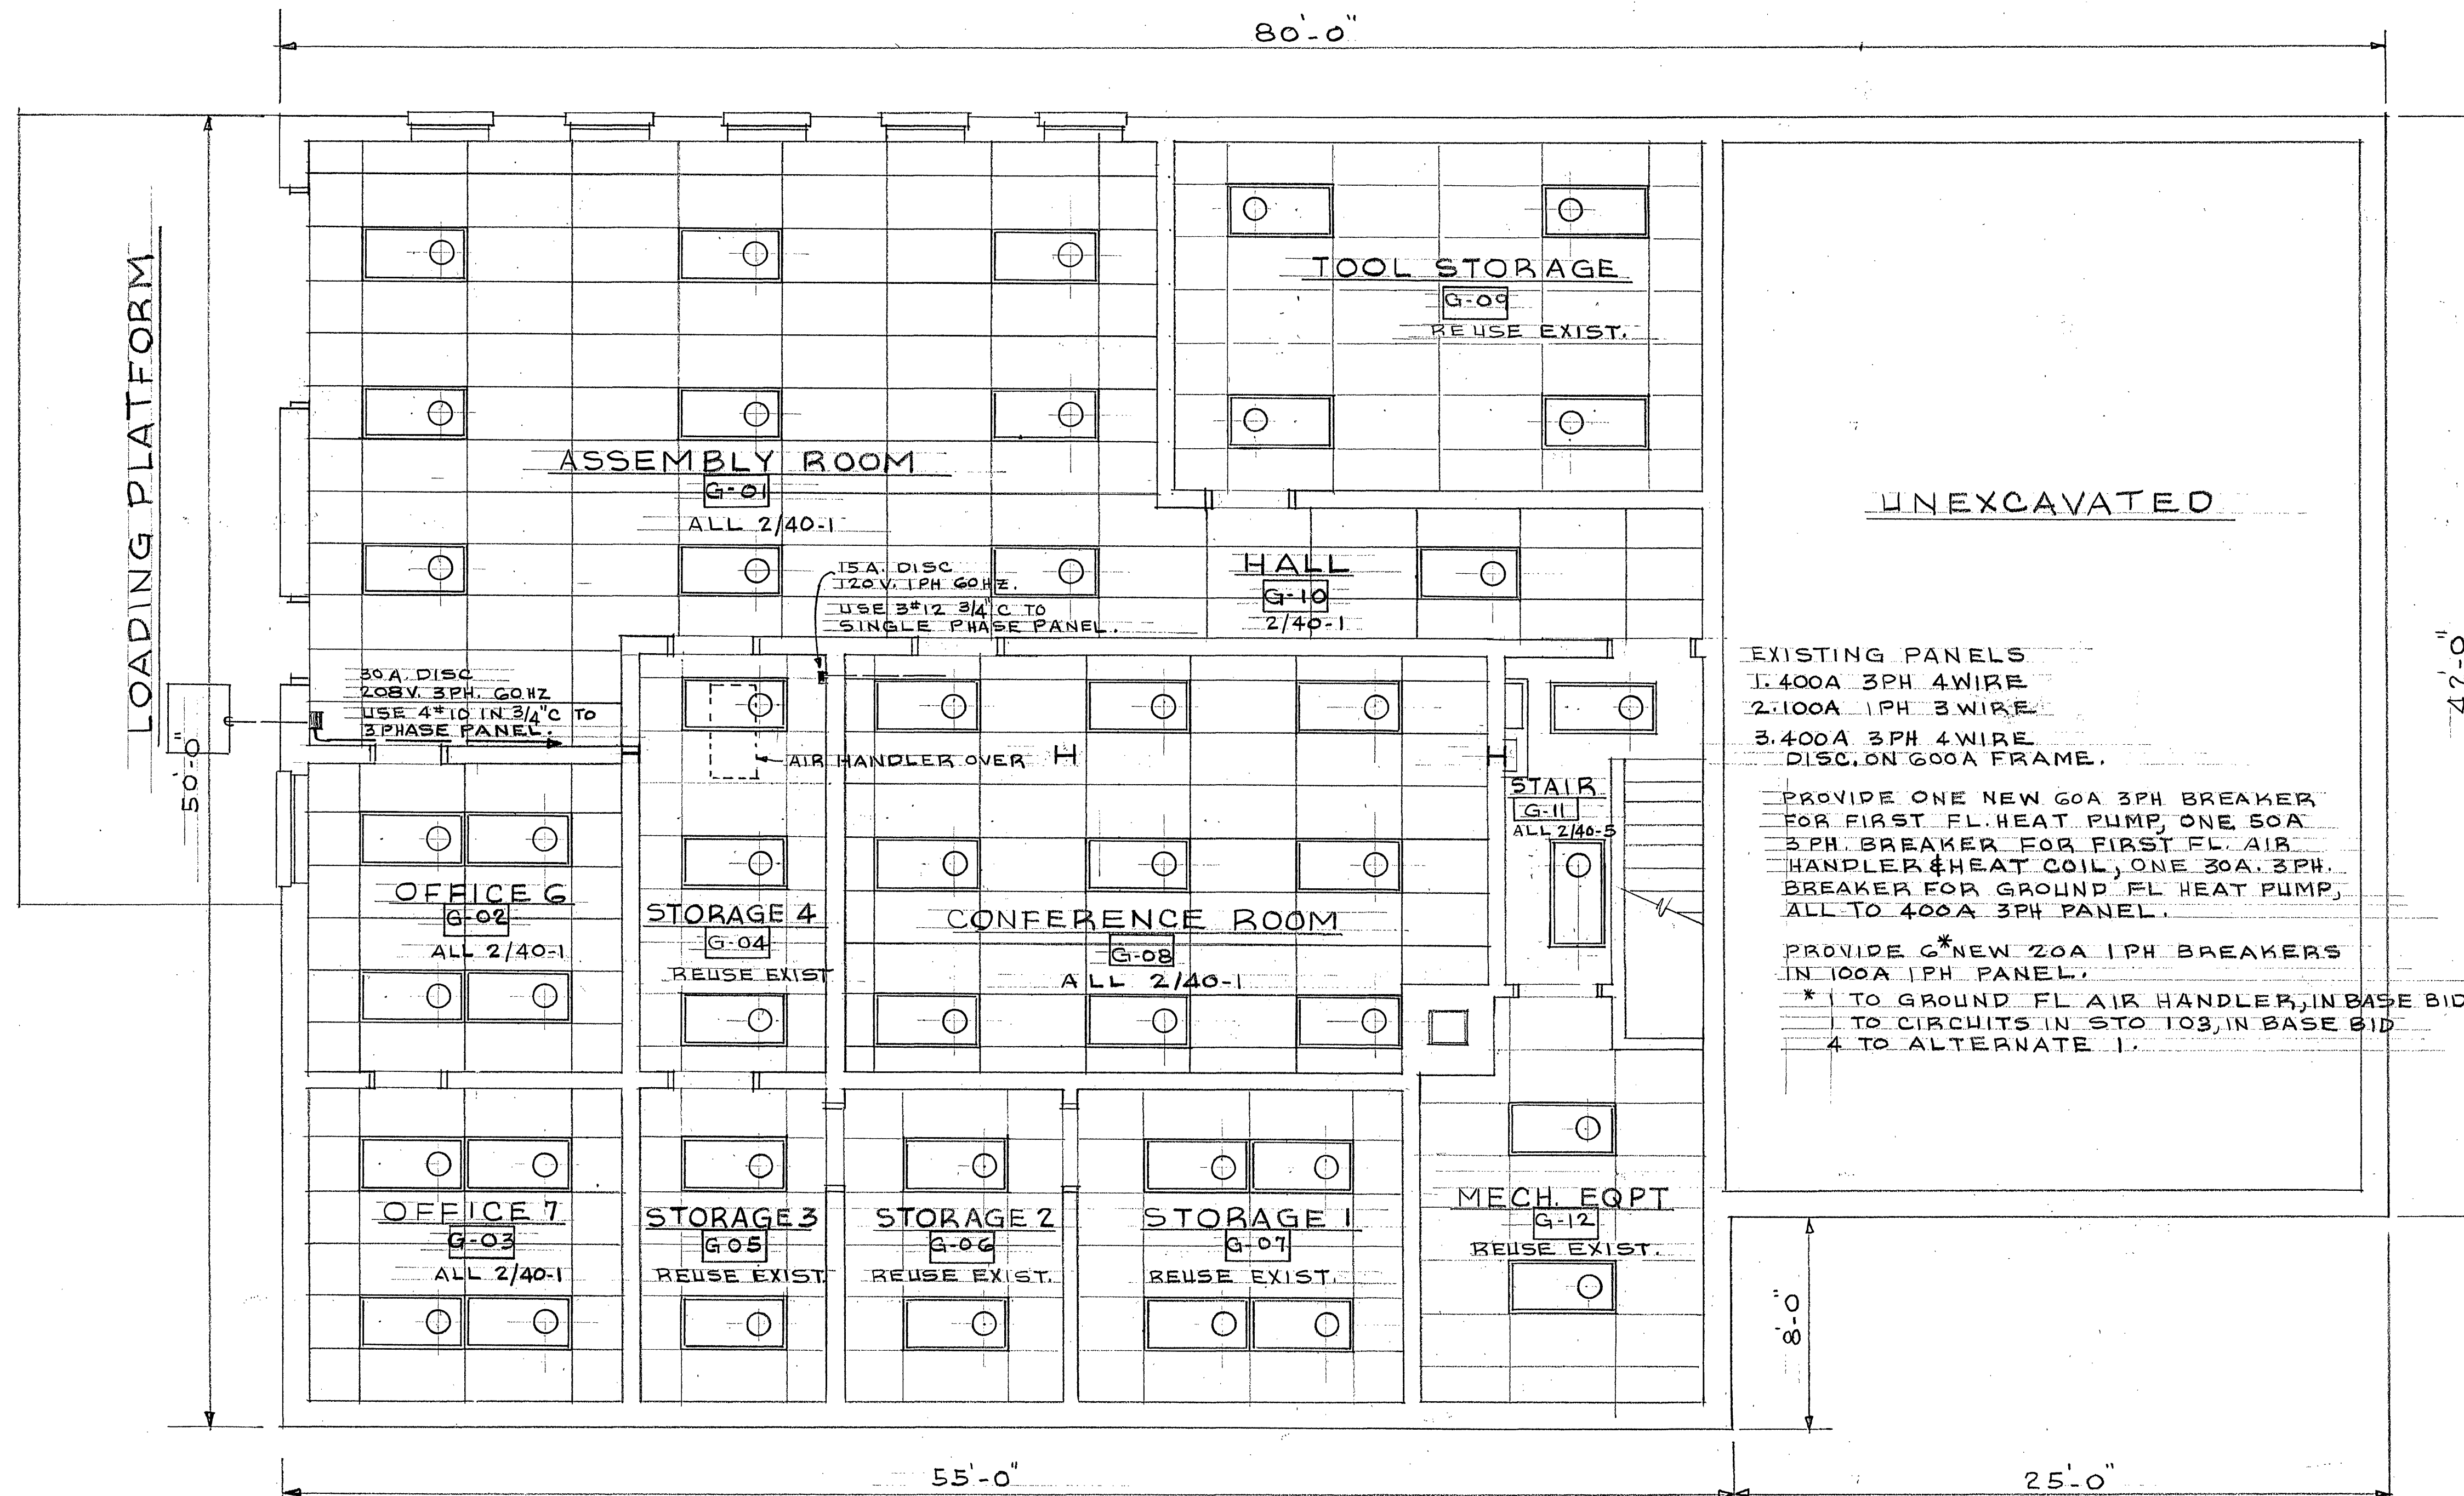

GROUND FLOOR PLAN

SCALE: 1/4" = 1'-0"

REFLECTED CEILING PLAN

NEW CEILING REQUIRED IN ROOMS G-01, G-02, G-03, G-08 & G-10 ONLY. OTHER ROOM LAYOUTS SHOWN FOR FUTURE CEILINGS.
REUSE EXISTING FLUORESCENT FIXTURES FROM GROUND & FIRST FLOOR LEVELS IN ROOMS G-04, G-05, G-06, G-07, G-09; USE WITH TWO TUBES ONLY.

EXISTING PANELS
1. 400A 3PH 4WIRE
2. 100A 1PH 3WIRE
3. 400A 3PH 4WIRE
DISC. ON 600A FRAME.
PROVIDE ONE NEW 60A 3PH BREAKER FOR FIRST FL. HEAT PUMP, ONE 50A 3PH BREAKER FOR FIRST FL. AIR HANDLER & HEAT COIL, ONE 30A 3PH BREAKER FOR GROUND FL. HEAT PUMP, ALL TO 400A 3PH PANEL.
PROVIDE 6* NEW 20A 1PH BREAKERS IN 100A 1PH PANEL.
* TO GROUND FL. AIR HANDLER, IN BASE BID TO CIRCUITS IN STO 103, IN BASE BID 4 TO ALTERNATE 1.

DATE	REV.	DESCRIPTION	BY
5/15/85		ALTERATIONS & ADDITIONS	
		UTILITY LINES BUILDING	
		3447 READ ROAD, N.E.	
		ROANOKE, VIRGINIA	
			5-14-85
			11-85A
			E-1