


0001a2 JOB# 00001 ler 2/18/00 PLOT SCALE: XREF(S): 0001b1

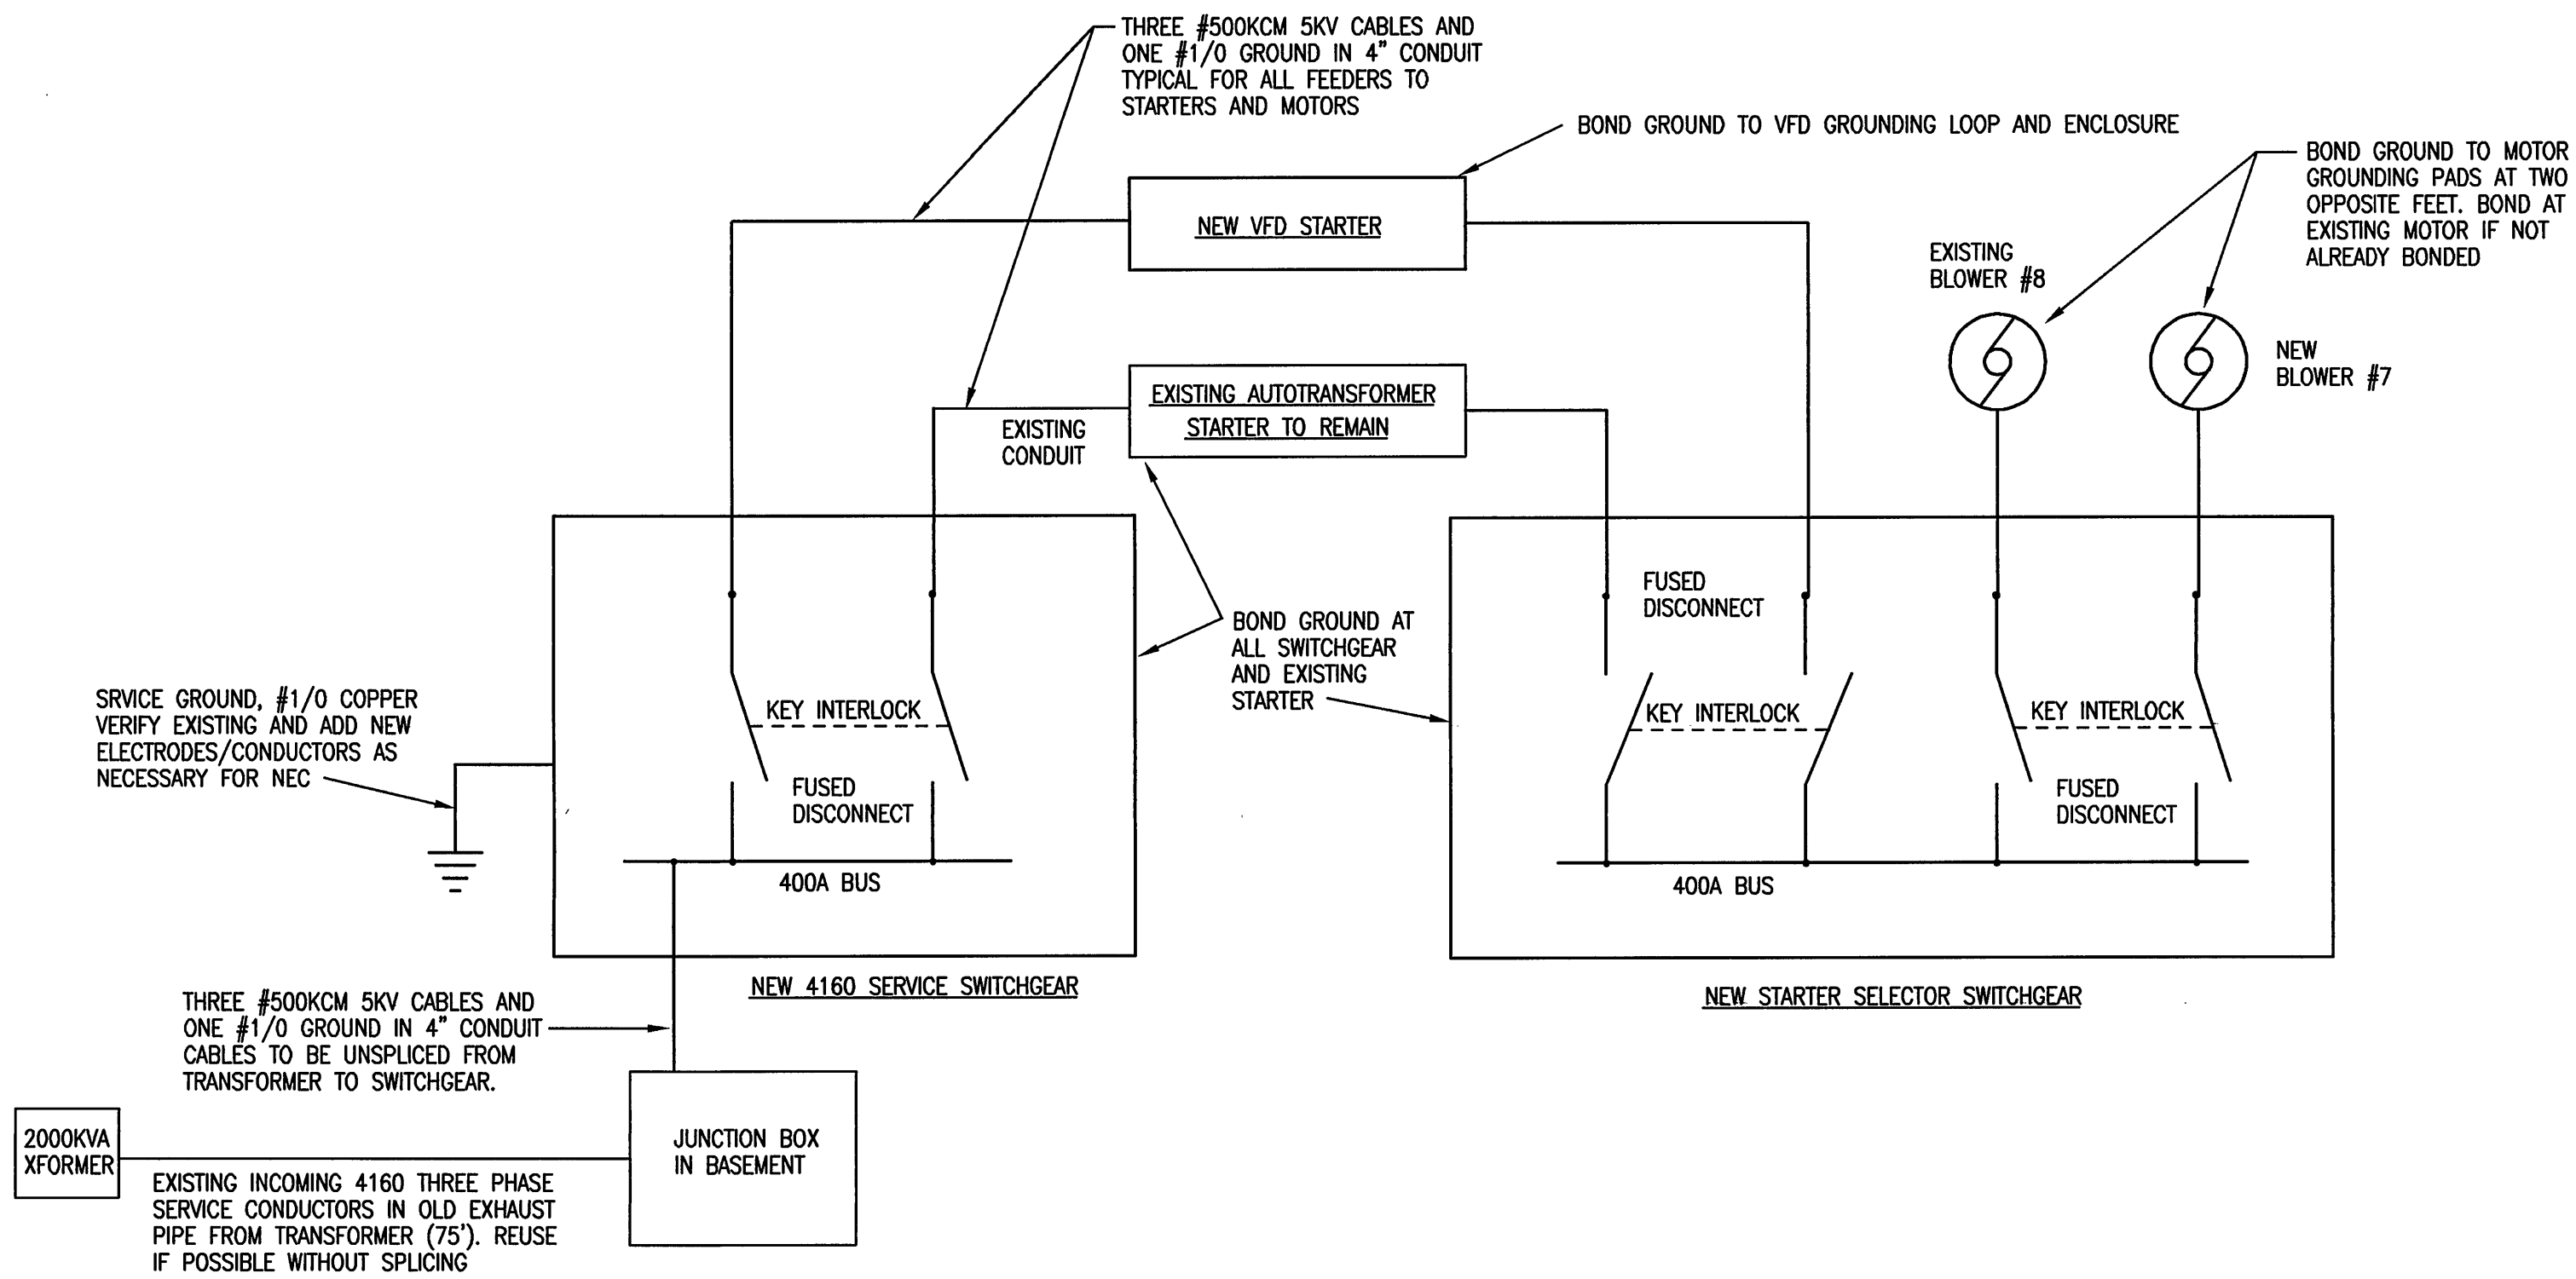


ONE-LINE DIAGRAM - MEDIUM VOLTAGE BLOWER EQUIPMENT

SCHEMATIC

KEY PLAN

GENERAL NOTES

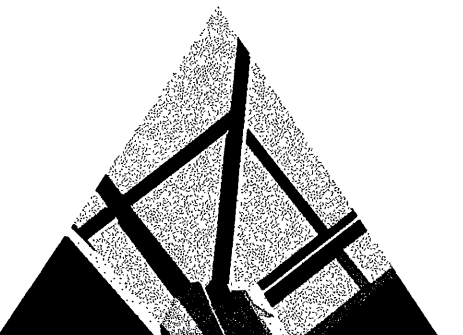


SPECTRUM DESIGN

325 MOUNTAIN AVENUE ROANOKE, VIRGINIA 24016 540.345.8020
ROANOKE • MARION • VIRGINIA BEACH

ROANOKE SEWAGE
TREATMENT PLANT

BLOWER
ROOM
RENOVATION

SPECTRUM DESIGN PROJECT NO. 00001

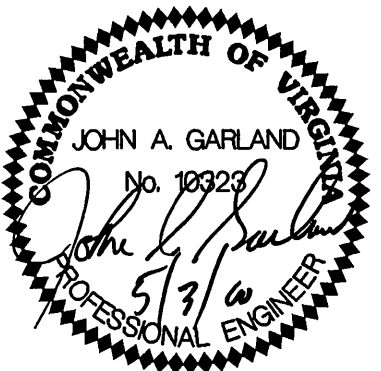

DATE 28 APRIL 2000
DESIGN ARCHITECT
PROJECT ARCHITECT LER
PROJECT ENGINEER
CHECKED BY LER
DRAWN BY
REVISIONS NUMBER DATE

SHEET TITLE

BLOWER MOTOR
WIRING DIAGRAM

E-2.2