



PART PLAN OF PUMP ROOM & GALLERY

Scale: $\frac{1}{8}'' = 1'-0''$

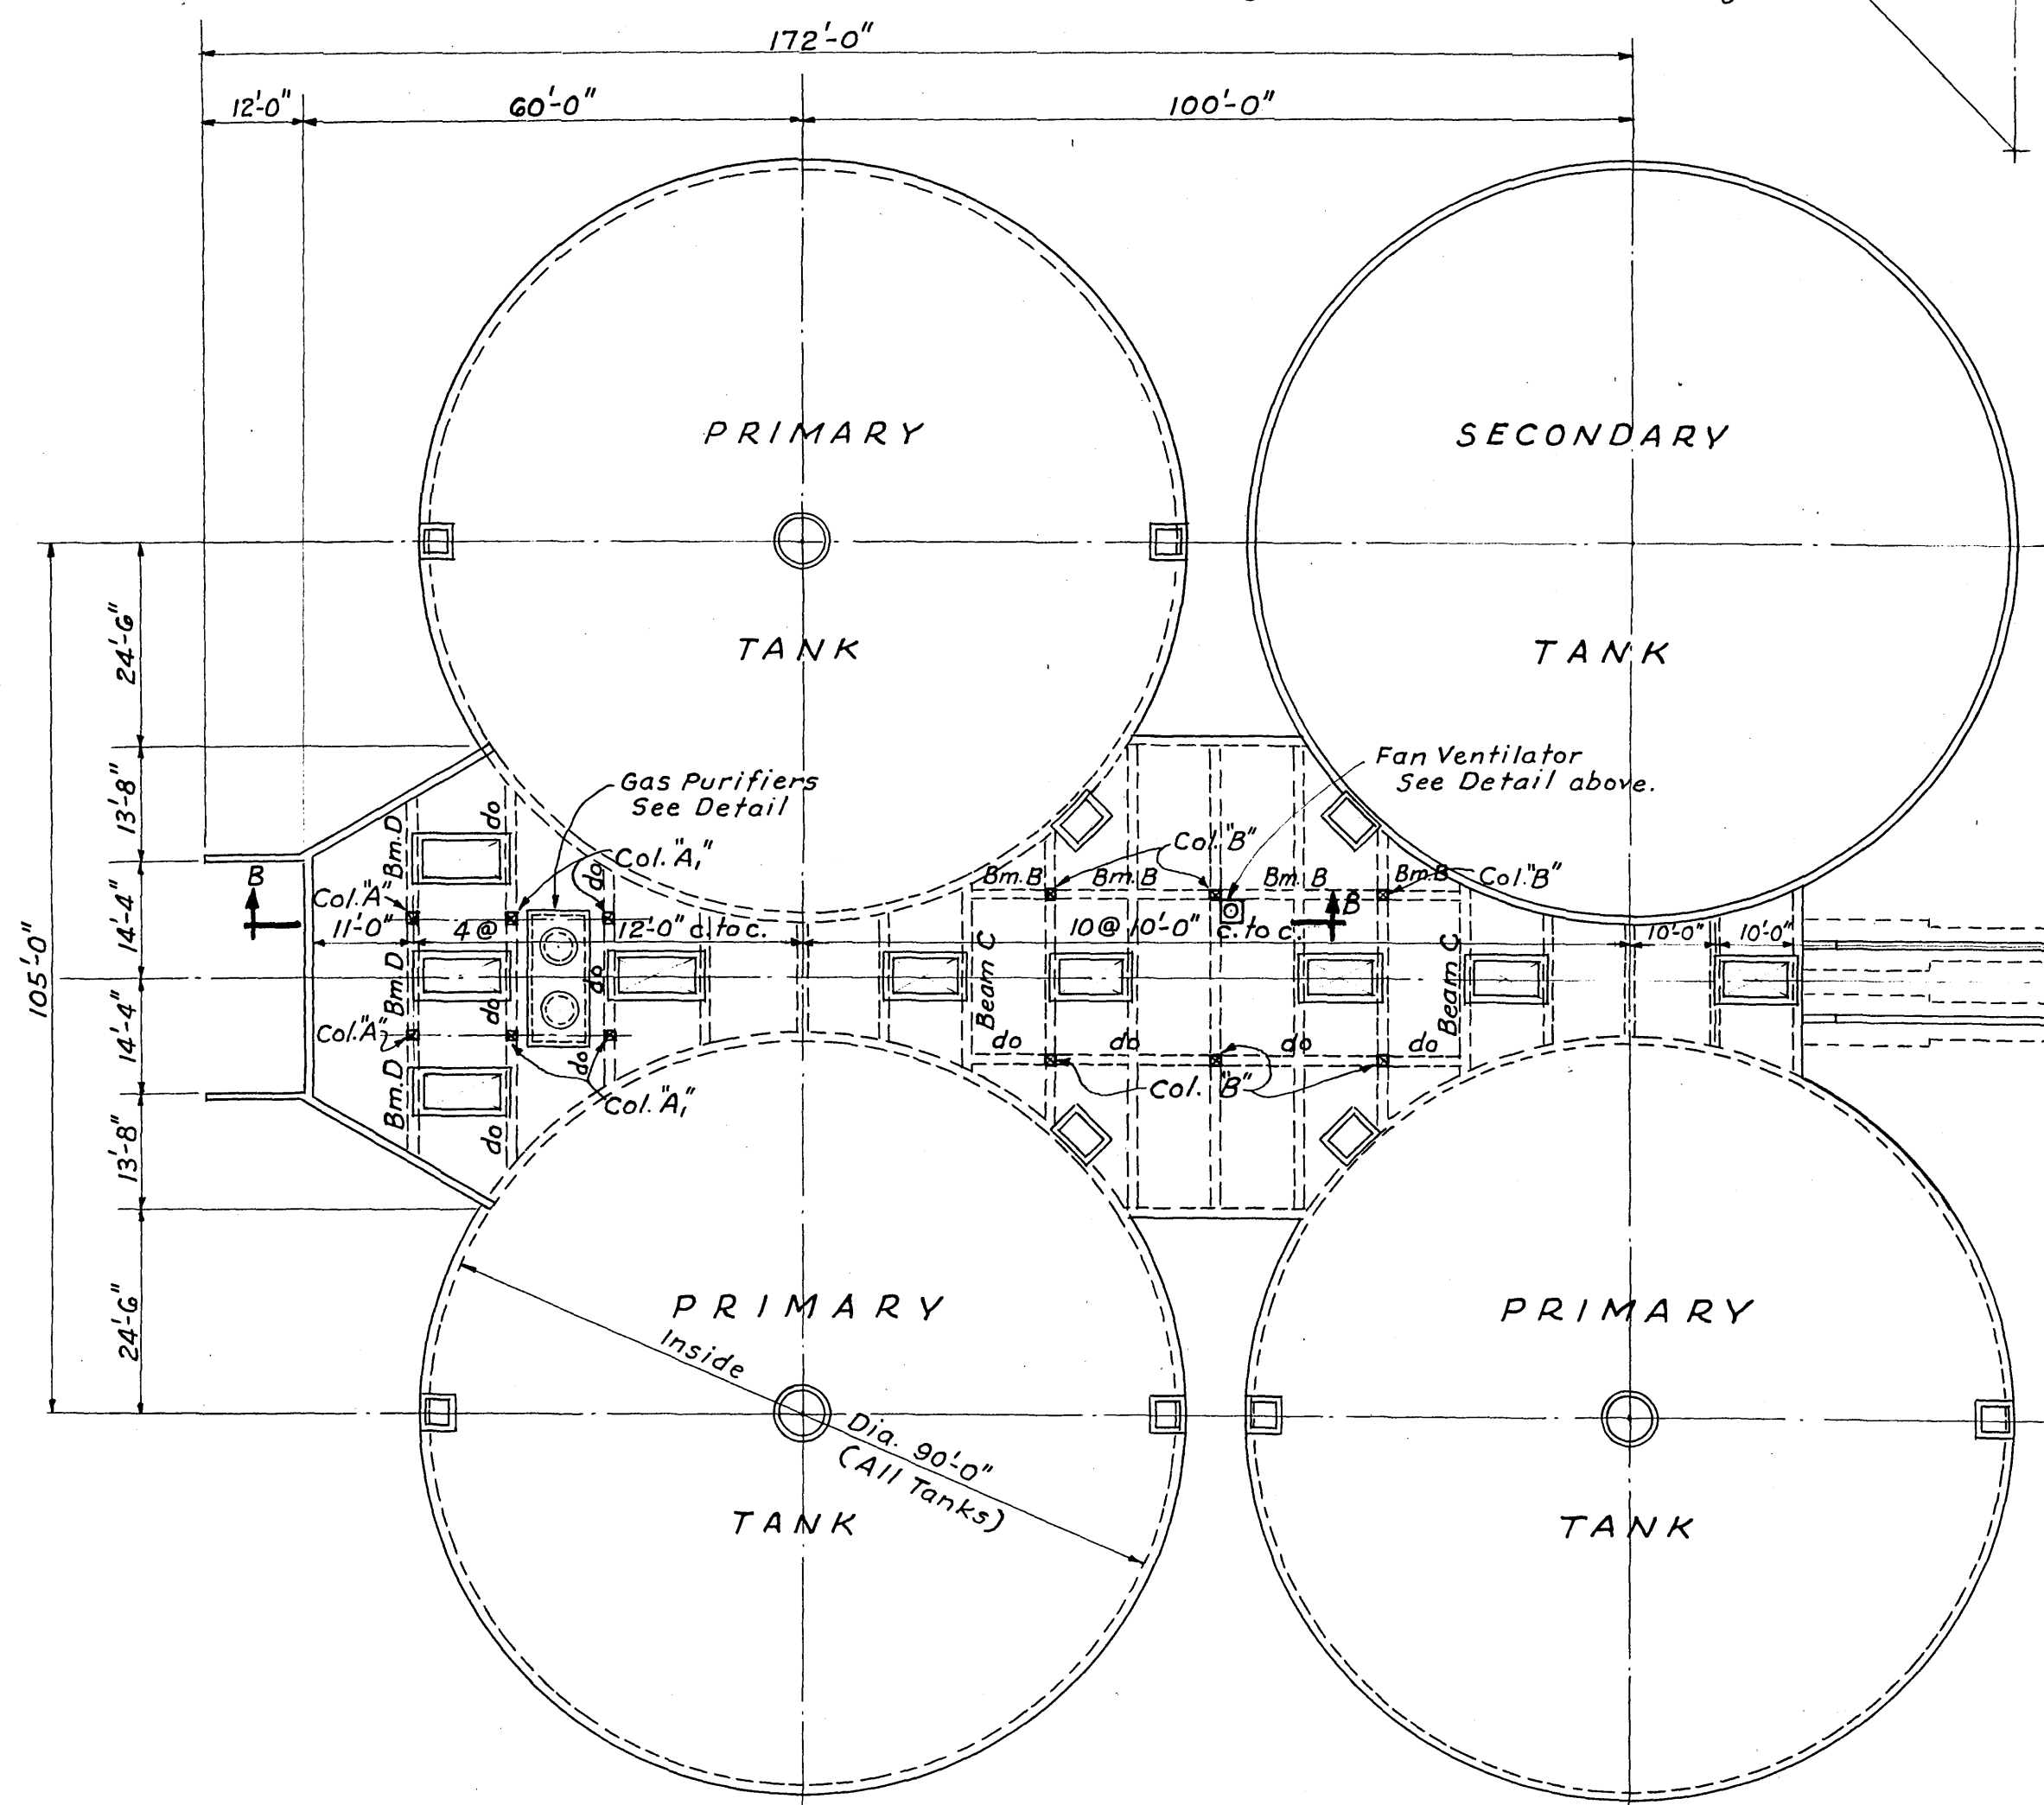


ROOF PLAN OF DIGESTION TANKS

Scale: $1'' = 20'-0''$

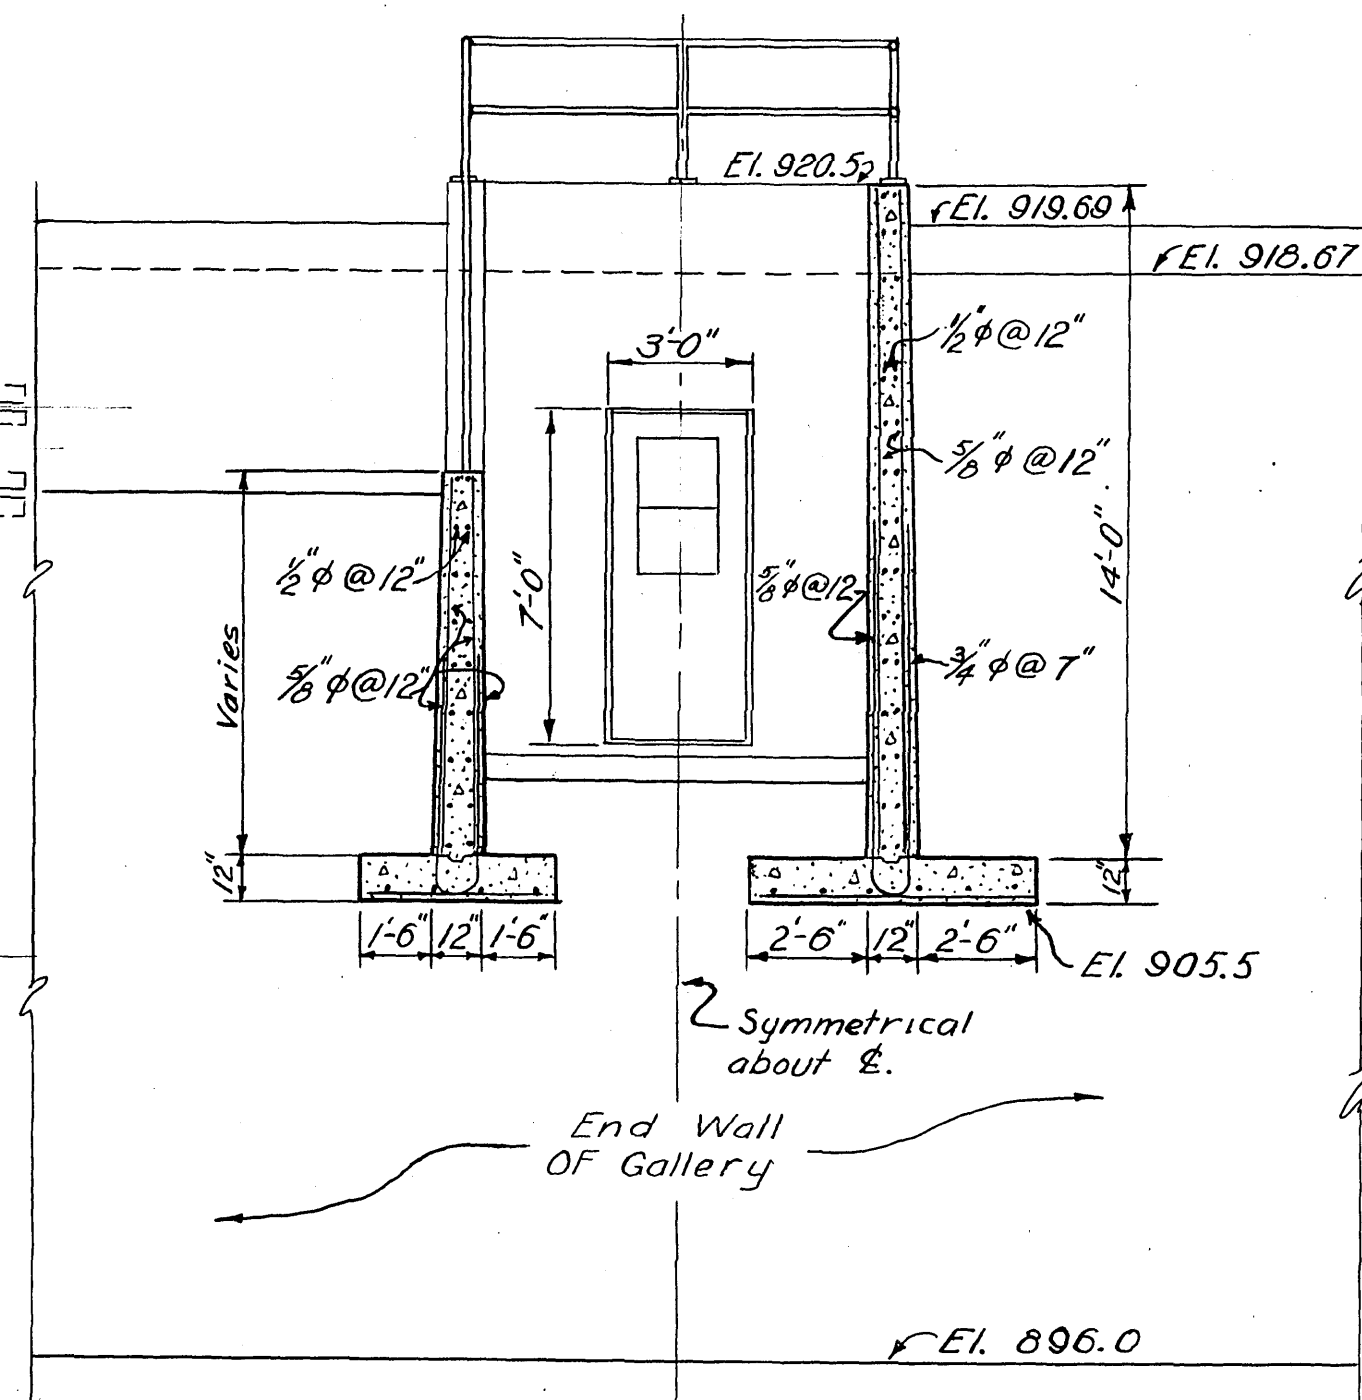

SECTION G-G

Scale: $\frac{1}{4}'' = 1'-0''$

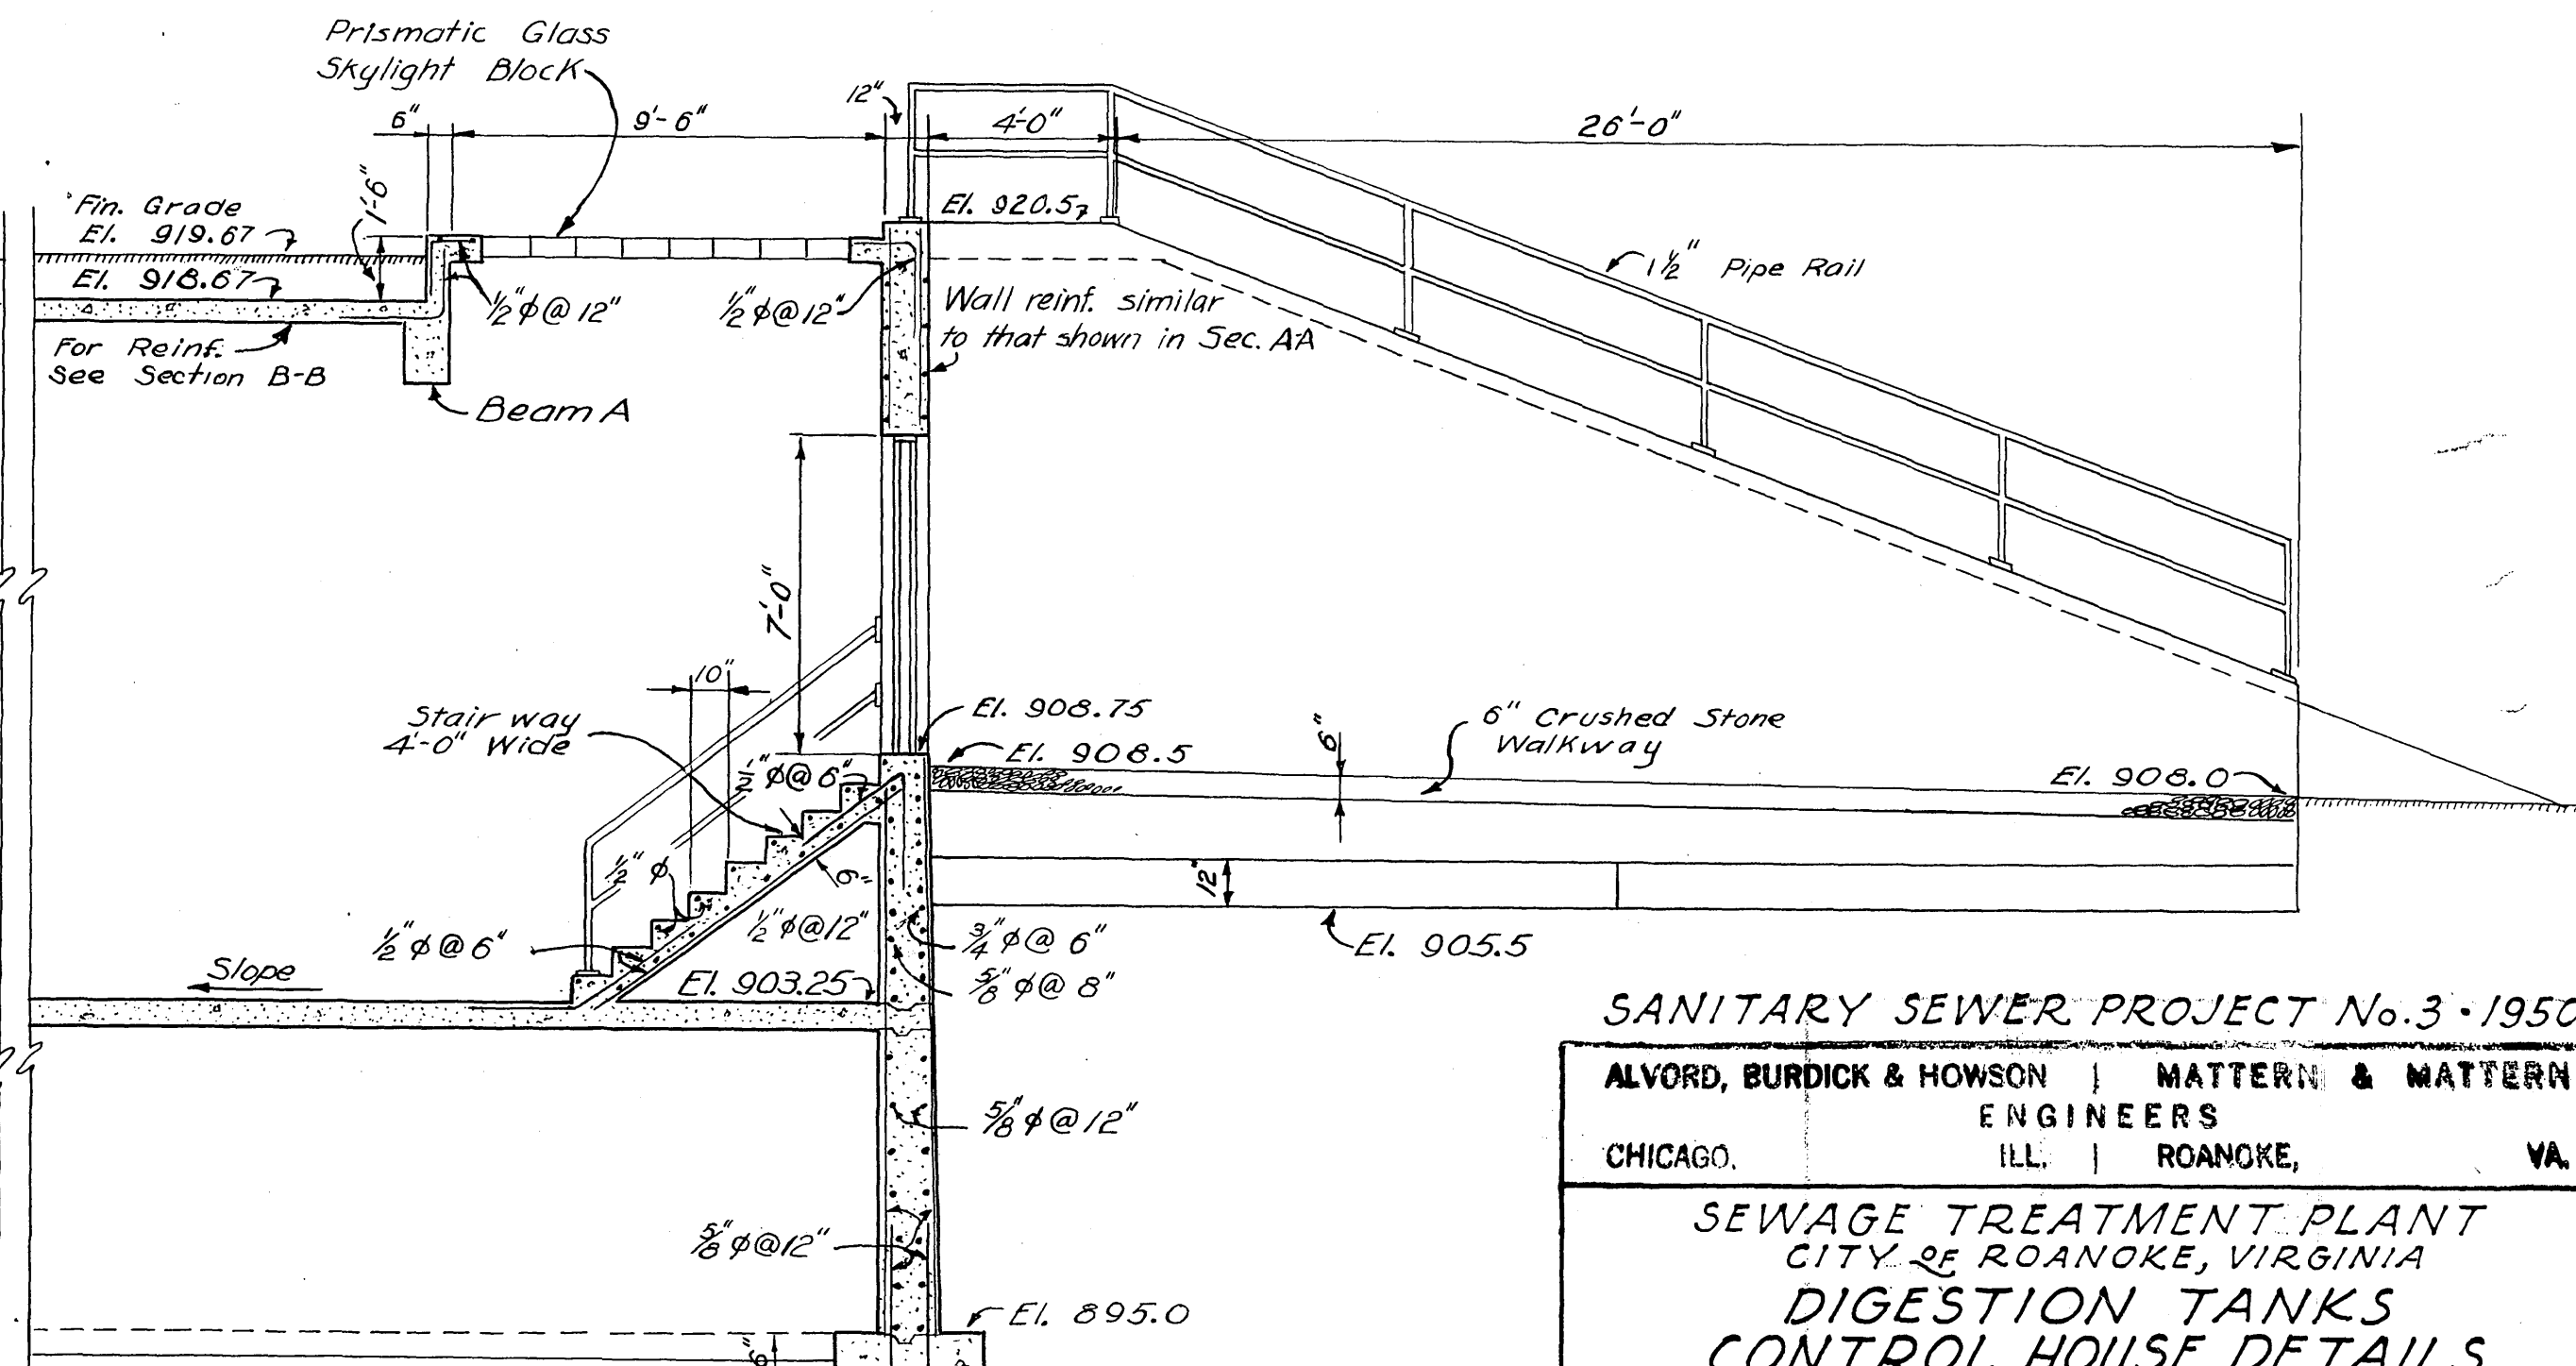

SECTION F-F

Scale: $\frac{1}{4}'' = 1'-0''$

Notes:
For Typical Corner Details and
Construction Joints see Sheet No. 37.
For Existing Ground and Finished
Grade elevations see Sheet No. 1.

SANITARY SEWER PROJECT No. 3-1950			
ALVORD, BURDICK & HOWSON		MATTERN & MATTERN	
ENGINEERS		ENGINEERS	
CHICAGO, ILL.	CHICAGO, ILL.	ROANOKE, VA.	ROANOKE, VA.
SEWAGE TREATMENT PLANT CITY OF ROANOKE, VIRGINIA DIGESTION TANKS CONTROL HOUSE DETAILS			
DESIGNED	D.J.M.	SCALE AS SHOWN	COM. NO.
DRAWN	G.J.R.	DATE AUGUST, 1950	39
CHECKED	G.J.R.		