
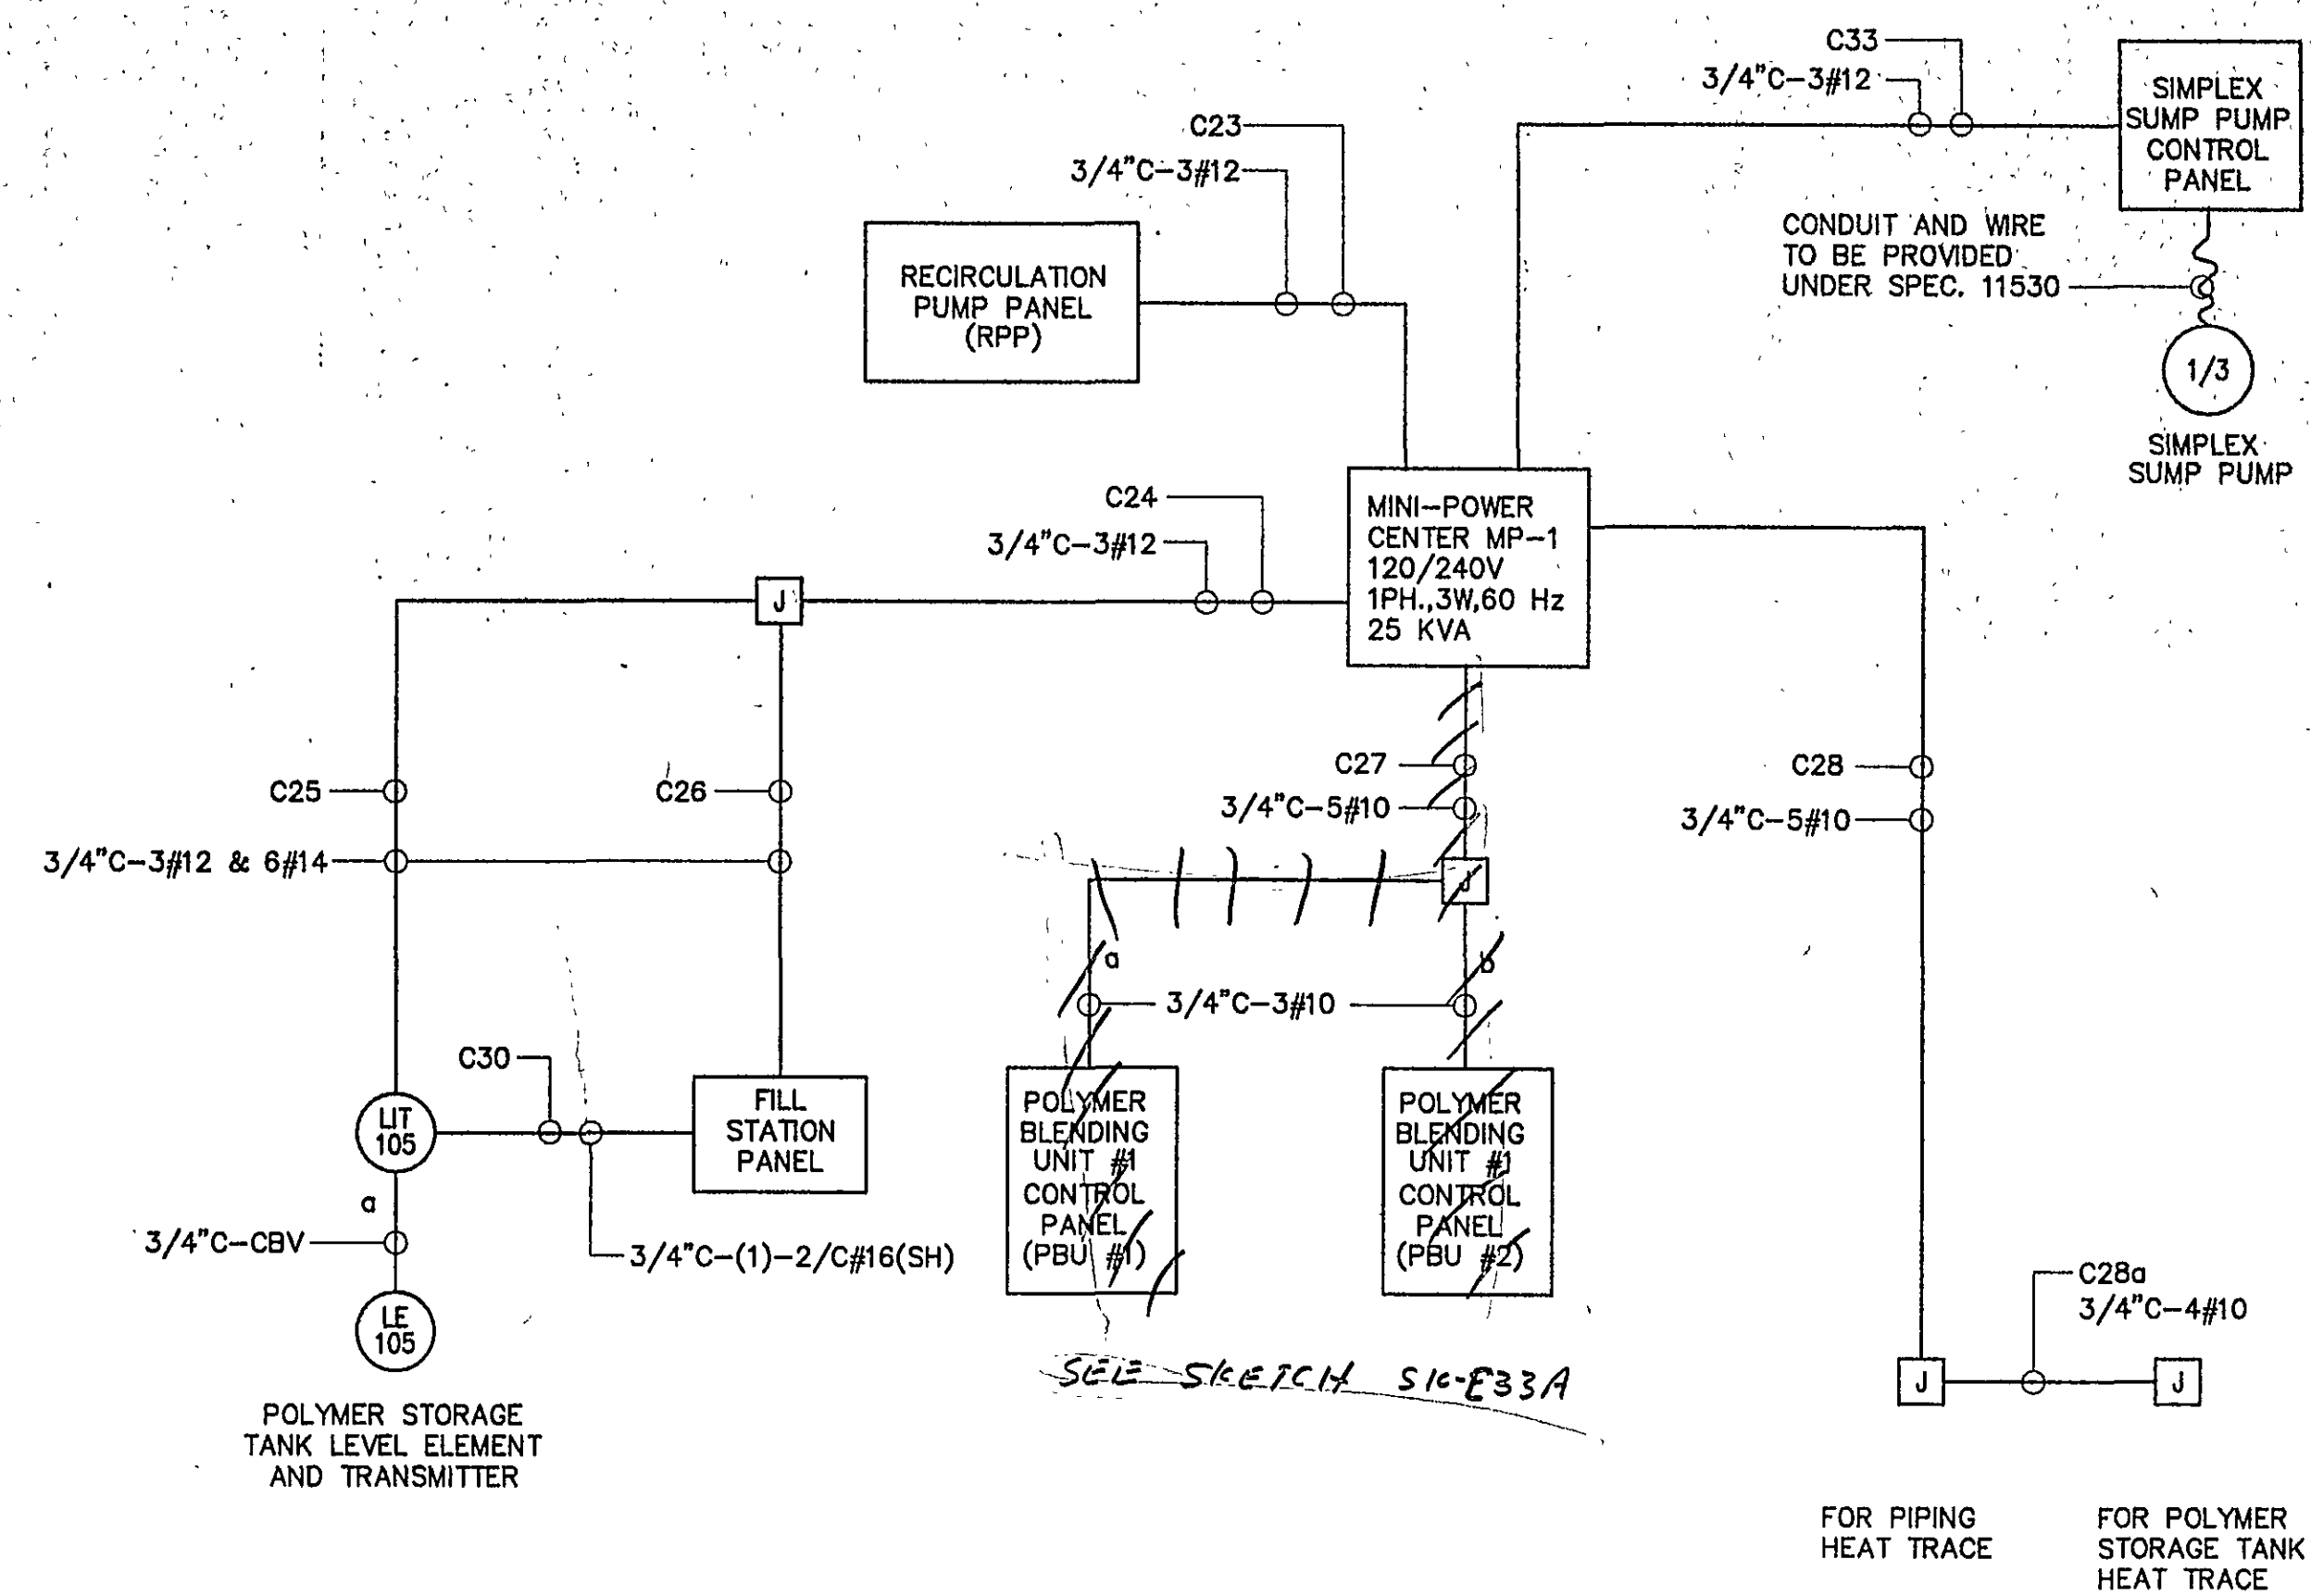
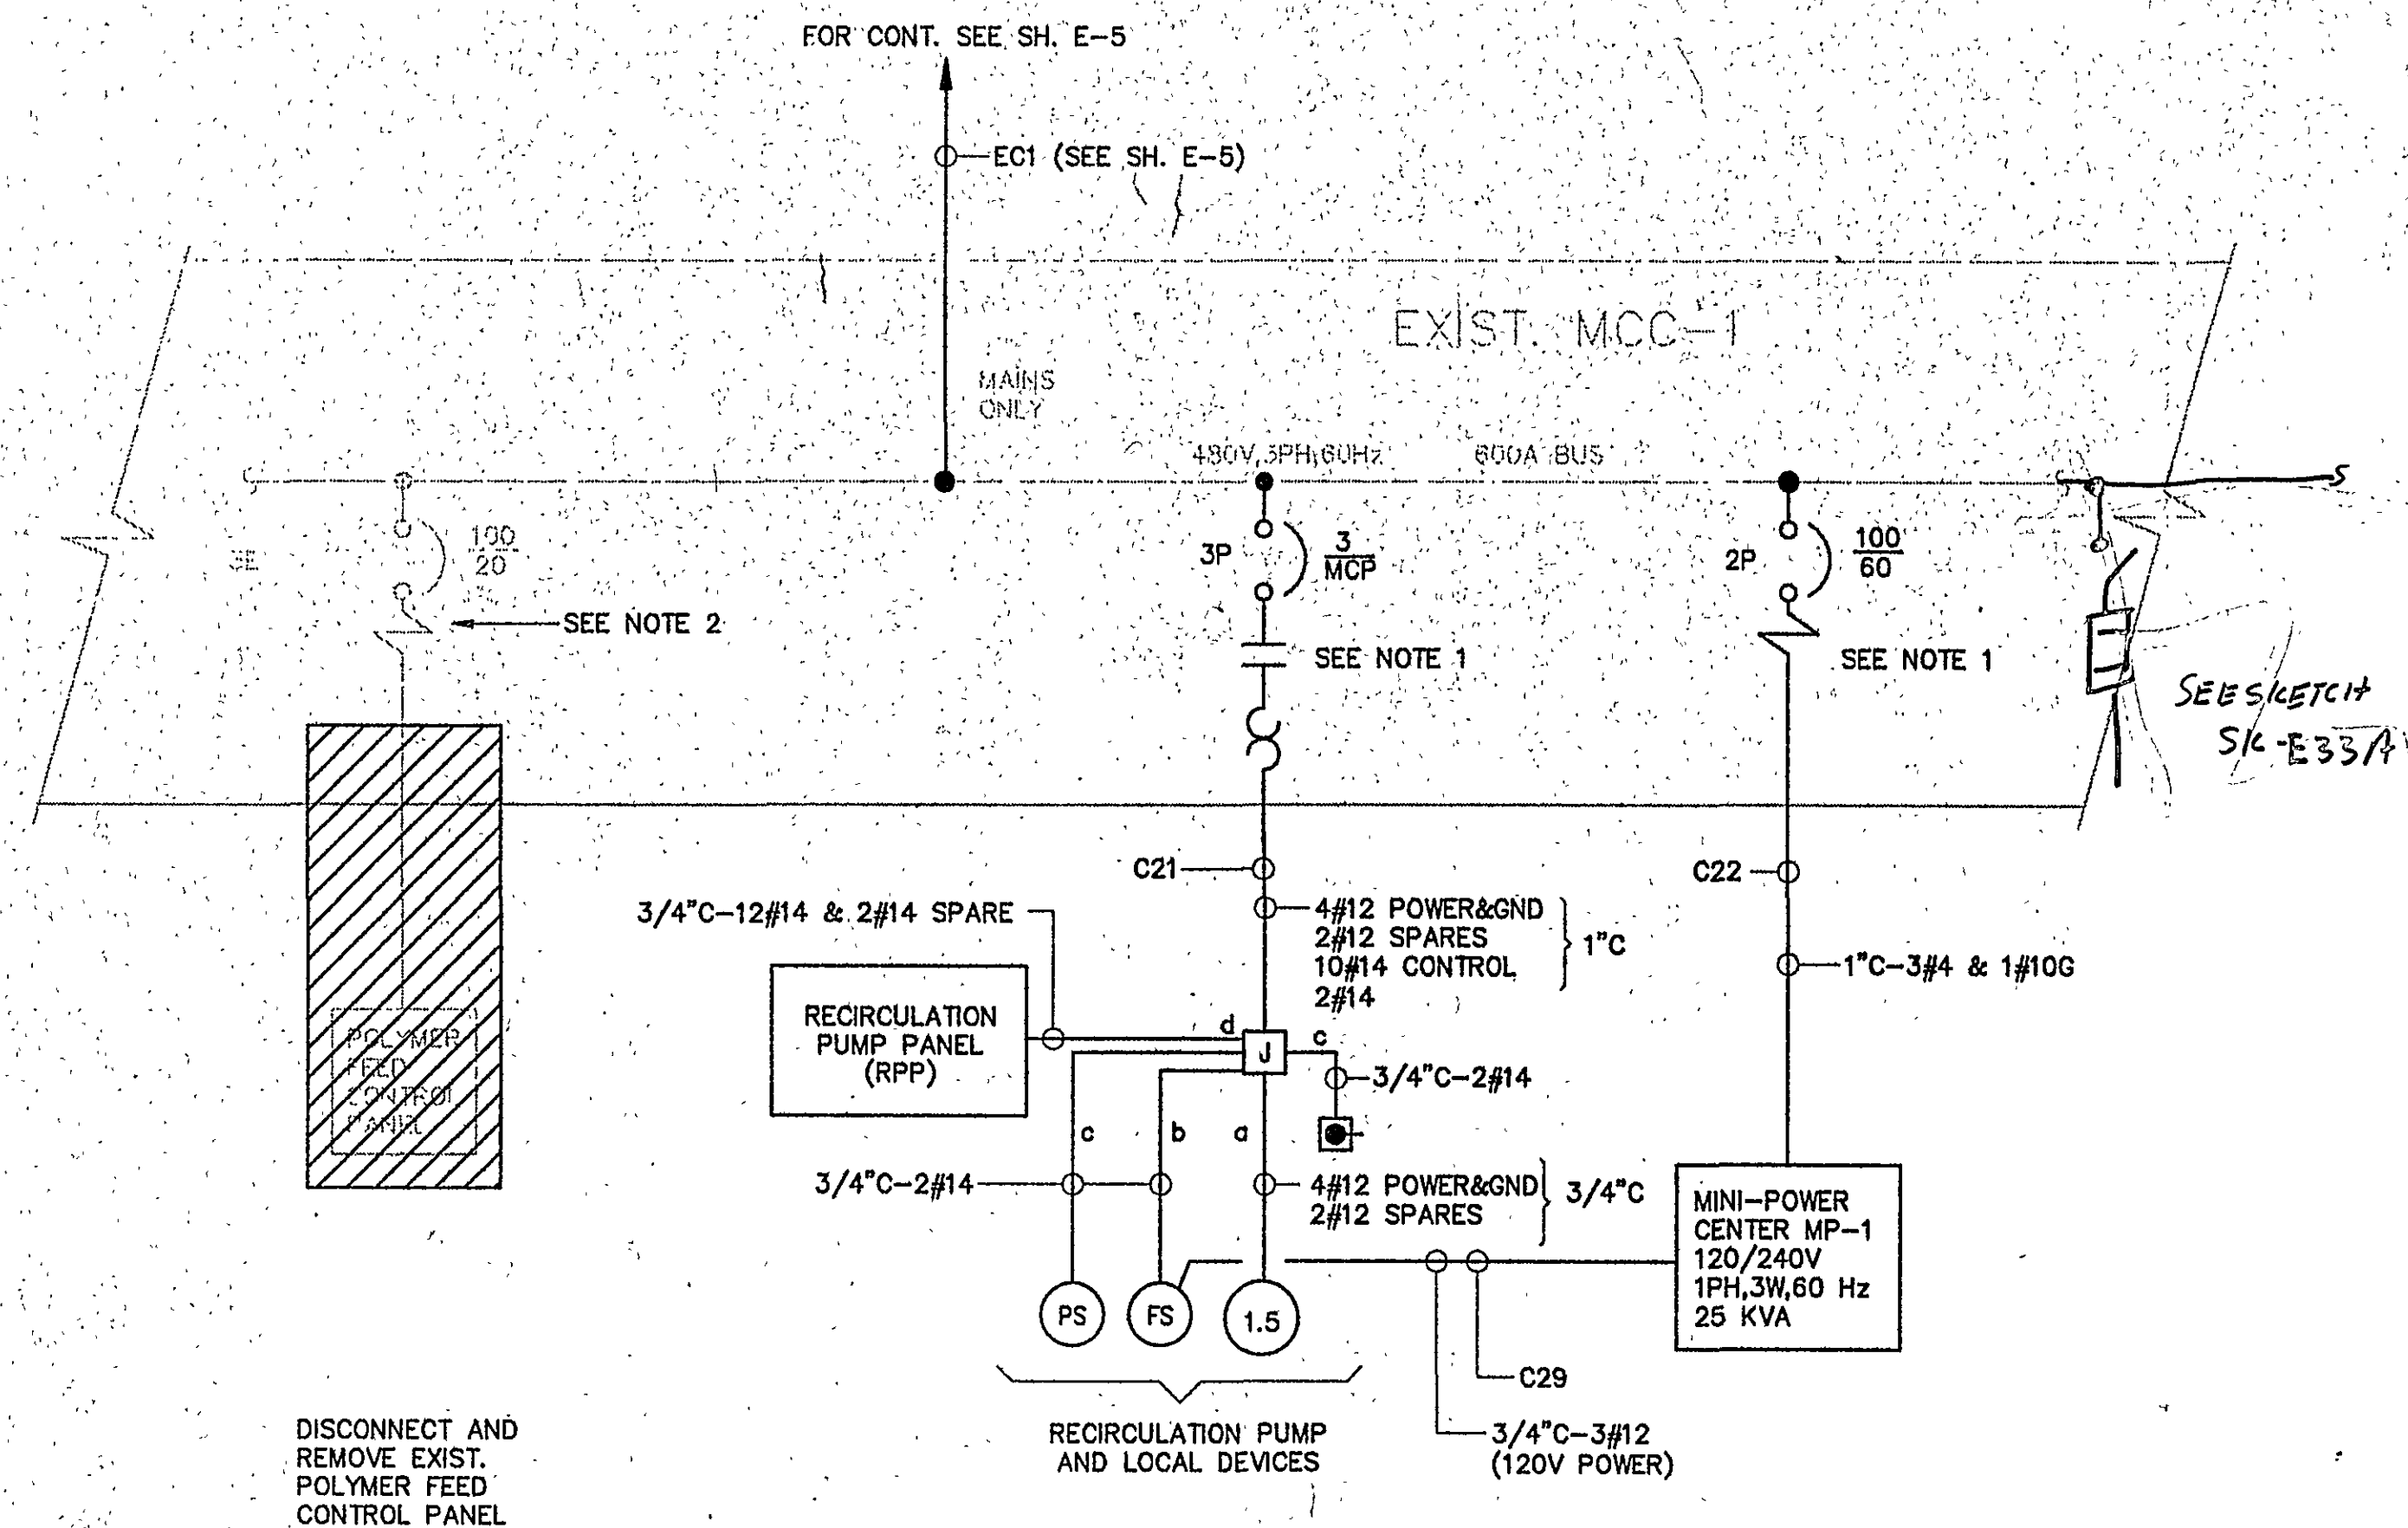
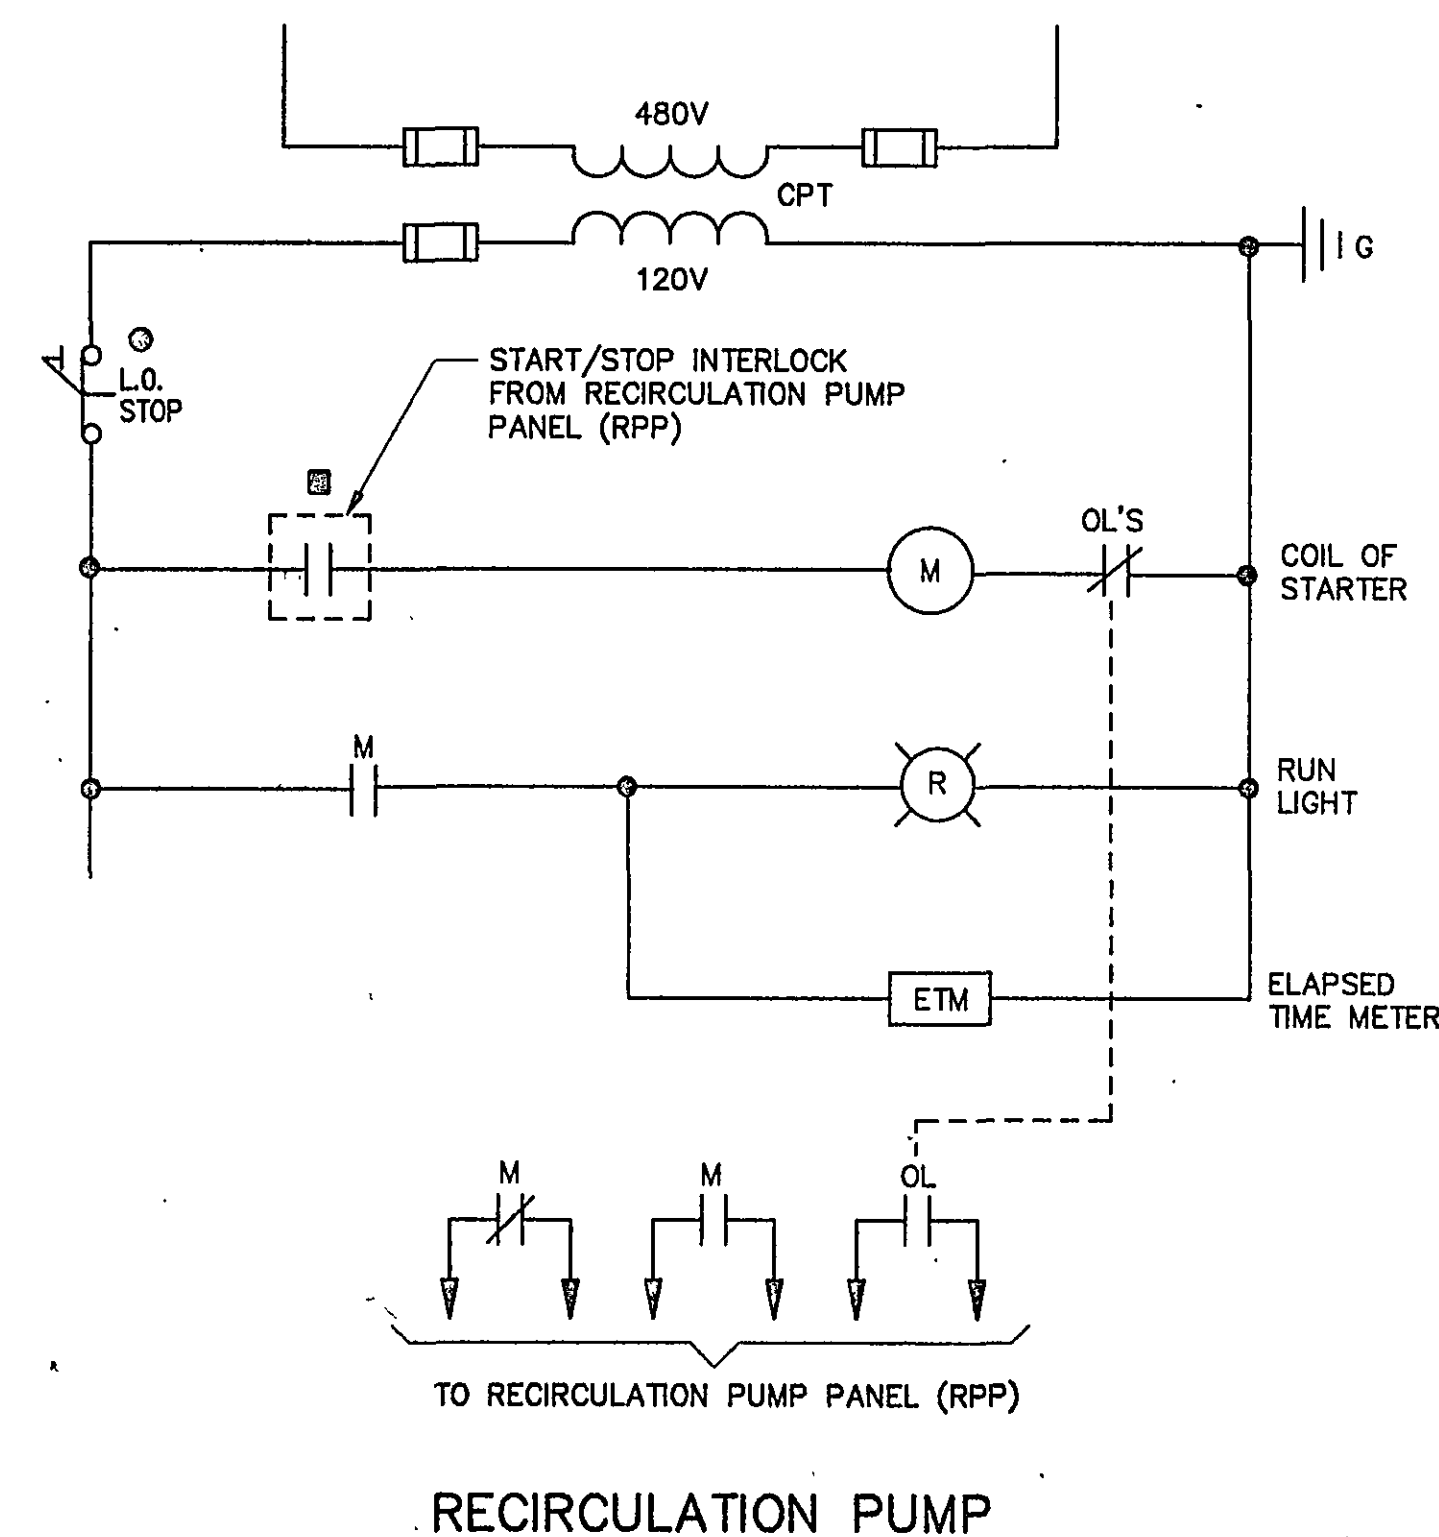


[illegible]

- NOTES:
1. INSTALL NEW COMBINATION STARTER AND CIRCUIT BREAKER IN EXISTING MCC-1 SPACE AS SHOWN ON MCC-1 ONE LINE DIAGRAM. PROVIDE NEW DOORS AND NAMEPLATES.
 2. DISCONNECT AND REMOVE CONDUIT AND WIRING FROM MCC-1 FEEDER BREAKER TO EXISTING POLYMER FEED CONTROL PANEL. EXISTING BREAKER SHALL REMAIN AS A SPARE BREAKER. REMOVE EXISTING NAMEPLATE AND REPLACE IT WITH NEW NAMEPLATE READING "SPARE".
 3. ALL ITEMS SHOWN ON CONTROL SCHEMATIC ARE LOCATED IN THE MCC UNLESS NOTED OTHERWISE.

RECORD DRAWINGS

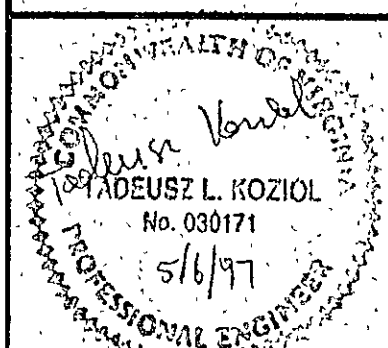

**MALCOLM
PIRNIE**
11832 Rock Landing Drive, Suite 400
Newport News, Virginia 23606

[illegible]

DES TK
DWN TK
CKD FAS



CITY OF ROANOKE, VIRGINIA
WATER POLLUTION
CONTROL PLANT
UPGRADE AND EXPANSION

DISSOLVED AIR FLOATATION THICKENER
ONE LINE DIAGRAM
AND MCC FRONT VIEW
SCALE: NOT TO SCALE

COPYRIGHT © 1997
MALCOLM PIRNIE, INC.
DATE MAY 1997
E SHEET 33 OF 36
CAD REF. NO. 0060E698