


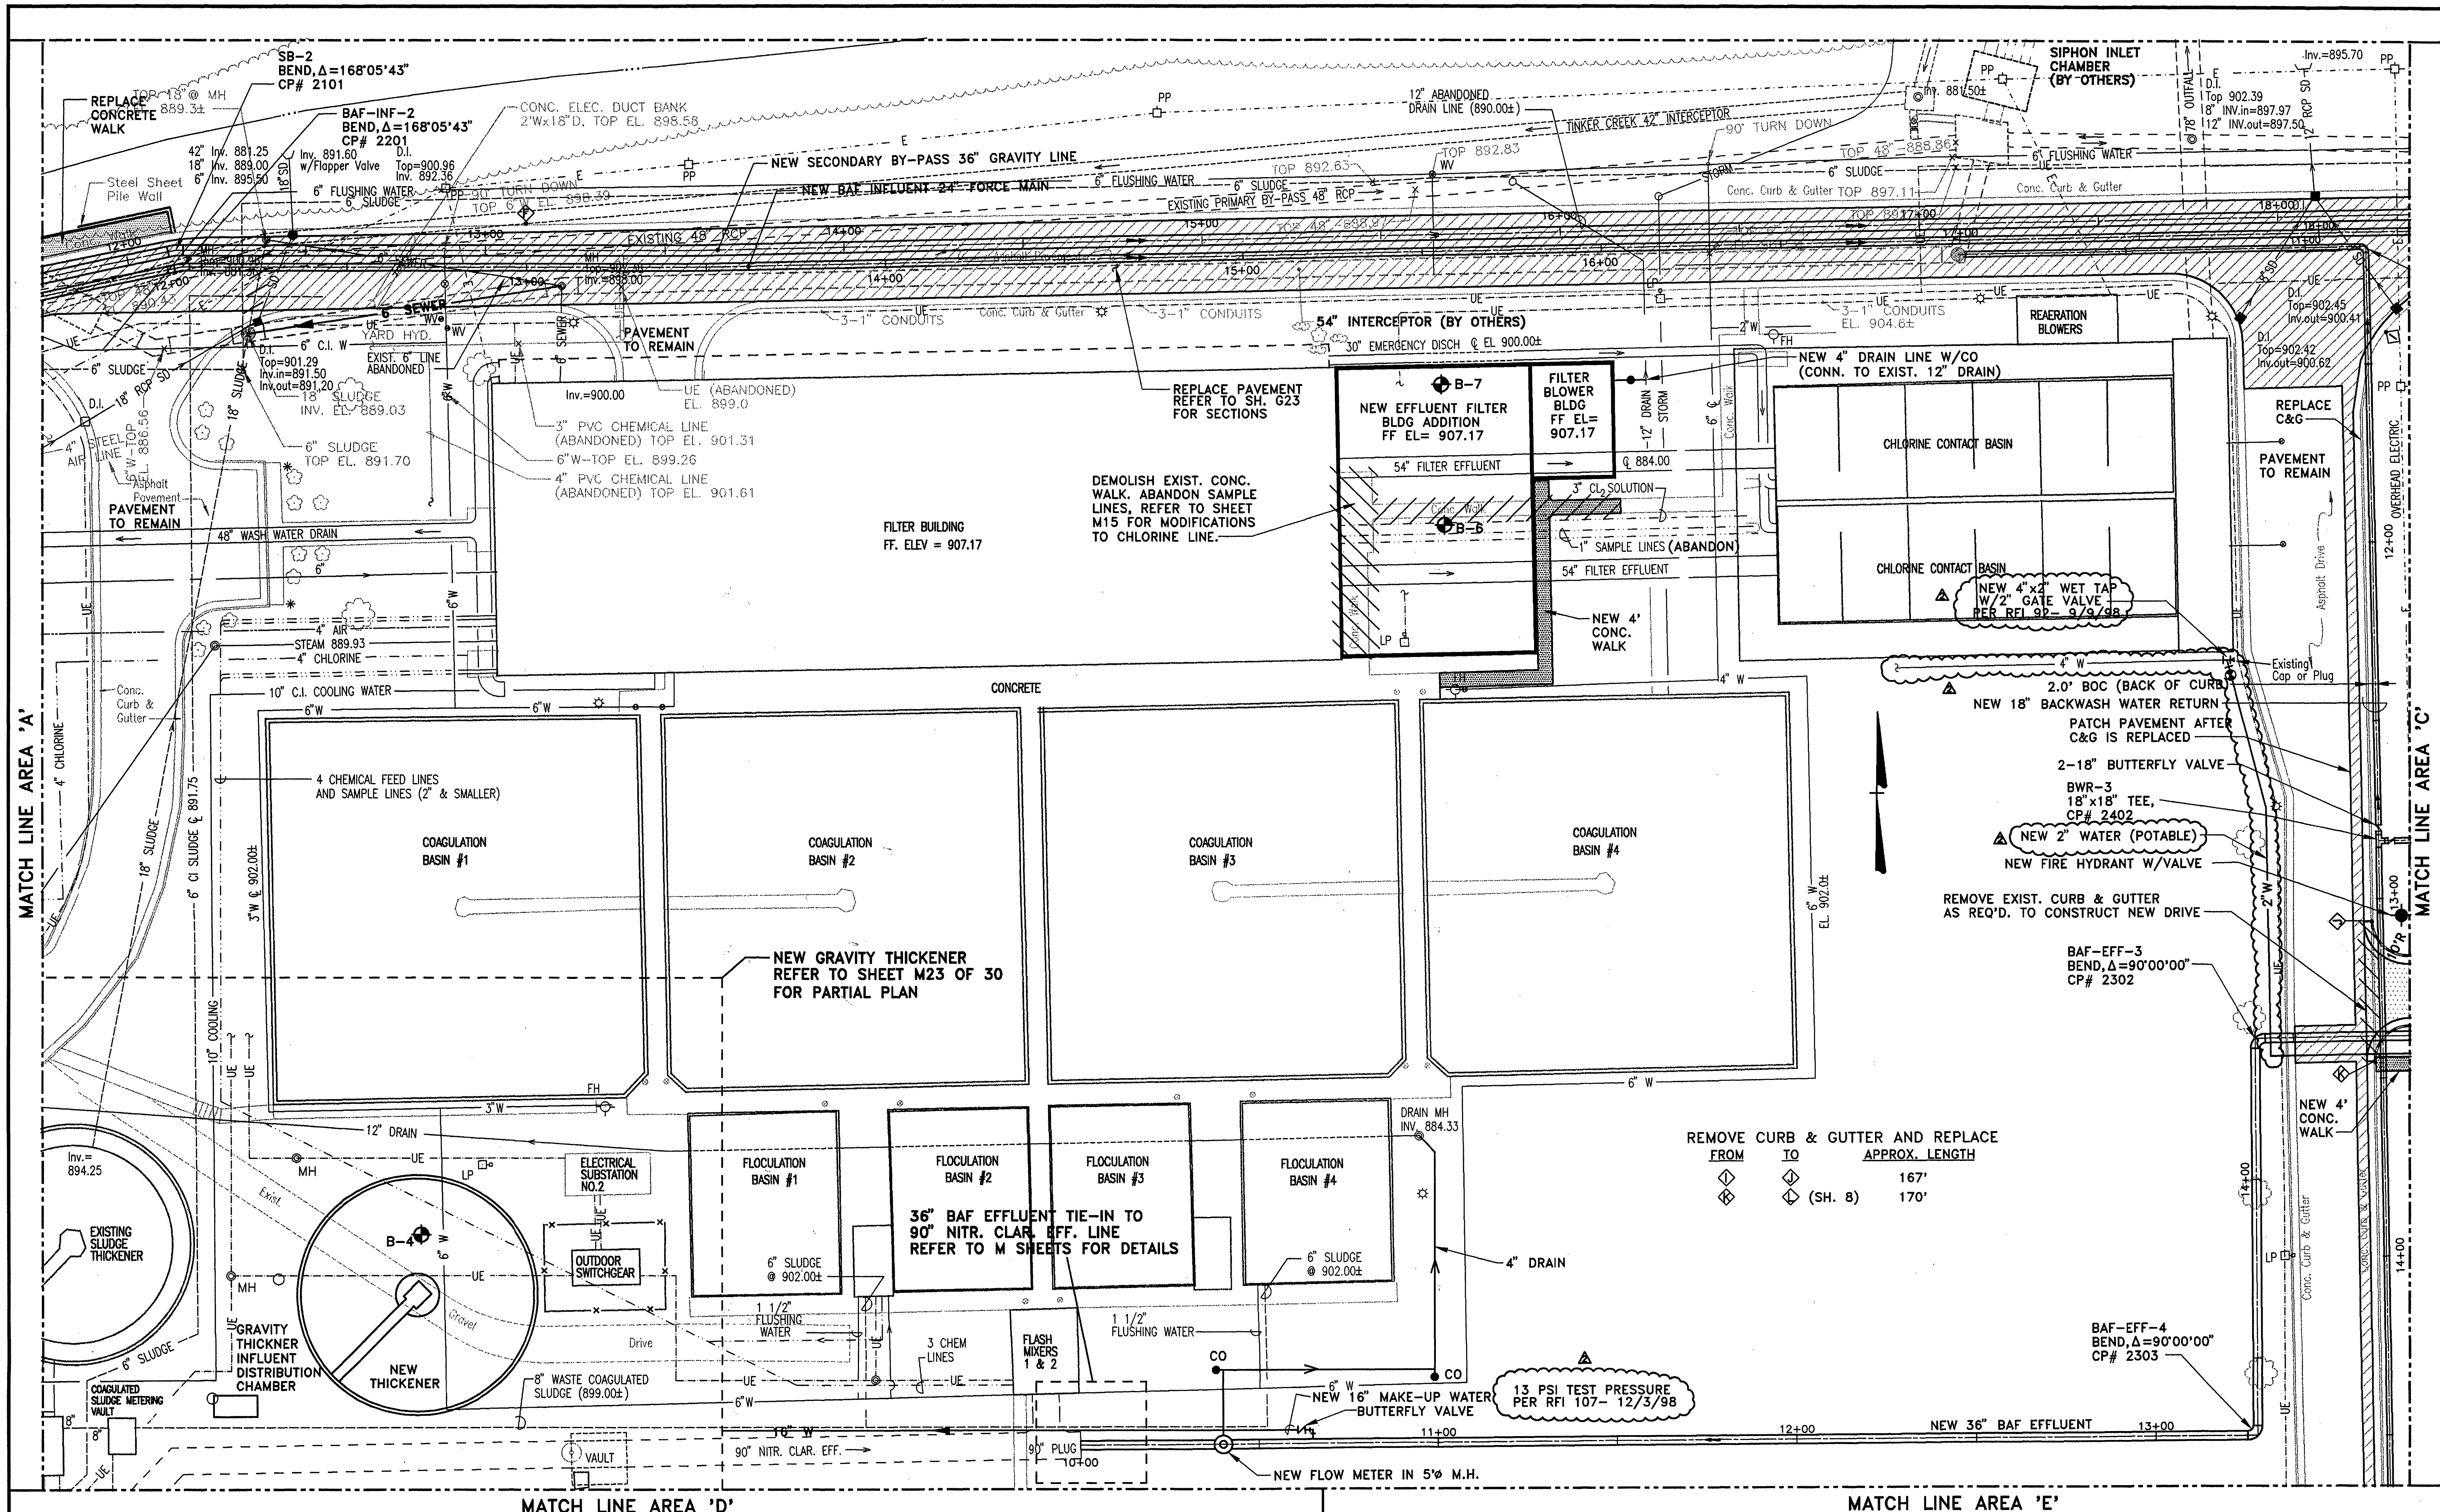

Mattern & Craig, Inc.
CONSULTING ENGINEERS - SURVEYORS
100 TRUMP STREET, S.W.
ROANOKE, VIRGINIA 24016
(804) 544-8444
(804) 544-7991 FAX

NO.	BY	DATE	REVISIONS	REMARKS
1	SWH	2/12/98	REVISED 24" & 36" YARD PIPING	
2	ARB	JAN. 2000	RECORD DRAWING	

DES. WTA
DWN. LDL/ARB
CKD. SWH

CITY OF ROANOKE, VIRGINIA
**WATER POLLUTION
CONTROL PLANT
UPGRADE AND EXPANSION**

SITE PLAN
**LAYOUT, YARD PIPING, AND UTILITIES
AREA 'B'**
1"=20'

DATE MAY, 1997

G SHEET 5 OF 23

CAD REF. NO. G5.DWG