

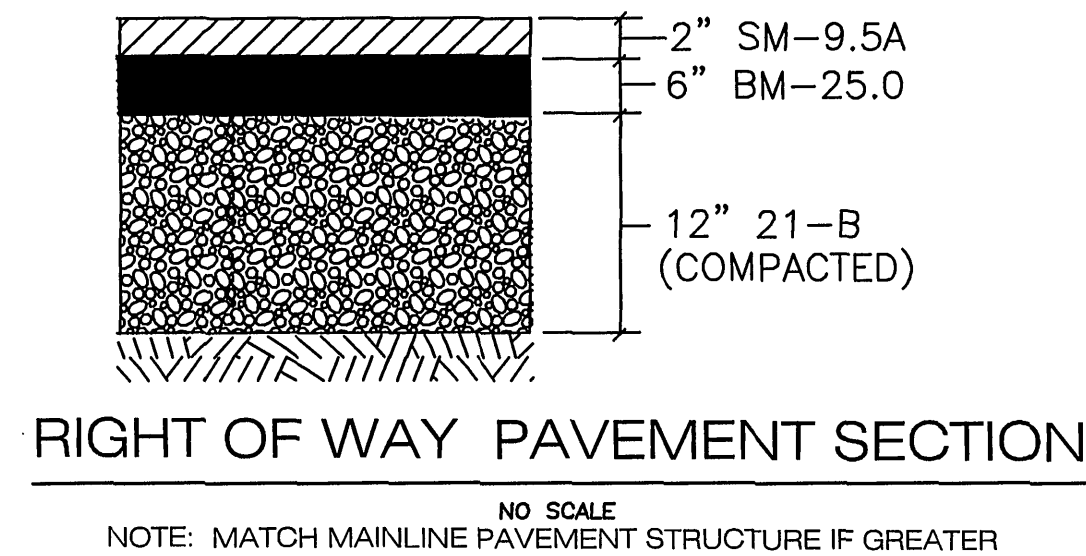
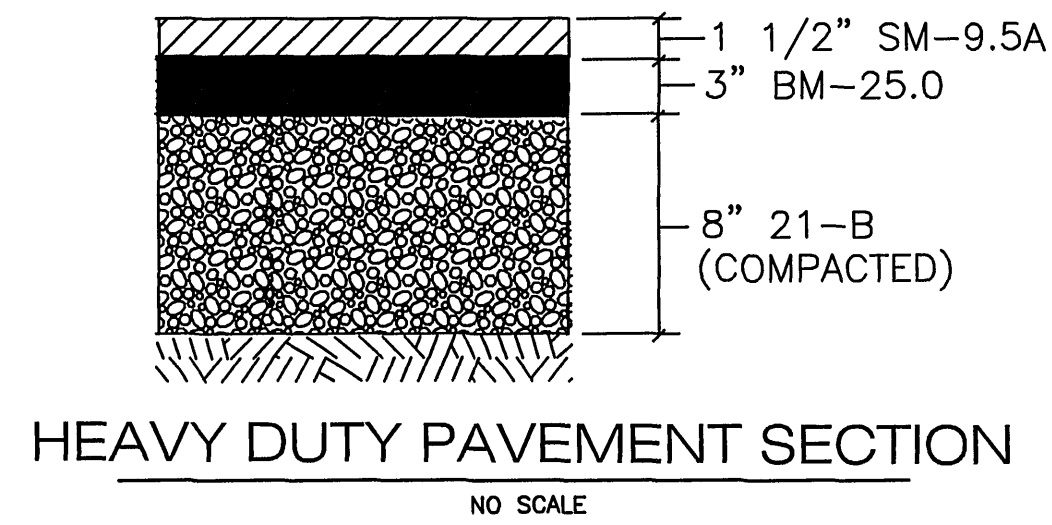


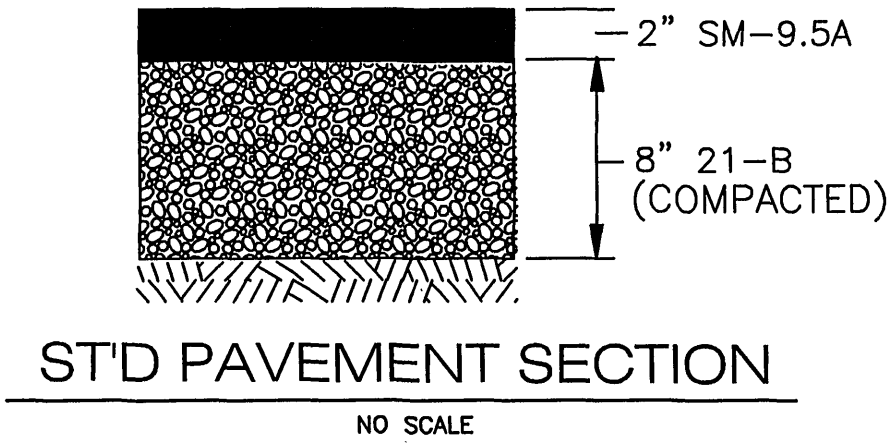





- NOTE: MATCH MAINLINE PAVEMENT STRUCTURE IF GREATER
1. PAVING CONTRACTOR TO COORDINATE LIFTS WITHIN THE RIGHT OF WAY PAVEMENT AND TURN LANE PAVEMENT.
 2. 12" STONE BASE MUST BE PLACED IN TWO LIFTS OF NO MORE THAN 6" EACH.
 3. THE 6" INTERMEDIATE COURSE MUST BE PLACED IN TWO LIFTS OF NO MORE THAN 3" EACH.

GREASE INTERCEPTOR DESIGN

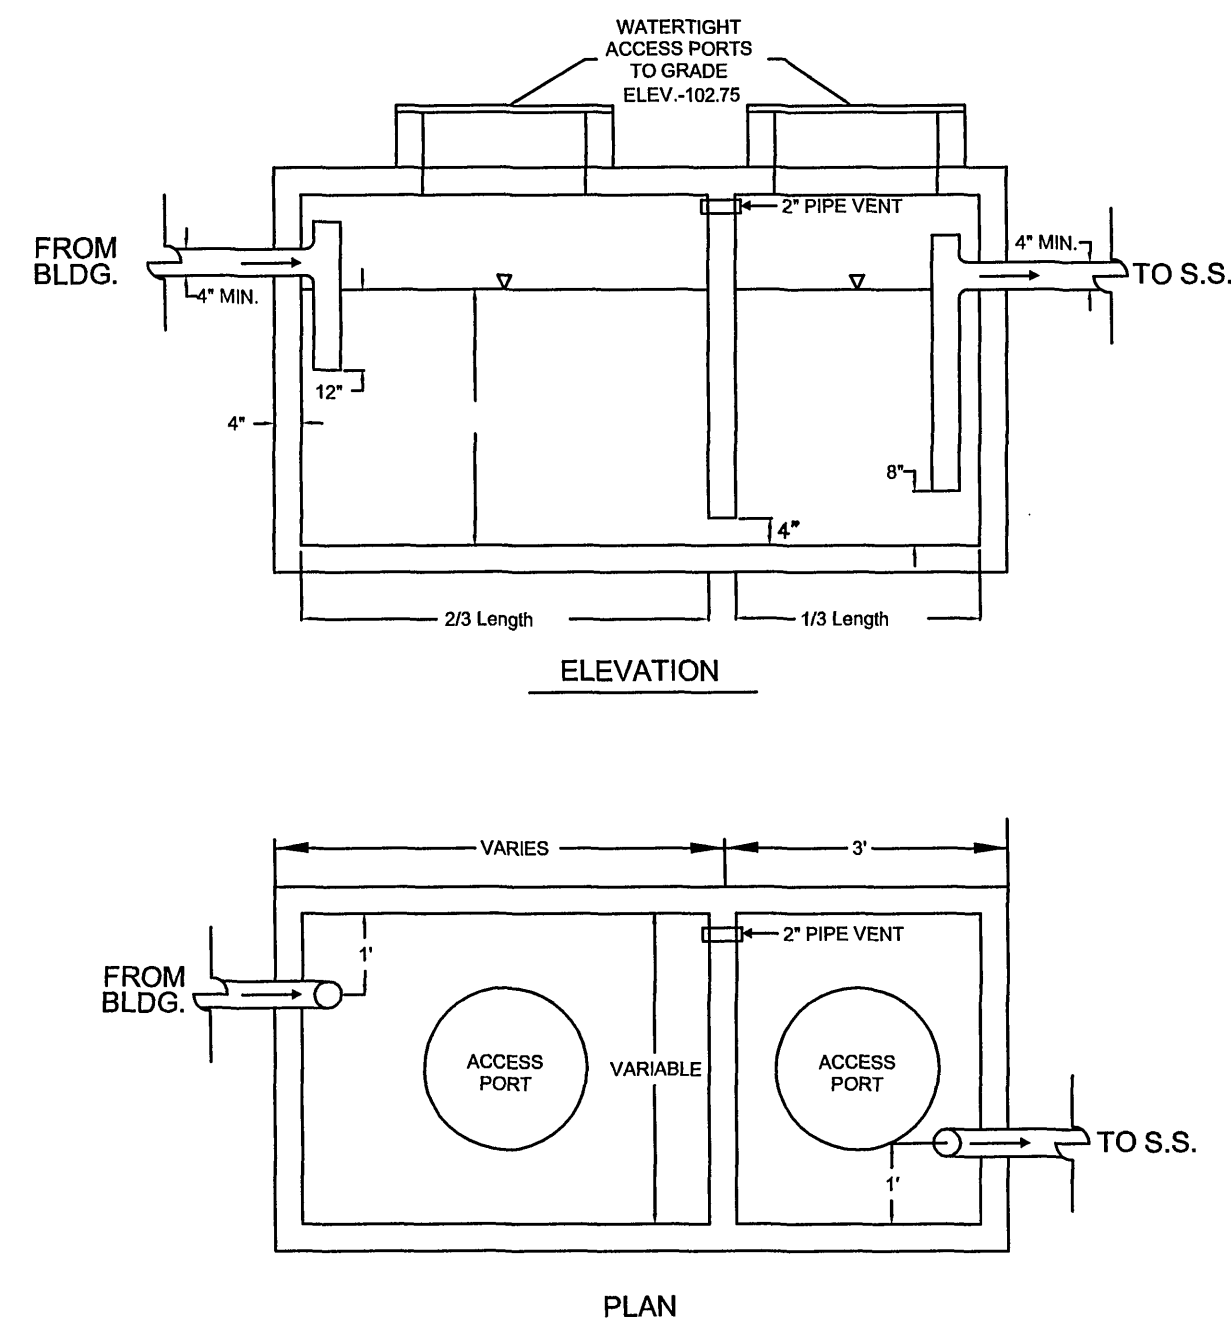

NOTES:

1. MINIMUM RETENTION TIME SHOULD BE 30 MINUTES AT PEAK FLOW
2. GREASE TRAP SHOULD BE DESIGNED TO WITHSTAND TRAFFIC LOADS.
3. THE GREASE TRAP SIZE SHALL BE 1,500 GALLONS
4. SEE PLUMBING PLANS FOR EXACT BLDG. CONNECTION DETAILS AND GREASE TRAP DESIGN CALCULATIONS
5. GREASE INTERCEPTOR SHALL BE INSPECTED AND APPROVED BY WESTERN VIRGINIA WATER AUTHORITY PRIOR TO SITE RECEIVING WATER SERVICE CONNECTION.
6. FORTY- EIGHT (48) HOURS PRIOR TO INSTALLATION, THE CONTRACTOR SHALL COMPLETE THE FOLLOWING:
 - a. SUBMIT SHOP DRAWINGS TO CASSIE ALTICE 601 S. JEFFERSON STREET ROANOKE, VA 24011
 - b. CALL (540) 853-5698 TO SCHEDULE GREASE INTERCEPTOR INSPECTION
7. A GREASE CONTAINER WILL BE UTILIZED ONSITE AND STORED IN THE DUMPSTER ENCLOSURE. (SEE DUMPSTER DETAIL ON ARCH. PLANS)
8. THE GREASE INTERCEPTOR SHALL BE RATED FOR H-20 WHEEL LOADS

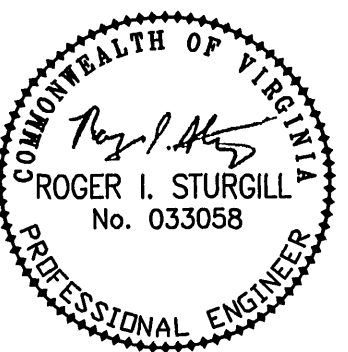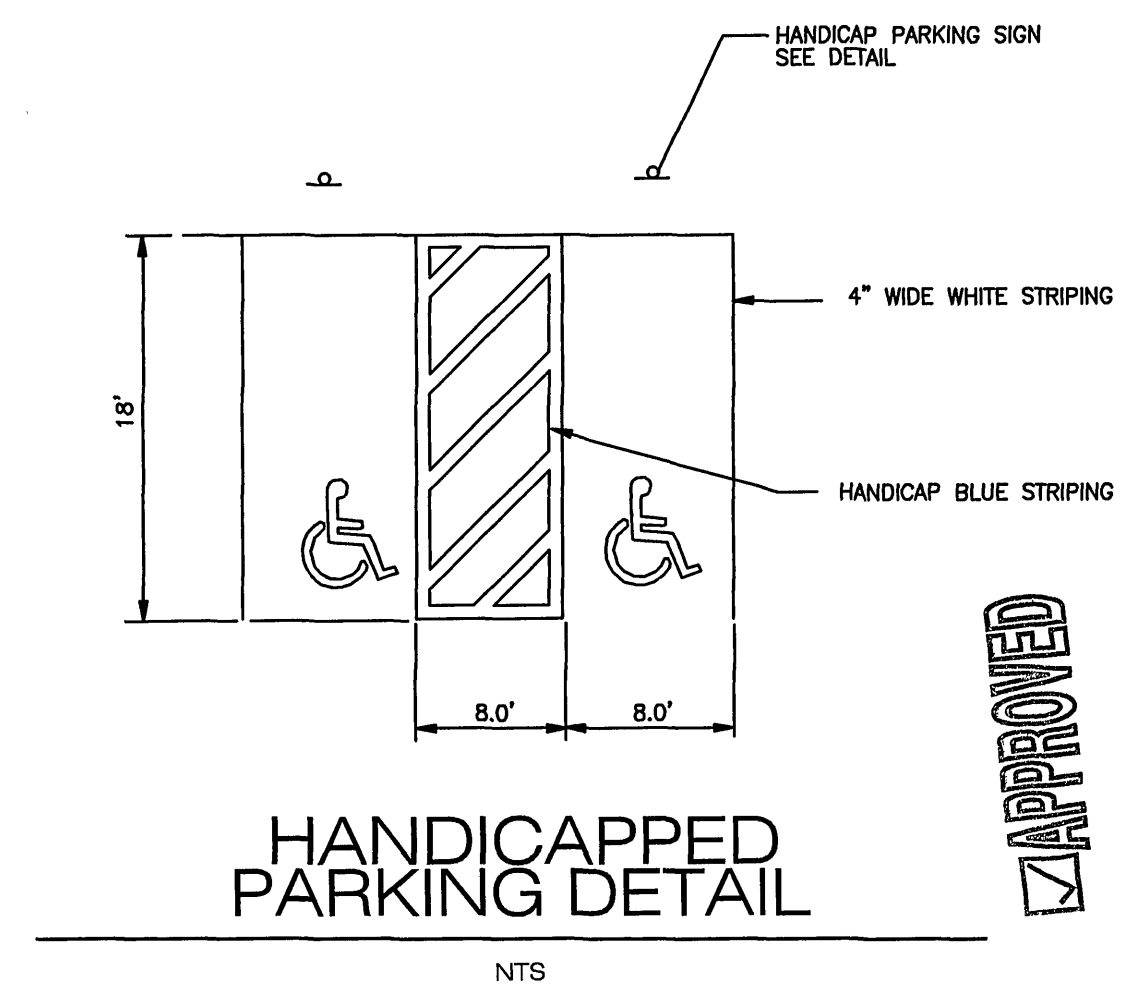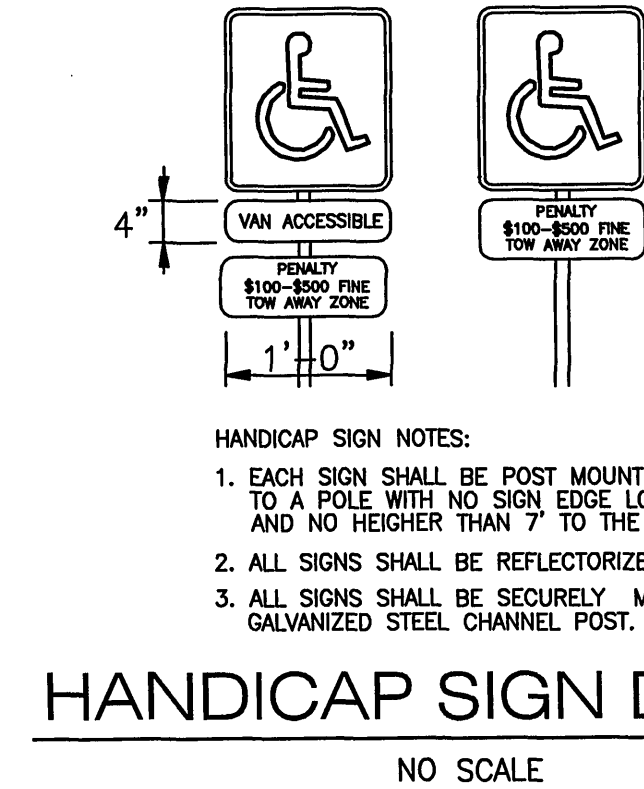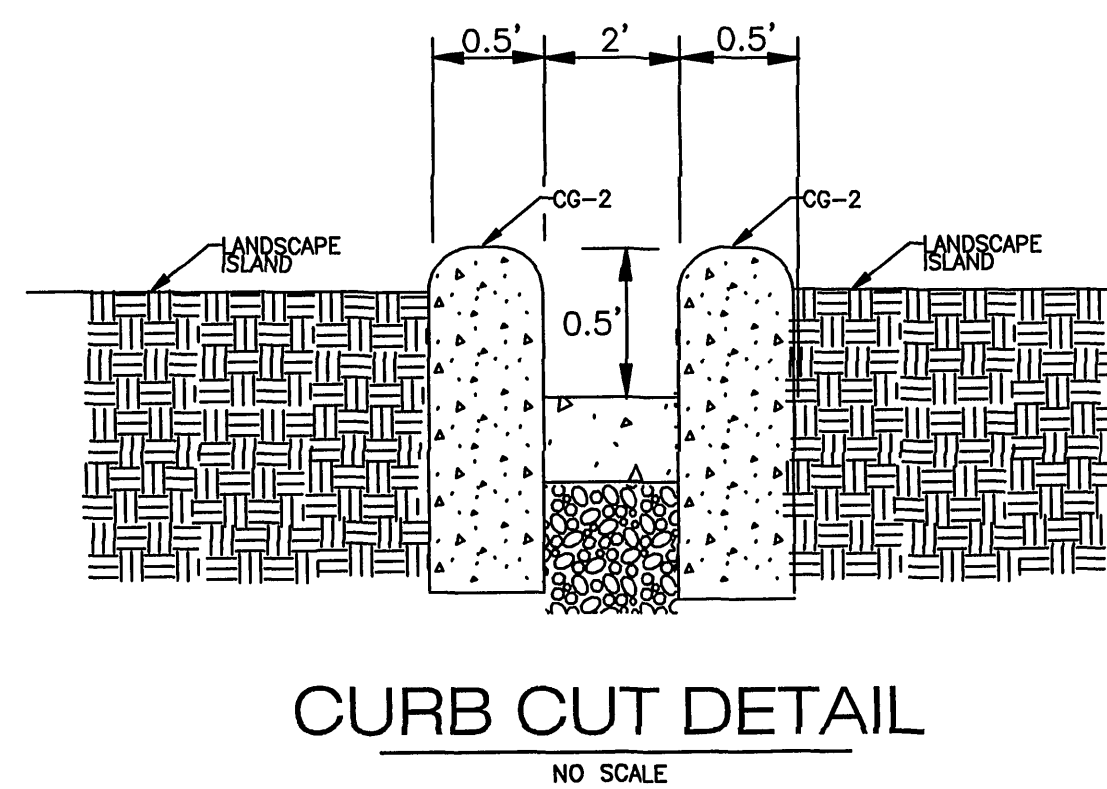

BALZER
AND ASSOCIATES INC.
PLANNERS • ARCHITECTS
ENGINEERS • SURVEYORS

1208 Corporate Circle
Roanoke, Virginia 24018
Phone: 540/772-9580
FAX: 540/772-8050

501 Branchway Road
Richmond, Virginia 23296
Phone: 804/784-0571
FAX: 804/784-2635

880 Technology Park Drive
Suite 200
Olney, VA 22450
Phone: 804/653-0132
FAX: 804/653-0133

448 Peppers Ferry Road, NW
Christiansburg, Virginia 24073
Phone: 540/381-4290
FAX: 540/381-4291

1581 Commerce Road
Suite 401
Verona, Virginia 24482
Phone: 540/248-3220
FAX: 540/248-3221

BOJANGLES - BRAMBLETON
SITE DETAILS I
CAVE SPRING
COUNTY OF ROANOKE, VIRGINIA

DRAWN BY: BTC
DESIGNED BY: BTC
CHECKED BY: RIS
DATE: 11-26-07
REVISIONS:
1-9-08
2-27-08
3-11-08

SCALE: N.T.S.
SHEET NO.
C-13
JOB NO.
R0700128.00