

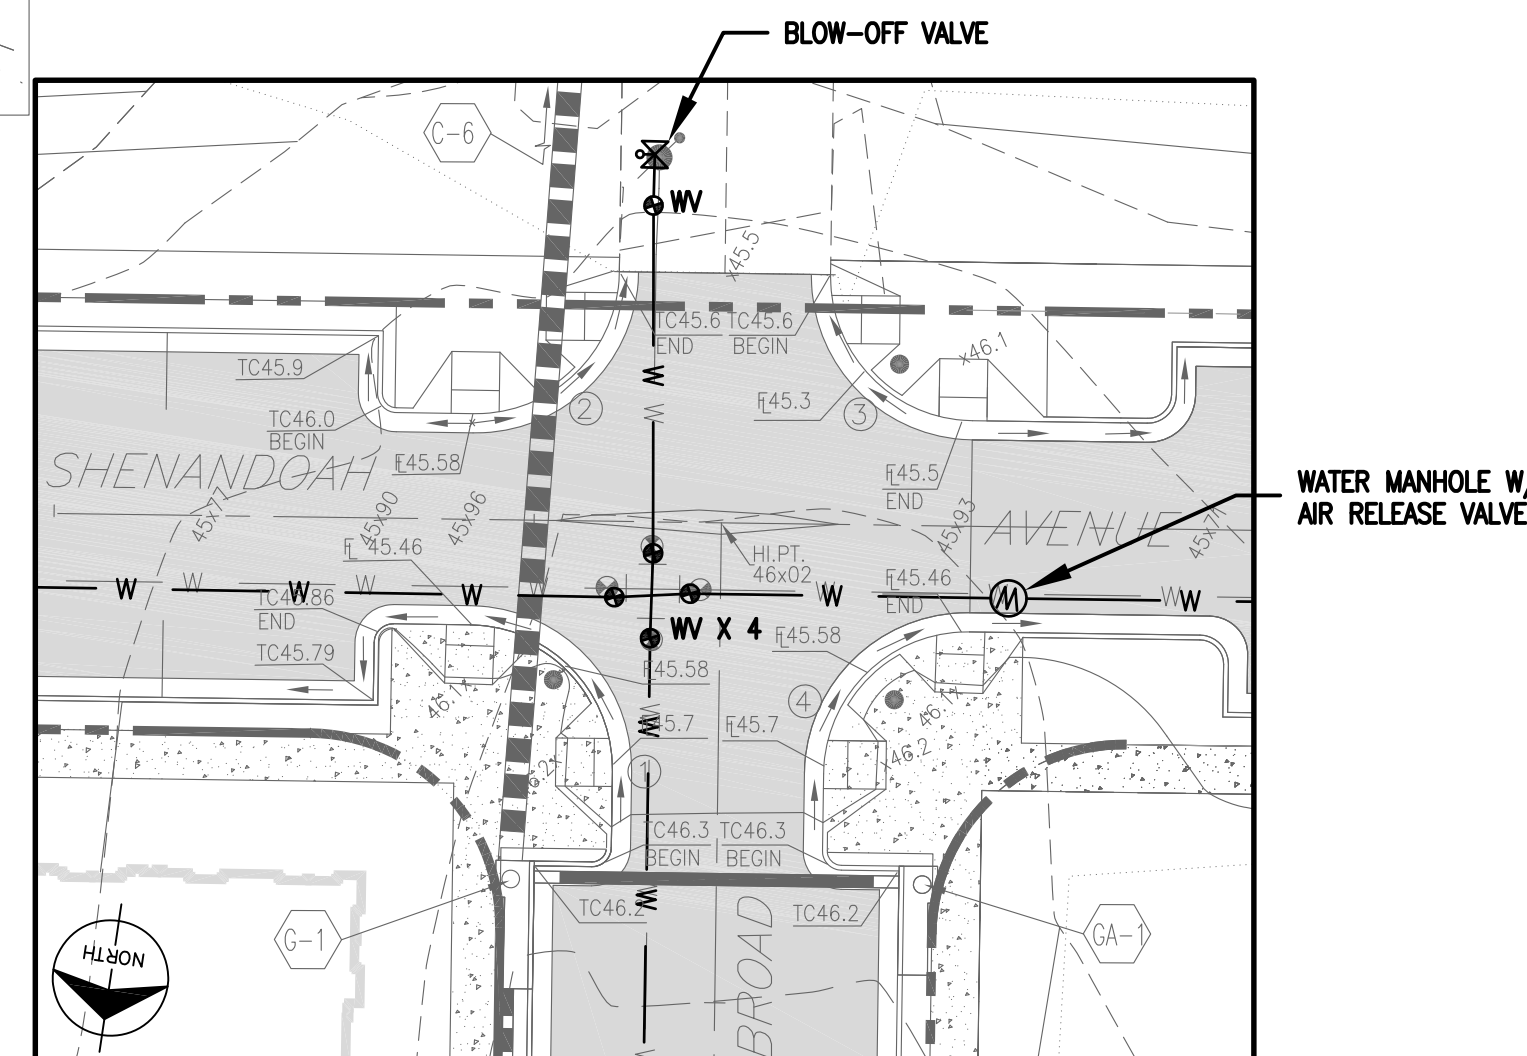
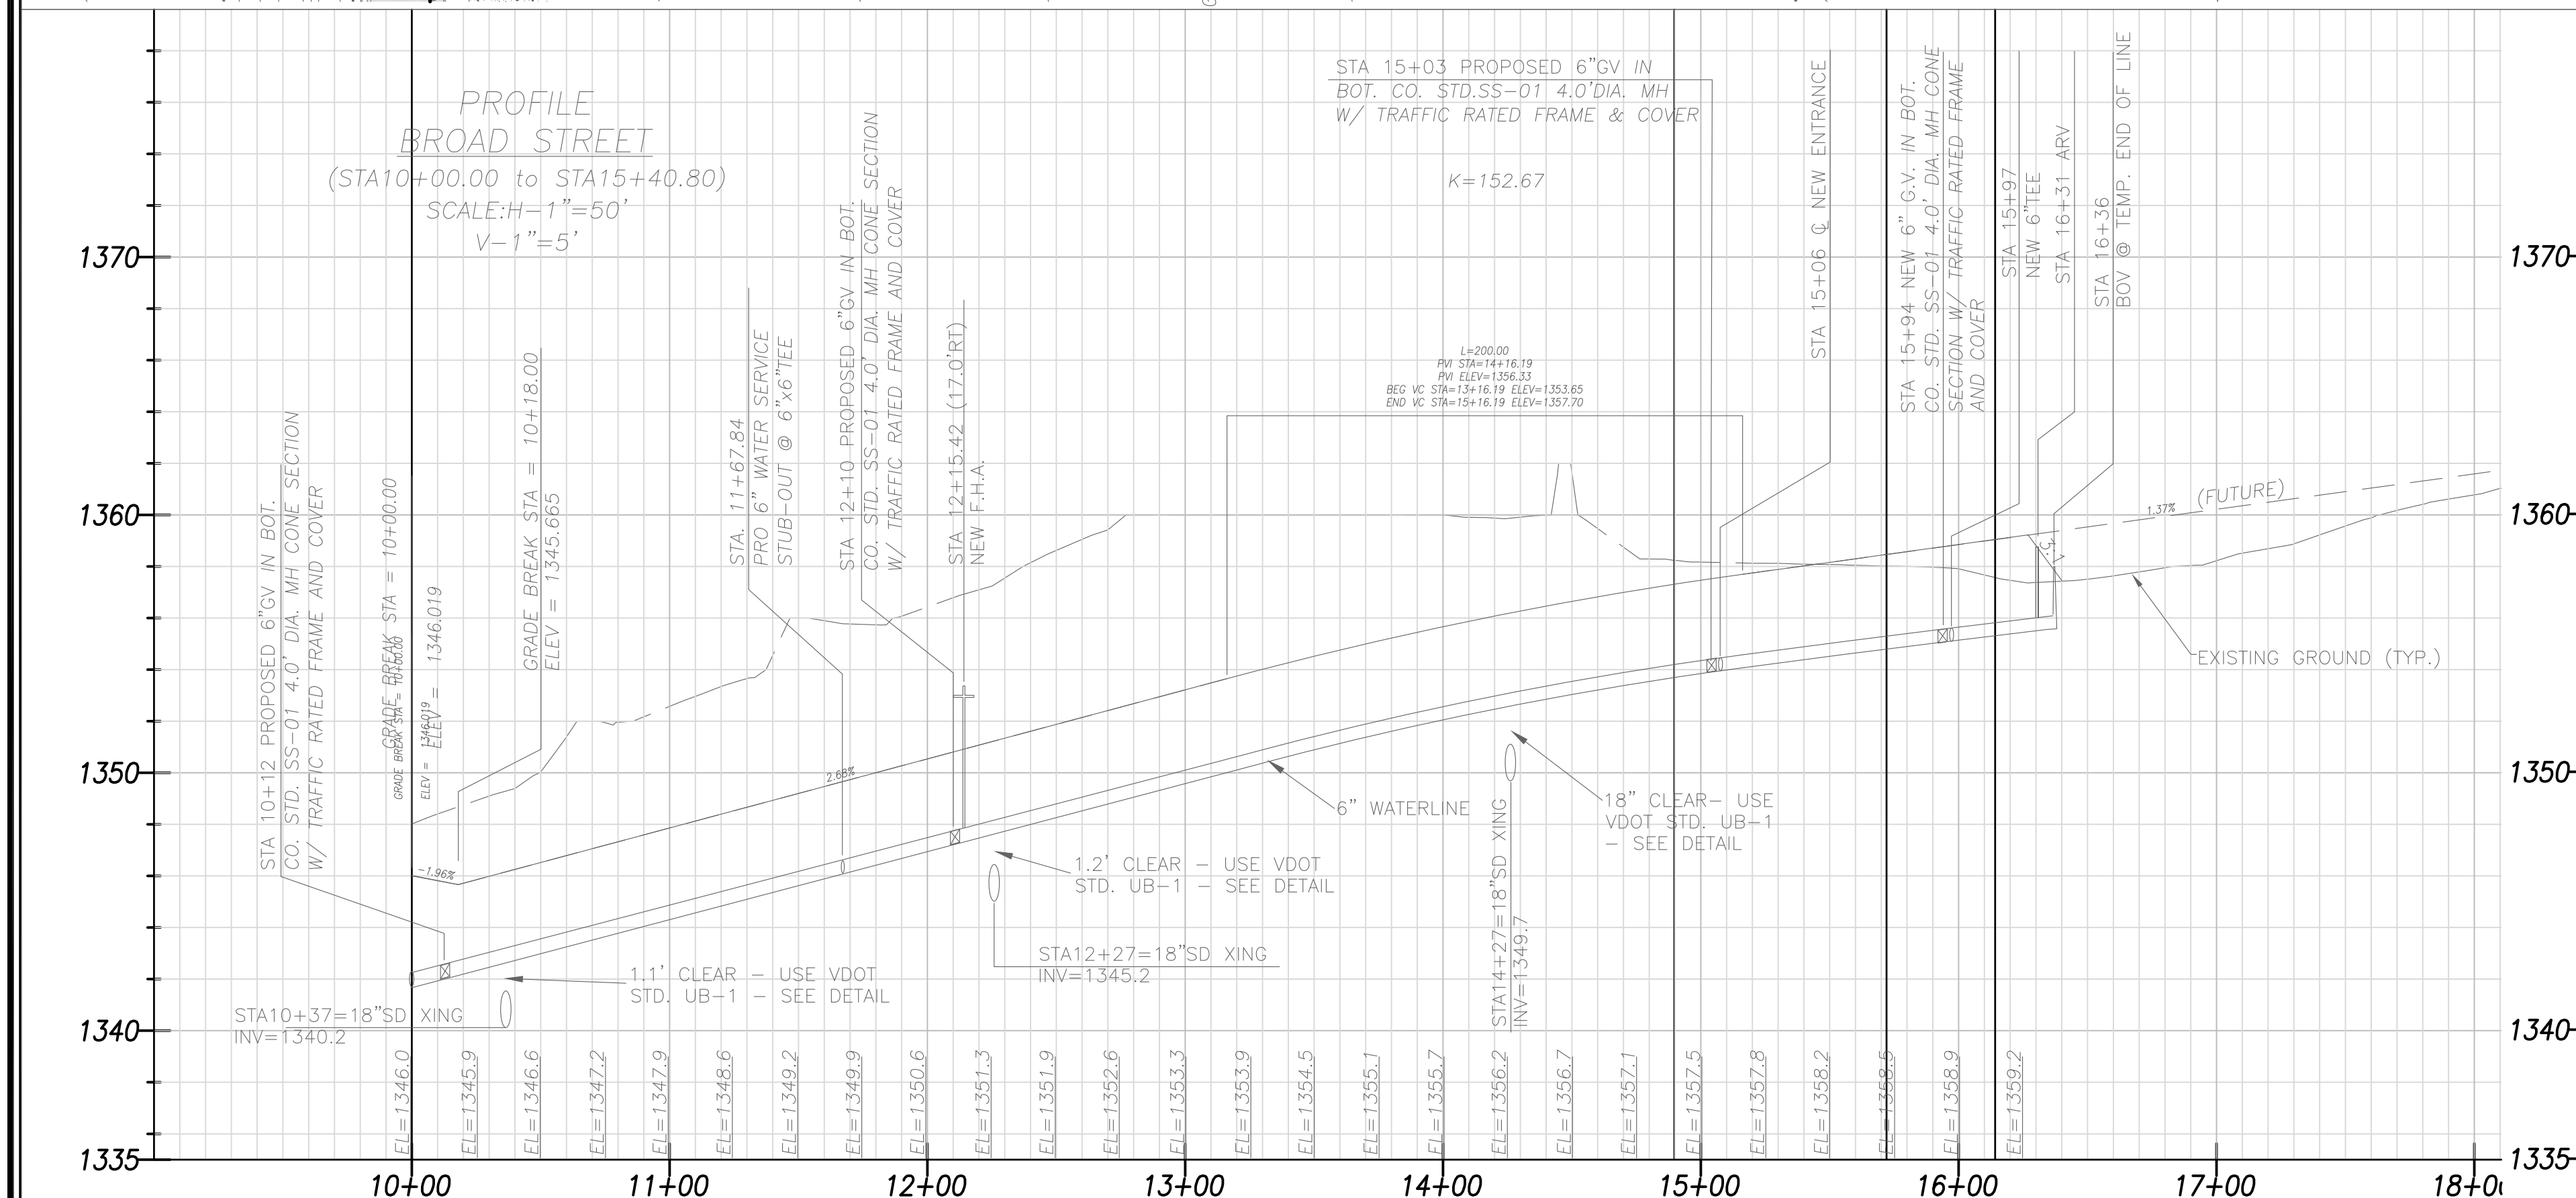
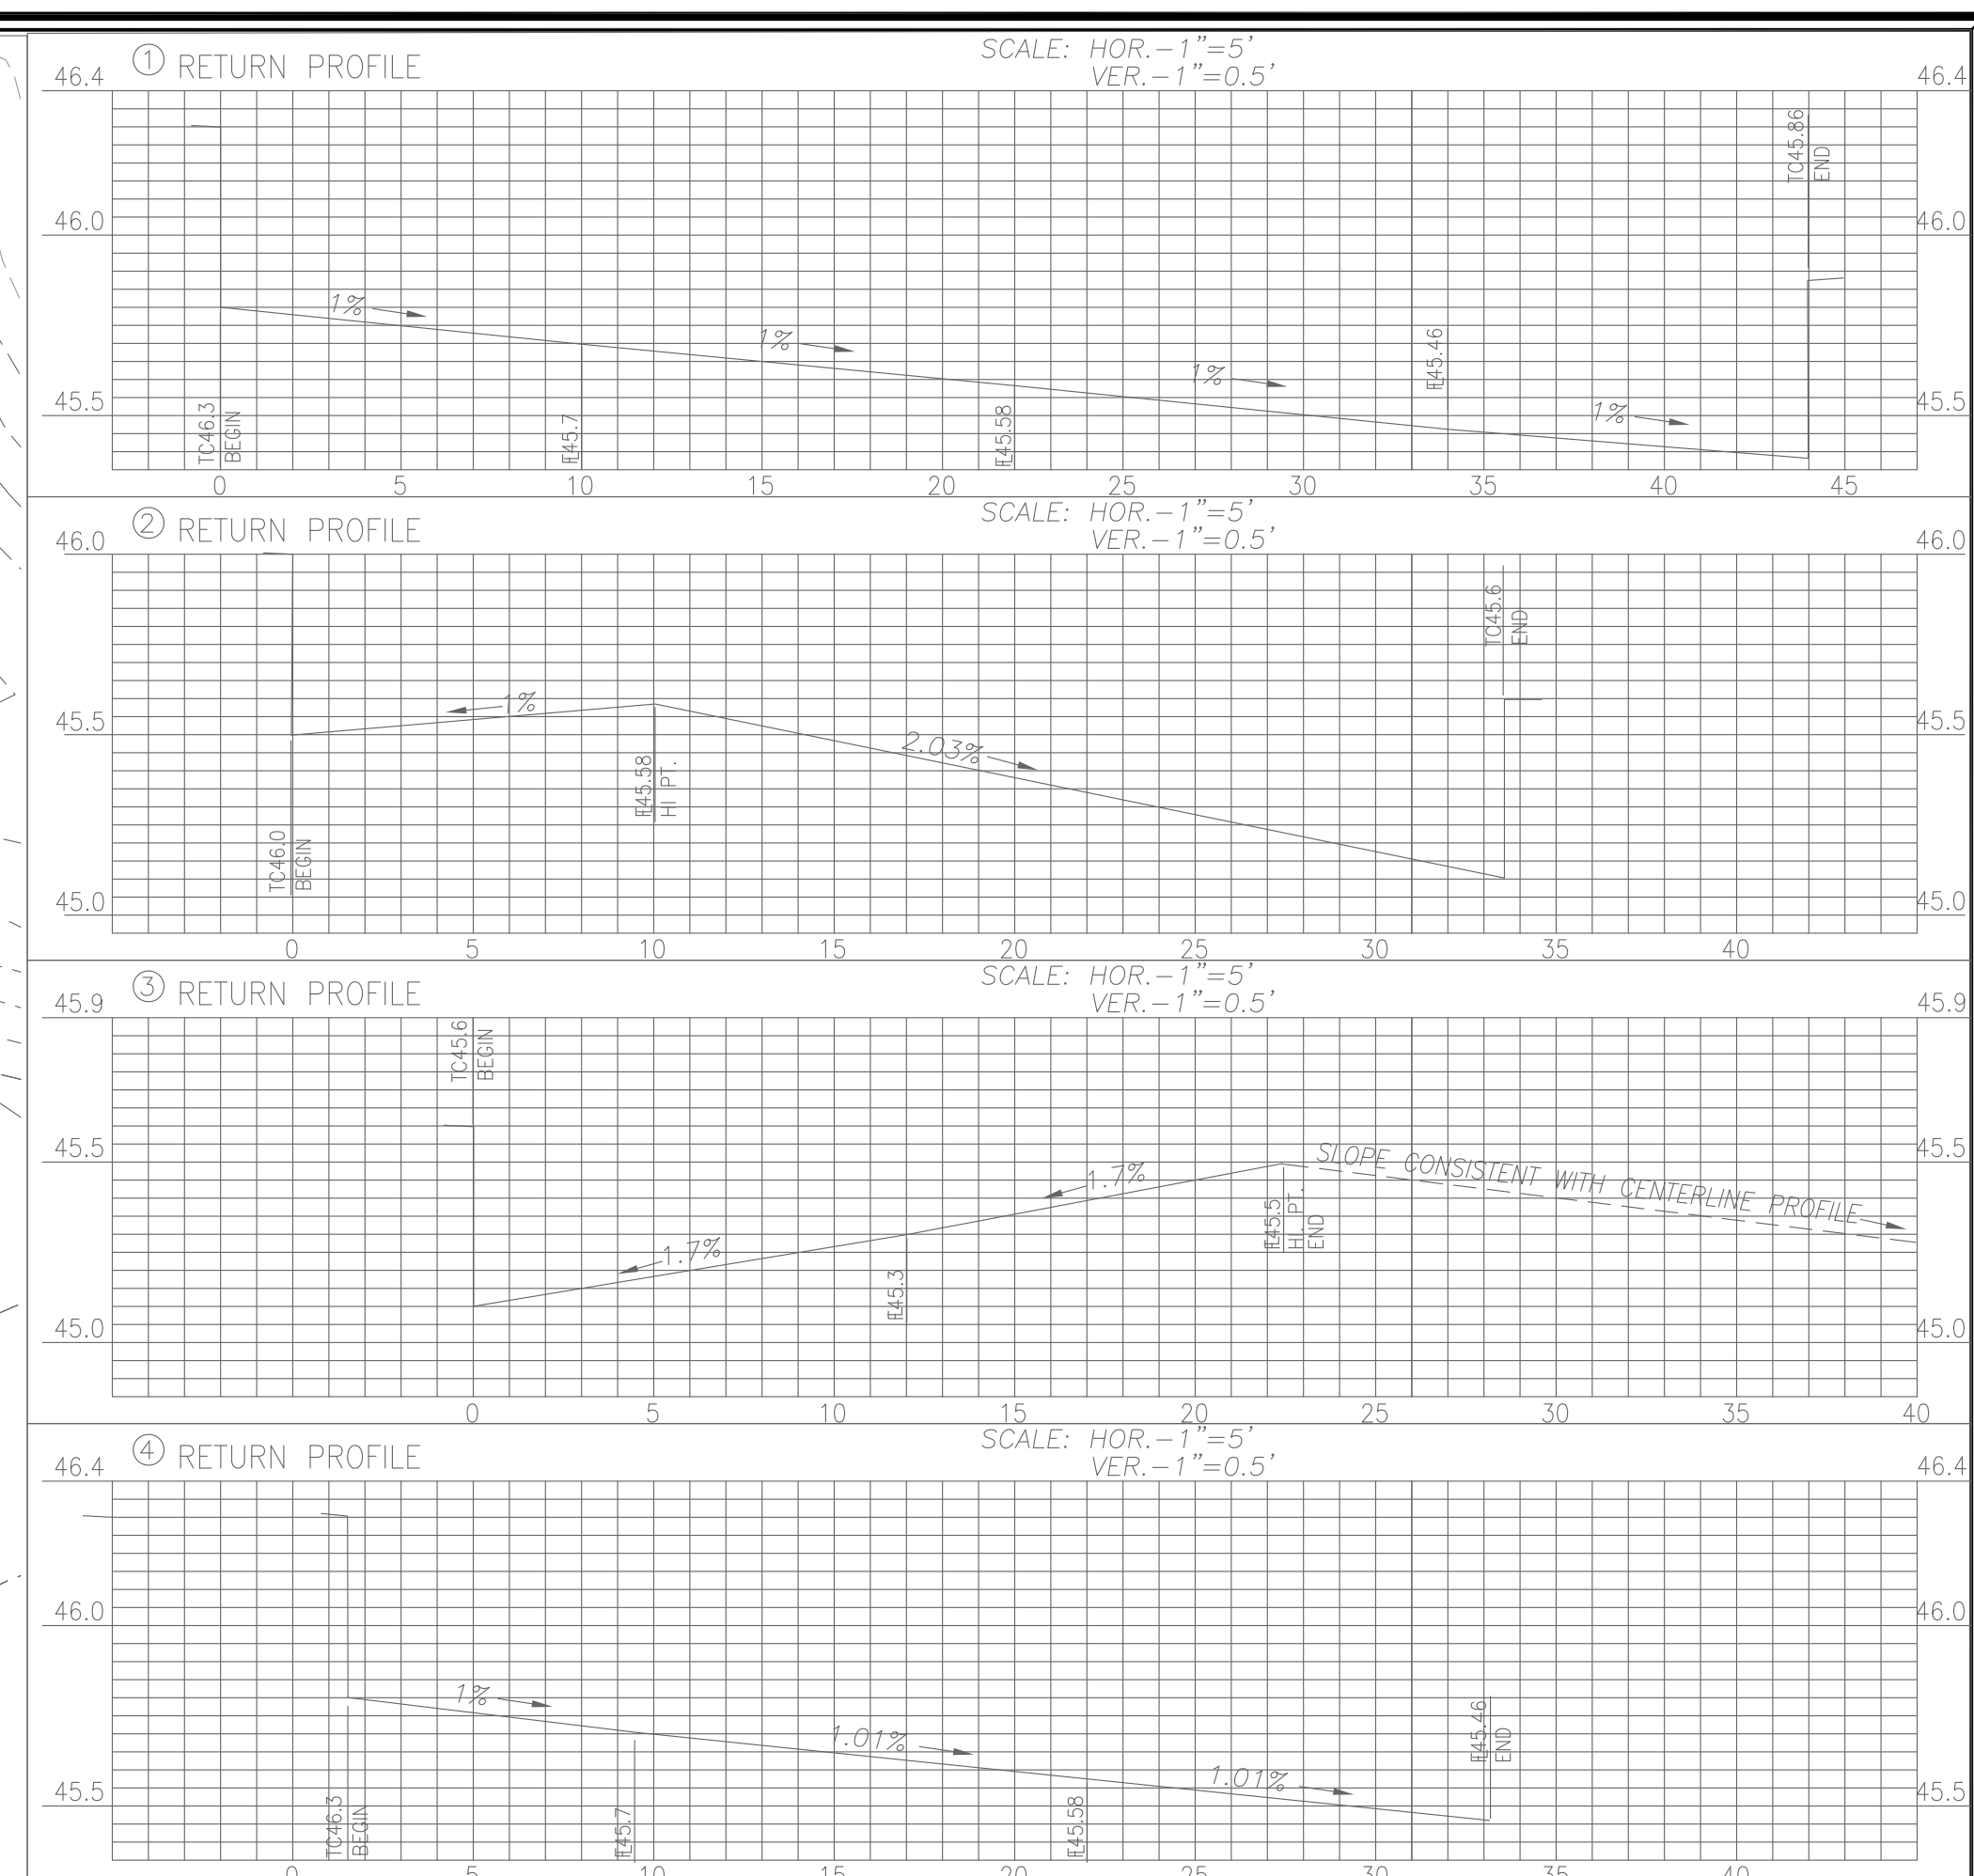


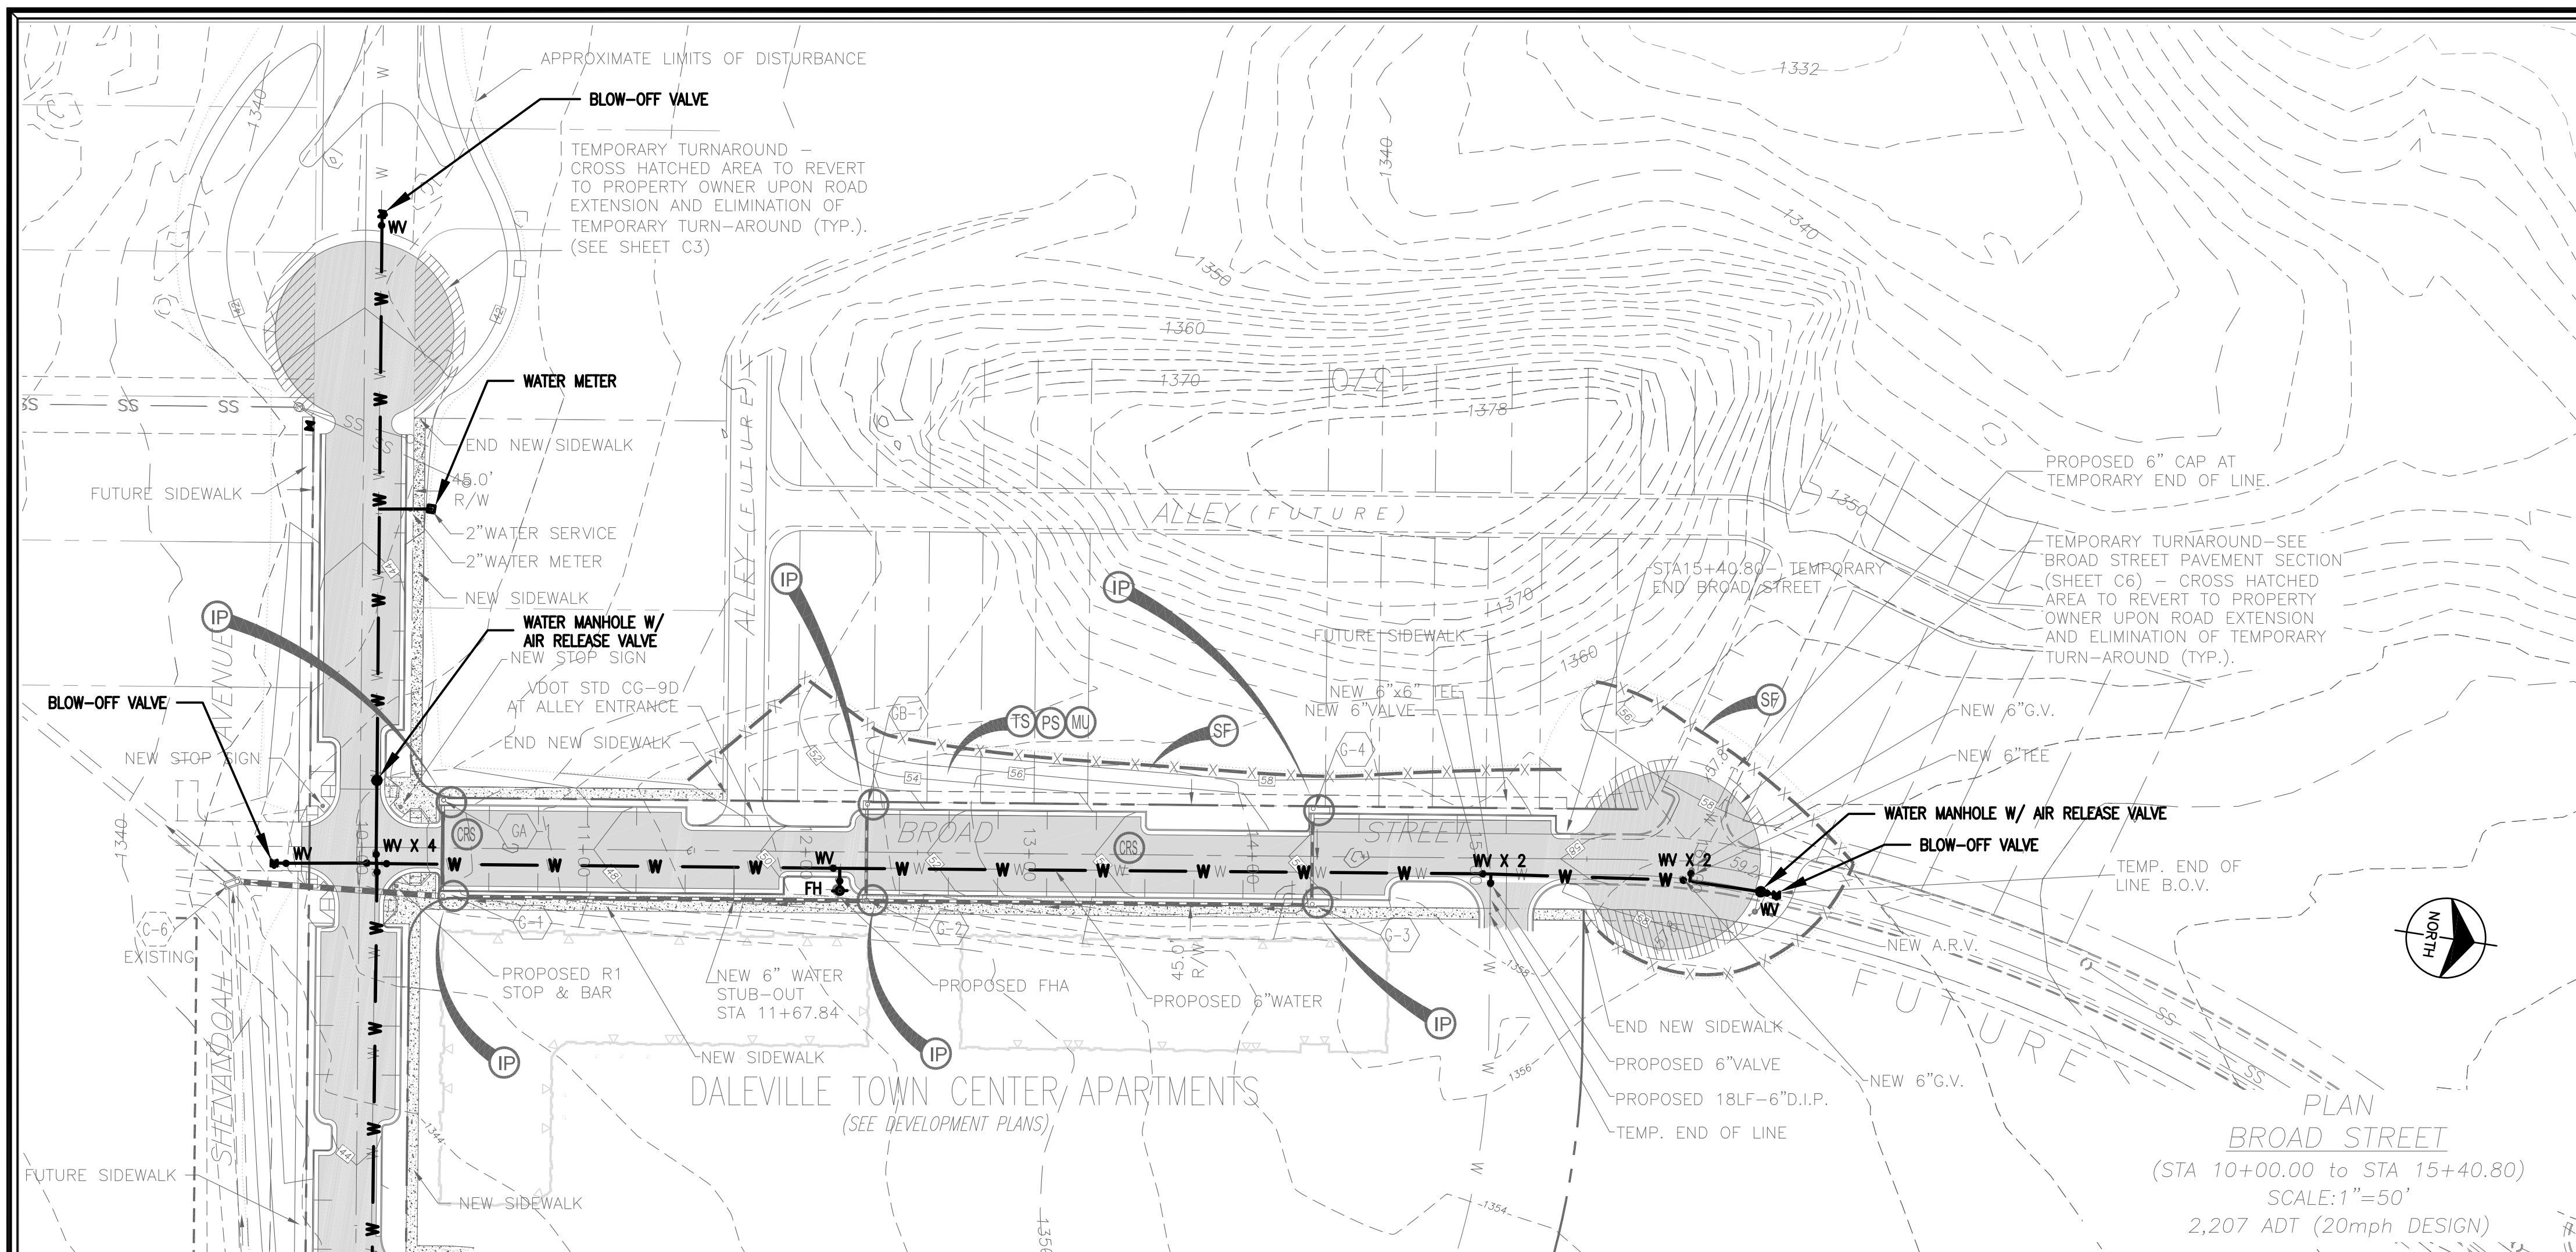

"Water As-Built"

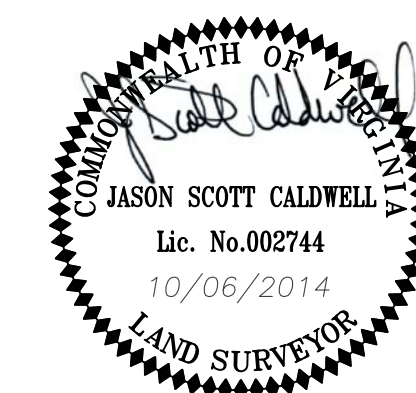

ENGINEERING CONCEPTS, INC.
 20 S. ROANOKE ST., PO BOX 619
 FINCASTLE, VIRGINIA 24090
 540.473.1253 FAX: 540.473.1254

No.	Revision	By	Appd.	Date	Drawn	MSMj	PLAN AND PROFILE BROAD STREET	SCALE: AS SHOWN
1	MISC. REVISIONS	MSM	RHW	11/14/12	Designed	ECI		DATE: SEP. 6, 2012
					Checked	RHW		PROJECT: 11029
					Approved	RHW	DALEVILLE TOWN CENTER BOTETOURT COUNTY – VIRGINIA	C4