

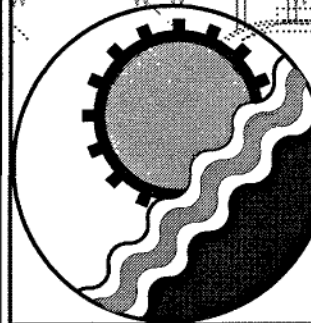


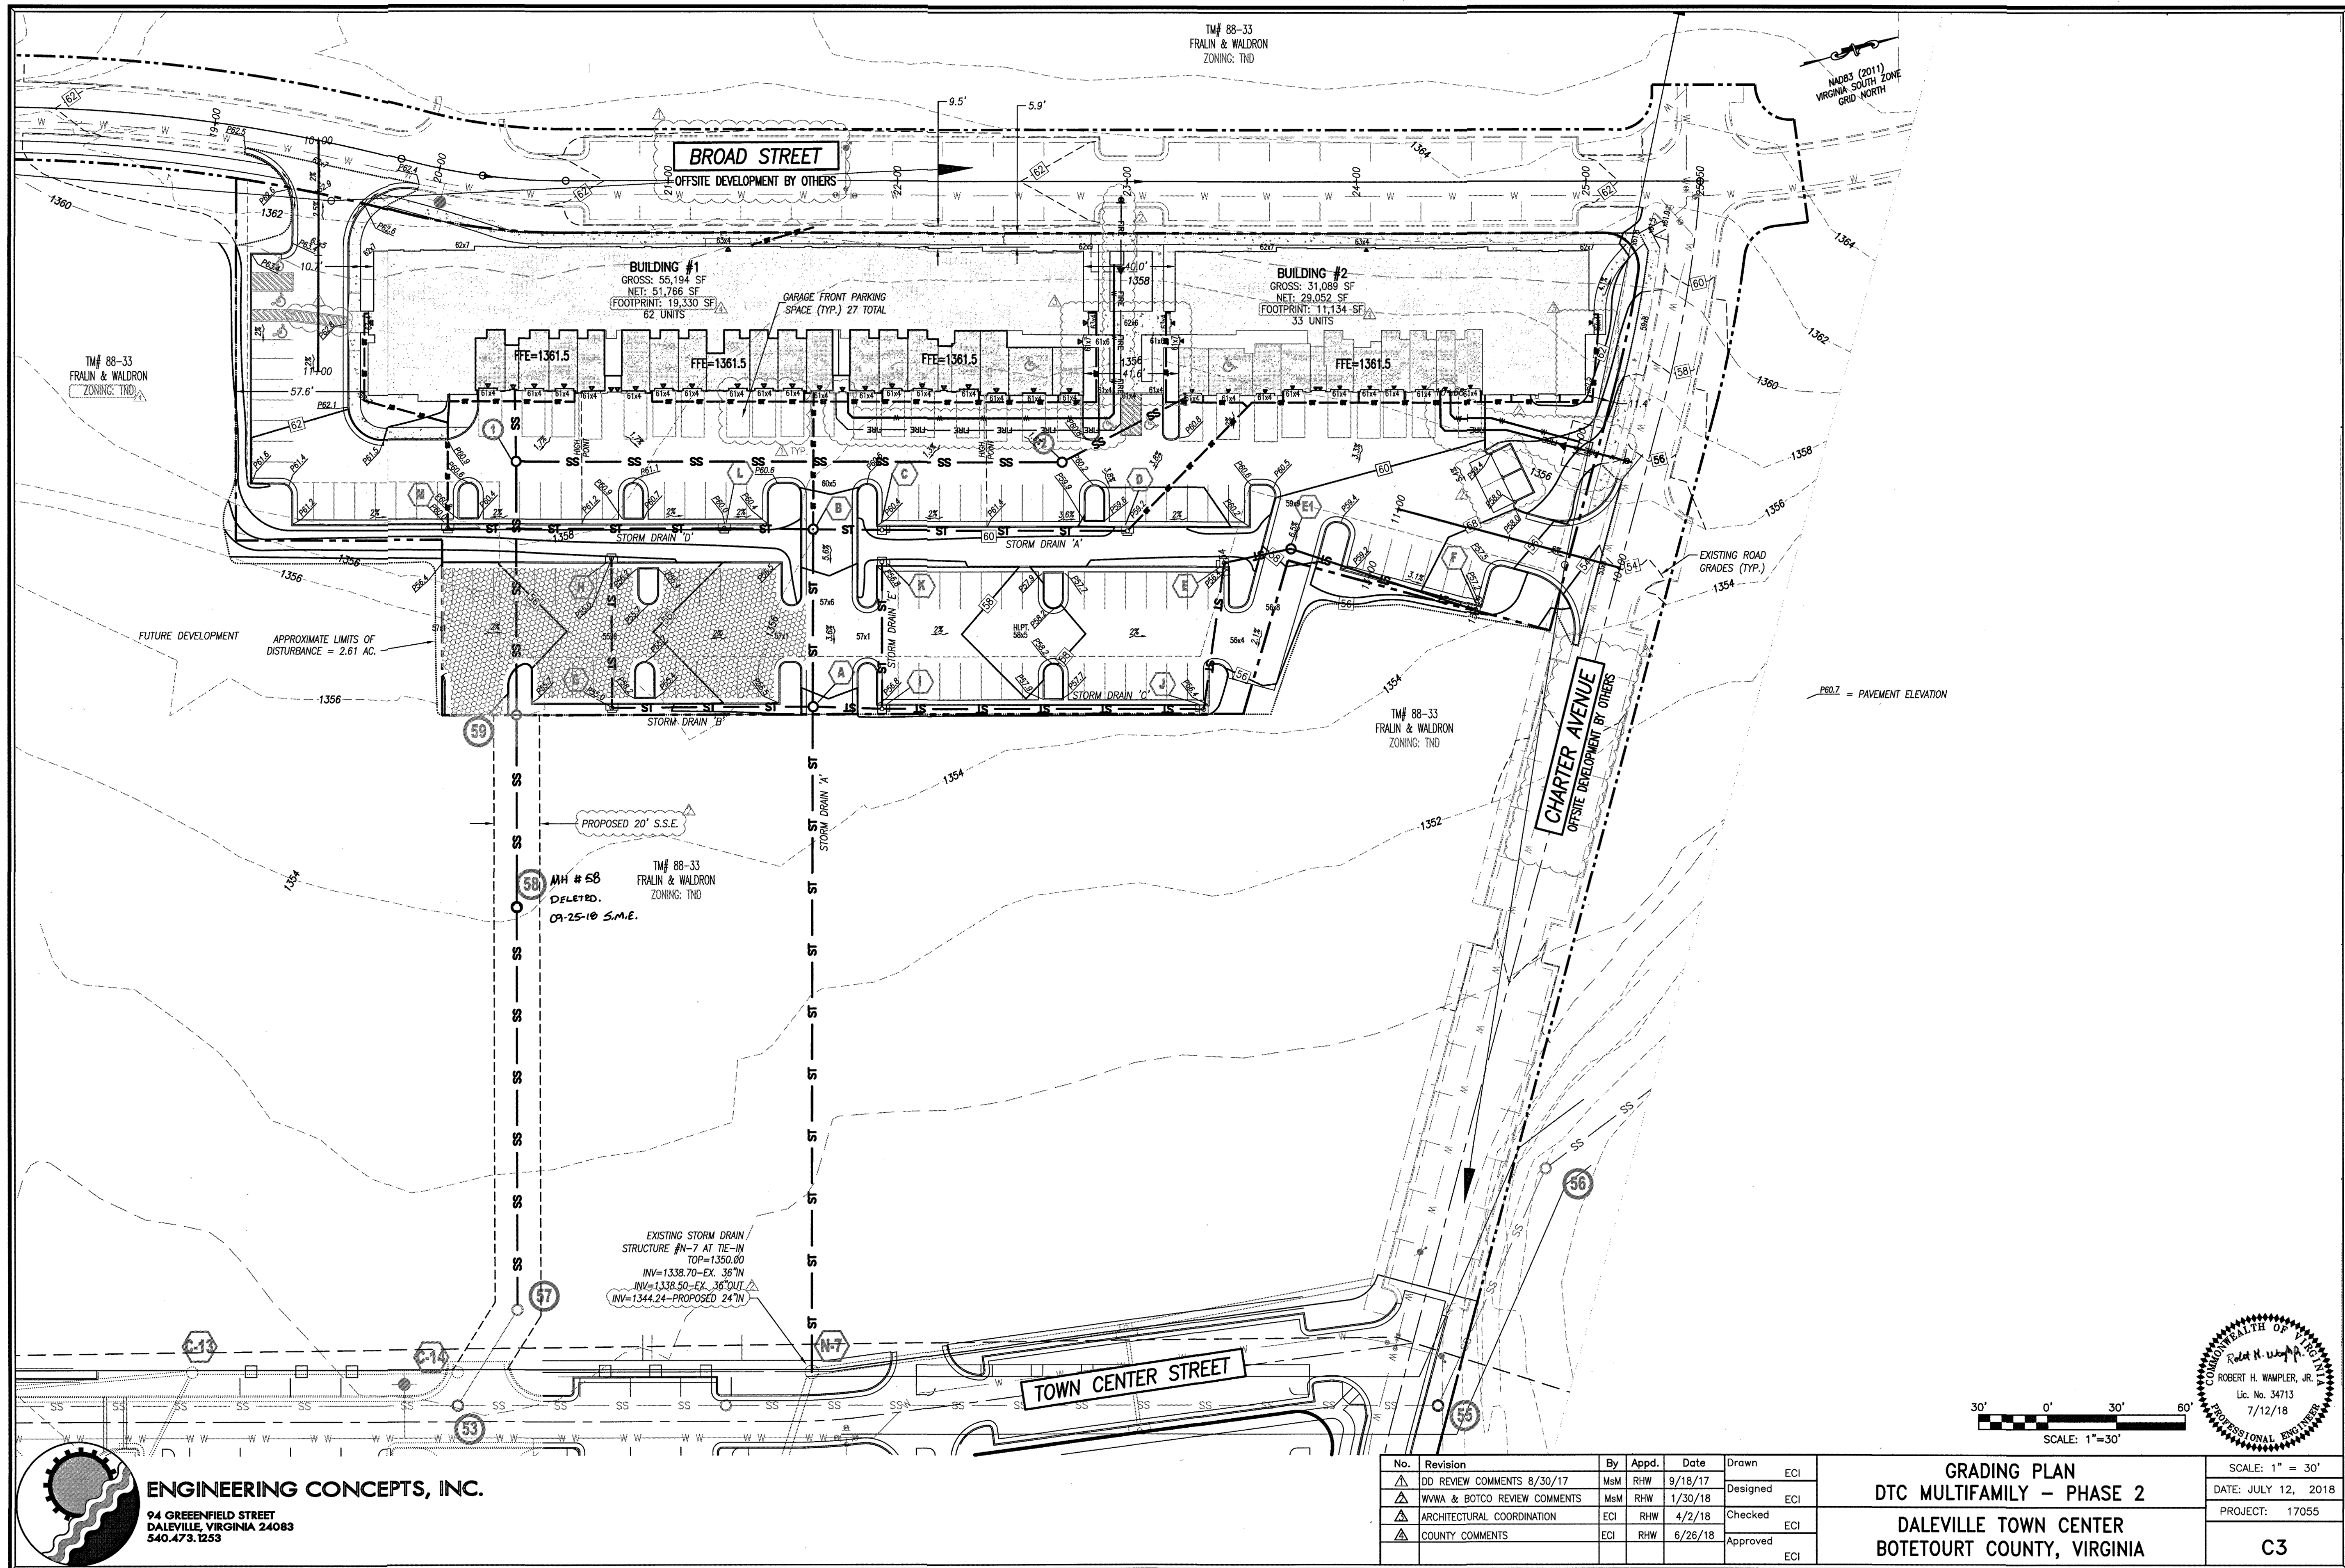

ENGINEERING CONCEPTS, INC.
94 GREENFIELD STREET
DALEVILLE, VIRGINIA 24083
540.473.1253

No.	Revision	By	Appd.	Date	Drawn	ECI
1	DD REVIEW COMMENTS 8/30/17	MsM	RHW	9/18/17	Designed	ECI
2	WWA & BOTCO REVIEW COMMENTS	MsM	RHW	1/30/18	Designed	ECI
3	ARCHITECTURAL COORDINATION	ECI	RHW	4/2/18	Checked	ECI
4	COUNTY COMMENTS	ECI	RHW	6/26/18	Approved	ECI

GRADING PLAN
DTC MULTIFAMILY - PHASE 2
DALEVILLE TOWN CENTER
BOTETOURT COUNTY, VIRGINIA

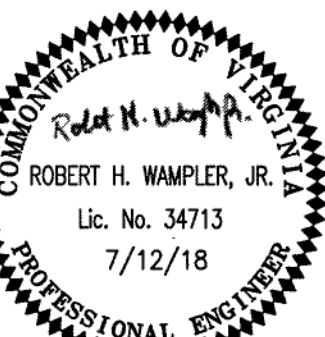

SCALE: 1" = 30'
DATE: JULY 12, 2018
PROJECT: 17055
C3