


INDEX

WASTEWATER COLLECTION SYSTEM

SHEET NO.	DESCRIPTION
1	COVER SHEET
2	INDEX AND KEY SHEET
3-6A	GRAVITY SEWER PLAN SHEETS
7	FORCE MAIN PLAN SHEET
8	FORCE MAIN PROFILE
9	PUMP STATION SITE PLAN & DETAIL SHEET
10-13A	GRAVITY SEWER PROFILE SHEETS
14	MISCELLANEOUS DETAIL SHEET

WASTEWATER TREATMENT PLANT

SHEET NO.	DESCRIPTION
15	DESIGN CRITERIA & HYDRAULIC PROFILE
16A	SITE PLAN
17	GRADING PLAN & HEADER PIPE DETAILS
18	AIR PIPING PLAN
19	CONTROL AREA STAKEOUT DETAILS
20A	CLARIFIER & CHLORINE TANK DETAILS
21	AERATION STEP & RETURN SLUDGE DETAILS
22	CONTROL BUILDING DETAILS
23	BLOWER BUILDING DETAILS
24	HYDRAULIC WALL & INFLUENT MANHOLE DETAILS
25	MISCELLANEOUS DETAILS

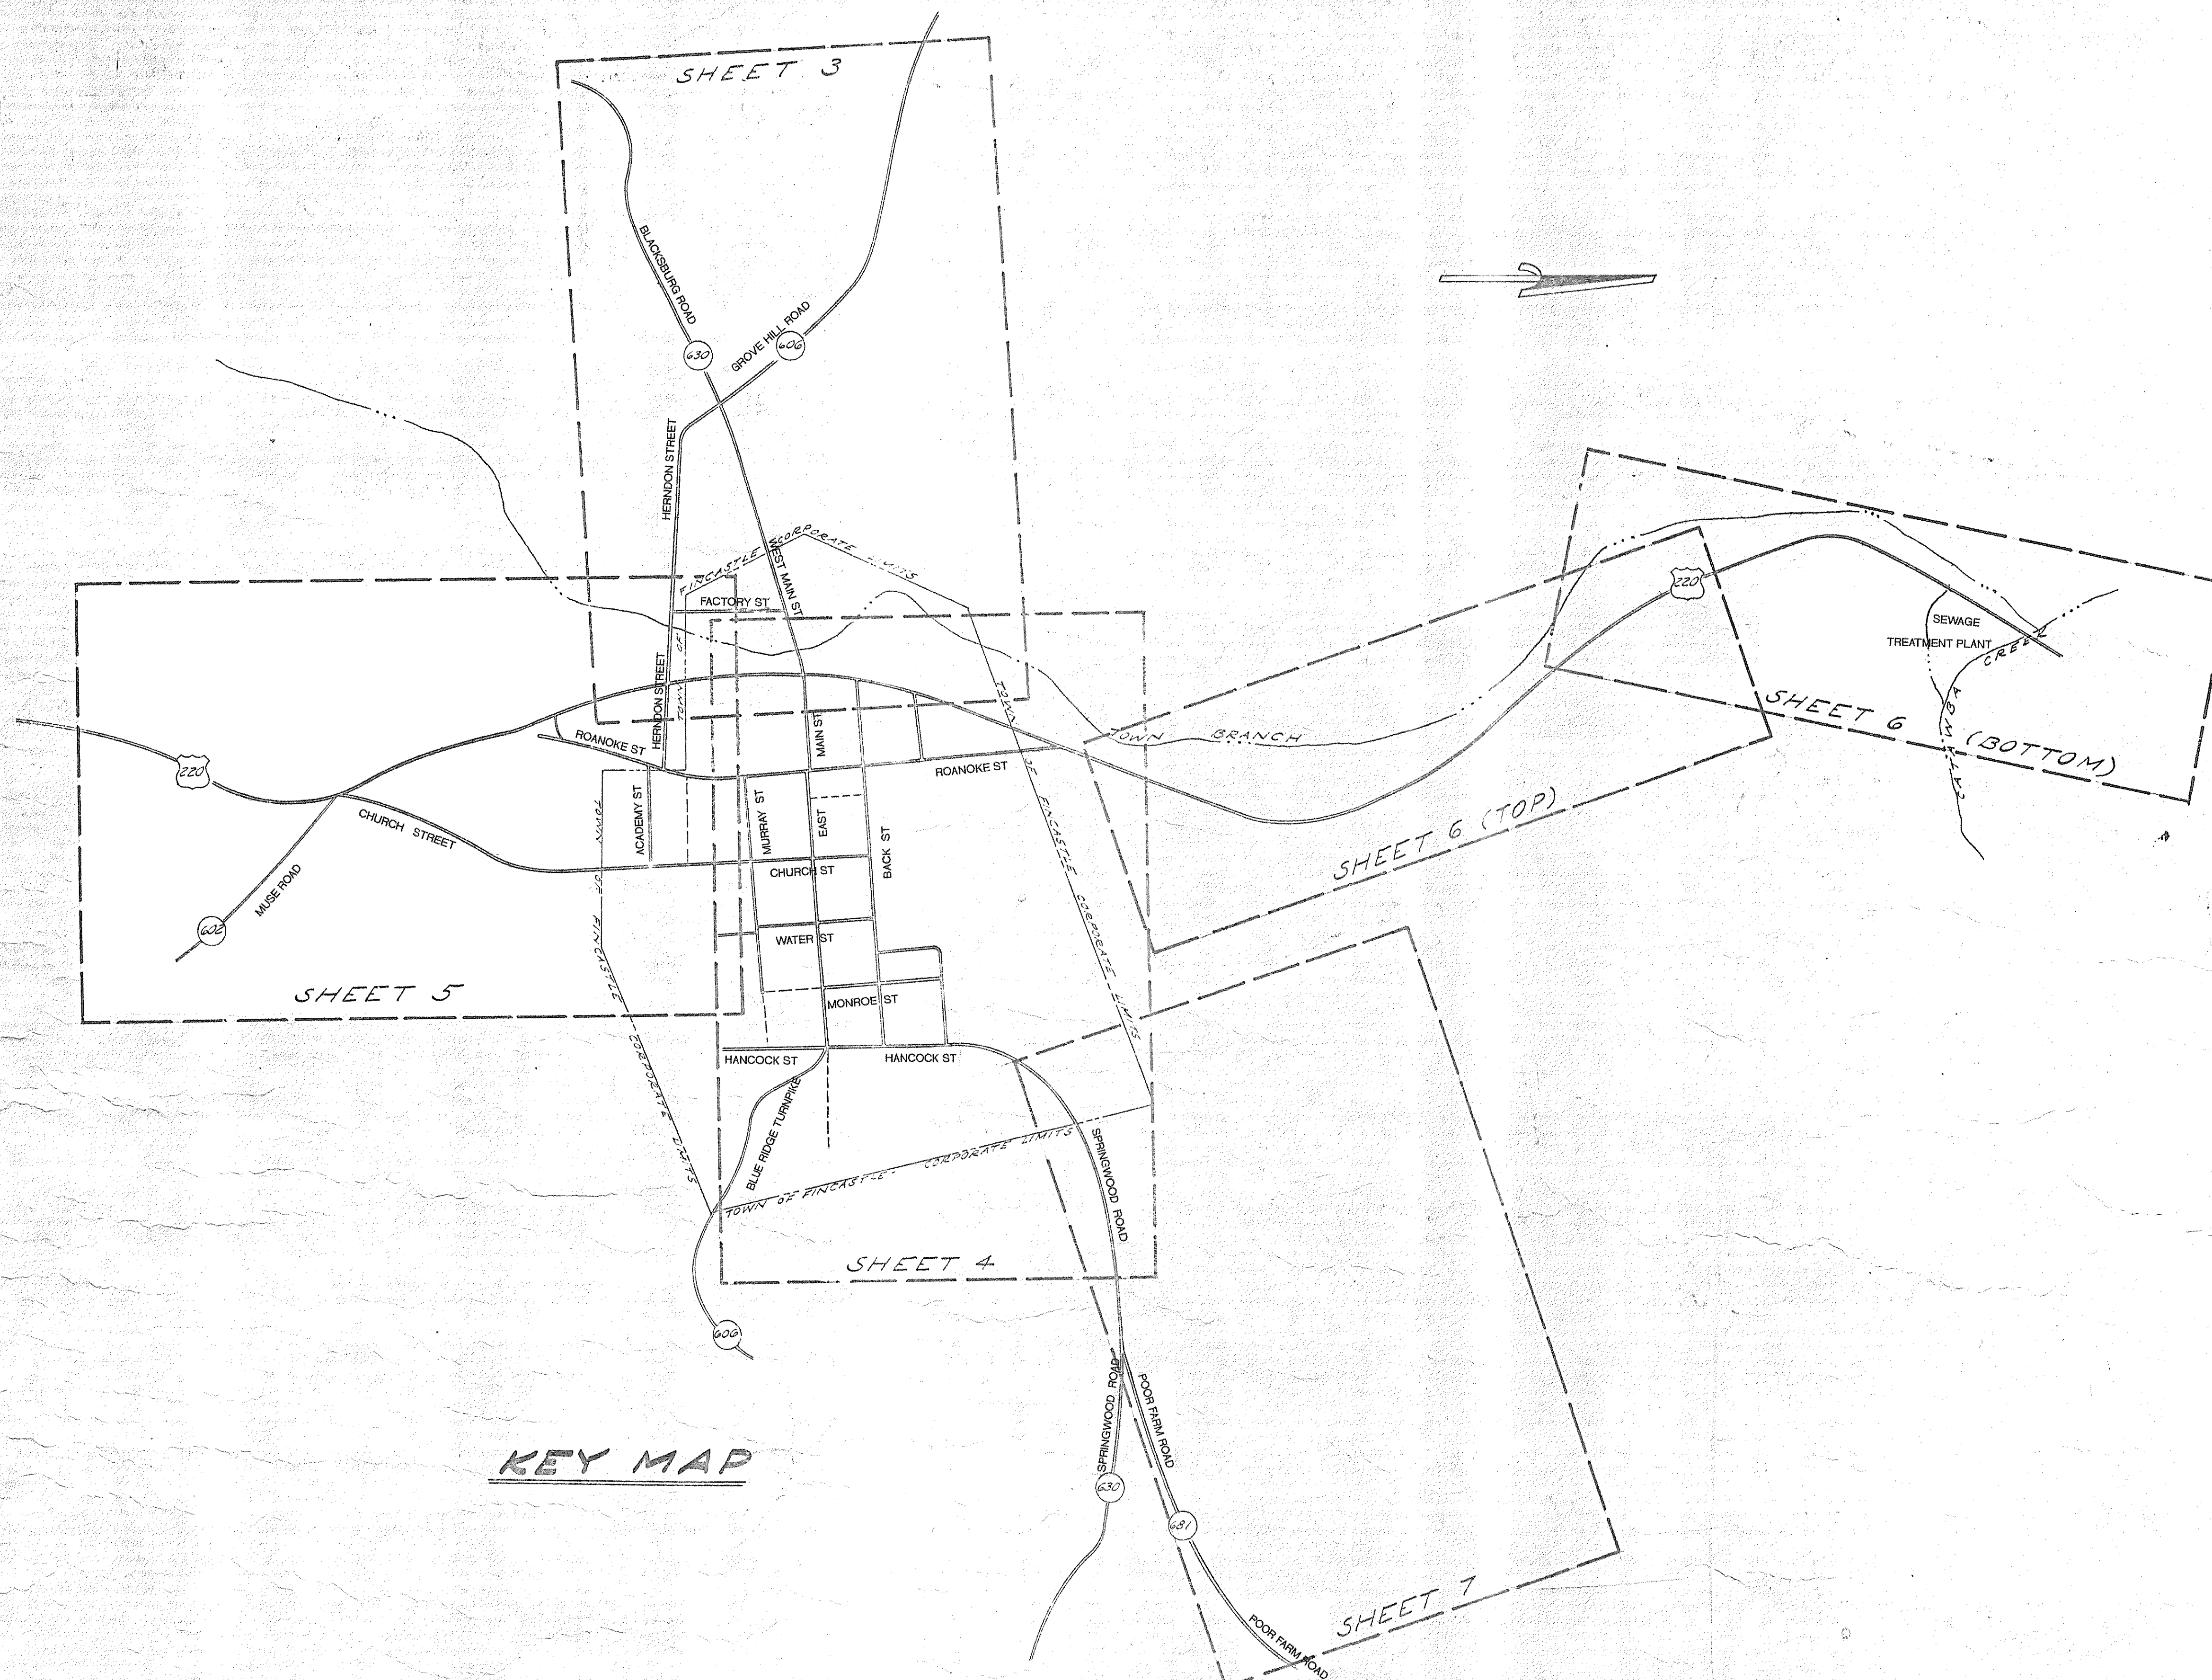

KEY MAP