
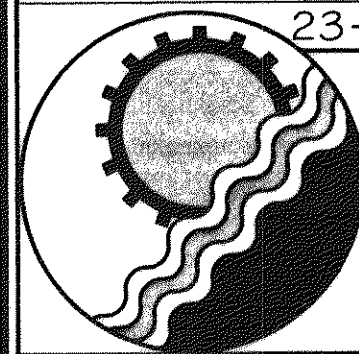
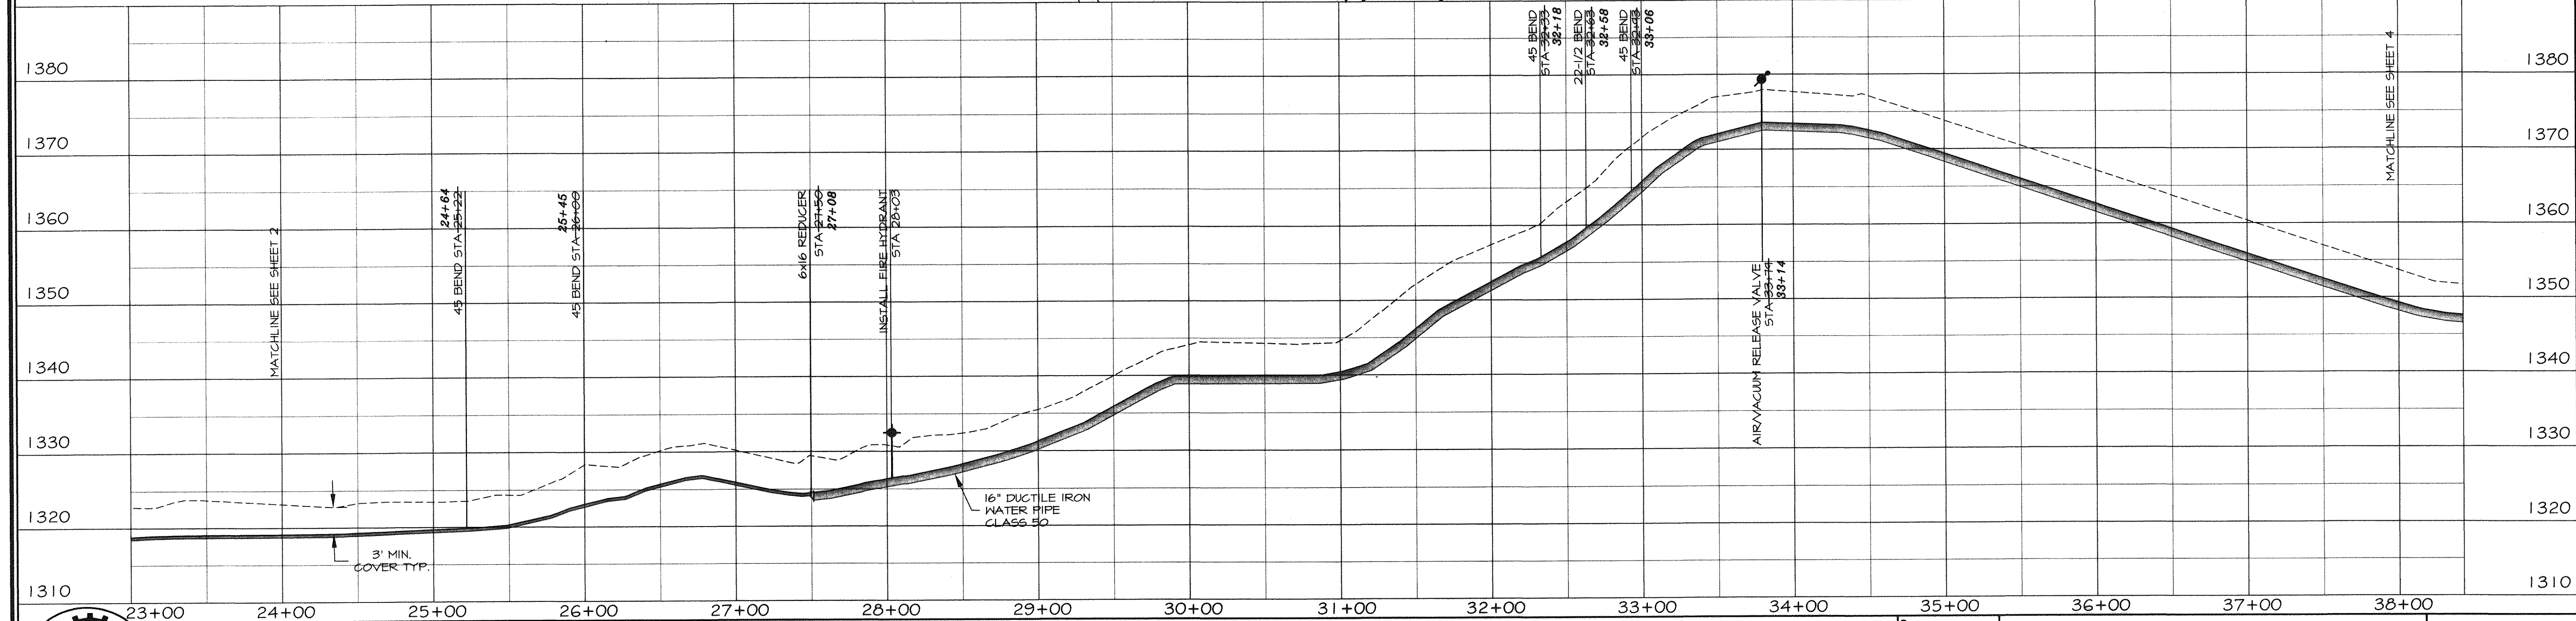


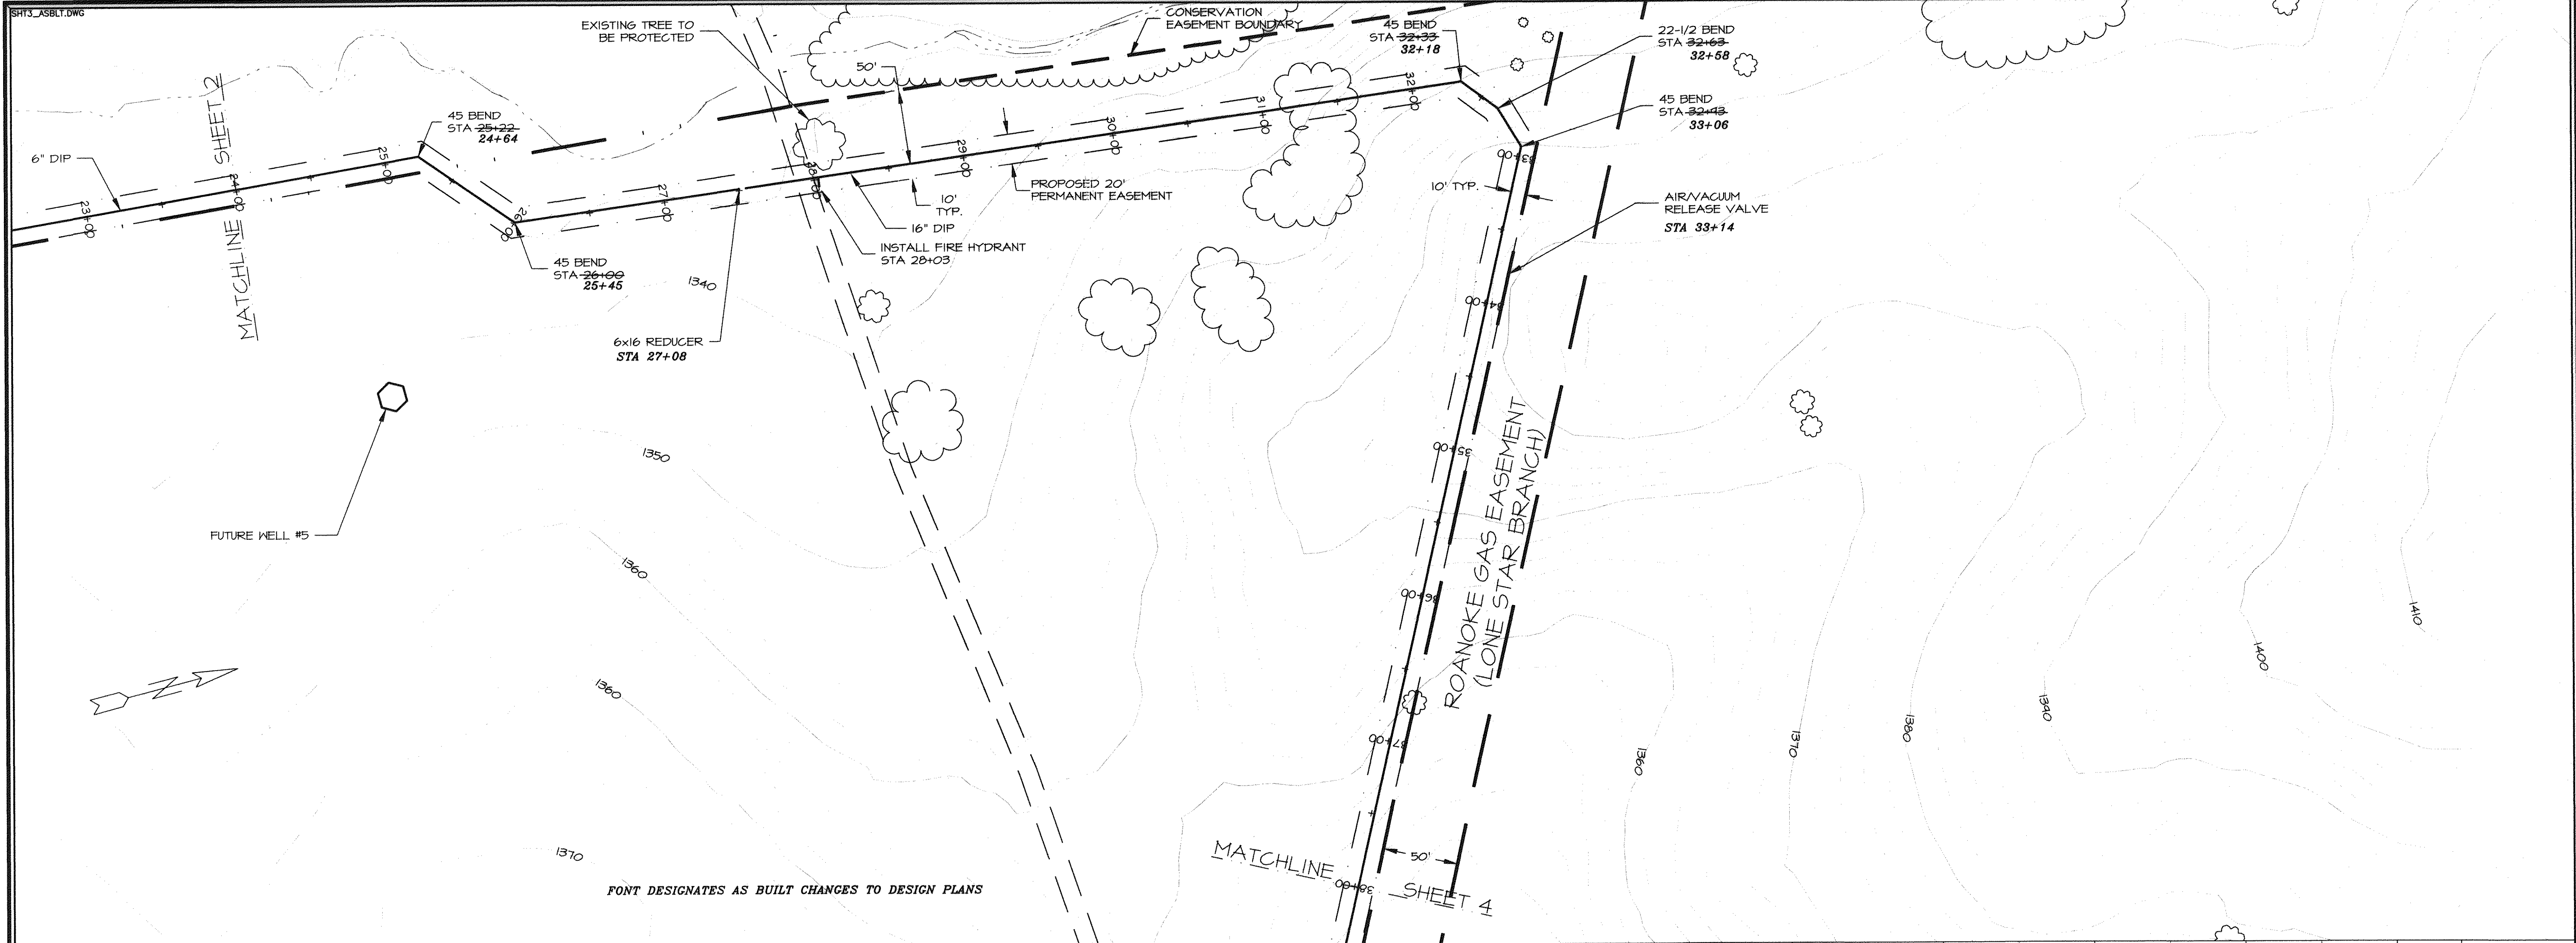

ENGINEERING CONCEPTS, INC.

20 S. ROANOKE ST., PO BOX 619
FINCASTLE, VIRGINIA 24090
540.473.1253 FAX: 540.473.1254

AS-BUILT

Drawn	RHW
Designed	RHW
Checked	WPJ
Approved	JST

**GREENFIELD
TANK FILL PIPELINE**

PLAN AND PROFILE
STA 24+00 - STA 38+00

H: 1"=50'	V: 1"=10'
JUNE 22, 1998	
PROJECT: 97075	
3 of 8	