
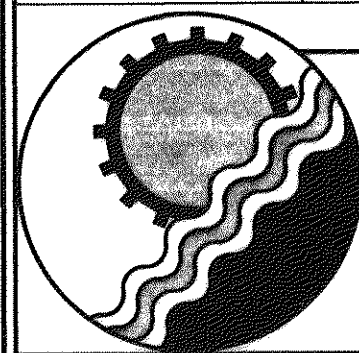


FONT DESIGNATES AS BUILT CHANGES TO DESIGN PLANS

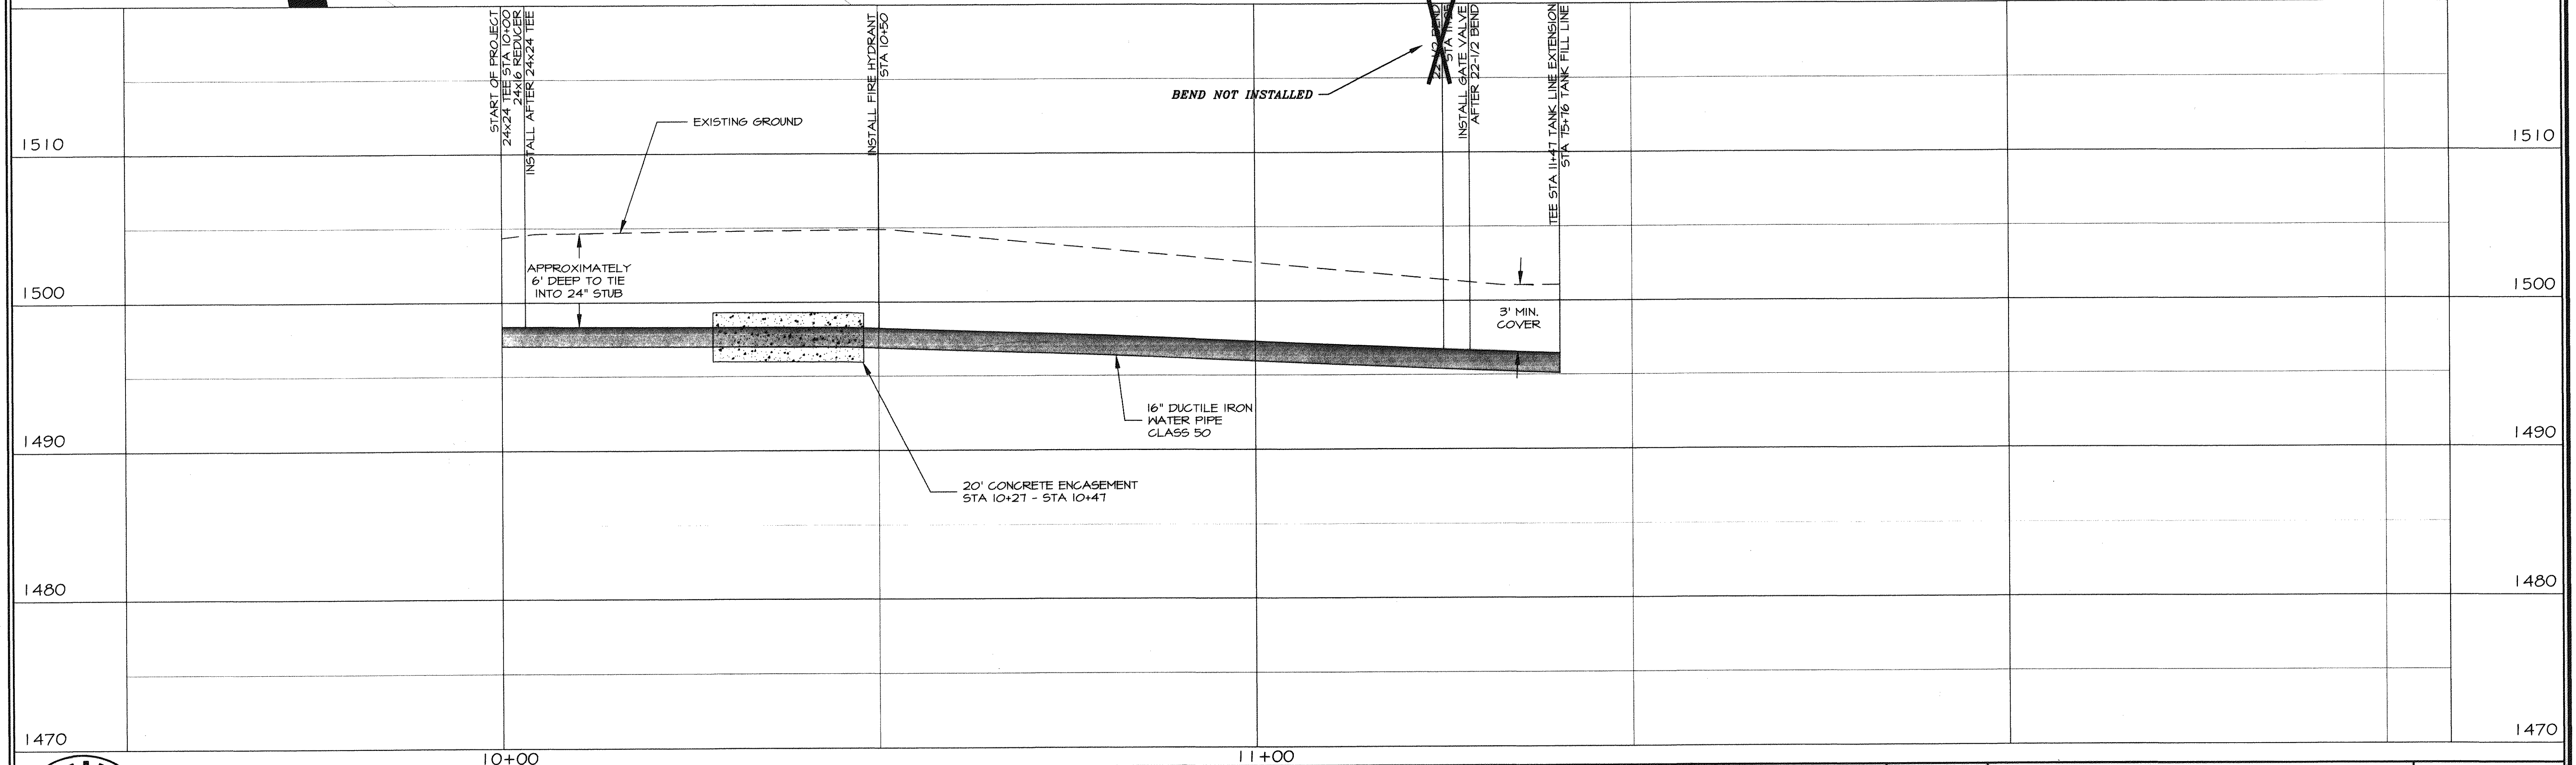

ENGINEERING CONCEPTS, INC.

20 S. ROANOKE ST., PO BOX 619
FINCASTLE, VIRGINIA 24090
540.473.1253 FAX: 540.473.1254

AS-BUILT

Drawn	RHW
Designed	RHW
Checked	WPJ
Approved	JST

**GREENFIELD TANK
FILL PIPELINE**

**PLAN AND PROFILE
TANK PIPELINE EXTENSION**

H: 1"=10'	V: 1"=5'
JUNE 22, 1998	
PROJECT: 97075	
7 of 8	